



# OTERO/GREENTREE REGIONAL LANDFILL CELLS NO. 1 AND NO. 2 CLOSURE

OTERO COUNTY, NEW MEXICO  
FEBRUARY 2021

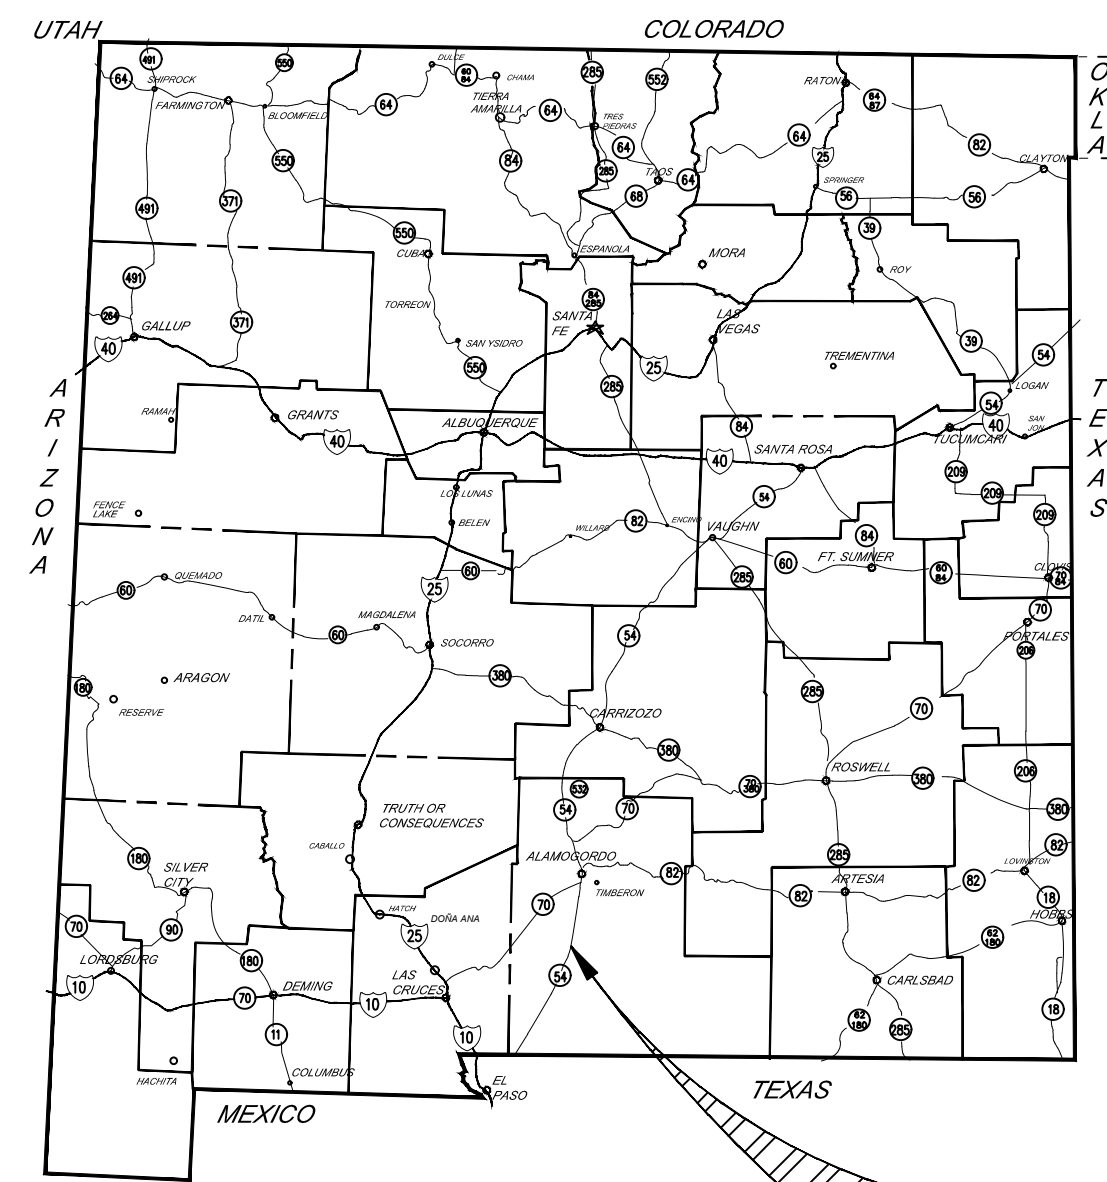

VICINITY MAP  
NOT TO SCALE

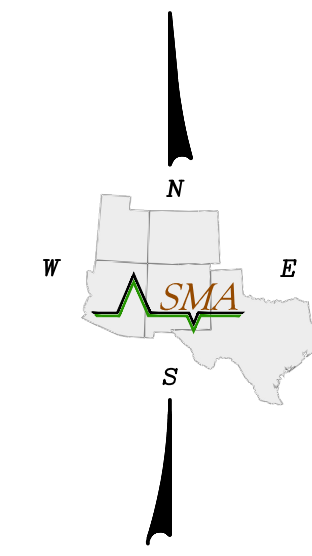

LOCATION MAP  
NOT TO SCALE

### SHEET INDEX

#### SHEET NO. DRAWING

C 100	TITLE SHEET
C 101	GENERAL NOTES AND DETAILS
C 200	2020 SURVEY CONTROL SHEET
C 201	SITE PLAN AND HAUL ROUTE
C 300	FINAL COVER GRADING PLAN
C 500	SOUTH TO NORTH ALIGNMENT CROSS SECTIONS 1 THRU 5
C 501	WEST TO EAST ALIGNMENT CROSS SECTIONS A THRU C
C 502	WEST TO EAST ALIGNMENT CROSS SECTIONS D THRU E

PREPARED FOR  
CITY OF ALAMOGORDO  
2600 NORTH FLORIDA AVE.  
ALAMOGORDO, NEW MEXICO 88310  
TELE: (575) 439-4240

PREPARED BY:  
THESE DETAILED PLANS AND SPECIFICATIONS WERE PREPARED UNDER MY DIRECTION  
AND SUPERVISION ON BEHALF OF SOUDER, MILLER AND ASSOCIATES.

PAUL J. POMPEO, NEW MEXICO PE 11490

02/11/2021  
DATE



To Request a Line Locate Dial 811

New Mexico state law requires everyone involved in any excavation to provide at least two working days' notice to owners of underground facilities when a dig is planned. All facility owners are then required to mark the locations of any underground lines or take other appropriate measures to protect them.

Rev #	Date	Description	By	CHKD
1	03/04	DRAWINGS ISSUED FOR CONSTRUCTION	SVG	PJP

SOUDER, MILLER & ASSOCIATES  
Engineering • Environmental • Geomatics  
Serving the Southwest & Rocky Mountains  
3500 Sedona Hills Pkwy.  
Las Cruces, NM 88011  
Phone: (575) 647-0799 Fax: (575) 647-0680  
www.soudermiller.com

ALAMOGORDO, NEW MEXICO  
GREENTREE REGIONAL LANDFILL CELLS NO. 1 AND NO. 2  
OTERO COUNTY, NEW MEXICO  
TITLE SHEET



02/11/2021

THIS DRAWING IS INCOMPLETE AND NOT TO BE USED FOR CONSTRUCTION UNLESS IT IS STAMPED, SIGNED AND DATED.

Designed	Drawn	Checked
PP	JDW	SG

Date: March 2021  
Scale: N.T.S.  
Project No: 4328859  
Sheet: C100



**PROJECT DESCRIPTION**

THE CLOSURE OF OTERO GREENTREE REGIONAL LANDFILL CELLS NO. 1 AND NO. 2 ENTAILS THE PREPARATION OF THE INTERIM COVER AND THE INSTALLATION OF A 24" THICK COMPACTED BARRIER SOIL LAYER OVERLAIN WITH A 6" THICK TOP SOIL VEGETATION LAYER. DRAINAGE INFRASTRUCTURE, SUCH AS GRADING, SHOULD BE INSTALLED IN AN EFFORT TO PROMOTE POSITIVE DRAINAGE PATTERNS ROUTING RUNOFF TO EXISTING DRAINAGE SWALES LOCATED ADJACENT TO THE CELLS.

**REVEGETATION SEED MIX**

THE FINAL CLOSURE GRADING AND DRAINAGE PLAN AS SHEET C300 PRESENTS THE FINISHED SLOPES AND DRAINAGE IMPROVEMENTS TO PROTECT THE LANDFILL COVER. THE RESISTANCE OF THE OUTER LAYER TO EROSION FROM WIND AND SURFACE WATER IS CRITICAL IN THE PROTECTION OF THE INFILTRATION LAYER. THIS RESISTANCE IS ACHIEVED BY THE DEVELOPMENT OF A VIABLE VEGETATIVE COVER WITH A SHALLOW ROOT SYSTEM, WHICH BINDS THE SOIL PROFILE. THE RECOMMENDED SEED MIX AND PLANTING RATE TO BE USED FOLLOWING TABLE 3-1. THE SEED MIX WILL BE DROUGHT RESISTANT AND REQUIRE LITTLE OR NO FERTILIZATION. THE FOLLOWING SEED MIX WILL BE APPLIED TO THE SURFACE OF THE VEGETATIVE/EROSION SOIL LAYER, BY THE CITY OF ALAMOGORDO AT A LATER DATE AND WILL NOT BE INCLUDED IN THE CONTRACT FOR THE CLOSURE OF CELLS 1 AND 2. THE FOLLOWING INFORMATION HAS BEEN PROVIDED FOR CLARIFICATION PURPOSES ONLY.

TABLE 3-1 RECOMMENDED SEED MIX AND PLANTING RATE

COMMON NAME	LATIN NAME	BROADCAST APPLICATION RATE (LBS/ACRE)
BLUE GRAMA, NATIVE	BOUTELOUA GRACILIS	3.6
SIDEOATS GRAMA	BOUTELOUA CURTIPENDULA	3.0
LITTLE BLUESTEM	SCHIZACHYRIUM SCOPARIUM	1.8
	PLEURAPHIS JAMESII	1.8
SAND DROPSEED	SPOROBOLUS CRYPTANDRUS	0.6
ALKALI SACATON	SPRROBOLUS AIROIDES	1.2
TOTAL		12.0


THE SEEDED AREAS SHALL BE COVERED WITH STRAW, MULCH OR CHIPPED LANDSCAPE DEBRIS TO INCREASE MOISTURE RETENTION IN THE SOIL. IF DEEMED APPROPRIATE, COMMERCIAL FERTILIZER CAN BE APPLIED TO THE PLANTED AREA IN ACCORDANCE WITH THE MANUFACTURER'S SUGGESTED APPLICATION RATES. THE PLANTING OF THE GRASS SEED MIXTURE (OR EQUIVALENT) LISTED ABOVE WILL PROMOTE EROSION RESISTANCE OF THE FINAL COVER SYSTEM. DUE TO THE ARID CLIMATE OF THE AREA AND BASED ON EXISTING NATIVE VEGETATIVE COVERAGE AND THE PERMIT RENEWAL APPLICATION, GORDON ENVIRONMENTAL, INC., 2013), ONLY APPROXIMATELY 50% FINAL VEGETATIVE COVERAGE OF THE FINAL LANDFILL CAP IS ANTICIPATED

NOTE:  
APPLY SEED WITH A BRILLION SEEDER, "WHIRLWIND" TYPE SPREADER OR A DRILL SEEDER (DEPENDING ON AVAILABILITY AND THE SIZE OF THE PROJECT). APPLY 1/2 OF THE SEED AT A TIME, GOING OPPOSITE DIRECTIONS WITH EACH PASS IF POSSIBLE. RAKE OR DRAG LIGHTLY TO COVER SEED TO A DEPTH OF NO MORE THAN 1/4 INCH. LIGHTLY ROLL THE ENTIRE SURFACE TO FIRM THE SEEDBED WHEN POSSIBLE. IT IS RECOMMENDED TO PLANT IN LATE JUNE TO PROMOTE ESTABLISHMENT.


**GENERAL NOTES**

1. SOUDER, MILLER AND ASSOCIATES SHALL HEREINAFTER BE KNOWN AS THE ENGINEER. THERE WILL BE A PERSON PROVIDED BY THE ENGINEER THAT WILL ACT AS A CONSTRUCTION OBSERVER WHO WILL BE THE CONTACT FOR QUESTIONS FROM THE CONTRACTOR TO THE ENGINEER.
2. THE CONTRACTOR IS SOLELY RESPONSIBLE FOR CONSTRUCTING THE PROJECT ACCORDING TO NEW MEXICO STANDARD SPECIFICATIONS FOR PUBLIC WORKS CONSTRUCTION (NMSSPWC) SECTIONS 701, 801 AND 802.
3. CONTRACTOR IS SOLELY RESPONSIBLE FOR UTILITY LOCATION, PROTECTION, AND VERIFICATION. CONTRACTOR MUST NOTIFY NEW MEXICO ONE CALL SYSTEM, INC. AT 1-800-321-2537, AND ALL LOCAL UTILITY PROVIDERS, THREE (3) DAYS BEFORE STARTING UTILITY LINE CONSTRUCTION.
4. IN THE EVENT THAT THE CONTRACTOR ENCOUNTERS ITEMS OF HISTORICAL IMPORTANCE, THE ENGINEER SHALL BE NOTIFIED IMMEDIATELY AND WORK IN THE AREA SHALL IMMEDIATELY CEASE UNTIL THE SITE CAN BE CLEARED PROPERLY.
5. EROSION CONTROL SHALL BE IMPLEMENTED TO PROTECT PROJECT AREA, PROPERTIES AND PUBLIC FACILITIES FROM THE ADVERSE EFFECTS OF EROSION AND SEDIMENTATION AS A RESULT OF CONSTRUCTION ACTIVITIES.
6. CONTRACTOR SHALL ENSURE ALL EXISTING IMPROVEMENTS ARE COMPLETED AS SHOWN IN THE DESIGN PLANS. ALL COVER SHALL BE INTACT AND ADDITIONAL MATERIAL SHALL BE ADDED IF NEEDED. THIS WORK SHALL BE CONSIDERED INCIDENTAL AND NO EXTRA PAYMENT WILL BE MADE.
7. ENTIRE AREA WITHIN CELL 1 AND 2 SHALL HAVE 6" OF TOP SOIL MATERIAL FOR REVEGETATION OF SITE.
8. RESEEDING THE SITE SHALL BE CERTIFIED WEED FREE AND SEED LOT SHALL BE PROVIDED TO OWNER. IT IS SMA'S UNDERSTANDING THAT THE CITY OF ALAMOGORDO INTENDS TO SEED THE SITE AT A LATER DATE. INFORMATION ASSOCIATED WITH THE RESEEDING OF CELLS 1 AND 2 HAVE BEEN PROVIDED FOR CLARIFICATION PURPOSES ONLY. WORK ASSOCIATED WITH RESEEDING CELLS 1 AND 2 IS NOT INCLUDED IN THIS CONTRACT.
9. THE EARTHWORK HAUL ON THIS PROJECT WILL BE CONSIDERED INCIDENTAL, AND NO SEPARATE MEASUREMENT OR PAYMENT WILL BE MADE THEREFORE.
10. THE CONTRACTOR SHALL BE RESPONSIBLE FOR ALL REMOVALS REQUIRED TO COMPLETE THE PROJECT. ADDITIONAL REMOVALS NOT SHOWN ON THE PLANS WILL BE CONSIDERED INCIDENTAL AND THE CONTRACTOR WILL NOT RECEIVE ADDITIONAL COMPENSATION FOR UNLISTED REMOVALS.
11. ALL CONSTRUCTION EXISTING GROUND LINE PROFILES SPECIFIED ON THE PLAN AND PROFILE SHEETS HAVE BEEN DERIVED FROM AN ELECTRONIC DIGITAL TERRAIN MODEL AND HAVE BEEN USED FOR ESTIMATING PURPOSES ONLY. THE CONTRACTOR SHALL FIELD VERIFY ALL ELEVATIONS, DIMENSIONS, EXISTING GROUND LINE PROFILES PRIOR TO CONSTRUCTION STAKING, AND NO SEPARATE MEASUREMENT OR PAYMENT WILL BE MADE. CONTRACTOR SHALL NOTIFY AND SUBMIT VERIFIED ELEVATIONS TO THE OWNER'S PROJECT MANAGER.
12. ALL EARTHWORK QUANTITIES REFERENCED HEREIN REPRESENT IN-PLACE COMPACTED SOIL.
13. ALL DIMENSIONS ON PLANS ARE FOR INFORMATION PURPOSES ONLY. THE CONTRACTOR SHALL FIELD VERIFY ALL DIMENSIONS AND ALL OTHER PERTINENT INFORMATION THAT MAY BE REQUIRED TO COMPLETE THE WORK.
14. ALL DISTURBANCES SHALL BE LIMITED TO PROJECT BOUNDARIES. ACCESS ROADS SHALL MINIMIZE DAMAGE TO EXISTING VEGETATION. DISTURBANCES FROM LANDFILL SITE TO BORROW SITE SHALL BE MINIMAL. ALL DISTURBED AREAS SHALL BE GRADED TO NATURAL TERRAIN AND BE RE-VEGETATED LEAVING MINIMAL IMPACT TO SURROUNDING AREAS. THIS WORK WILL BE CONSIDERED INCIDENTAL AND NO EXTRA PAYMENT WILL BE MADE.
15. MATERIAL PROPERTY REQUIREMENTS SHALL BE IN ACCORDANCE WITH N.M.A.C 20.9.6.9.A(1) OR AS PROVIDED WITHIN THE PROJECT TECHNICAL SPECIFICATIONS.
16. MATERIAL TESTING FREQUENCIES (MINIMUM) SHALL BE IN ACCORDANCE WITH N.M.A.C 20.9.4.14 B(3) OR AS PROVIDED WITHIN THE PROJECT CONSTRUCTION QUALITY ASSURANCE/QUALITY CONTROL PLAN.
17. EARTHWORK AND TOPOGRAPHIC SURVEYS SHALL BE COMPLETED IN THREE MAJOR PHASES: INTERMEDIATE SURFACE COMPACTION, COMPACTED BARRIER SOIL LAYER AND TOPSOIL LAYER. CONTRACTOR SHALL PROVIDE PROJECT ENGINEER COMPLETE CONSTRUCTION MATERIAL TESTING REPORTS AND A TOPOGRAPHIC SURVEY FOR EACH PHASE OF COVER INSTALLATION INDICATING PASSING RESULTS. CONSTRUCTION OF SUBSEQUENT LAYERS SHALL NOT COMMENCE UNTIL THE PROJECT ENGINEER HAS RECEIVED AND ACCEPTED SUCH REPORTS AND TOPOGRAPHIC SURVEY. ANY EARTHWORK DONE PRIOR TO PROJECT ENGINEER ACCEPTANCE SHALL BE CONSIDERED AT RISK BY CONTRACTOR.
18. AFTER EACH RAINFALL EVENT, THE FINAL CAP AREA SHALL BE INSPECTED TO ENSURE EROSION HAS NOT CREATED AREAS OF CONCENTRATED FLOWS. IN THE EVENT THAT CONCENTRATED FLOWS HAVE DEVELOPED, THOSE AREAS SHALL BE MITIGATED TO RETURN THE STORMWATER RUNOFF TO A SHEET FLOW CONDITION.

**PROJECT DETAILS**

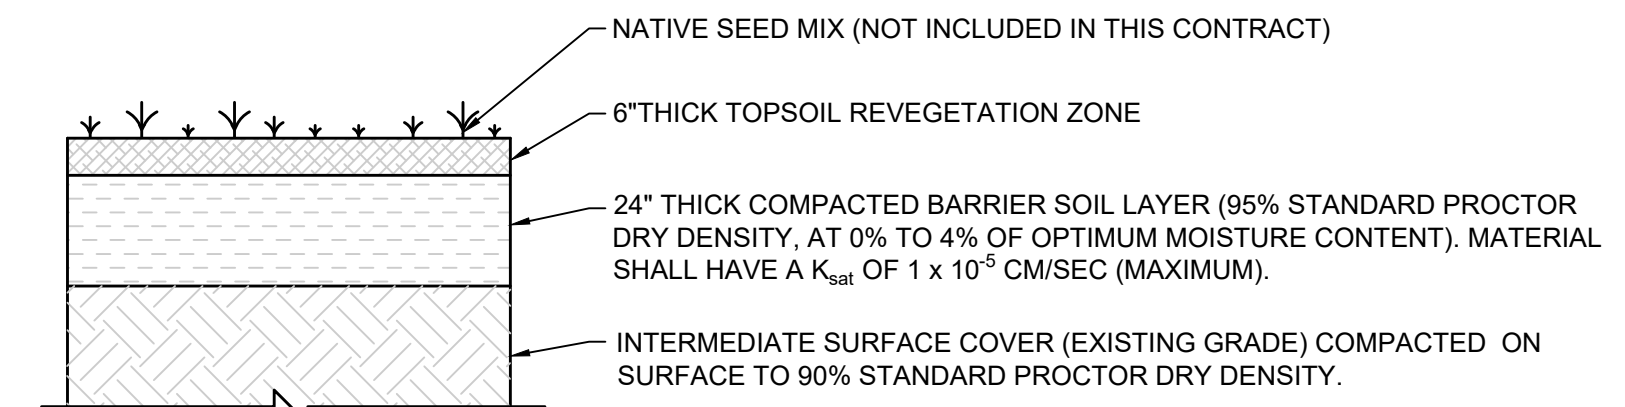

1 FINAL CAP DETAIL  
C101 NOT TO SCALE

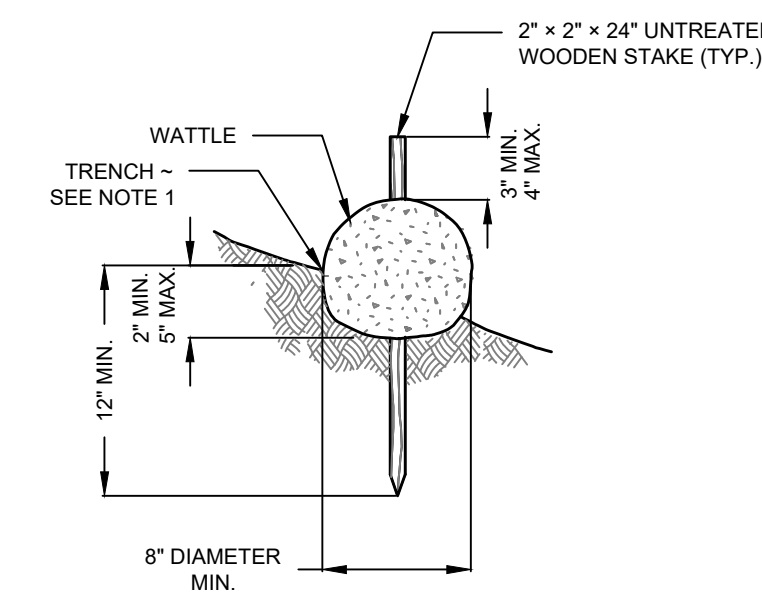

2 STRAW WATTLE DETAIL  
C101 NOT TO SCALE

**NOTES:**

1. INSTALL WATTLES ALONG CONTOURS.
2. SECURELY KNOT EACH END OF WATTLE OVERLAP ADJACENT WATTLE ENDS 12" BEHIND ONE ANOTHER AND SECURELY TIE TOGETHER.
3. COMPACT EXCAVATED SOIL AND TRENCHES TO PREVENT UNDERCUTTING. ADDITIONAL STAKING MAY BE NECESSARY TO PREVENT UNDERCUTTING.
4. INSTALL WATTLE PERPENDICULAR TO FLOW ALONG CONTOURS.
5. WATTLES SHALL BE INSPECTED REGULARLY AND IMMEDIATELY AFTER A RAINFALL PRODUCES RUNOFF, TO ENSURE THEY REMAIN THOROUGHLY ENTRENCHED AND IN CONTACT WITH THE SOIL.



To Request a Line Locate Dial 811

New Mexico state law requires everyone involved in any excavation to provide at least two working days' notice to owners of underground facilities when a dig is planned. All facility owners are then required to mark the locations of any underground lines or take other appropriate measures to protect them.

Rev #	Date	Description	By	CHKD
1	12/22	DRAWINGS ISSUED FOR NAMED REVIEW	SVG	PJP
2	02/11	DRAWINGS ISSUED FOR FINAL REVIEW	SVG	PJP

**SOUDEUR, MILLER & ASSOCIATES**  
 Engineering • Environmental • Geomatics  
 Serving the Southwest & Rocky Mountains  
 3500 Sedona Hills Plwy.,  
 Las Cruces, NM 88011  
 Phone: (575) 647-0799 Fax: (575) 647-0680  
 www.soudermiller.com

ALAMOGORDO, NEW MEXICO  
**GREENTREE REGIONAL LANDFILL CELLS NO. 1 AND 2**  
 OTERO COUNTY, NEW MEXICO  
 GENERAL NOTES AND DETAILS




02/11/2021

THIS DRAWING IS INCOMPLETE AND NOT TO BE USED FOR CONSTRUCTION UNLESS IT IS STAMPED, SIGNED AND DATED


Designed	Drawn	Checked
PP	JDW	SG

Date: February 2021  
 Scale: N.T.S.  
 Project No: 4328859  
 Sheet: C101



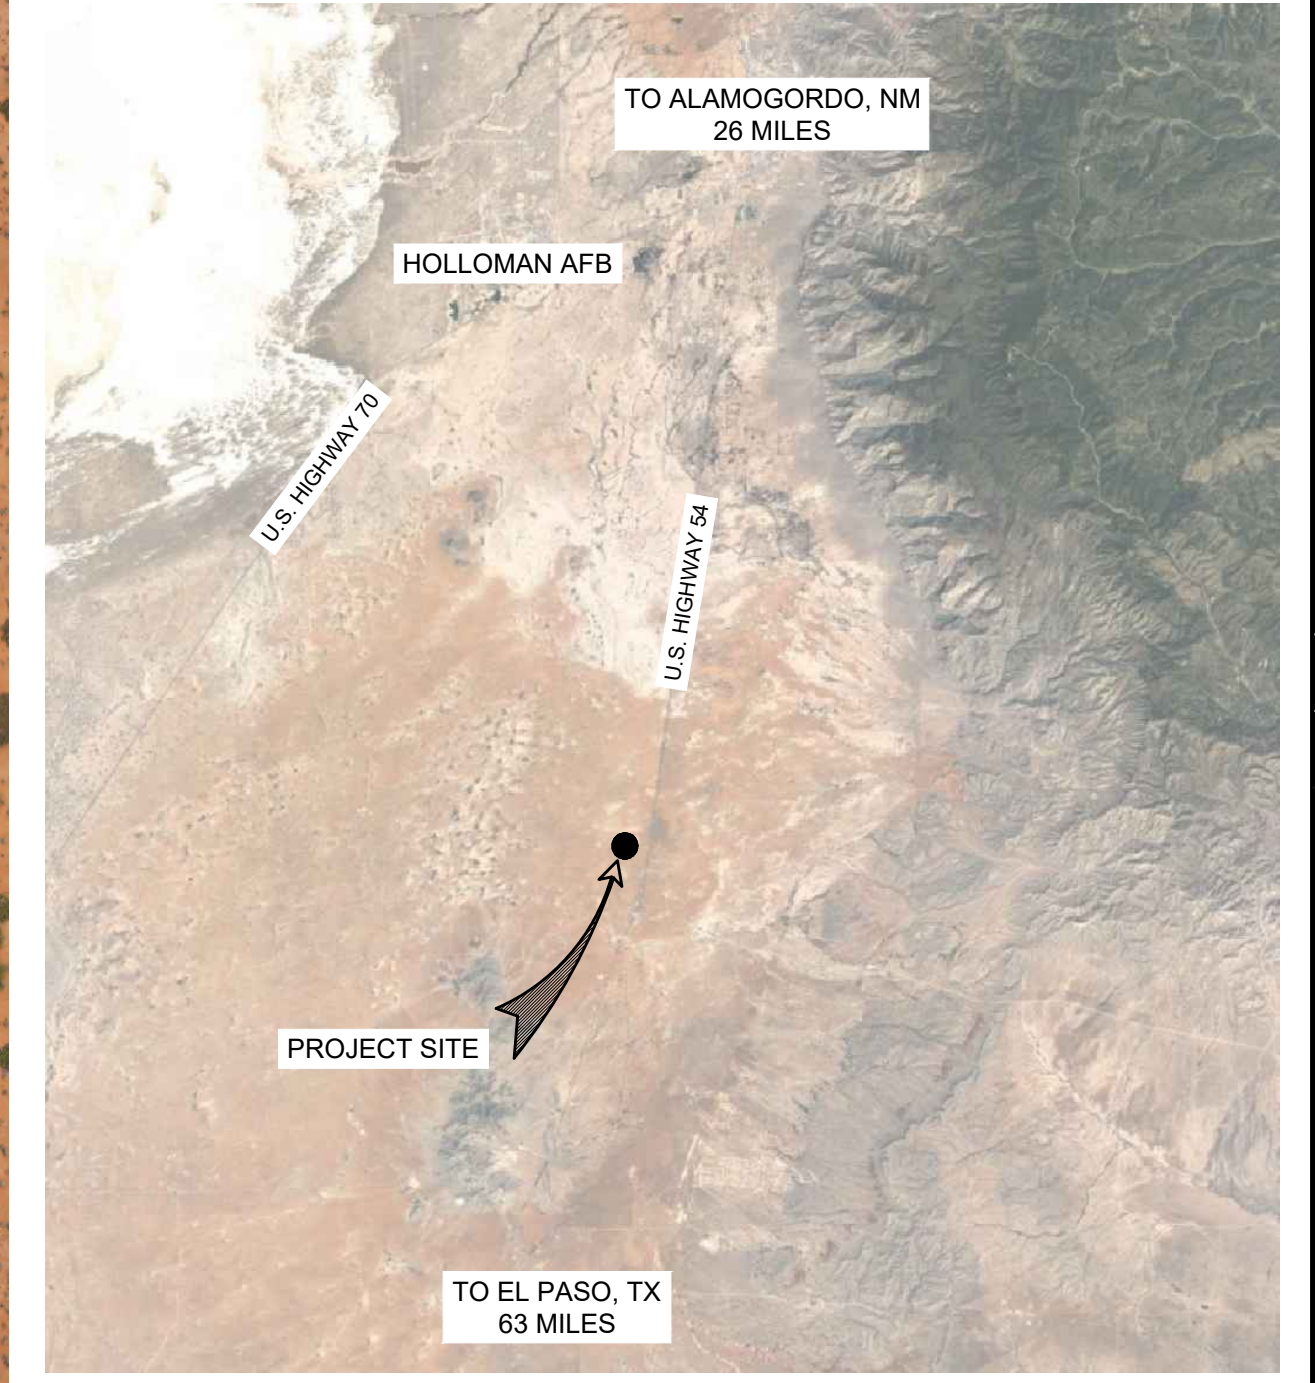


VICINITY MAP  
NOT TO SCALE

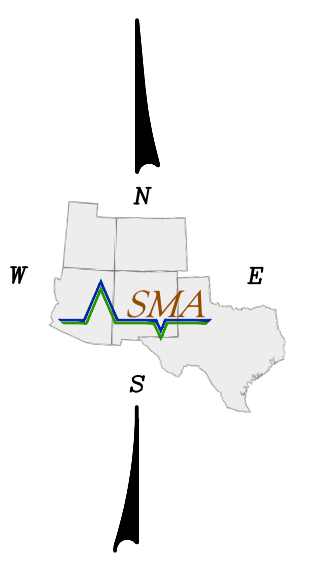

Control Point Table				
Point #	Elevation	Northing	Easting	Description
100	4033.10	570634.27	1709685.33	CP 100
102	4025.72	570691.53	1708100.12	5/8IN IR CNTRL CAP
103	4036.65	568350.82	1710273.85	5/8IN IR CNTRL CAP
110	4040.90	568140.84	1709545.62	CP110
111	4096.40	569166.06	1708181.94	CP111

**COORDINATE SYSTEM**

COORDINATES BASED ON A MODIFIED STATE PLANE  
 COORDINATES BASED ON THE NEW MEXICO STATE PLANE NAD 83 CENTRAL ZONE (3002)  
 DISTANCES ARE US SURVEY FEET AND DISTANCES ARE GROUND  
 BEARING BASED ON GRID NORTH  
 GRID TO GROUND SCALE FACTOR 1.0001480011 SCALE AT CP POINT 100  
 N= 570634.270, E=1709685.330, ELEV= 4033.100  
 (N32°34'06.69234", W106°01'29.57714")  
 ELEVATIONS BASED ON NAVD83, USING GEOID 12A  
 PROJECT HEIGHT 3957.701

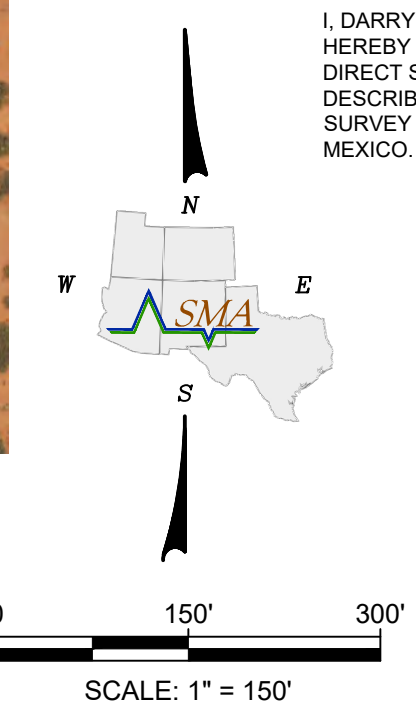


I, DARRYL D. COSTER, NEW MEXICO PROFESSIONAL SURVEYOR NO. 21204, DO  
 HEREBY CERTIFY THAT THIS CONTROL SURVEY WAS PREPARED BY ME OR UNDER MY  
 DIRECT SUPERVISION BASED ON AN ACTUAL SURVEY ON THE GROUND AS  
 DESCRIBED HEREIN, THAT I AM RESPONSIBLE FOR THIS SURVEY, AND THAT THE  
 SURVEY AND REPORT MEETS THE MINIMUM STANDARDS FOR SURVEYING IN NEW  
 MEXICO.

Rev #	Date	Description	By	CHKD
1	03/04	DRAWINGS ISSUED FOR CONSTRUCTION	SVG	DDC

**SOUDEY, MILLER & ASSOCIATES**  
 Engineering • Environmental • Geomatics  
 Serving the Southwest & Rocky Mountains  
 3500 Sedona Hills Pkwy.  
 Las Cruces, NM 88011  
 Phone (575) 647-0799 Fax (575) 647-0680  
 www.soudermiller.com

ALAMOGORDO, NEW MEXICO  
**OTERO GREENTREE REGIONAL LANDFILL**  
 OTERO COUNTY, NEW MEXICO  
 2020 SURVEY CONTROL SHEET

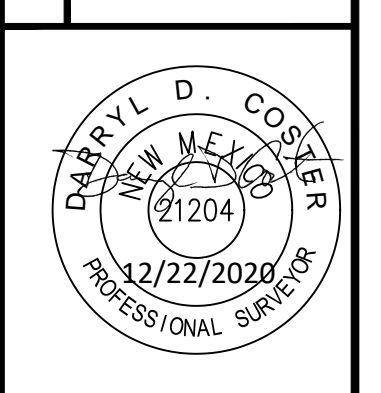

THIS DRAWING IS INCOMPLETE AND NOT TO BE USED FOR CONSTRUCTION UNLESS IT IS STAMPED, SIGNED AND DATED


Designed	Drawn	Checked
DDC	SVG	DDC

Date: December 2020  
 Scale: Horiz: N/A  
 Vert: N/A  
 Project No: 4328859  
 Sheet: C200





NOTE: ALLOWABLE HAUL ROUTE AS SHOWN FROM BORROW SOURCE TO PROJECT AREA

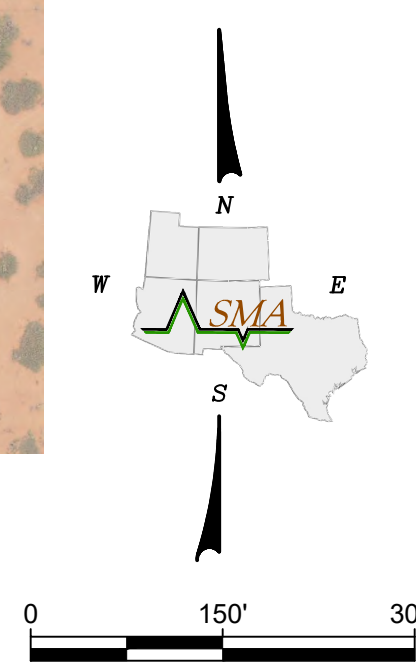

Rev #	Date	Description	By	CHKD
1	03/04	DRAWINGS ISSUED FOR CONSTRUCTION	SVG	PJP

**SOUDEY, MILLER & ASSOCIATES**  
 Engineering • Environmental • Geomatics  
 Serving the Southwest & Rocky Mountains  
 3500 Sedona Hills Pkwy.  
 Las Cruces, NM 88011  
 Phone (575) 647-0799 Fax (575) 647-0680  
 www.soudermiller.com

OTERO COUNTY ALAMOGORDO, NEW MEXICO  
**OTERO GREENTREE REGIONAL LANDFILL**  
 OTERO COUNTY, NEW MEXICO  
 SITE PLAN AND HAUL ROUTE



THIS DRAWING IS INCOMPLETE AND NOT TO BE USED FOR CONSTRUCTION UNLESS IT IS STAMPED, SIGNED AND DATED.


Designed	Drawn	Checked
SVG	JD	PJP

Date: March 2021  
 Scale: Horiz: N/A  
 Vert: N/A

Project No: 4328859


Sheet: C201



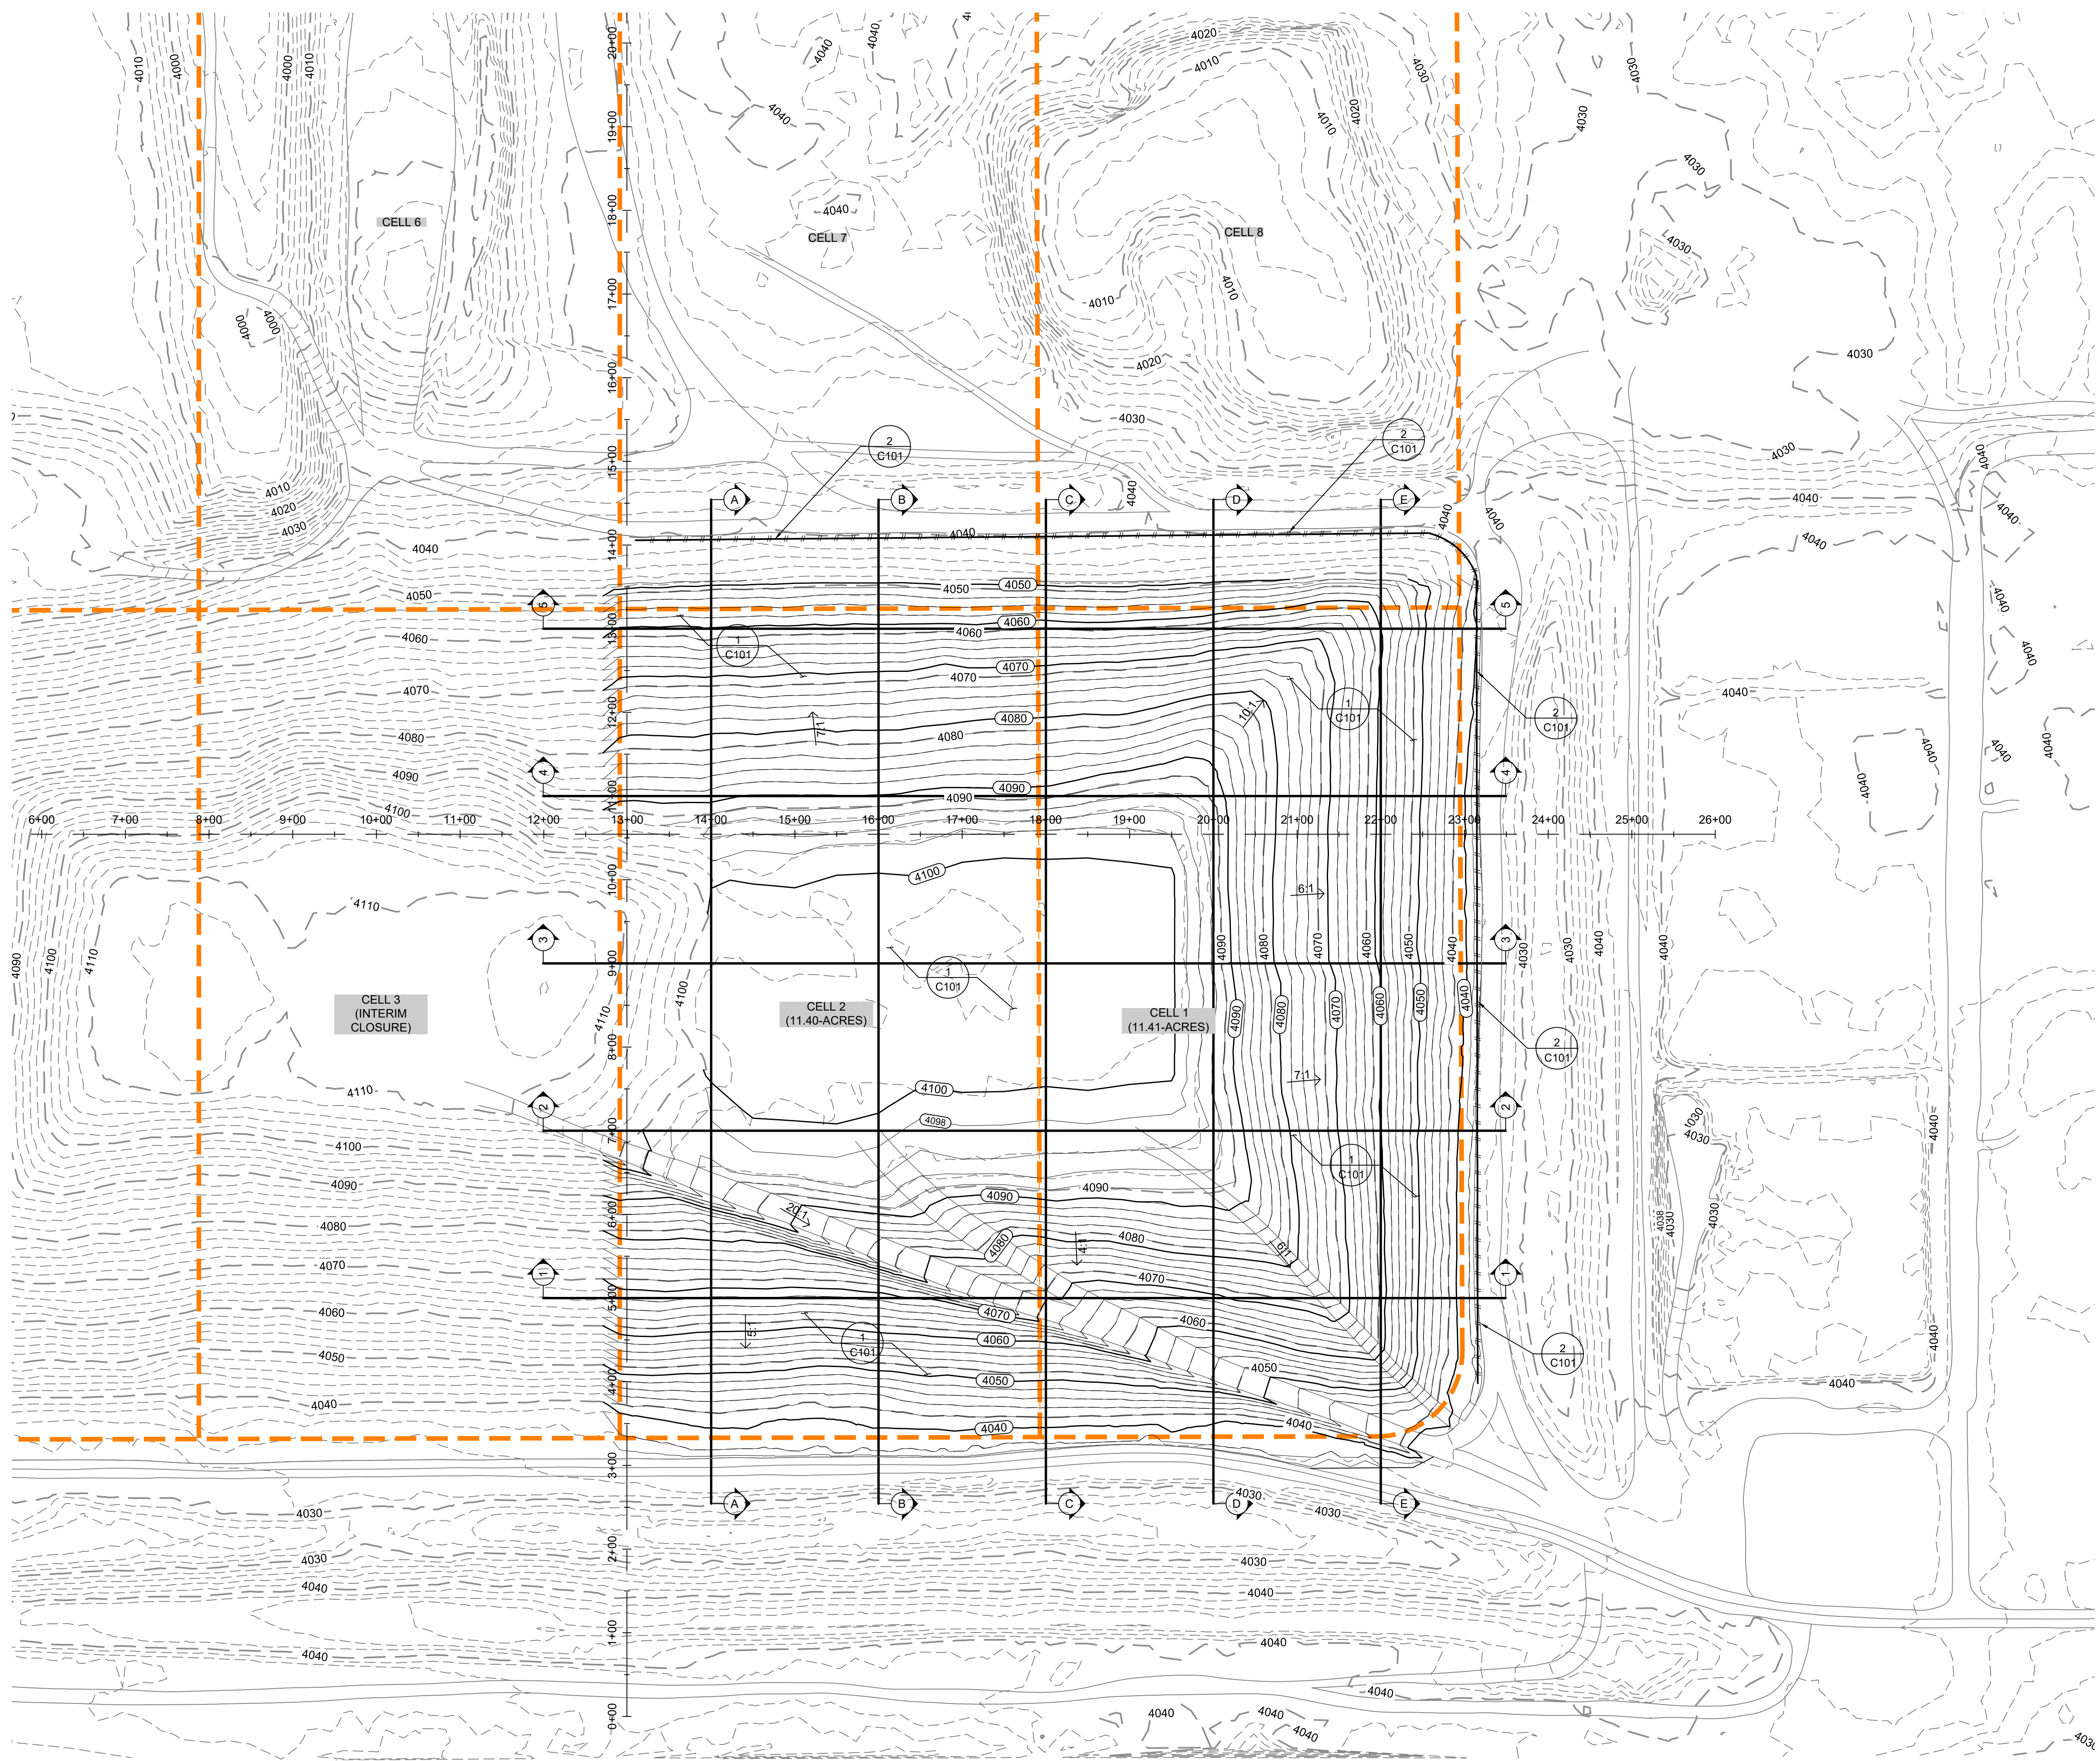

### LEGEND

	4130	= EXISTING GRADE MAJOR CONTOUR
	4129	= EXISTING GRADE MINOR CONTOUR
	4130	= DESIGN SOIL BARRIER COVER MAJOR CONTOUR
	4129	= DESIGN SOIL BARRIER COVER MINOR CONTOUR
		= CELL BOUNDARY LIMITS
		= CROSS SECTION CALLOUT
		= DETAIL CALLOUT
		= STRAW WATTLE

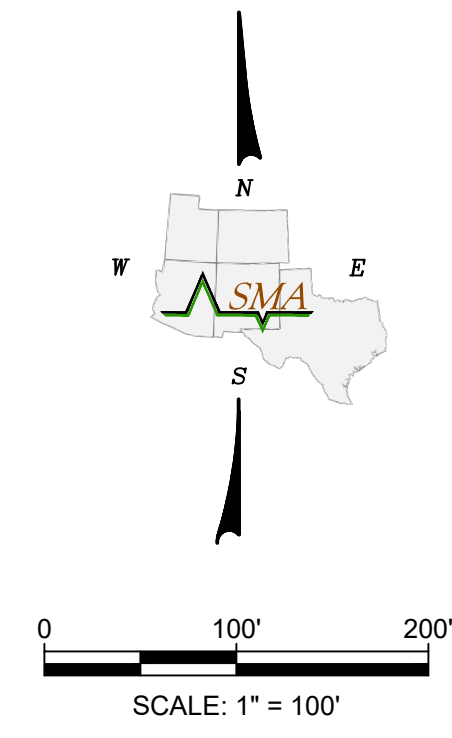







**Cut/Fill Summary**

Item	Qty	Factor	Fill Factor	2d Area	Cut	Fill	Net
24inch Compacted Soil Barrier	1.000	1.000		1054329.83 Sq. Ft.	0.80 Cu. Yd.	84532.43 Cu. Yd.	84531.63 Cu. Yd. <math>-(84531.63)</math>
6inch Top Soil Layer	1.000	1.000		1054214.30 Sq. Ft.	12.79 Cu. Yd.	19155.67 Cu. Yd.	19142.88 Cu. Yd. <math>-(19142.88)</math>
Totals				2108544.12 Sq. Ft.	13.54 Cu. Yd.	103688.28 Cu. Yd.	103674.74 Cu. Yd. <math>-(103674.74)</math>



SOUDER, MILLER & ASSOCIATES Engineering • Environmental • Geomatics Serving the Southwest & Rocky Mountains 3500 Saldana Hills Pkwy. Las Cruces, NM 88011 Phone: (575) 647-0799 Fax: (575) 647-0680 www.soudermiller.com	ALAMOGORDO, NEW MEXICO GREENTREE REGIONAL LANDFILL CELLS NO. 1 AND 2 OTERO COUNTY, NEW MEXICO FINAL COVER GRADING PLAN	By: CHK'd SVG PJP Description: DRAWINGS ISSUED FOR CONSTRUCTION Rev #   Date   1   03/04	<table border="1" style="width: 100%; border-collapse: collapse;"> <tr> <td style="width: 10%;">Designed</td> <td style="width: 10%;">Drawn</td> <td style="width: 10%;">Checked</td> </tr> <tr> <td>SVG</td> <td>DJB</td> <td>PJP</td> </tr> <tr> <td colspan="3">Date: February 2021</td> </tr> <tr> <td colspan="3">Scale: Horiz: 1" = 100'</td> </tr> <tr> <td colspan="3">Vert: N/A</td> </tr> <tr> <td colspan="3">Project No: 4328859</td> </tr> <tr> <td colspan="3">Sheet: C300</td> </tr> </table>	Designed	Drawn	Checked	SVG	DJB	PJP	Date: February 2021			Scale: Horiz: 1" = 100'			Vert: N/A			Project No: 4328859			Sheet: C300		
Designed	Drawn	Checked																						
SVG	DJB	PJP																						
Date: February 2021																								
Scale: Horiz: 1" = 100'																								
Vert: N/A																								
Project No: 4328859																								
Sheet: C300																								



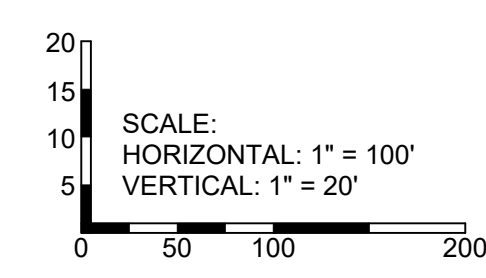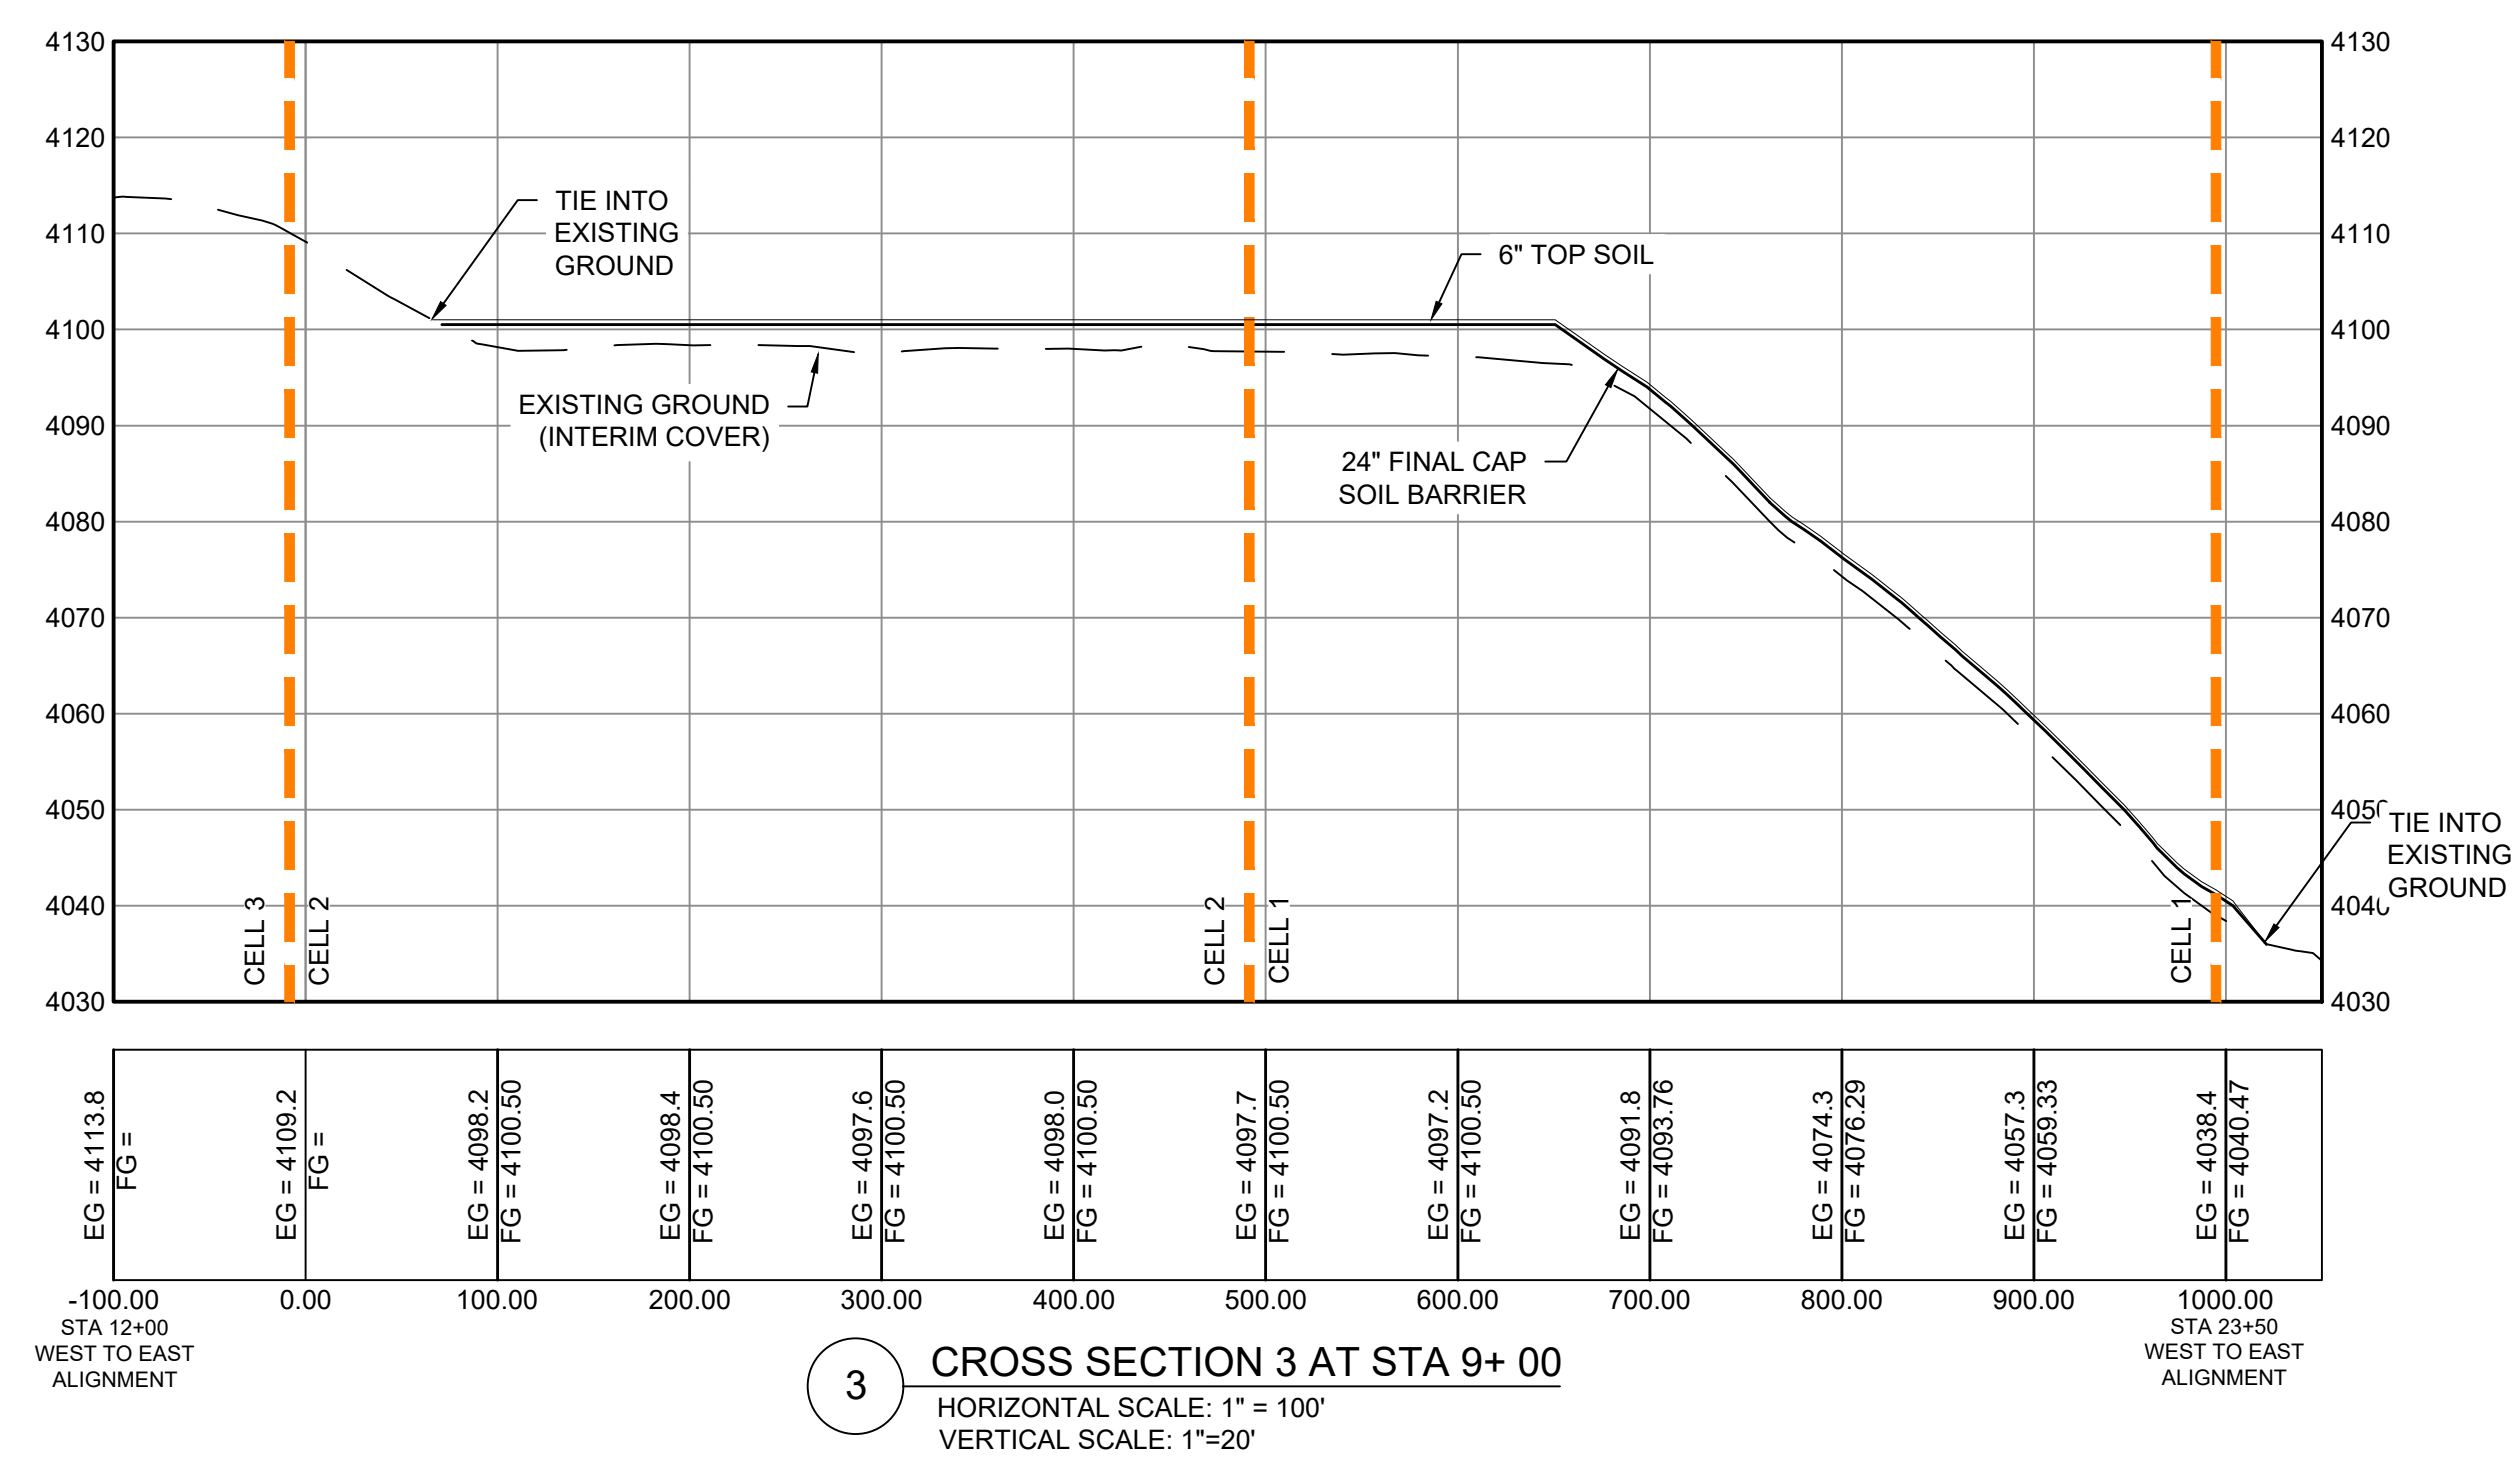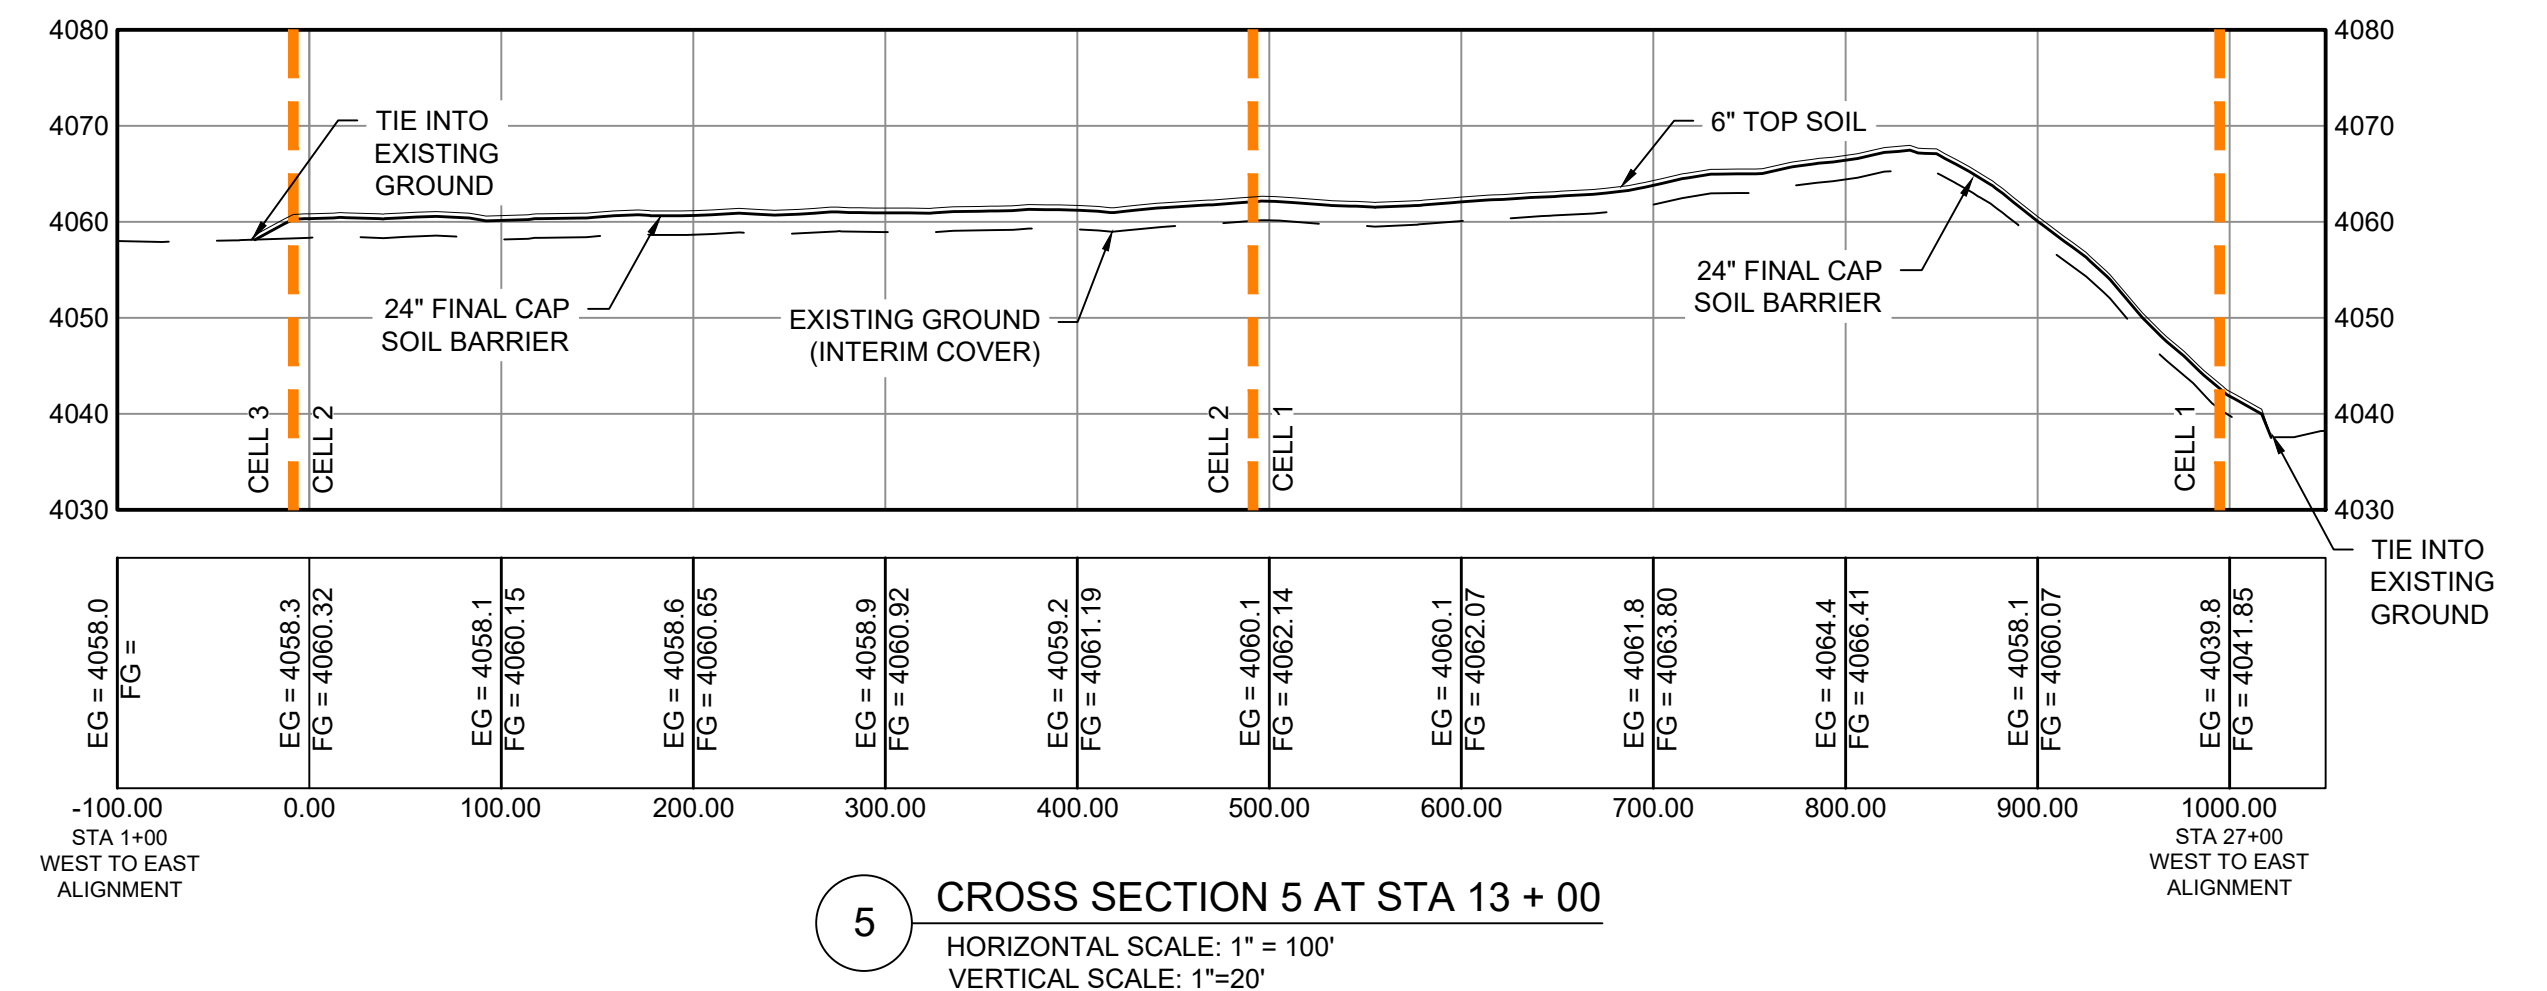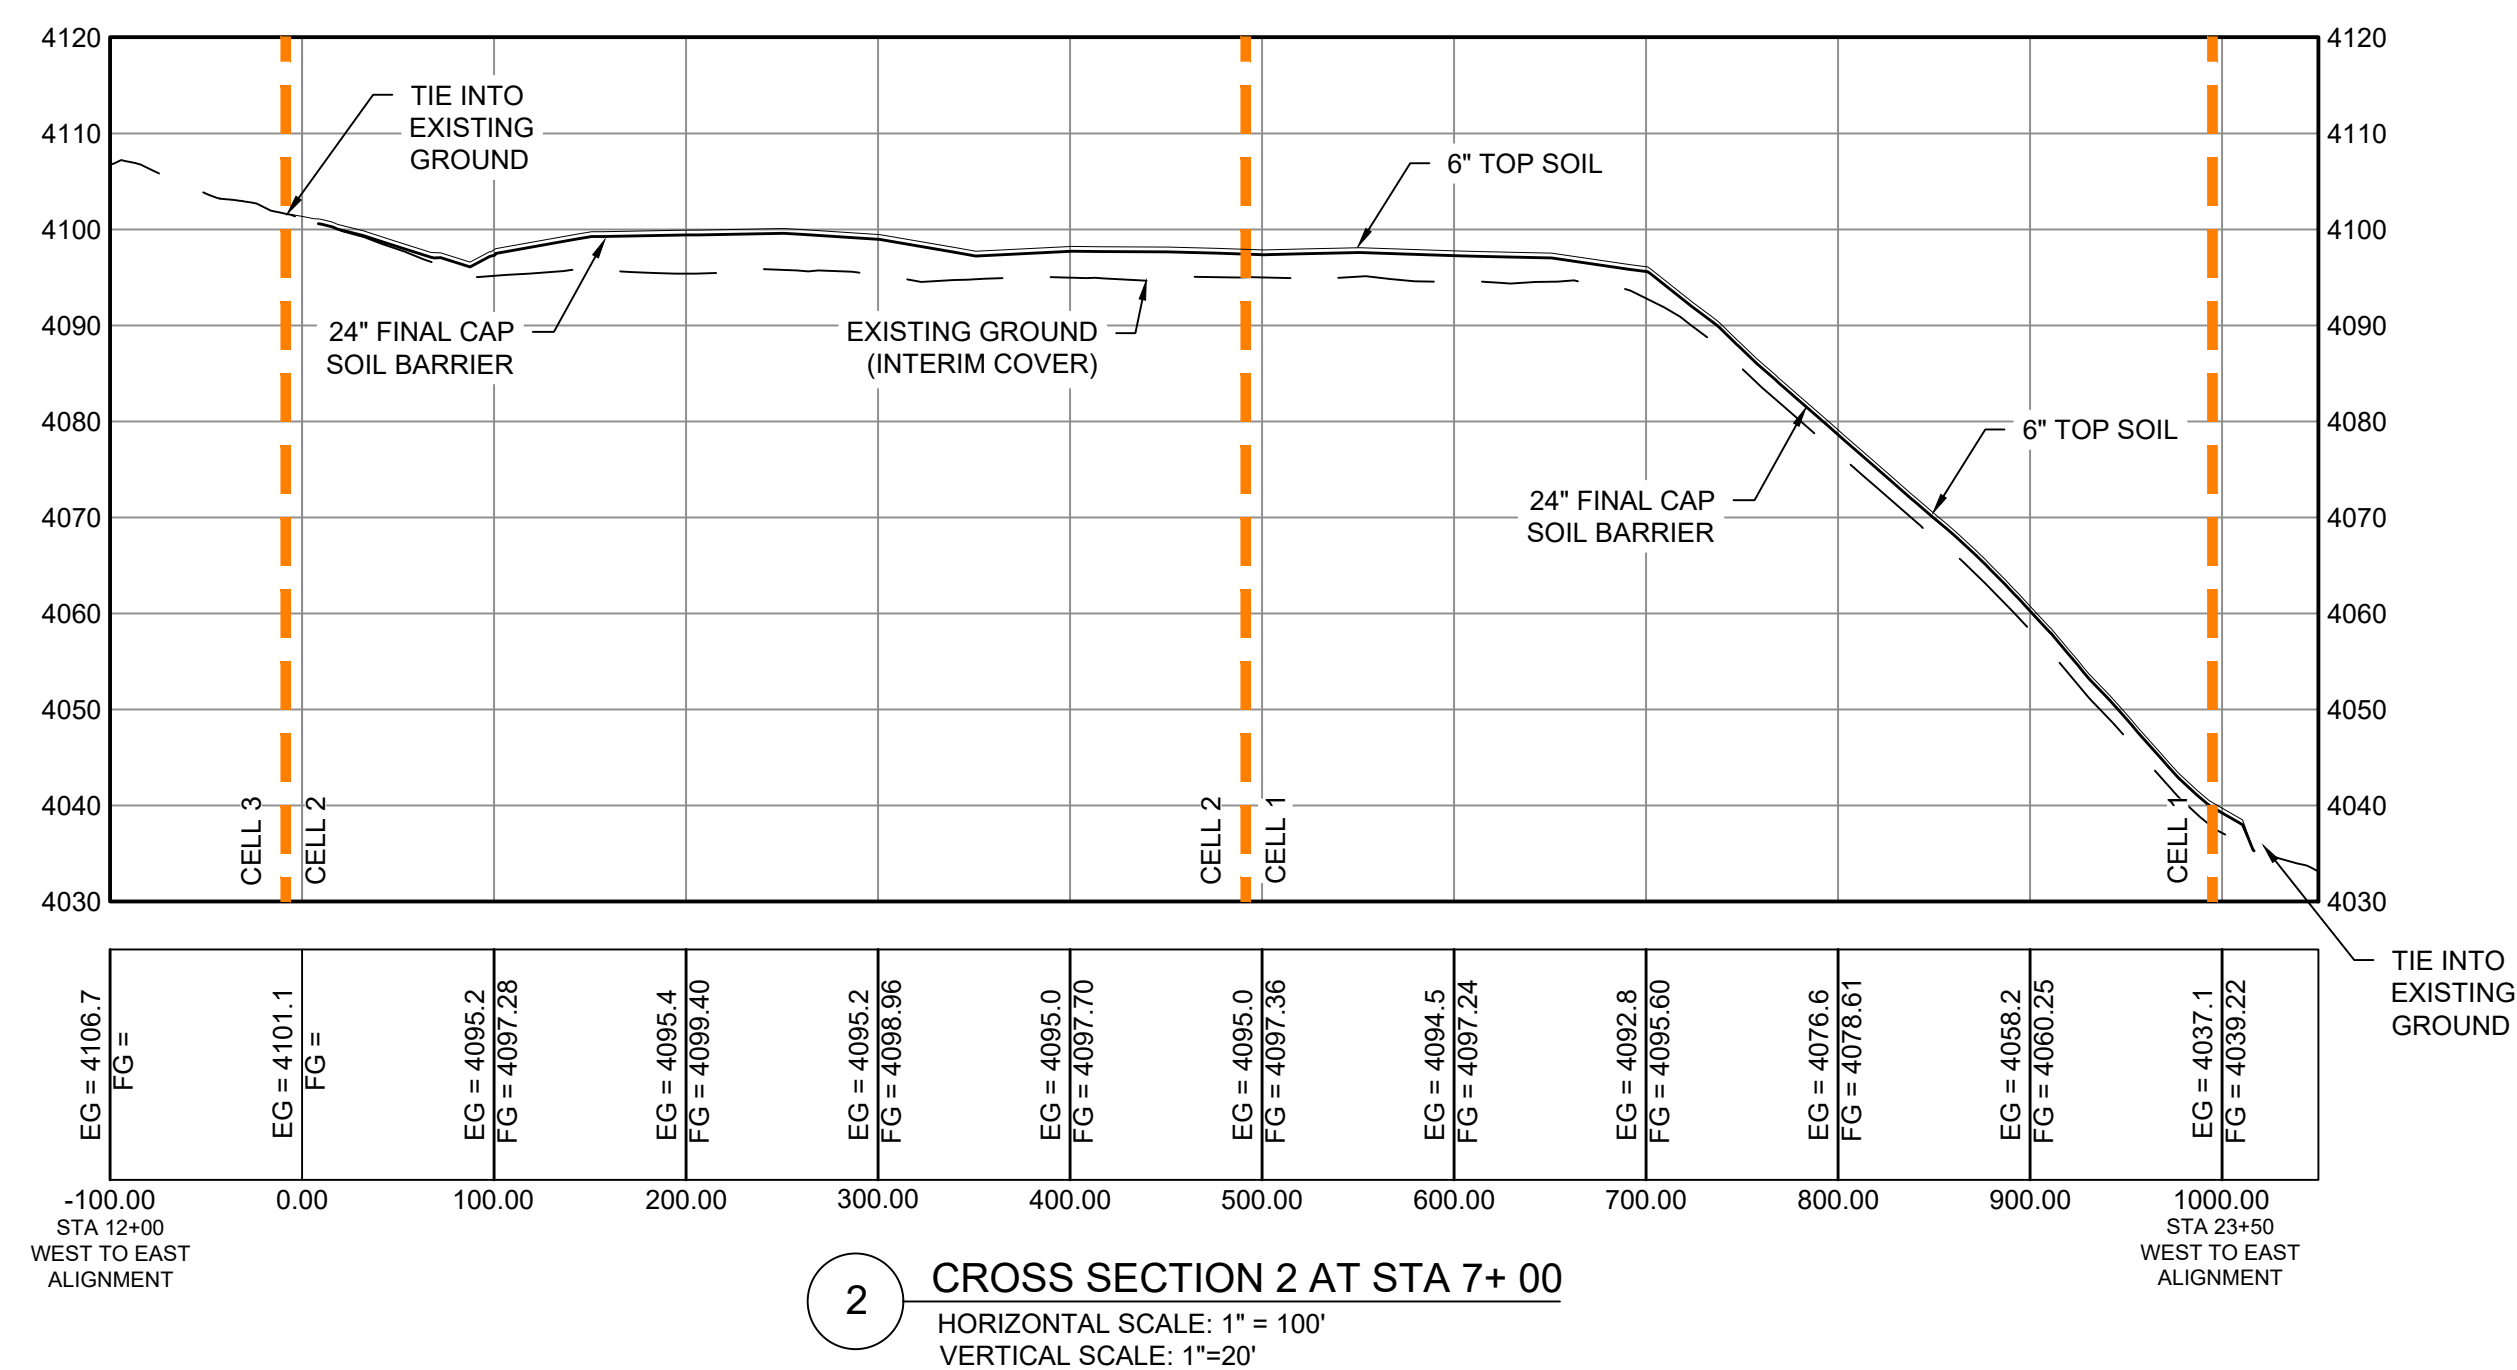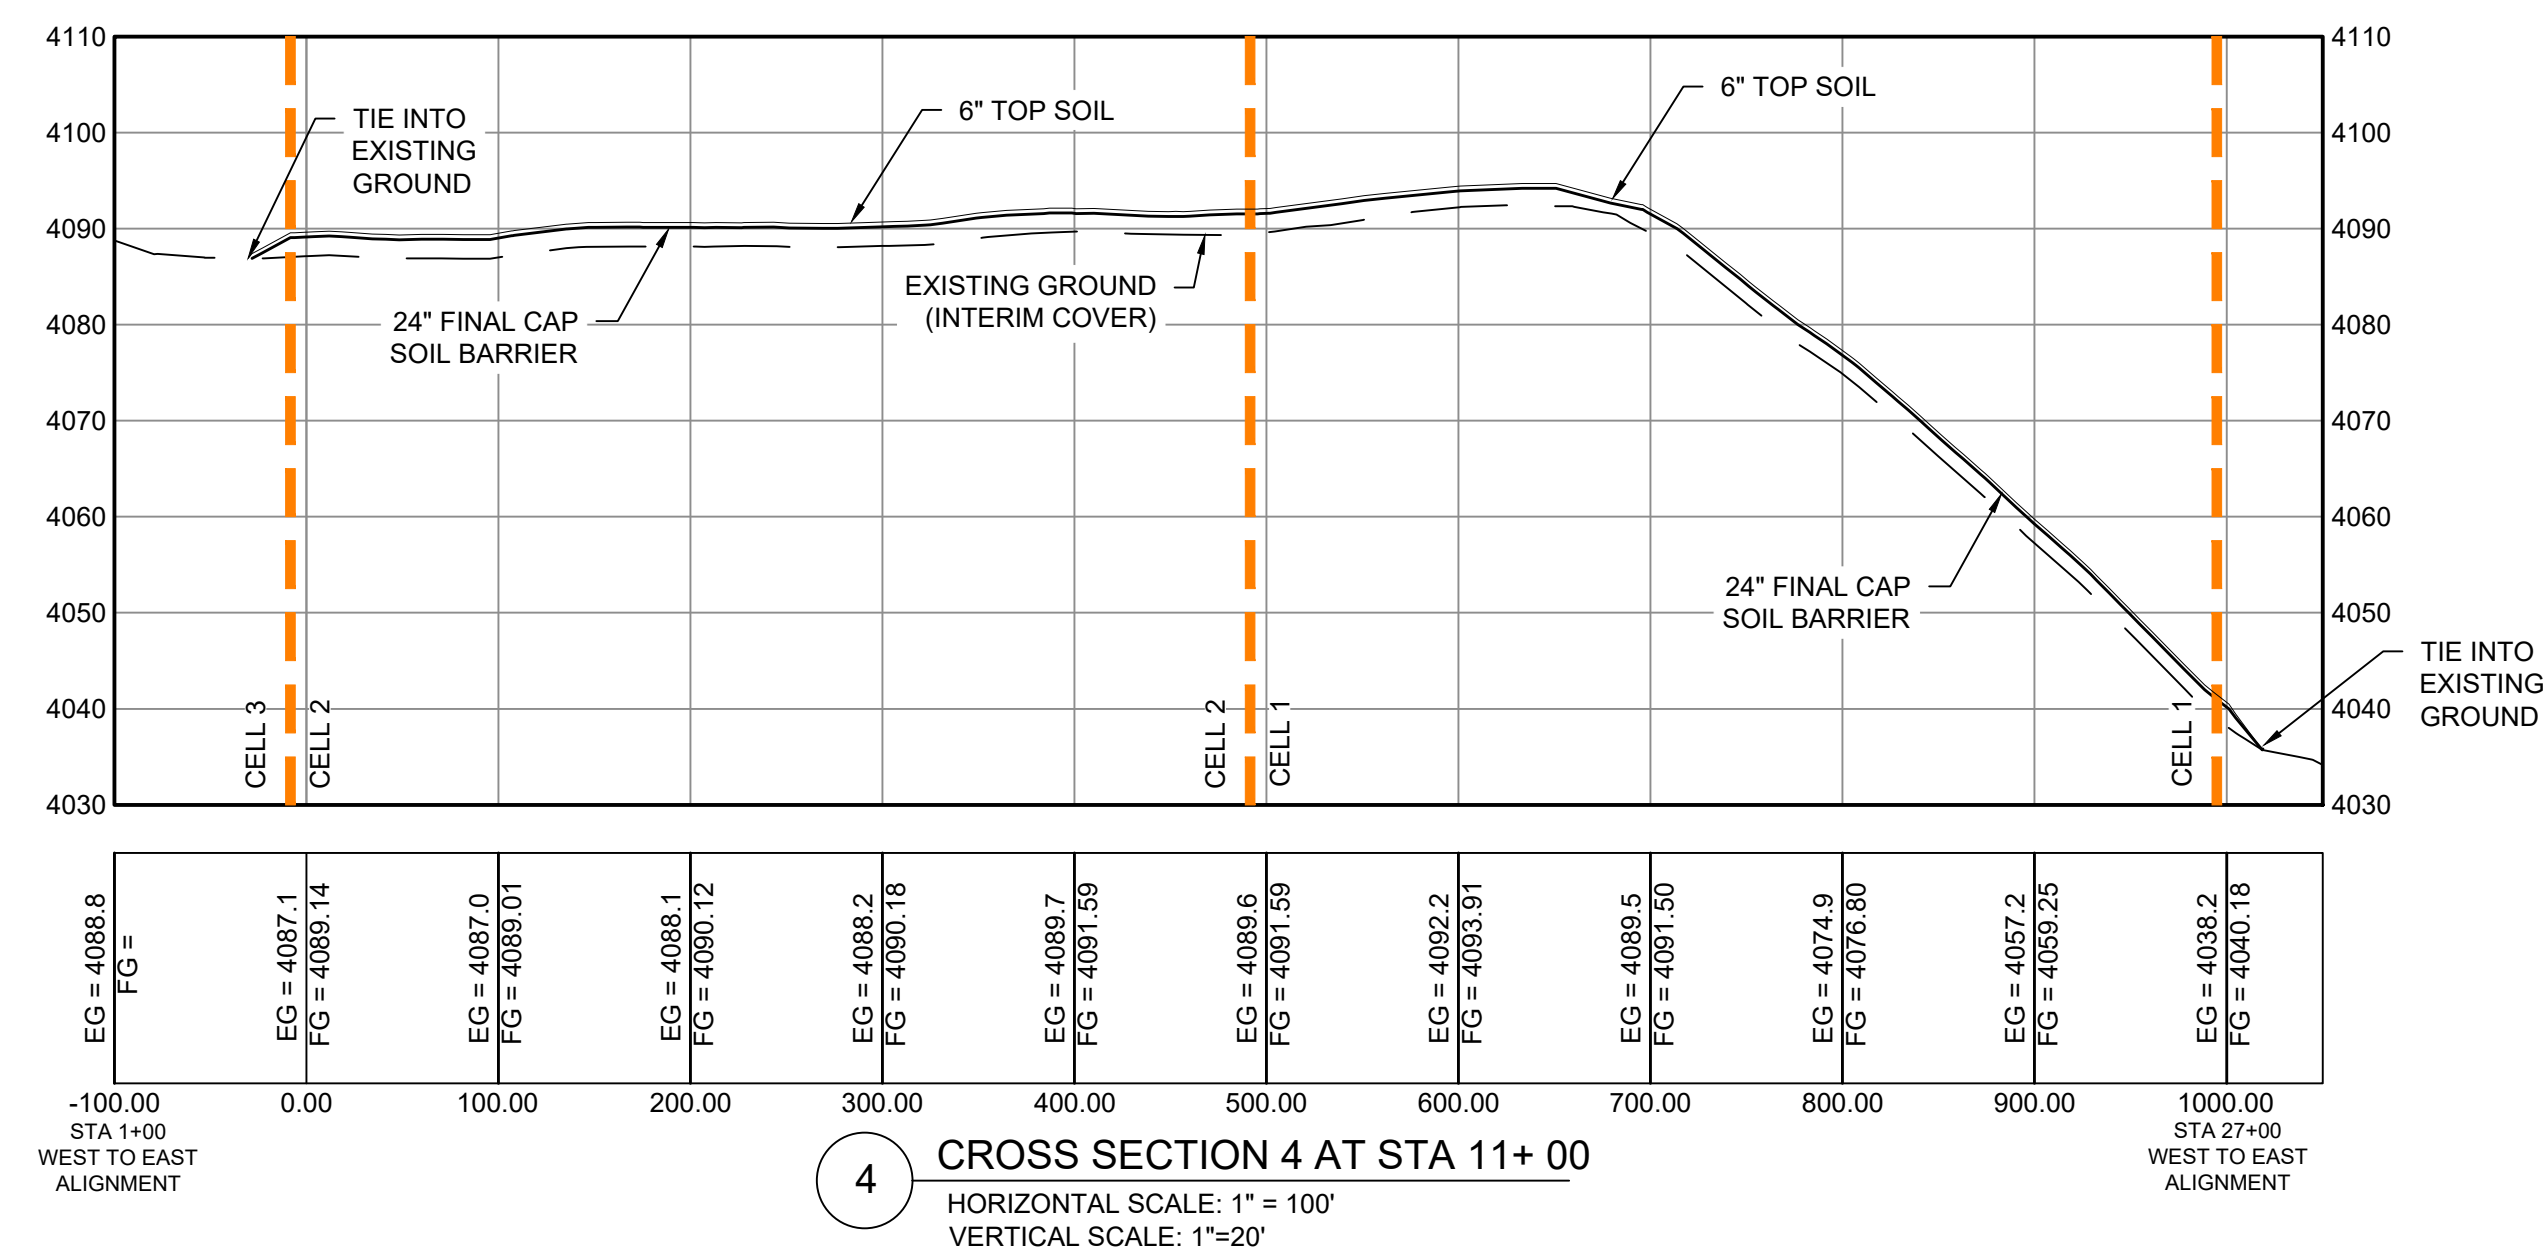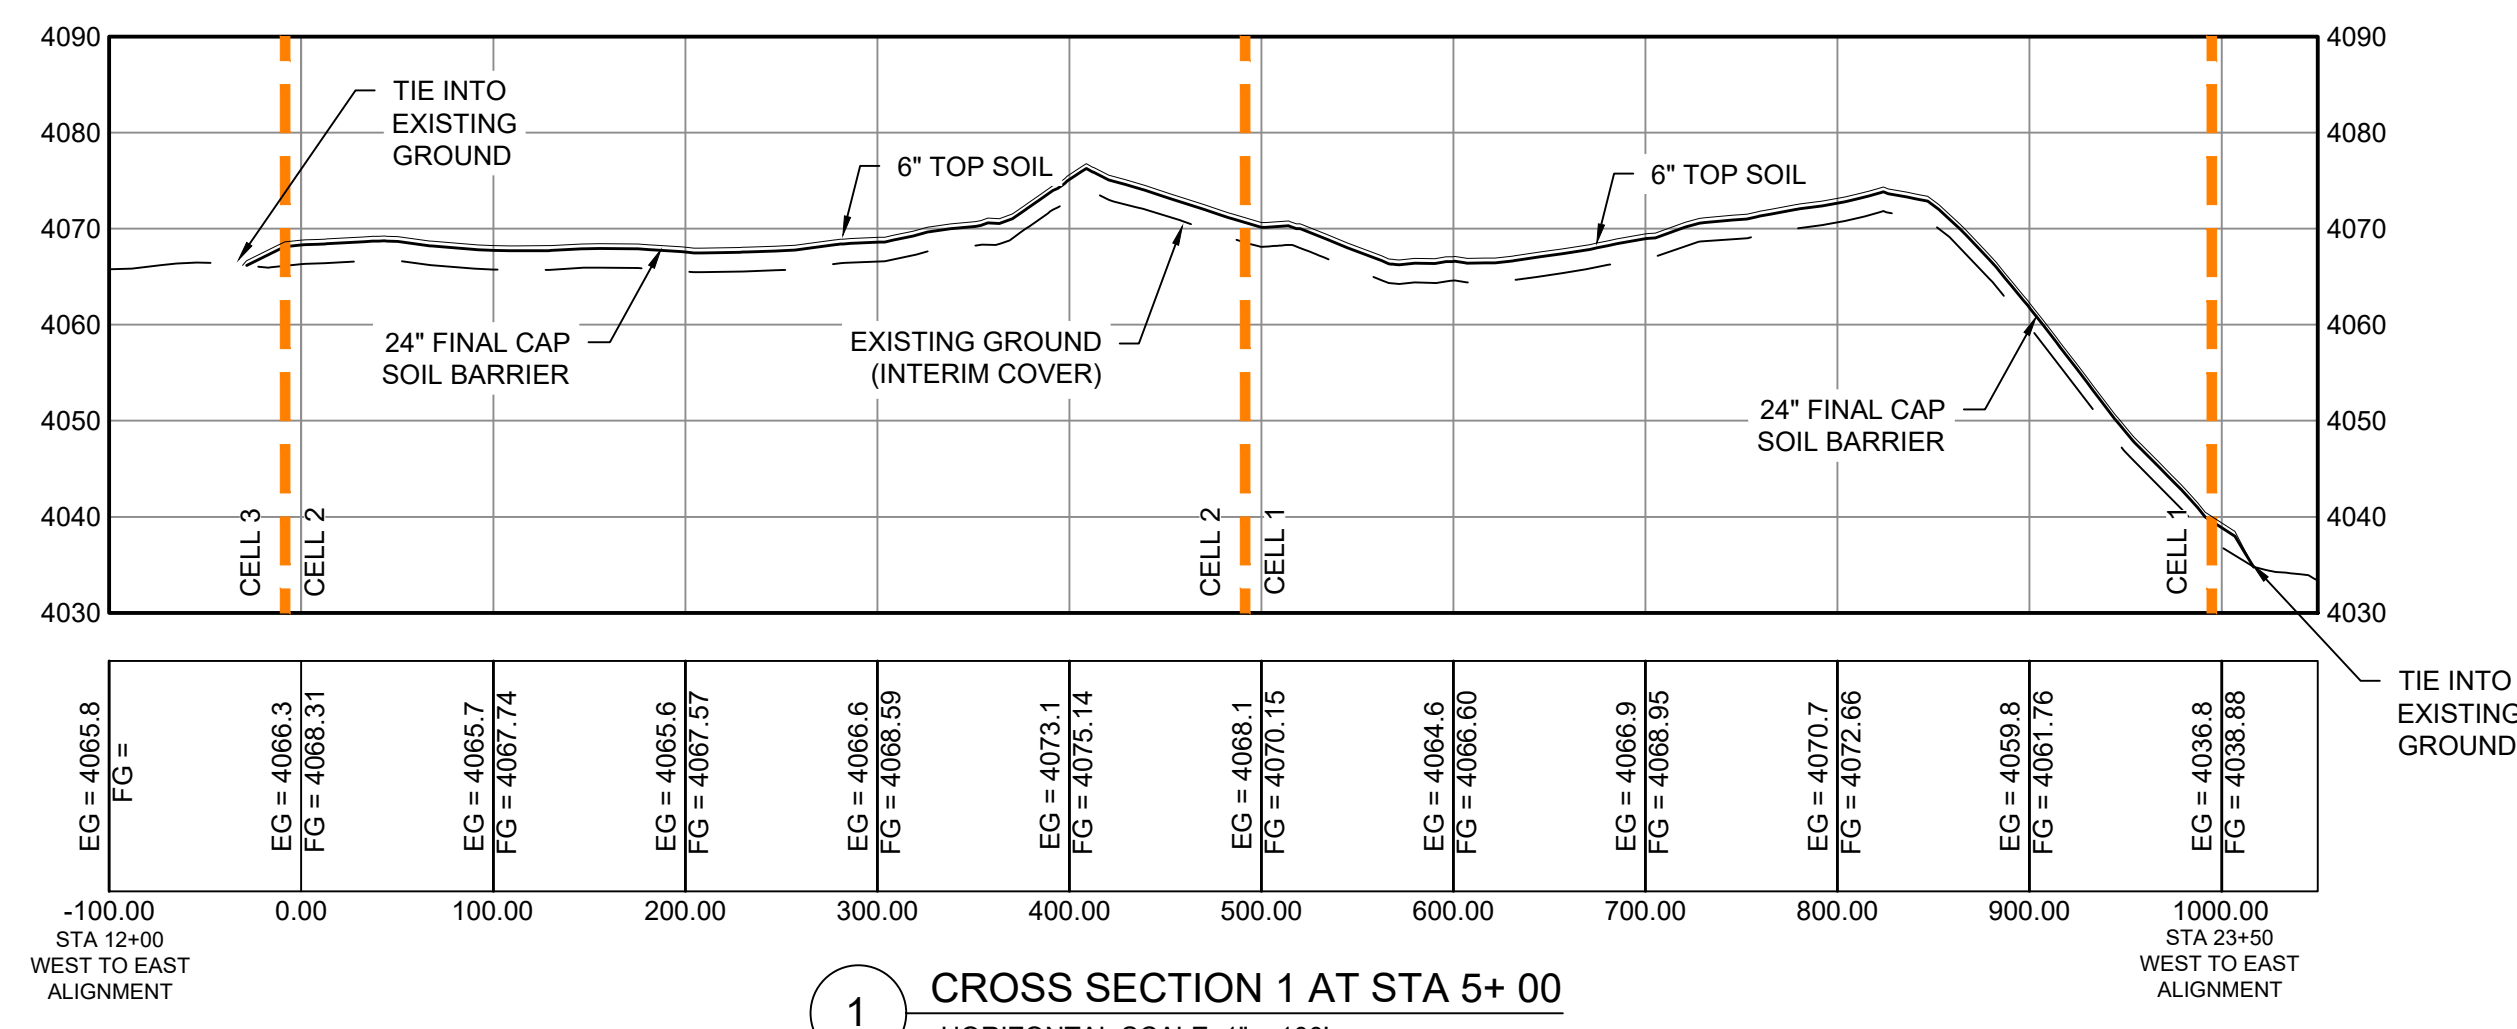

By	CHKD
Rev #	1
Date	1/20/21
Description	DRAWINGS ISSUED FOR CONSTRUCTION
SVG	PJP

**SOUDER, MILLER & ASSOCIATES**  
 Engineering • Environmental • Geomatics  
 Serving the Southwest & Rocky Mountains  
 3500 Saldonia Hills Pkwy.  
 Las Cruces, NM 88011  
 Phone: (575) 647-0799 Fax: (575) 647-0680  
 www.soudermiller.com

ALAMOGORDO, NEW MEXICO  
**GREENTREE REGIONAL LANDFILL CELLS NO. 1 AND 2**  
 OTERO COUNTY, NEW MEXICO  
 SOUTH TO NORTH ALIGNMENT  
 CROSS SECTIONS 1 THRU 5



02/11/2021

THIS DRAWING IS INCOMPLETE AND NOT TO BE USED FOR CONSTRUCTION UNLESS IT IS STAMPED, SIGNED AND DATED


Designed	SVG	Drawn	DJB	Checked	PJP
Date:	February 2021				
Scale:	Horiz: 1" = 100' Vert: 1" = 20'				
Project No:	4328859				
Sheet:	C500				




**To Request a Line Locate Dial 811**

New Mexico state law requires everyone involved in any excavation to provide at least two working days' notice to owners of underground facilities when a dig is planned. All facility owners are then required to mark the locations of any underground lines or take other appropriate measures to protect them.




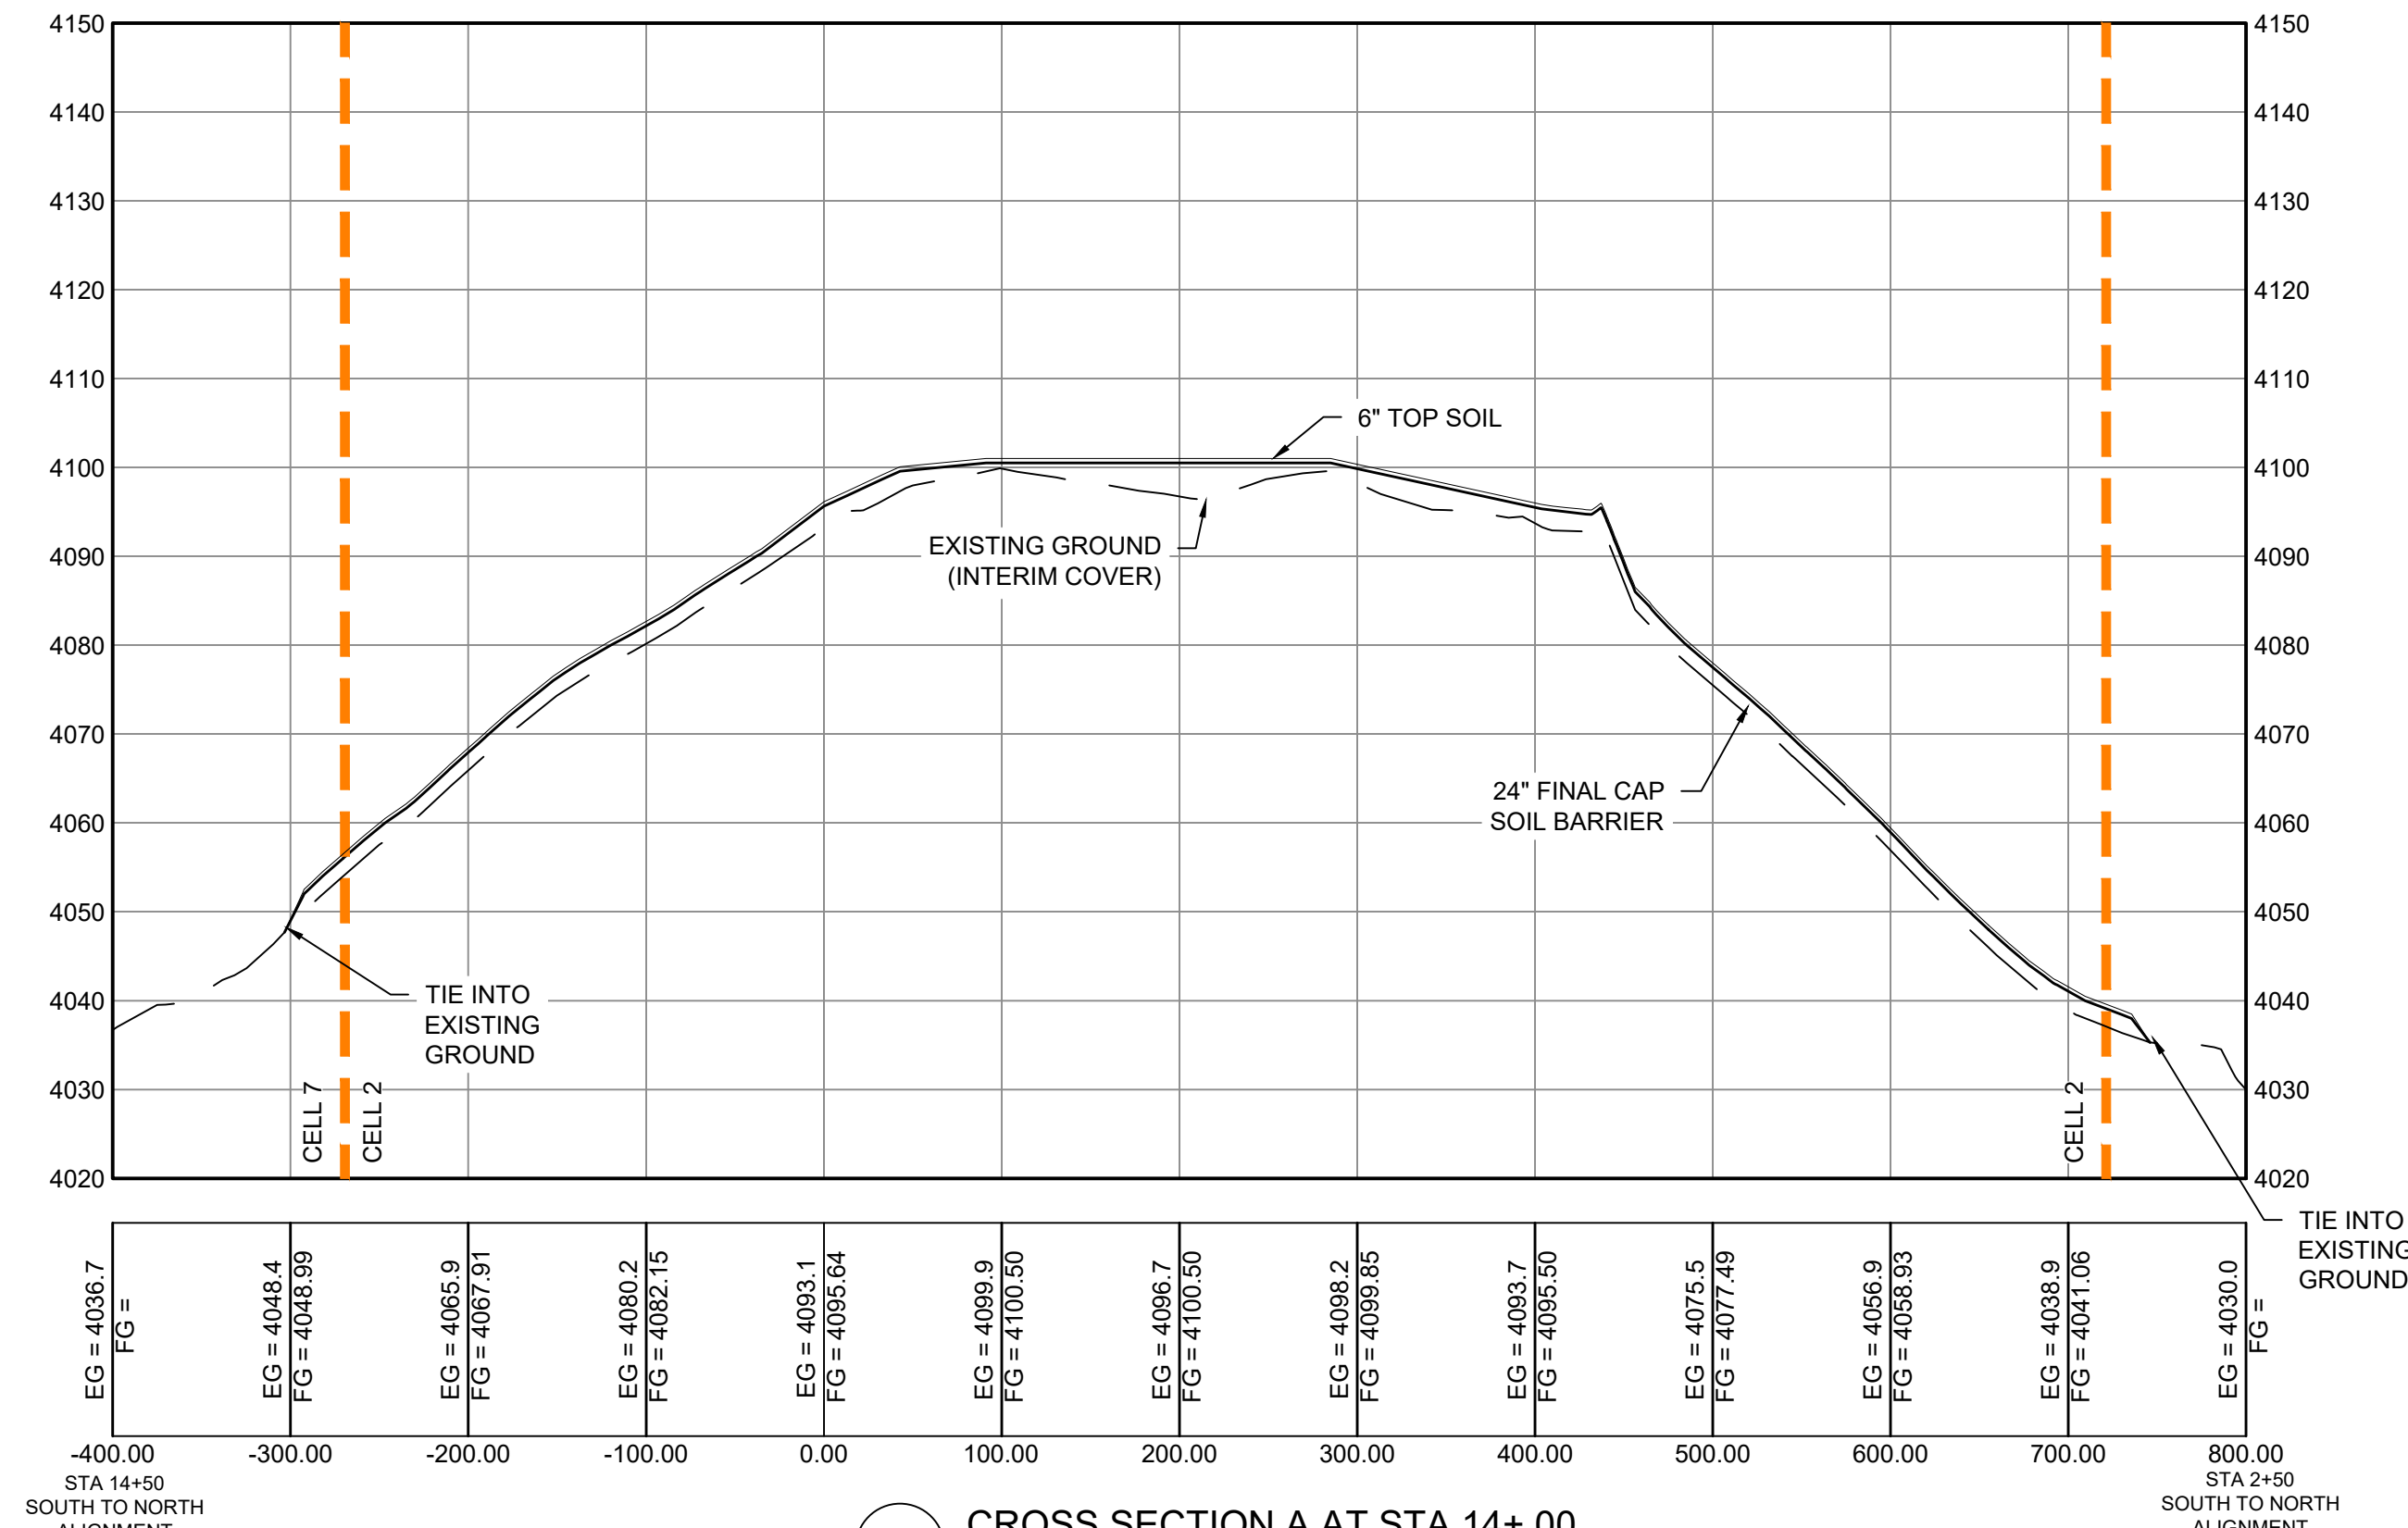


**A** CROSS SECTION A AT STA 14 + 00  
HORIZONTAL SCALE: 1" = 100'  
VERTICAL SCALE: 1" = 20'

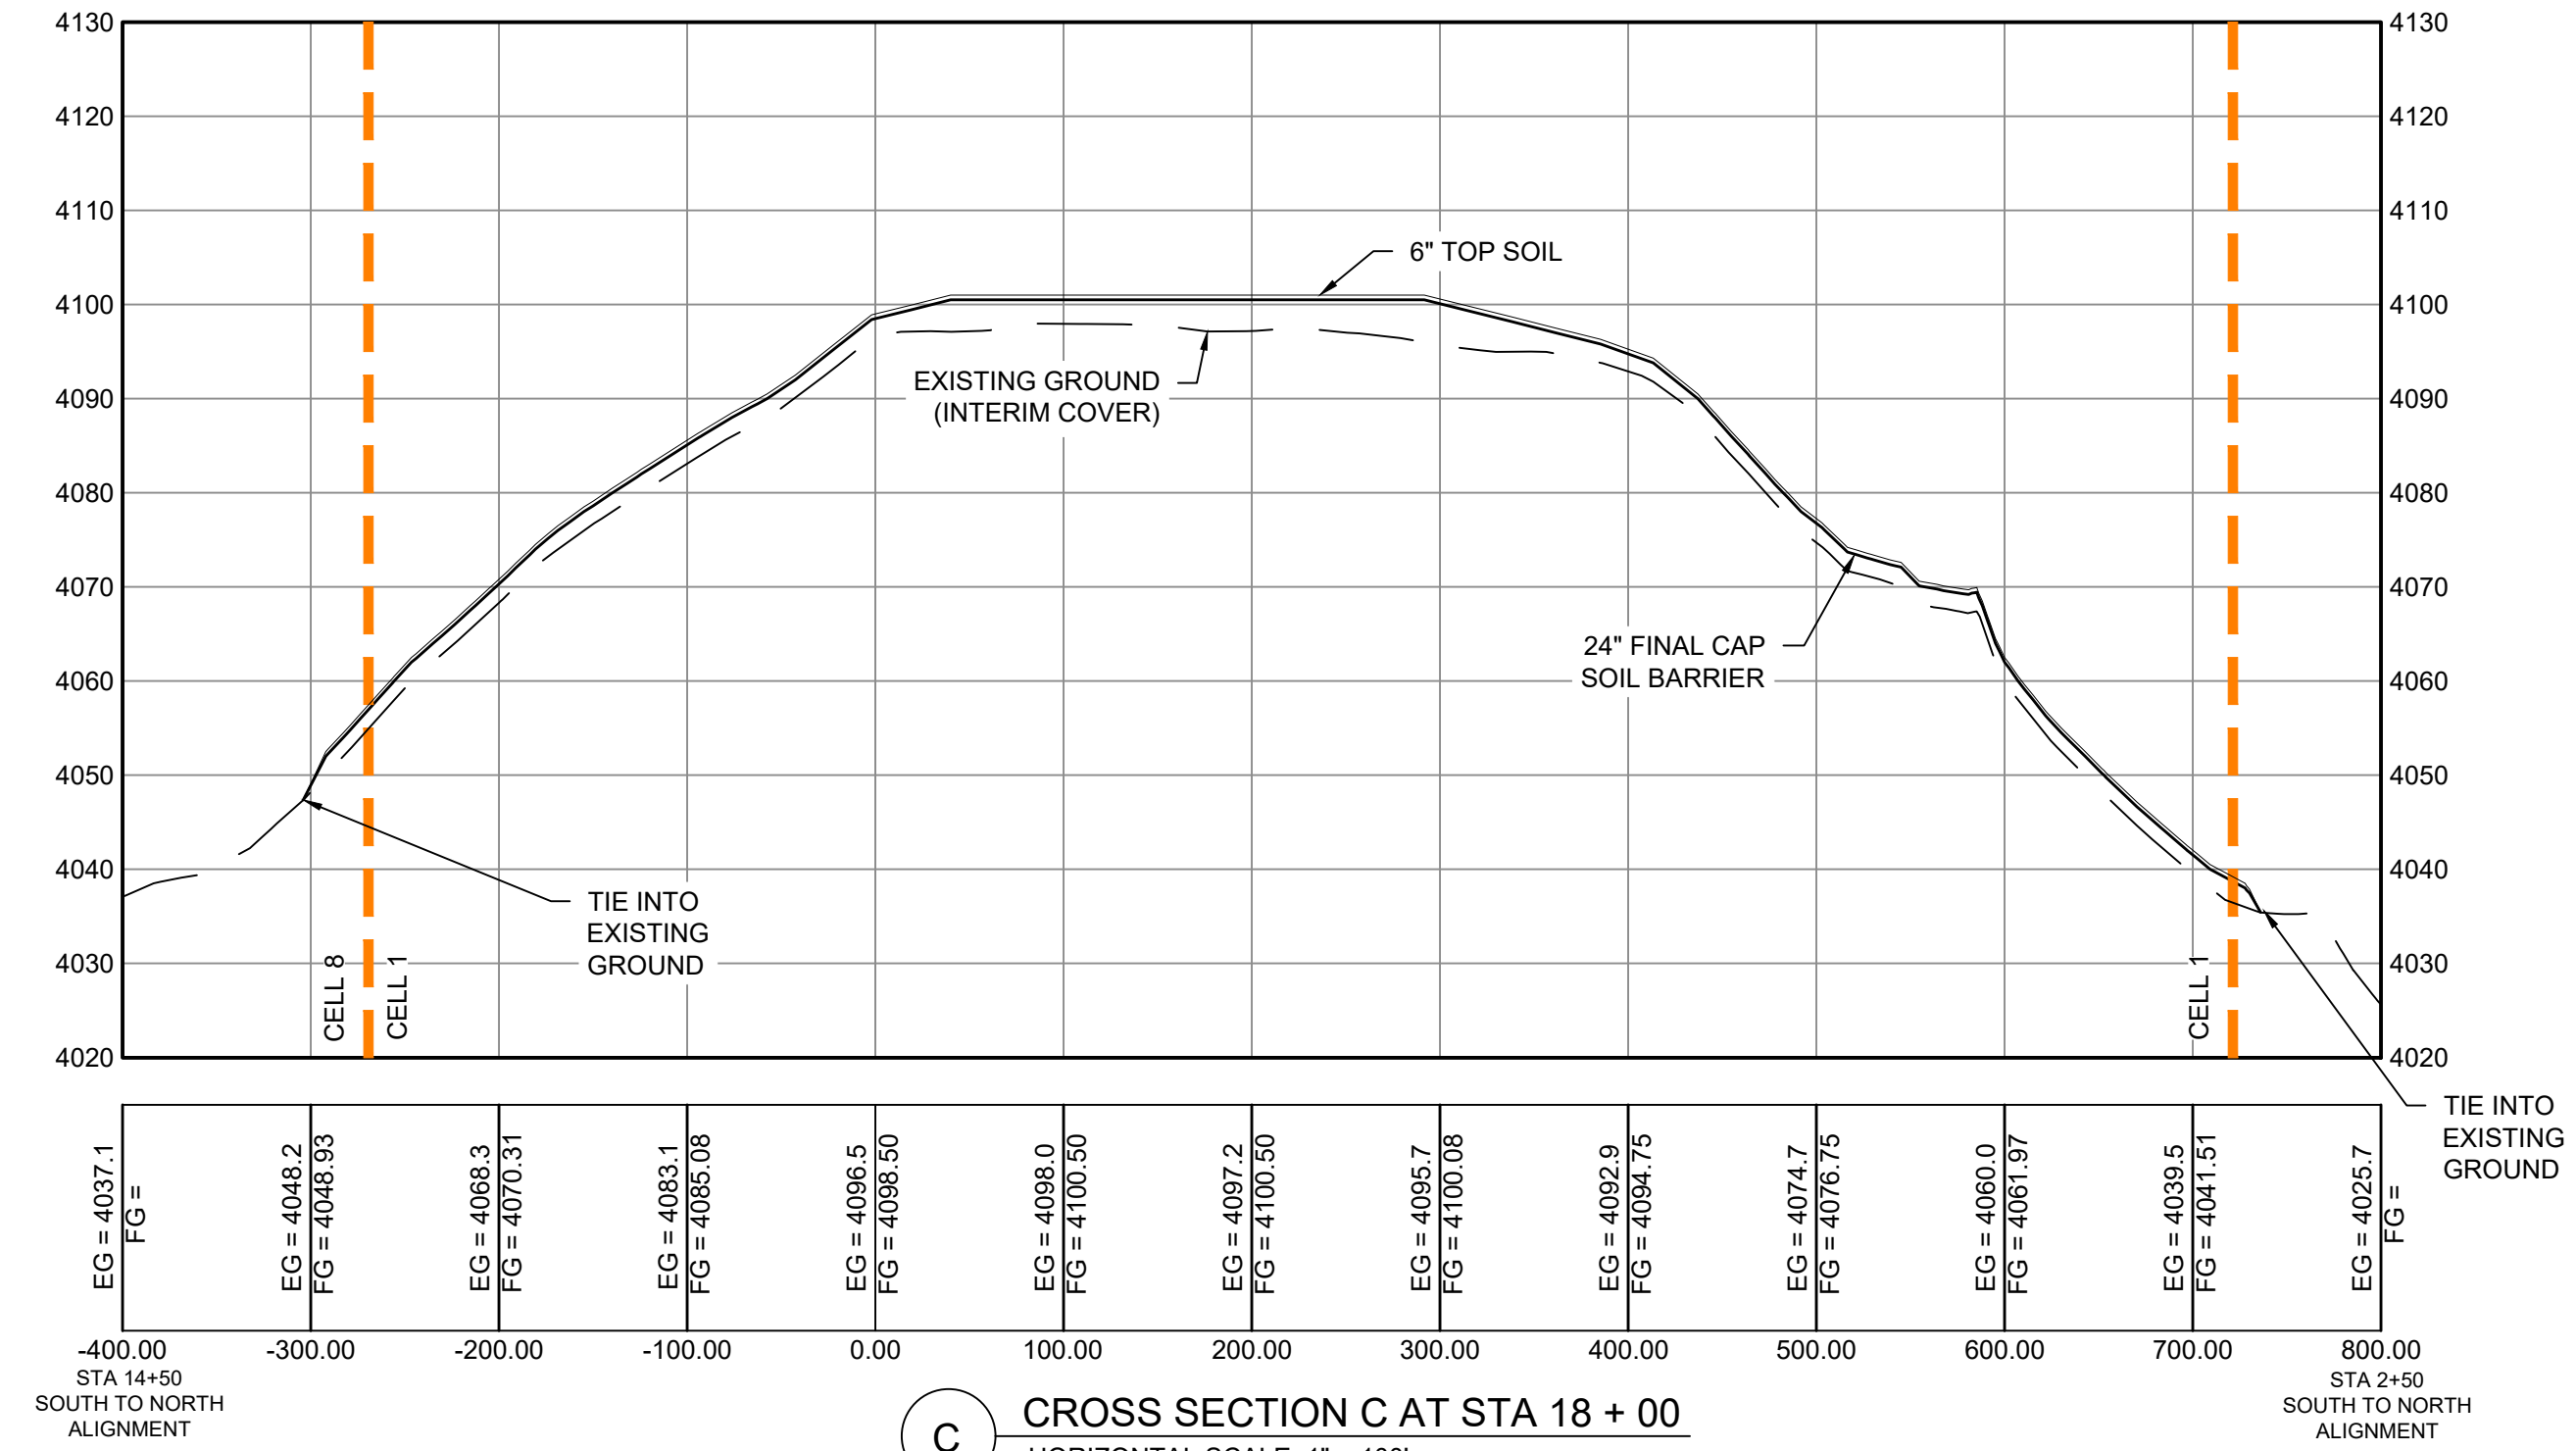

**C** CROSS SECTION C AT STA 18 + 00  
HORIZONTAL SCALE: 1" = 100'  
VERTICAL SCALE: 1" = 20'

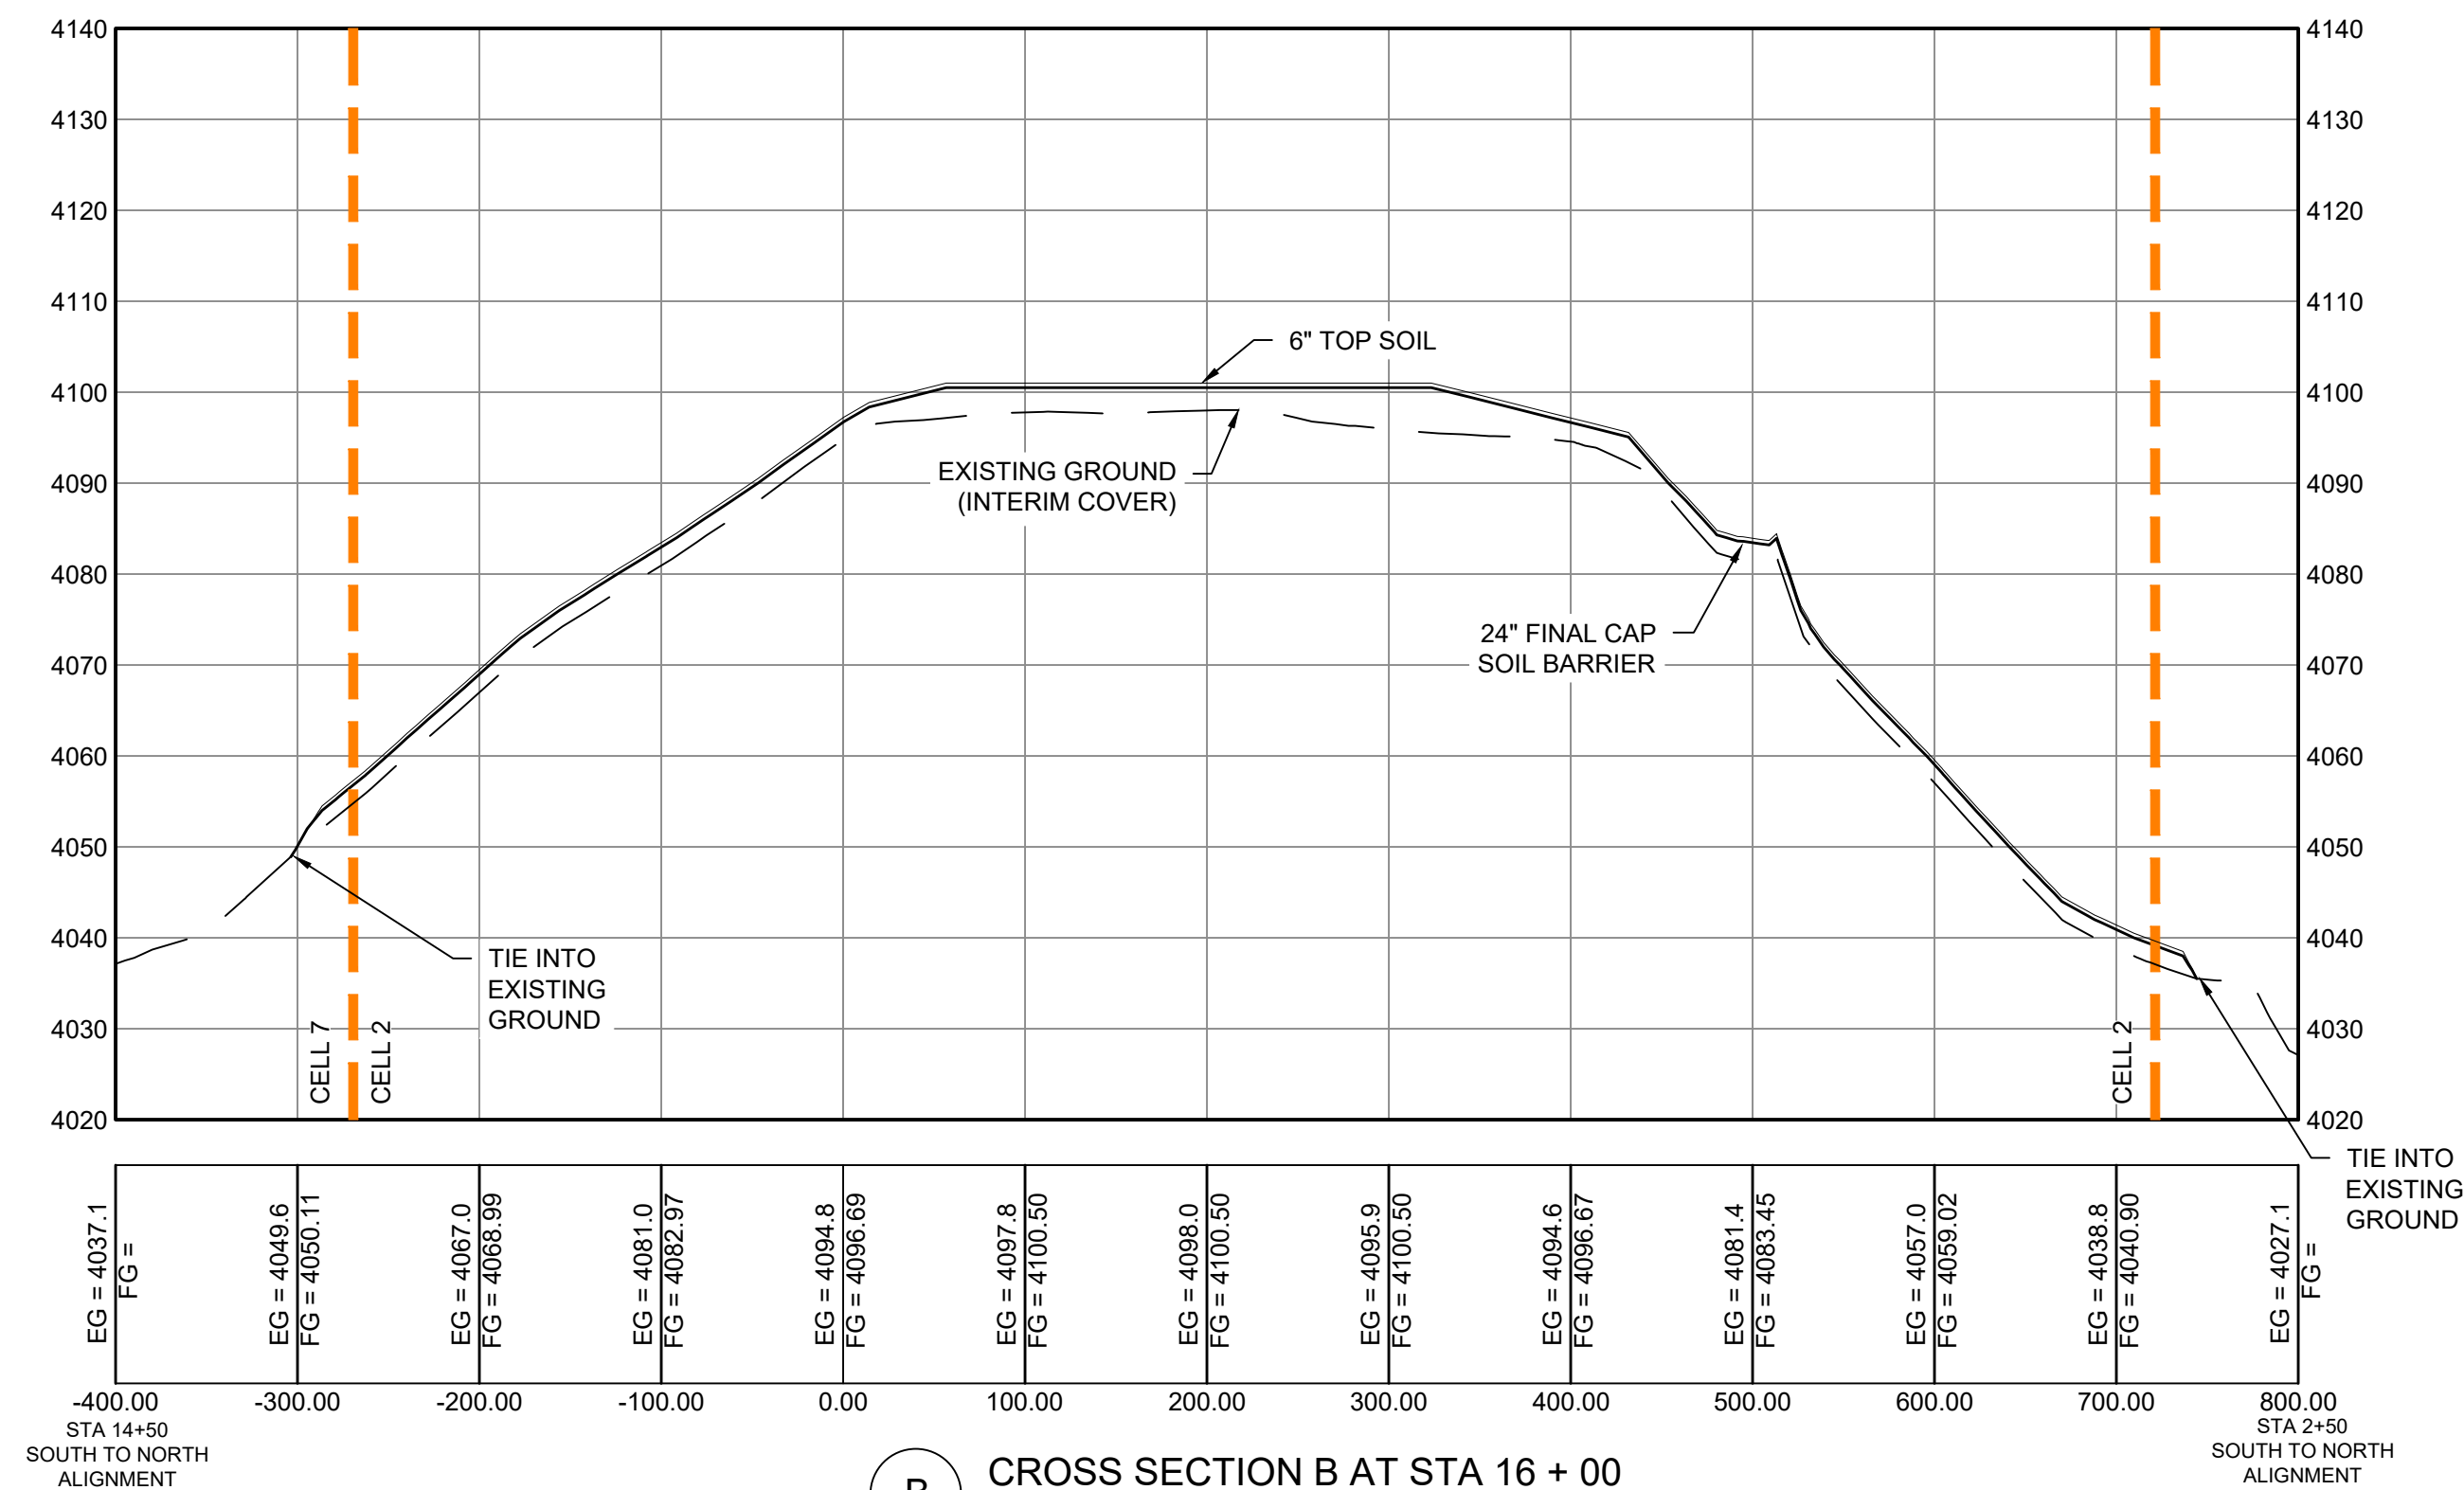

**B** CROSS SECTION B AT STA 16 + 00  
HORIZONTAL SCALE: 1" = 100'  
VERTICAL SCALE: 1" = 20'

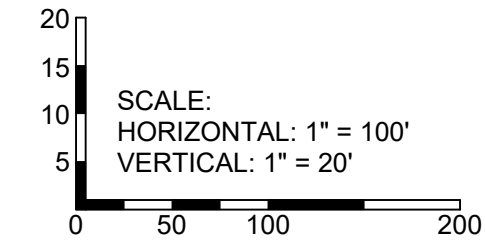

Rev #	Date	Description
1	10/04	DRAWINGS ISSUED FOR CONSTRUCTION

**SOUDER, MILLER & ASSOCIATES**  
 Engineering • Environmental • Geomatics  
 Serving the Southwest & Rocky Mountains  
 3500 Sedona Hills Pkwy.  
 Las Cruces, NM 88011  
 Phone: (505) 647-0799 Fax: (505) 647-0680  
 www.soudermiller.com

ALAMOGORDO, NEW MEXICO  
**GREENTREE REGIONAL LANDFILL CELLS NO. 1 AND 2**  
 OTERO COUNTY, NEW MEXICO  
 WEST TO EAST ALIGNMENT  
 CROSS SECTIONS A THRU C




02/11/2021		
THIS DRAWING IS INCOMPLETE AND NOT TO BE USED FOR CONSTRUCTION UNLESS IT IS STAMPED, SIGNED AND DATED		
Designed: SVG	Drawn: DJB	Checked: PJP
Date: February 2021		
Scale: Horiz: 1" = 100'	Vert: 1" = 20'	
Project No: 4328859		
Sheet: C501		



New Mexico One Call, Inc.  
**NMOC**  
 Call Two Working Days Before You Dig!  
 It's Free and It's the Law!

**To Request a Line Locate Dial 811**  
 New Mexico state law requires everyone involved in any excavation to provide at least two working days' notice to owners of underground facilities when a dig is planned. All facility owners are then required to mark the locations of any underground lines or take other appropriate measures to protect them.



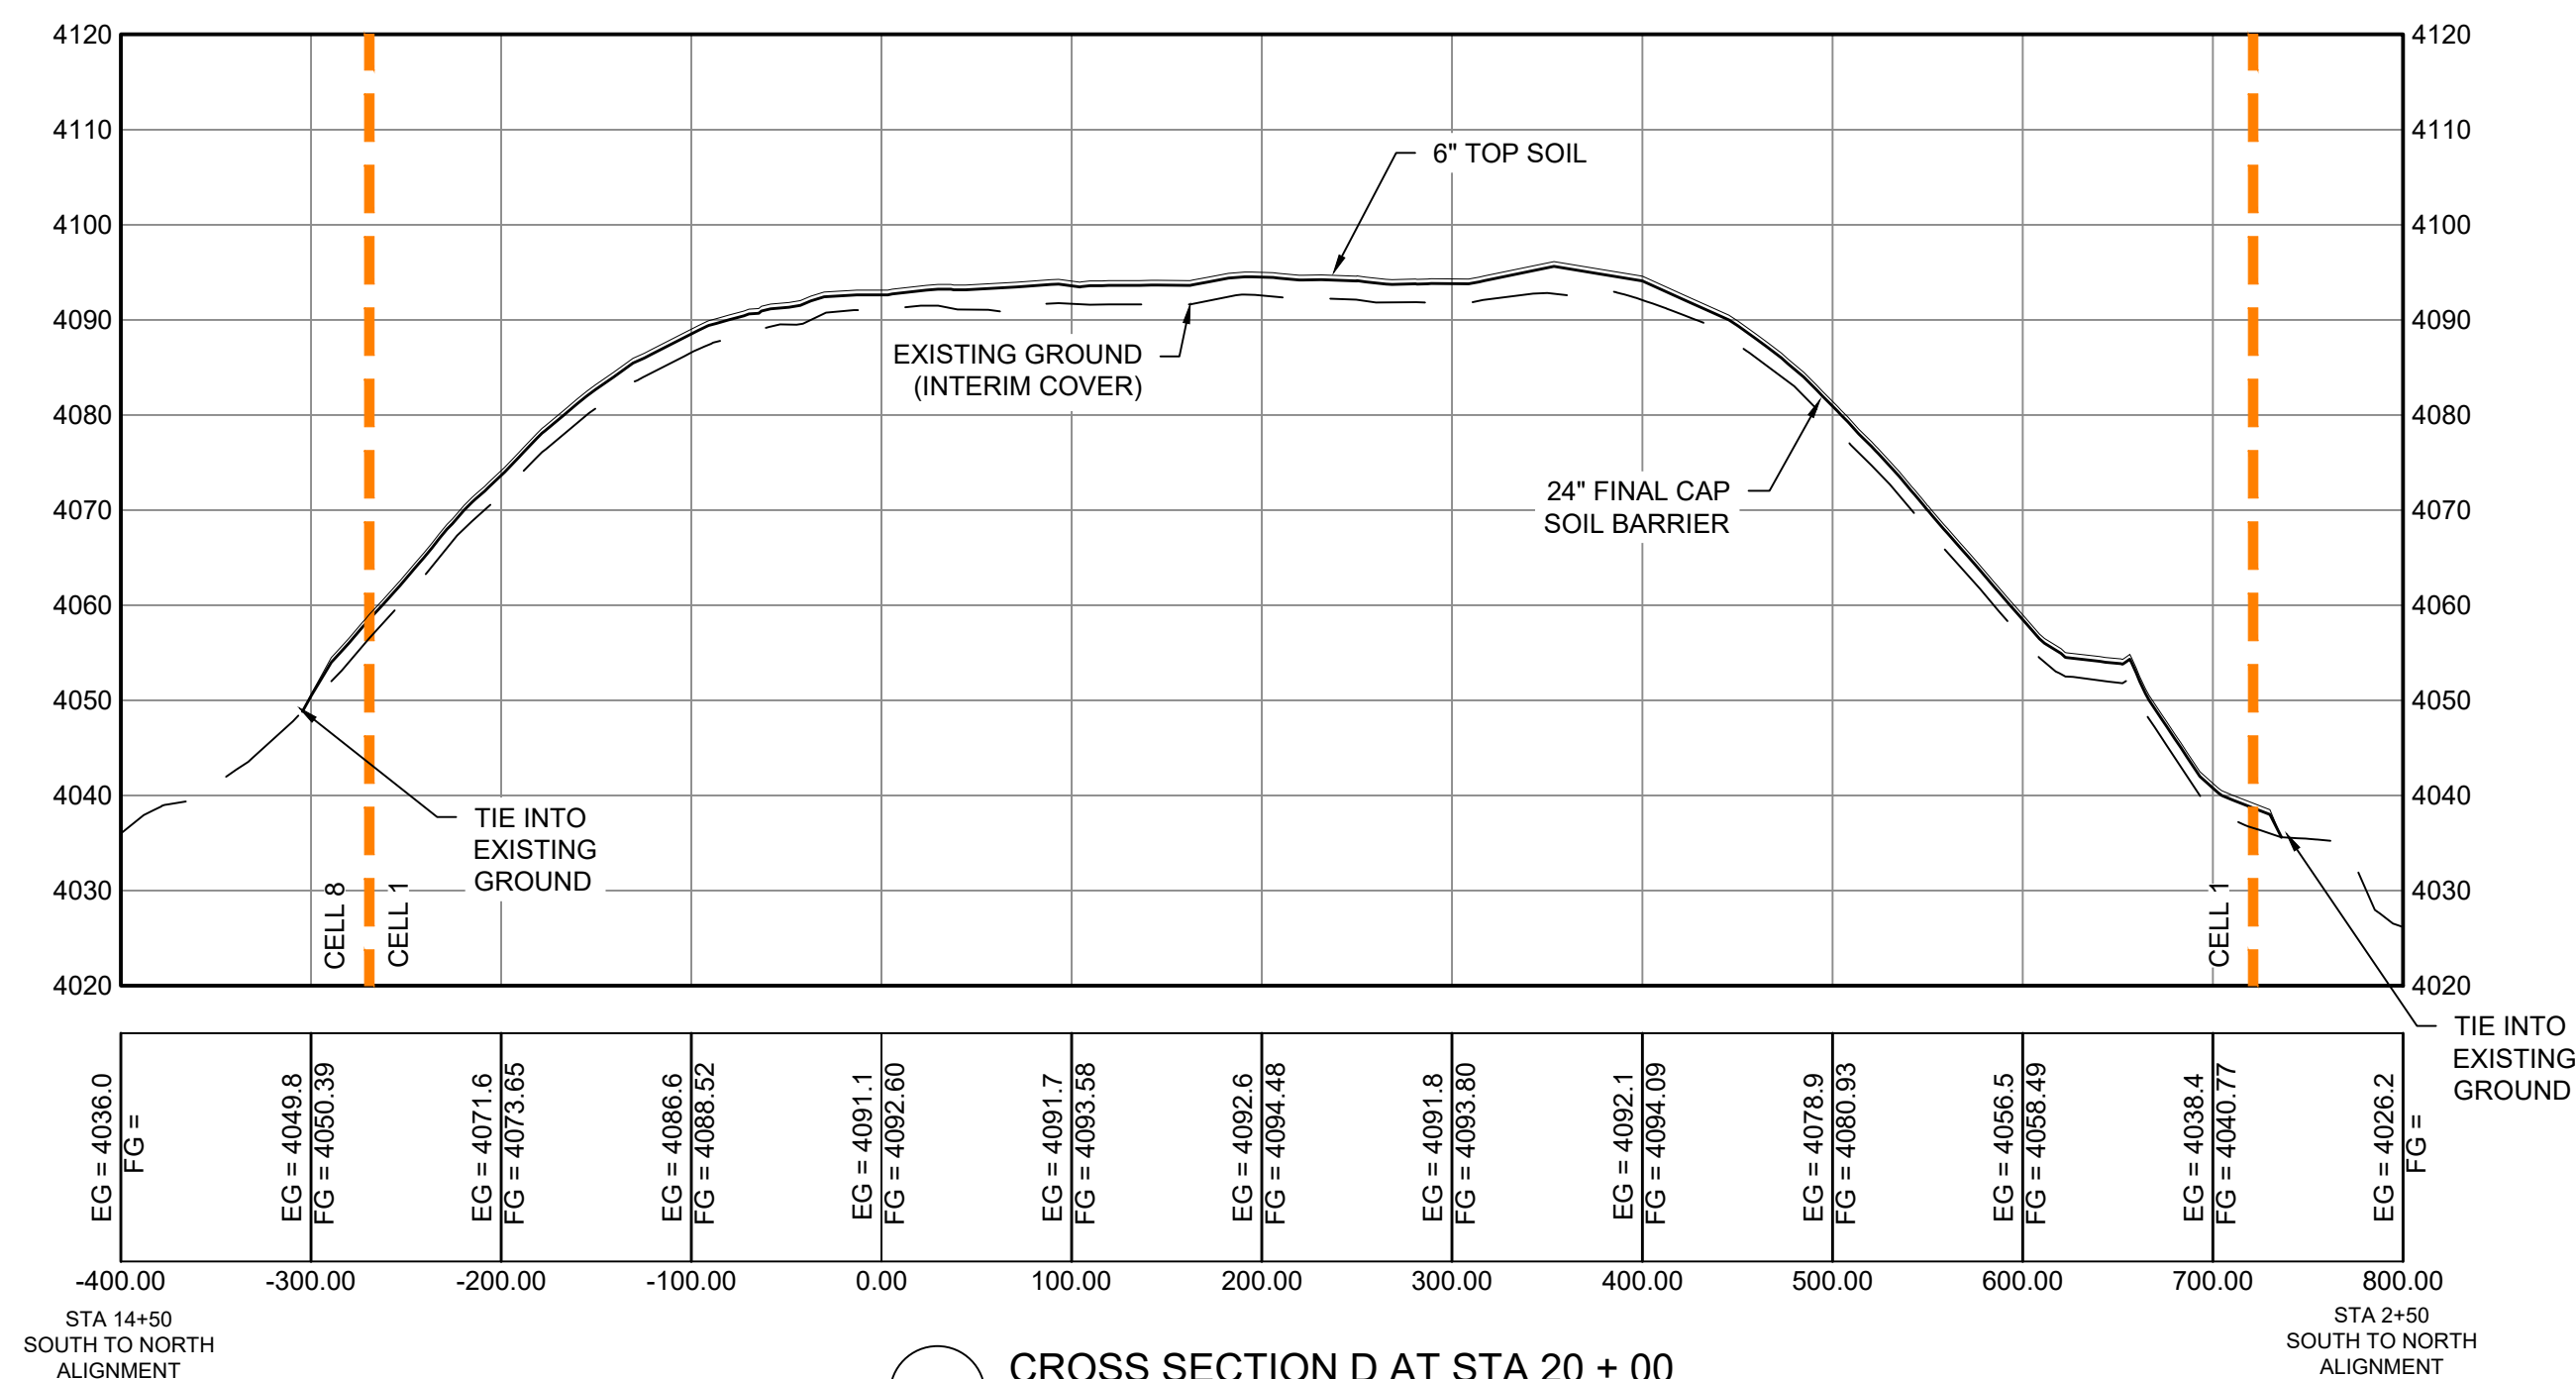

**D** CROSS SECTION D AT STA 20 + 00  
 HORIZONTAL SCALE: 1" = 100'  
 VERTICAL SCALE: 1" = 20'

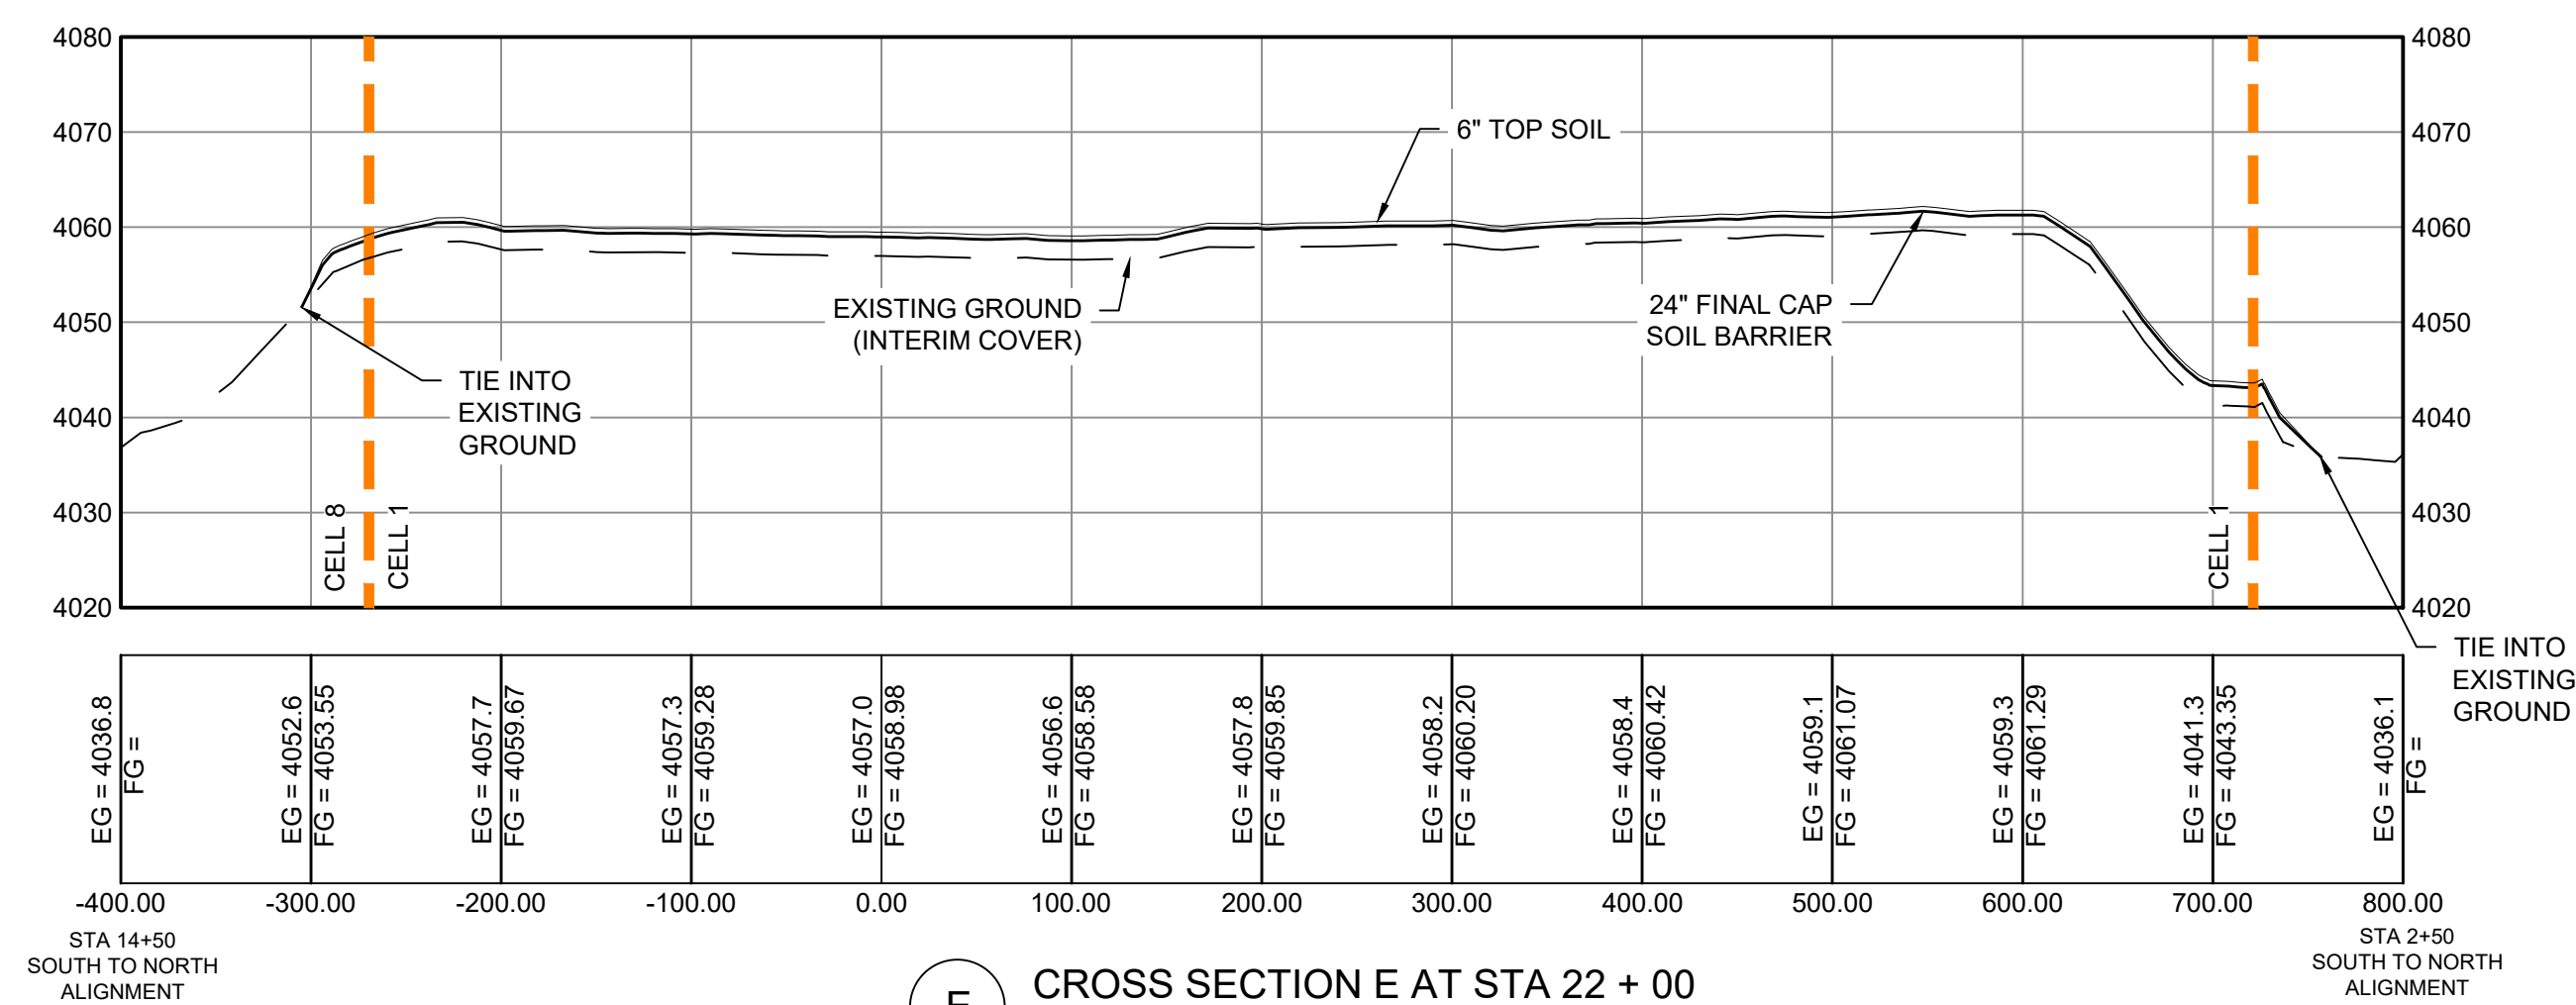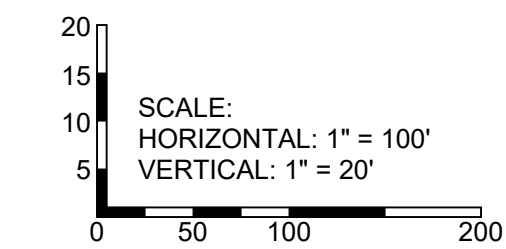

**E** CROSS SECTION E AT STA 22 + 00  
 HORIZONTAL SCALE: 1" = 100'  
 VERTICAL SCALE: 1" = 20'



**To Request a Line Locate Dial 811**  
 New Mexico state law requires everyone involved in any excavation to provide at least two working days' notice to owners of underground facilities when a dig is planned. All facility owners are then required to mark the locations of any underground lines or take other appropriate measures to protect them.

Rev.#	Date	Description	By	Checked
1	10/04	DRAWINGS ISSUED FOR CONSTRUCTION	SVG	PJP

**SOUDER, MILLER & ASSOCIATES**  
 Engineering • Environmental • Geomatics  
 Serving the Southwest & Rocky Mountains  
 3500 Sedona Hills Pkwy.  
 Las Cruces, NM 88011  
 Phone: (575) 647-0799 Fax: (575) 647-0680  
 www.soudermiller.com

ALAMOGORDO, NEW MEXICO  
**GREENTREE REGIONAL LANDFILL CELLS NO. 1 AND 2**  
 OTERO COUNTY, NEW MEXICO  
 WEST TO EAST ALIGNMENT  
 CROSS SECTIONS D THRU E



02/11/2021		
THIS DRAWING IS INCOMPLETE AND NOT TO BE USED FOR CONSTRUCTION UNLESS IT IS STAMPED, SIGNED AND DATED		
Designed	Drawn	Checked
SVG	DJB	PJP
Date:	February 2021	
Scale:	Horiz: 1" = 100' Vert: 1" = 20'	
Project No:	4328859	
Sheet:	C502	