

MEMBERS OF THE AMERICAN INSTITUTE OF ARCHITECTS
COPYRIGHT 2015 ALL RIGHTS RESERVED
PRINTED OR ELECTRONIC DRAWINGS AND DOCUMENTATION MAY NOT BE REPRODUCED IN ANY FORM WITHOUT WRITTEN PERMISSION FROM LS3P ASSOCIATES LTD.


REVISIONS:

No.	Description	Date
1	DUKE ENERGY TX COMMENTS	December 05, 2019

PROJECT: 9201-178520
DATE: JUNE 19, 2019
DRAWN BY: JR
CHECKED BY: MM

ELECTRICAL SITE PLAN

E-010

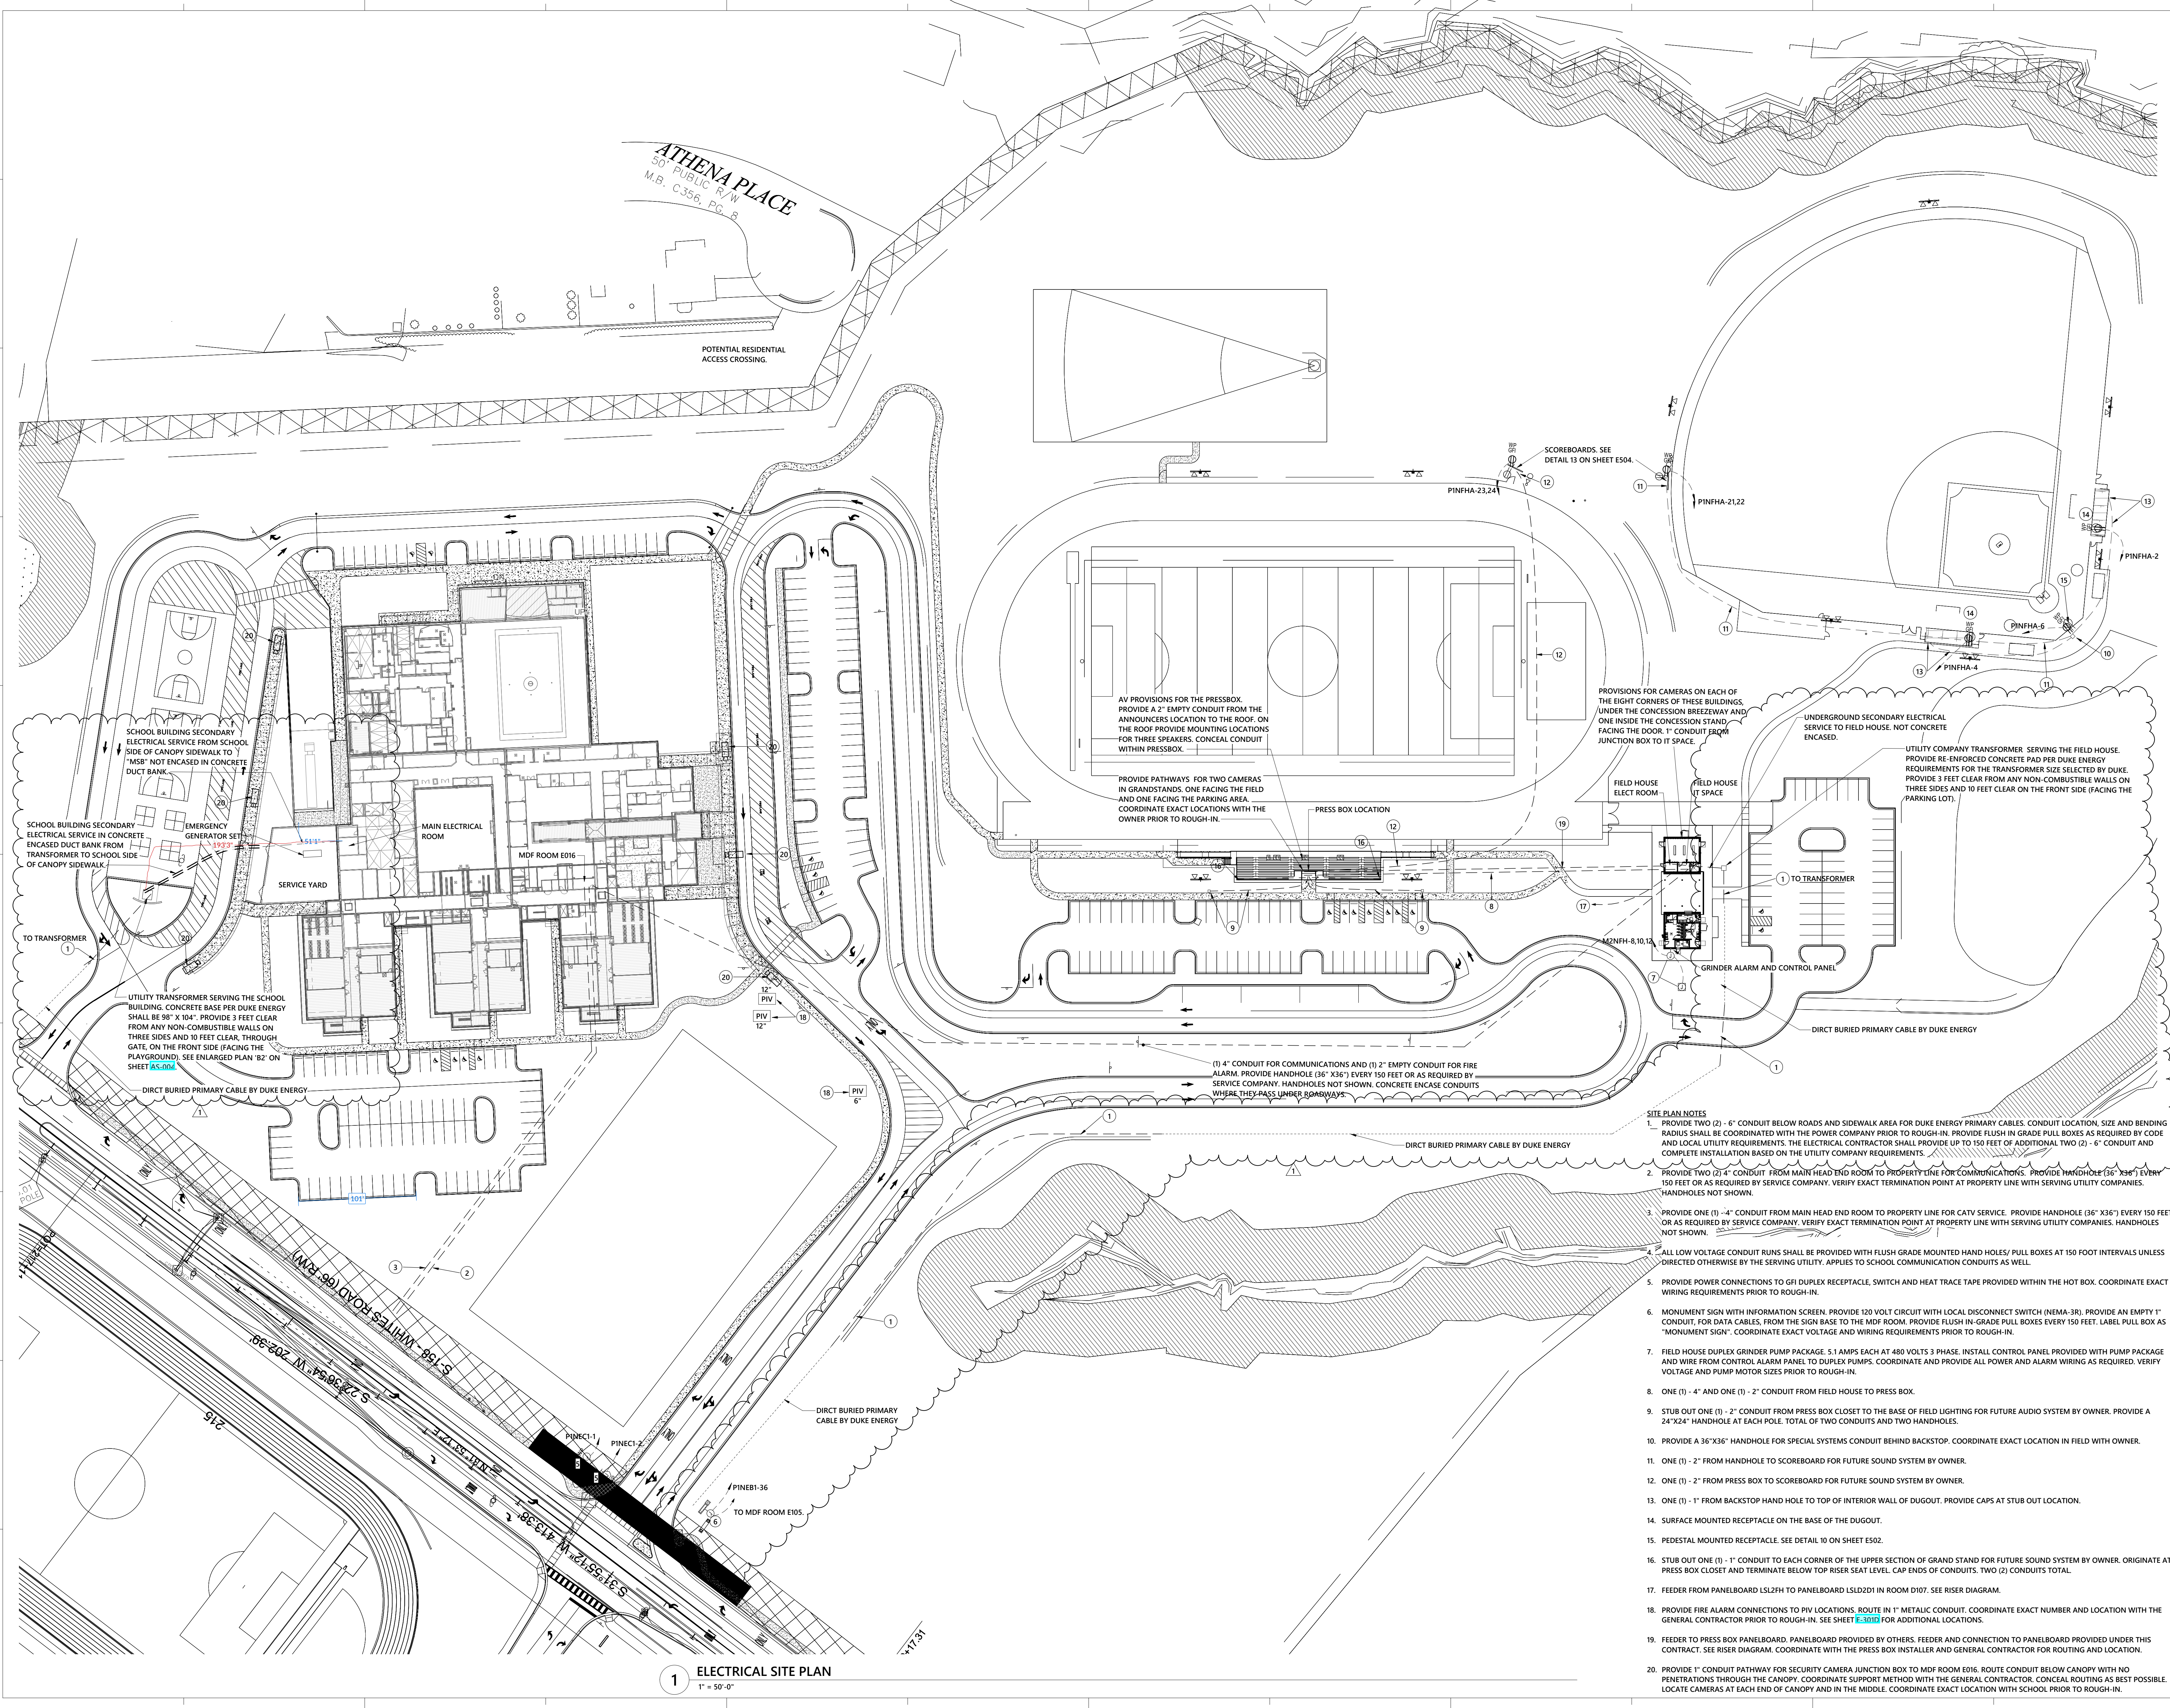

1 ELECTRICAL SITE PLAN
1" = 50'-0"

B:\180\FT Mill Middle School #6\MEP - FT Mill MS #6_2019.rvt
12/20/2019 2:25:42 PM