


This drawing is the property of Matrix Engineering, Inc., and is not to be reproduced or copied in whole or in part. It is only to be used for the project and site specifically identified herein and is not to be used on any other project. It is to be returned upon request.

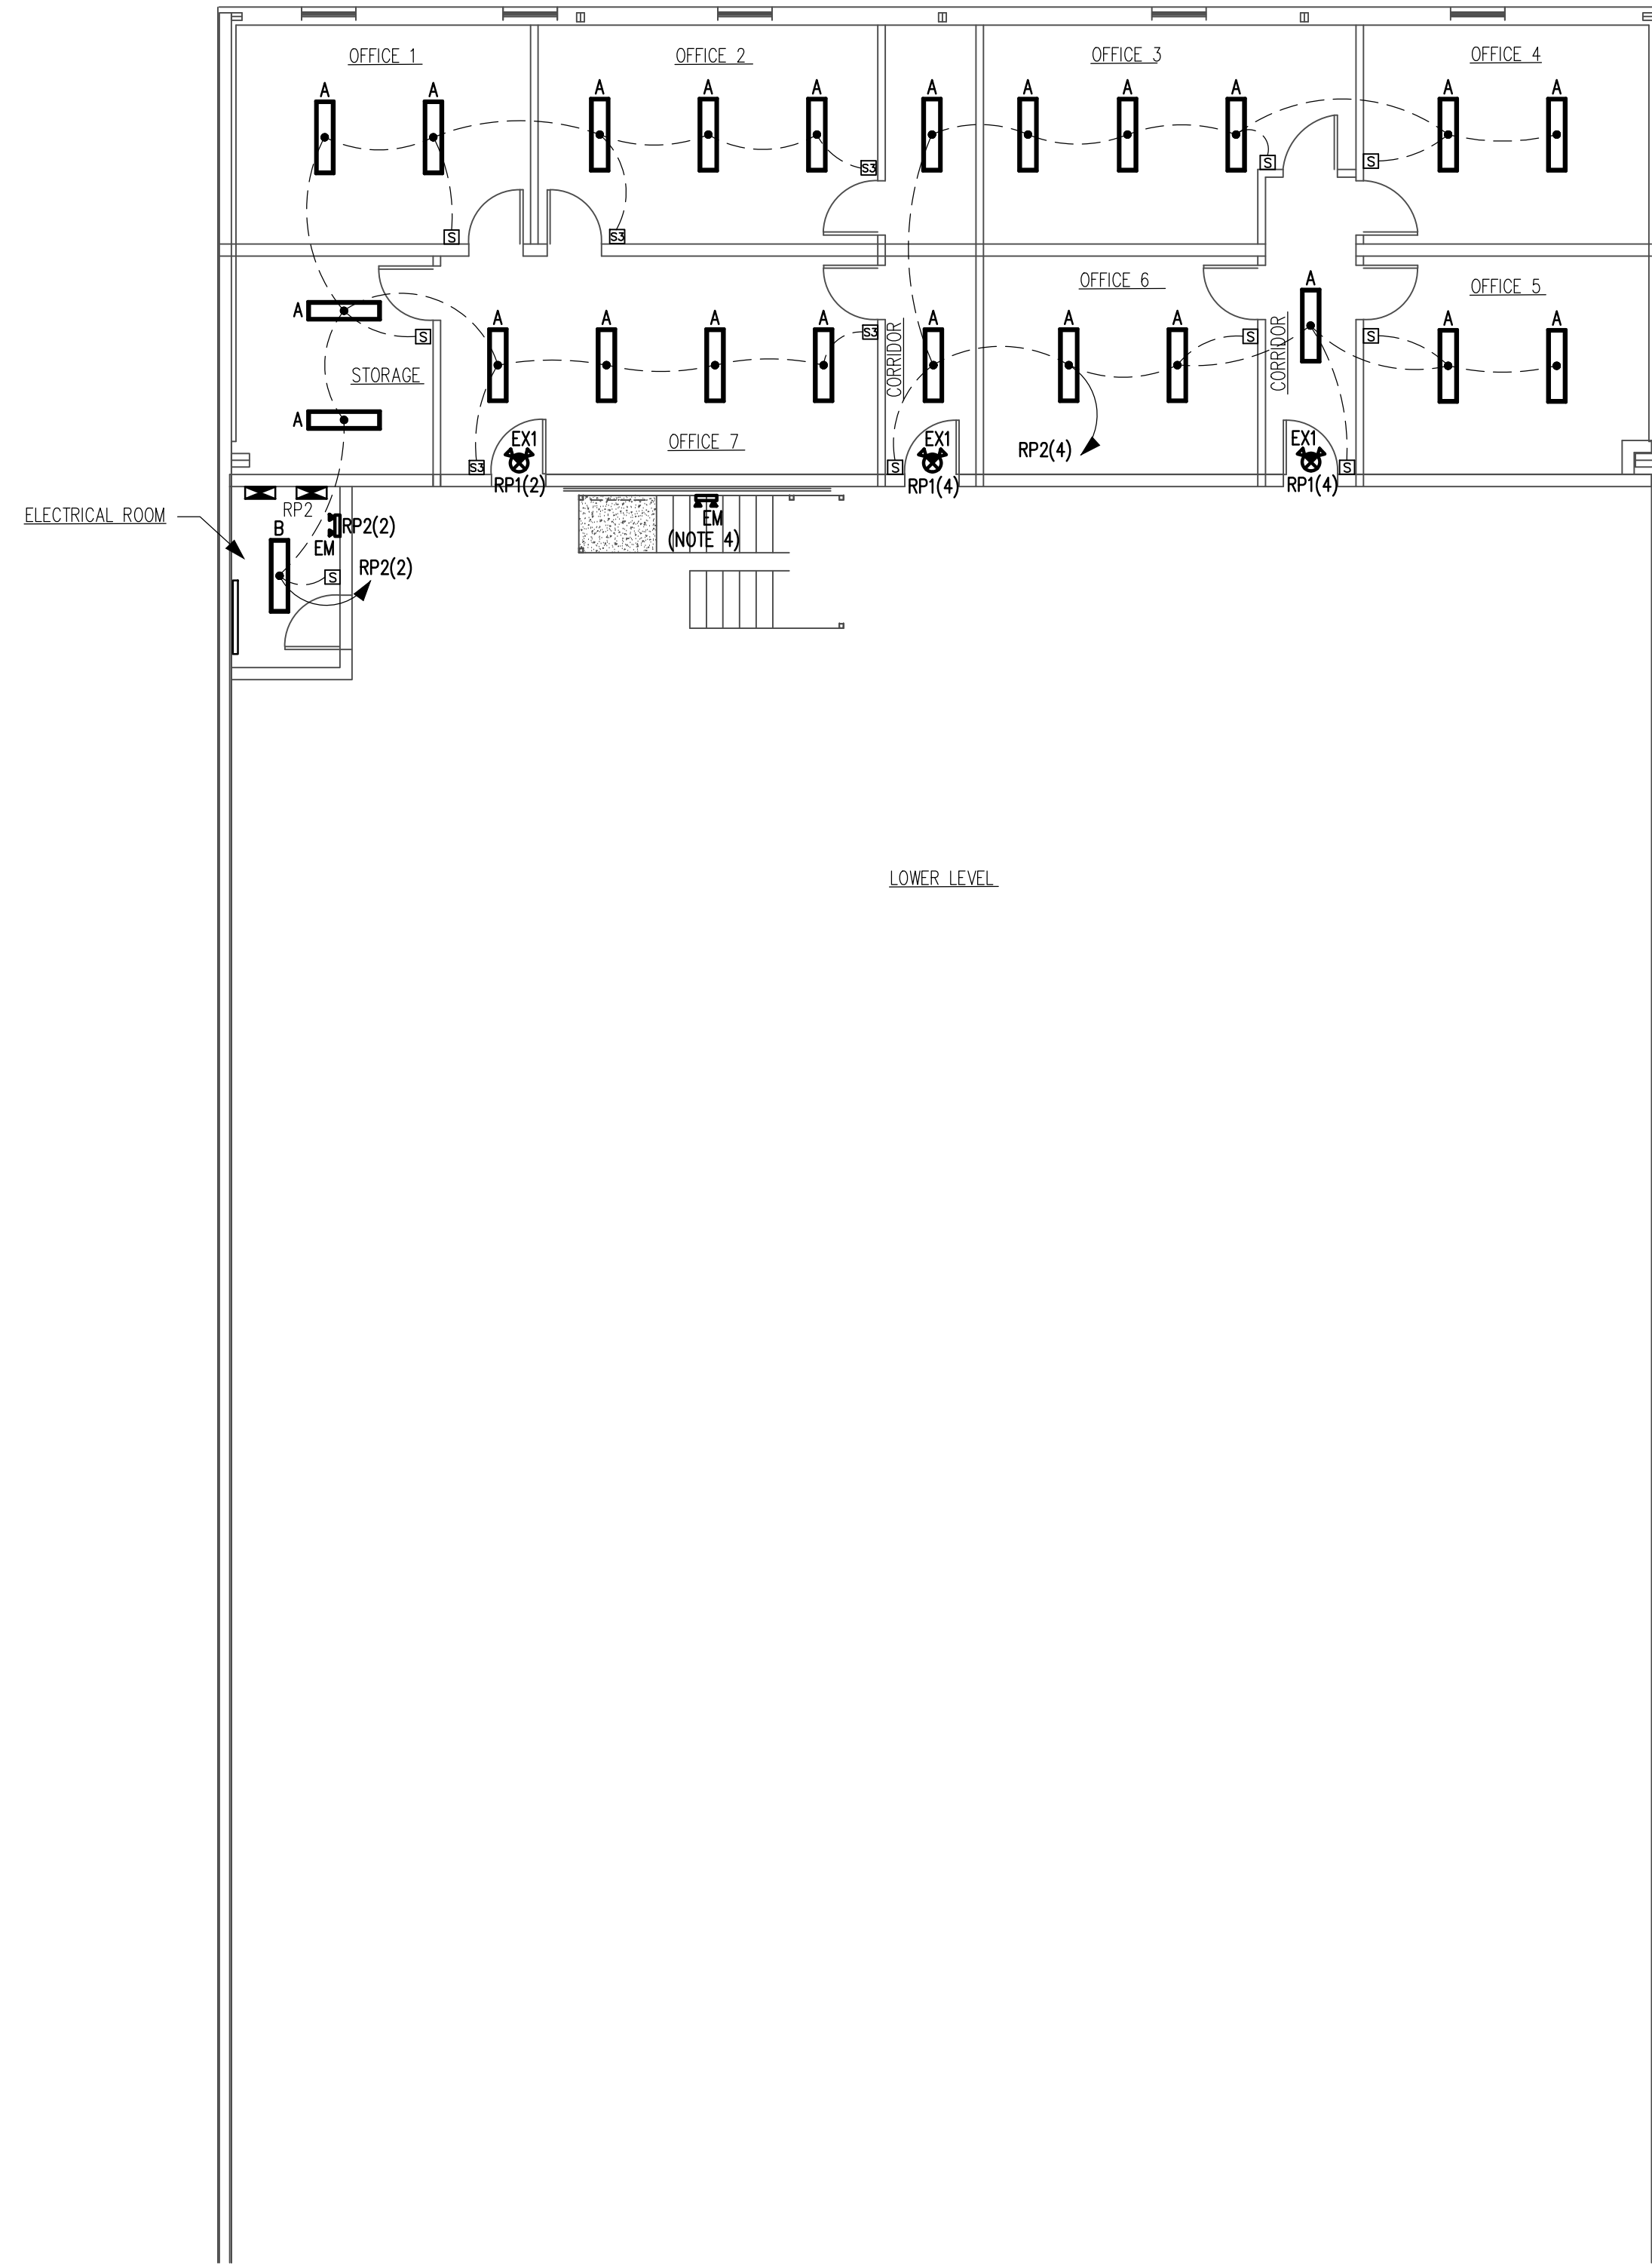


LOWER LEVEL LIGHTING PLAN
SCALE: 1/8" = 1'-0"

GENERAL LIGHTING NOTES:

1. ELECTRICAL CONTRACTOR TO COORDINATE ELECTRICAL WORK WITH ALL OTHER DISCIPLINES AND DAVID COOK WITH THE CITY OF SPARTANBURG.
2. ALL LIGHT FIXTURE SHALL MEET THE SEISMIC REQUIREMENTS OF ASCE 7.
3. ALL EMERGENCY EGRESS LIGHT FIXTURES SHALL BE WIRED UN-SWITCHED TO THE AREA LIGHTING CIRCUIT IN THE ROOM WHERE THE FIXTURES ARE MOUNTED.
4. WIRE EMERGENCY DUAL HEAD ILLUMINATING STAIRS TO EXISTING WAREHOUSE LIGHTING CIRCUIT.
5. LIGHT FIXTURES IN WAREHOUSE AREA TO REMAIN.

LIGHTING FIXTURE SCHEDULE								
TYPE	DESCRIPTION	LAMP	MANUFACTURER PART #	KELVIN	VOLTAGE	WATTAGE	MOUNTING	COMMENTS
A	4 FOOT FLUORESCENT WRAP-AROUND	(3) 32W T8	SELECTED BY OWNER/CONTRACTOR	4000	120	96	SURFACE MOUNTED ON CEILING	
B	4 FOOT FLUORESCENT INDUSTRIAL STRIP FIXTURE WITH WIREGUARD	(2) 32W T8	SELECTED BY OWNER/CONTRACTOR	4000	120	64	CHAIN HUNG	
EM	DUAL HEAD EMERGENCY LIGHT WITH BATTERY BACKUP	LED	SELECTED BY OWNER/CONTRACTOR		120	3	SURFACE MOUNTED ON WALL	
EX1	THERMOPLASTIC LED EXIT SIGN WITH HEADS AND BATTERY BACKUP	LED	SELECTED BY OWNER/CONTRACTOR		120	3	SURFACE MOUNTED	

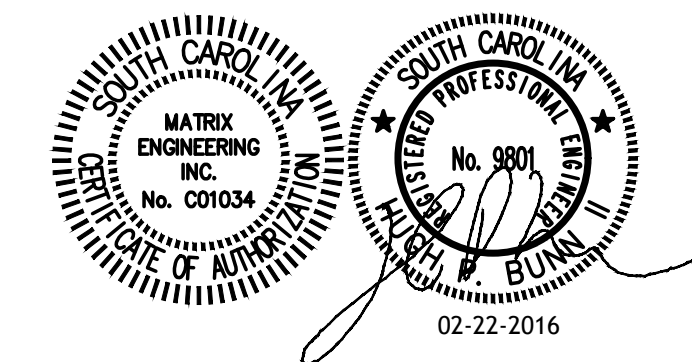

<p>TRANSFER STATION RENOVATION SPARTANBURG, S.C. FOR CITY OF SPARTANBURG</p>		<p>CLIENT NAME LOCATION & DESCRIPTION</p>
<p>MATRIX ENGINEERING, INC. 912 SOUTH PINE STREET SPARTANBURG, SOUTH CAROLINA (864)585-8274 www.matrixei.com</p>	<p>29502 FAX (864)583-2795</p>	<p>LOWER LEVEL LIGHTING PLAN</p>
<p>SCALE: AS NOTED DATE: 08-10-15</p>	<p>DWG NO: E-3.0</p>	<p>ISSUED FOR PERMITTING AND CONSTRUCTION DATE: 02/22/16 DESCRIPTION: DWN</p>
<p>FILE NAME: E-3.0 PROJECT NO: 2015-088</p>	<p>REV: 0</p>	<p>MRM SLS CKD HFB APP</p>