


Existing fire sprinkler system to put back in service and modification be made by a fire sprinkler engineer to provide fire sprinkler service to lower level and take into consideration Phase 2 Offices above.

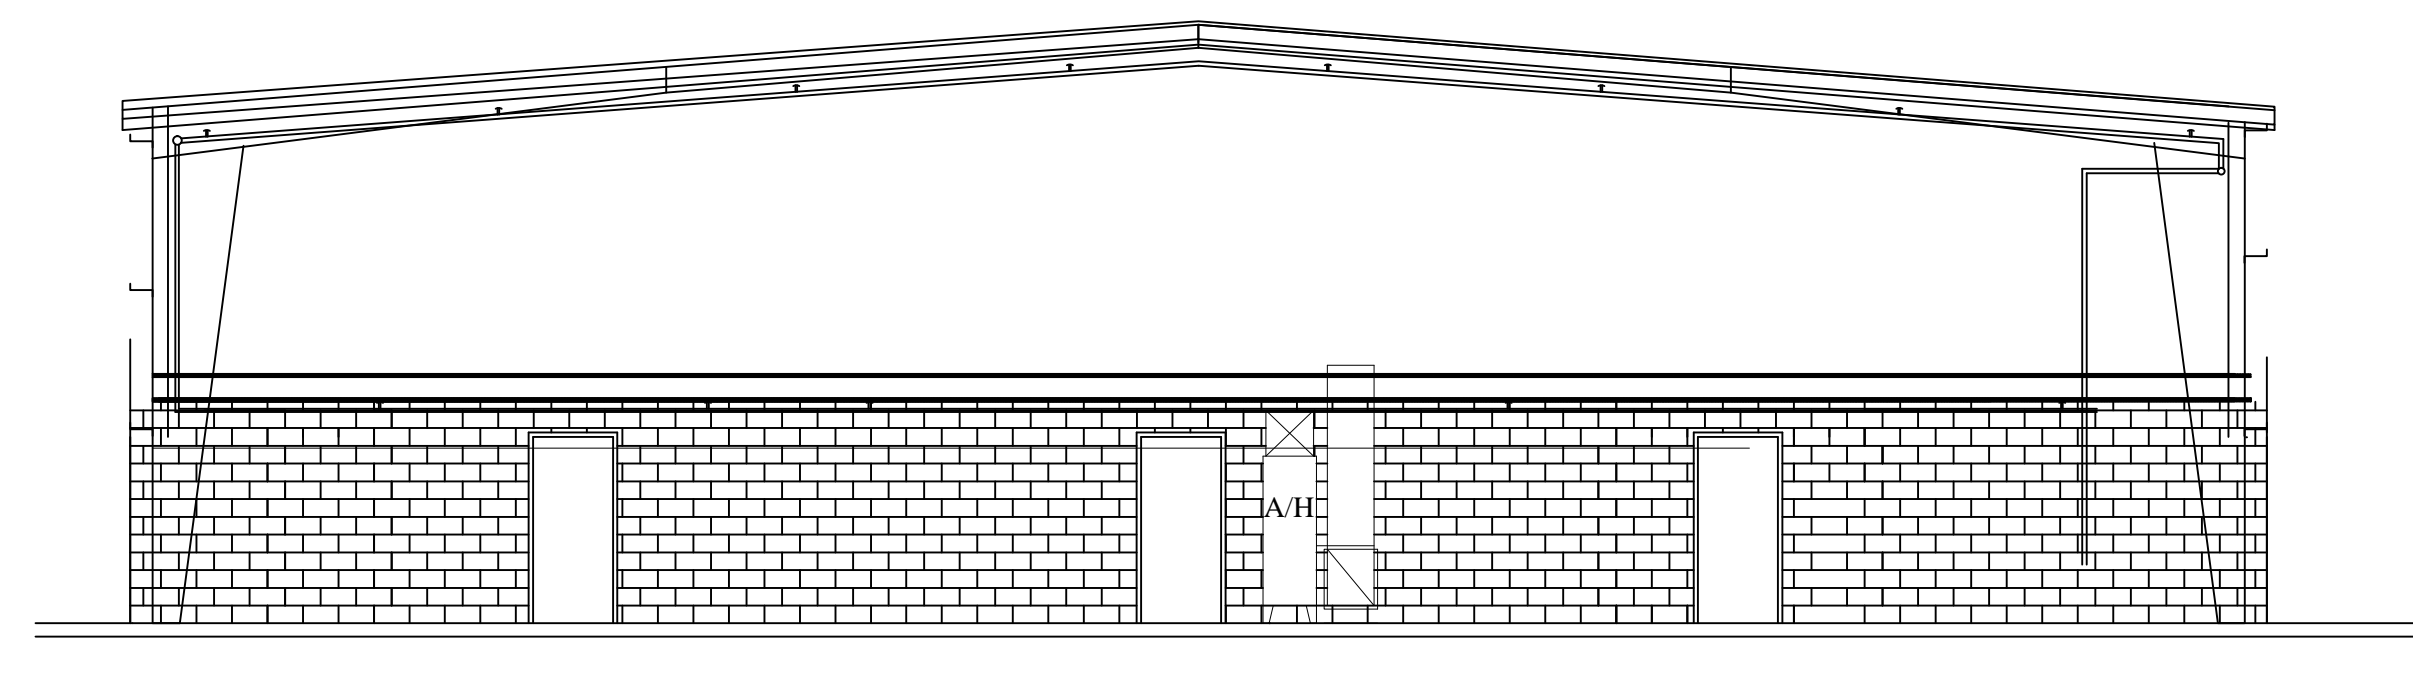

Looking from South to North Inside the Building

Drawing is for reference only. Contractor is responsible for evaluating, dimension of pipe and condition of existing system.

NOT TO SCALE

CITY OF SPARTANBURG

HENRY STREET OFFICES

REVISION

DRAWING DATE:

10/5/2015

DRAWING BY:

DAC

DRAWING:

FIRE SPRINKLER PLAN VIEW

DRAWING NO.
COS 4.0