

ADDENDUM NO. 3

**Chattanooga Downtown Library
ADA Bathrooms
City Contract No. L-20-002
Chattanooga, Tennessee**

Date: 5 August 2020

The following amendments to the specifications and/or revisions to the drawings shall be a part of the contract documents. Bidders therefore shall consider them when preparing cost estimates, and the contractors shall be bound by them.

GENERAL

Site Visit

A third site visit is scheduled for Friday, August 7, 2020 beginning at 10:30 AM. Contractors and sub-contractors will be escorted individually to the various parts of the building by the architect and library staff employees.

Sign-up Sheet

Attached is the sign-up sheet from the second site visit on August 4, 2020.

SPECIFICATIONS

Section 100100 Advertisement for Bids

Change to add: Final questions will be received no later than Monday, August 10, 2020 at 12:00 PM

DRAWINGS

Sheet P 2.0 Water Piping Plan

Re-issued as part of this addendum.

2nd Bid / Site Visit

PRE-CON MEETING SIGN-IN SHEET

Project: Downtown Library ADA Restrooms


Meeting Date: 2020/8/4 **10:30 A**

Facilitator: COC

Place/Room: ~~DRC Room 2D~~
Library

Project: Downtown Library ADA Restrooms


Name/Company	Title	E-Mail/Phone
BILL WILKERSON ^{DHW}	PARTNER	bill@dhw-architects.com
J Sullivan Library	CAO	Jsullivan@ gmail.com ^{Chattanooga.gov}
Victor Smith/Helton		victor@heltoncc.com
Jon CLINARD / INTEGRATED PROPERTIES	VP	JCLINARD@INTEGRATEDBUILDS.COM
JARED ERWIN / TRICON	PM	JARED@TRICONUS.COM
JASON BLACK / PBC	ESTIMATOR	JASONE@PC-CONST.COM
ANN STAHL	PM	astahl@pc-const.com
LANEE PRYOR / JCI	Sales	jeffrey.pryorejci.com
MARK A. FLEMING ^{Johnson Controls Fire} / JCI	Sales	mark.fleming@jci.com
Dane Bradford ^{Dill} / Contracting	Est.	dbradford@dillcontractingusa.com
Corinne Hill / Library	Director	chill@lib.chattanooga.gov
James Payne / COC	PM	jpayne@chattanooga.gov / 423-643-6515

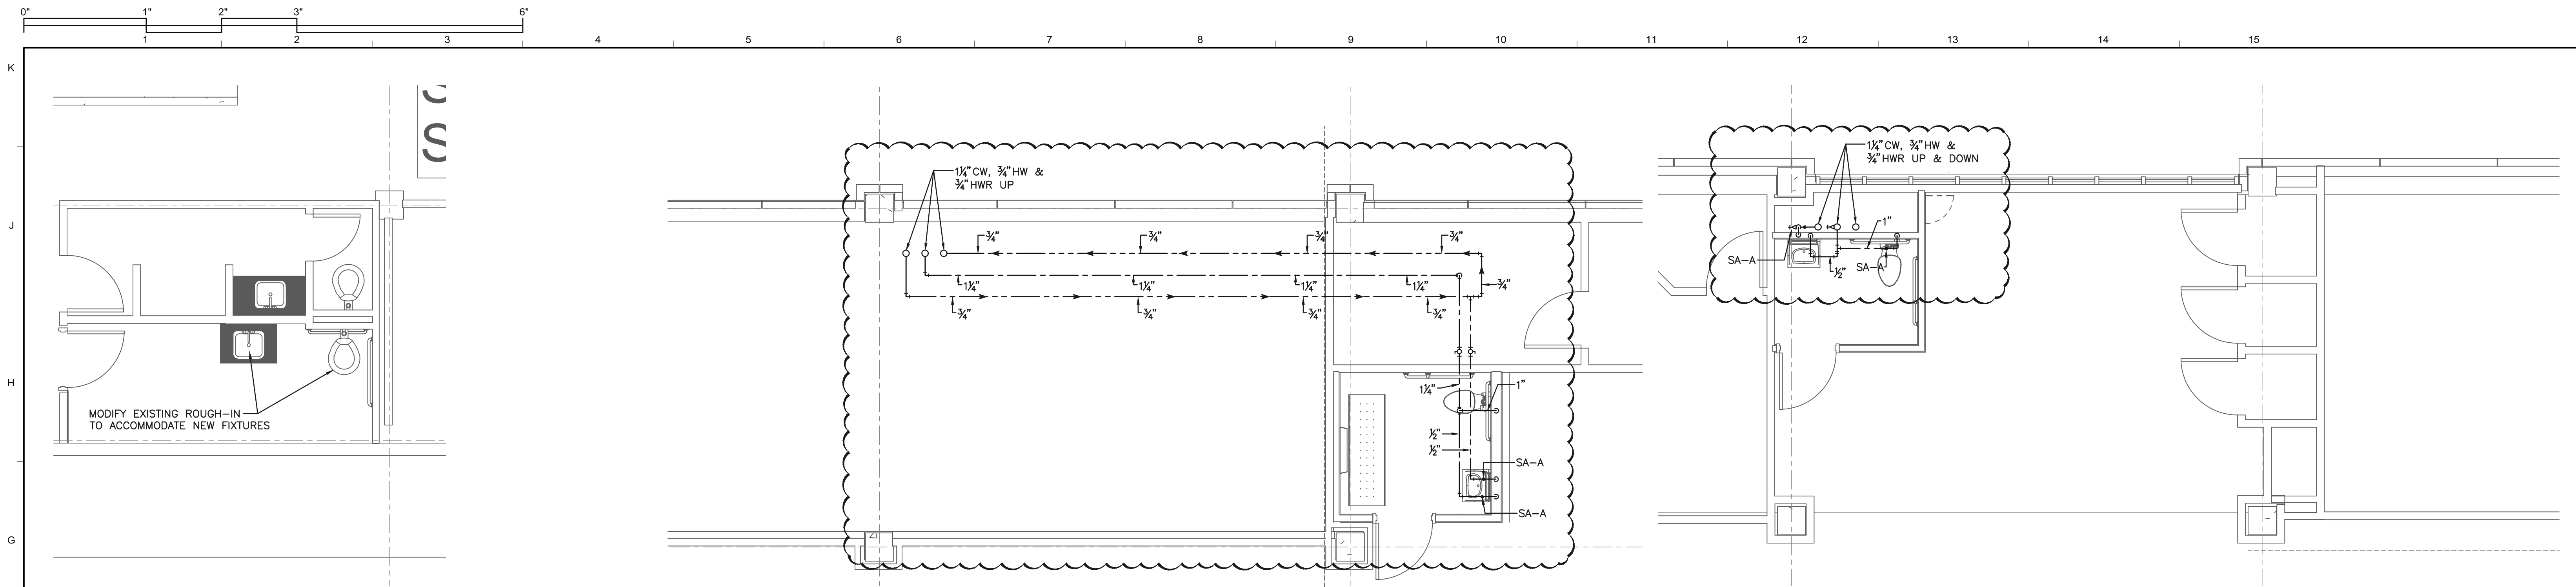


1 BASEMENT LEVEL - WATER PIPING
SCALE: 1/4" = 1'-0"

2 FIRST LEVEL - WATER PIPING
SCALE: 1/4" = 1'-0"

3 SECOND LEVEL - WATER PIPING
SCALE: 1/4" = 1'-0"

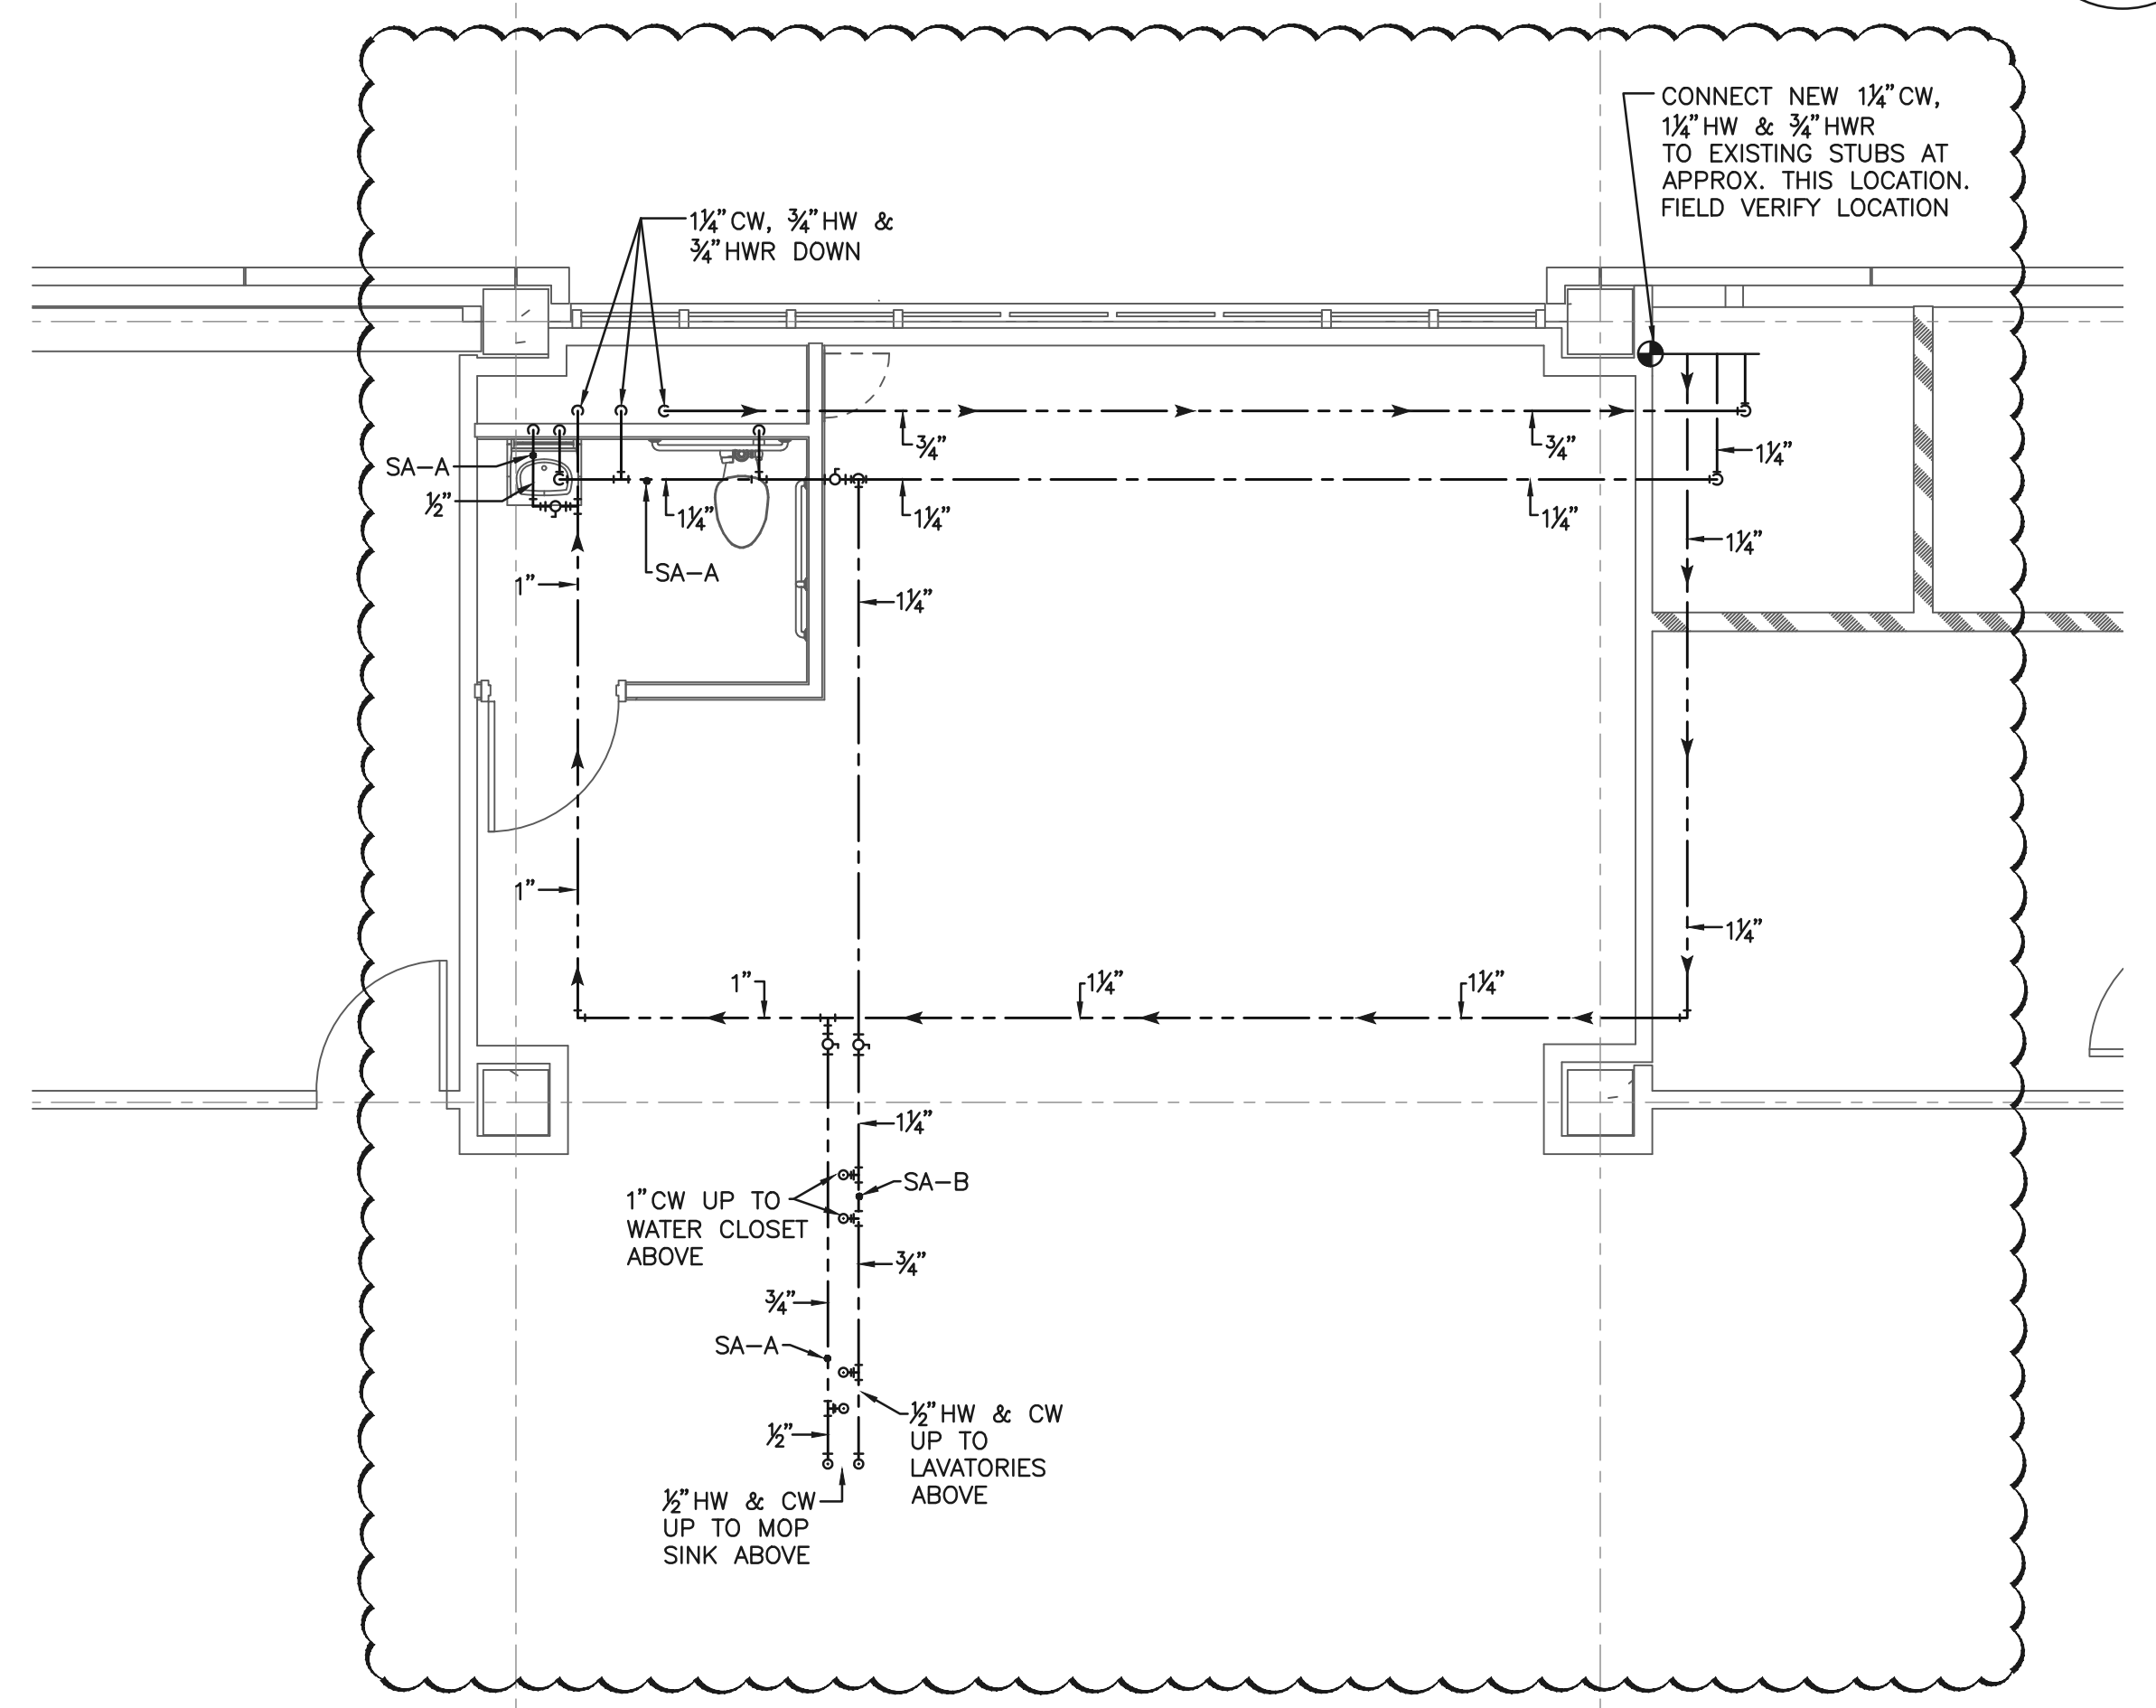

4 THIRD LEVEL - WATER PIPING
SCALE: 1/4" = 1'-0"

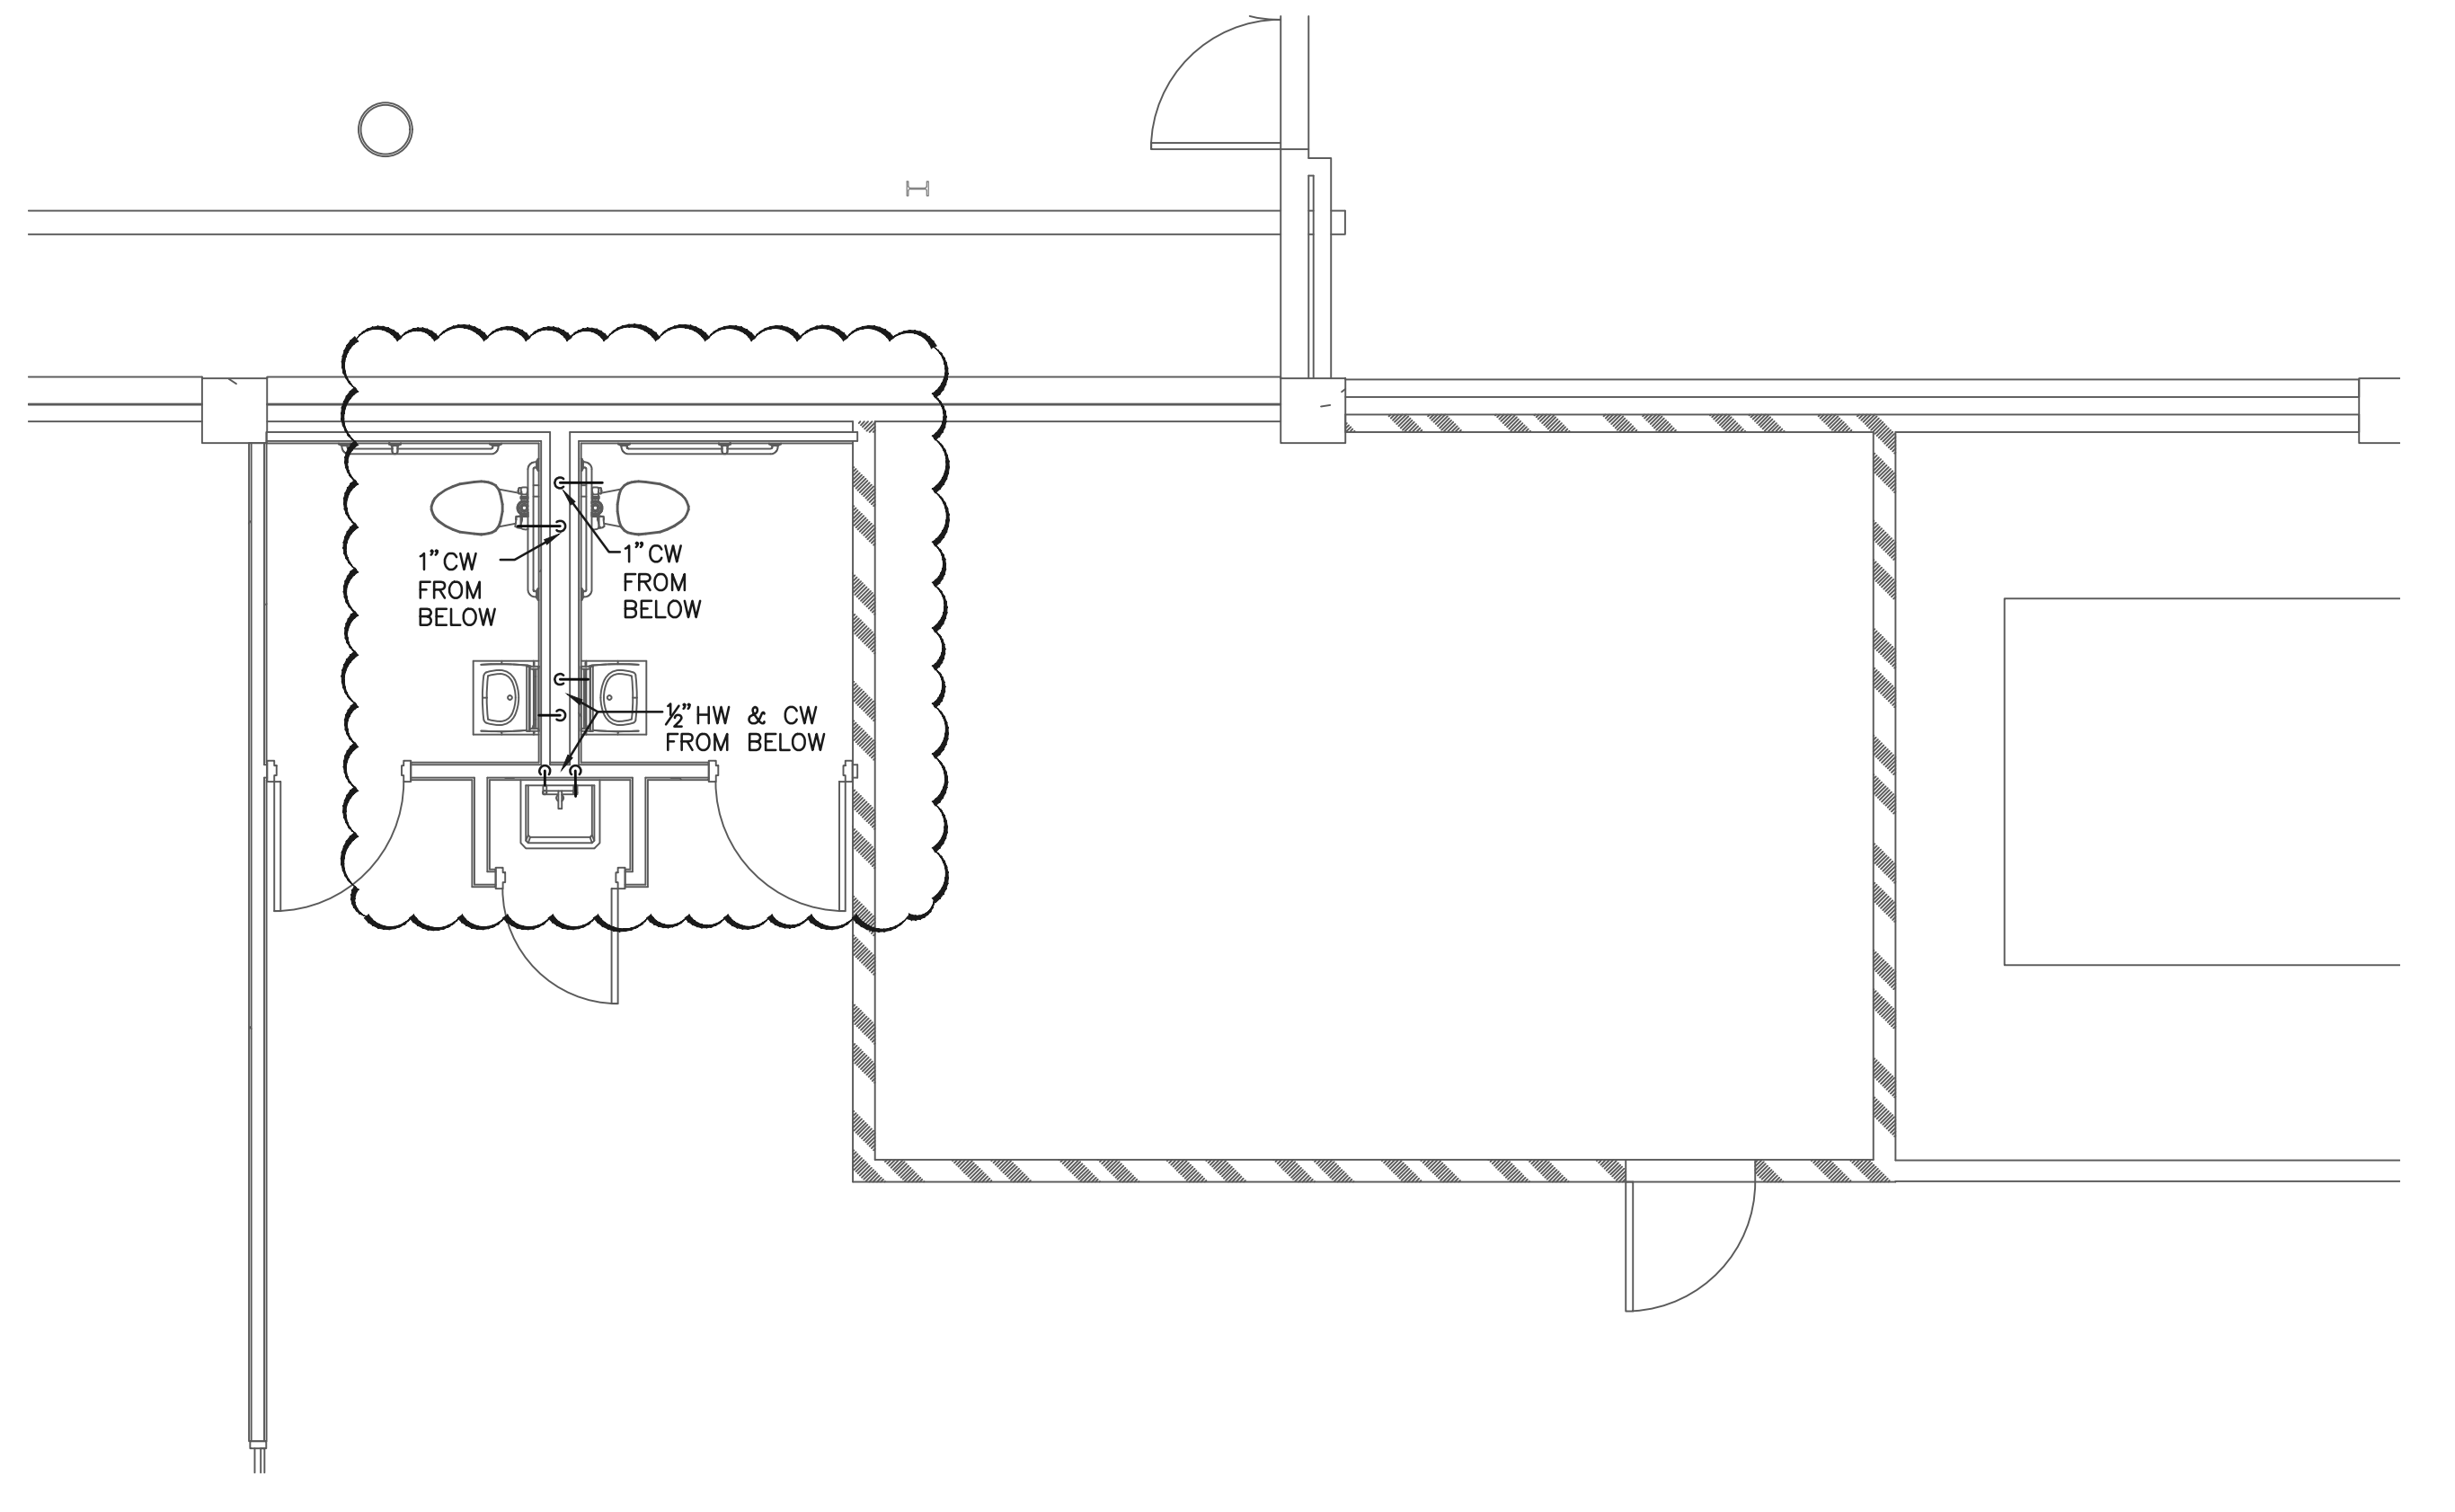

5 FOURTH LEVEL - WATER PIPING
SCALE: 1/4" = 1'-0"

C&A No. 20-050
CAMPBELL & ASSOCIATES, INC.
CONSULTING ENGINEERS
1401 Carter St. Chattanooga, TN 37402
(423) 267-9718 Fax: (423) 265-7879
E-mail: caengr@caengrs.com
www.caengrs.com



Derthick Henley & Wilkerson Architects
1001 Carter Street
Chattanooga, TN 37404
(423) 266-4816



**Chattanooga Downtown
Public Library
ADA Bathrooms**
June 12, 2020

Revisions:
1 Addendum #3 August 3, 2020



Title:
Water Piping Plans

Sheet No.
P2.0