




PUBLIC WORKS DEPARTMENT
TECHNICAL SERVICES

950 BELLEVUE AVENUE
DAYTONA BEACH, FL 32114

P 386 671 8610
F 386 957 6404

BRENT COHEN, ARCHITECT
FL LICENSE # AR93854

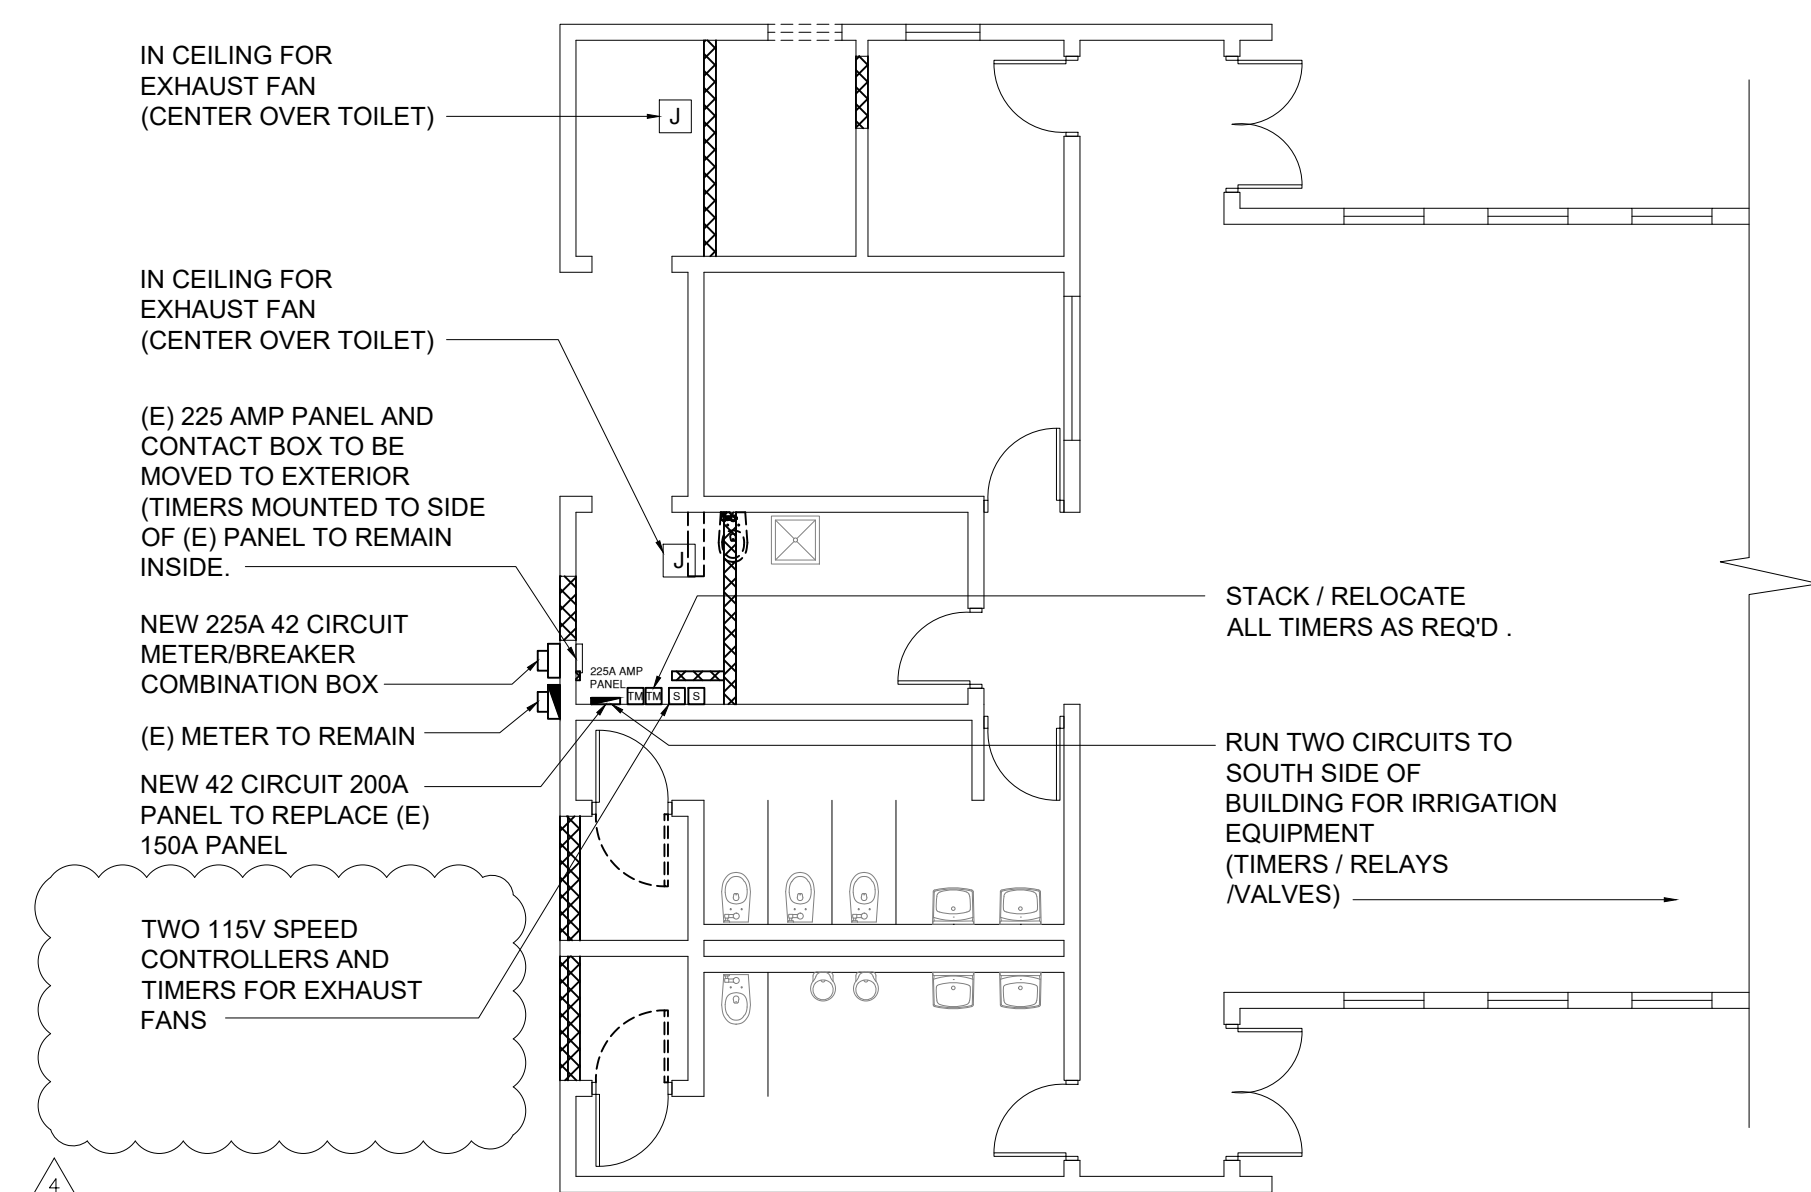


POWER PLAN
SCALE: 1/8" = 1'-0"

NOTE:

ALL CONDUIT AND SWITCHES TO BE IN SURFACE MOUNTED.
ALL NEW WIRING TO BE RUN IN EMT


ALL PANEL HARDWARE TO BE SQUARE D (QO BREAKER BOXES)

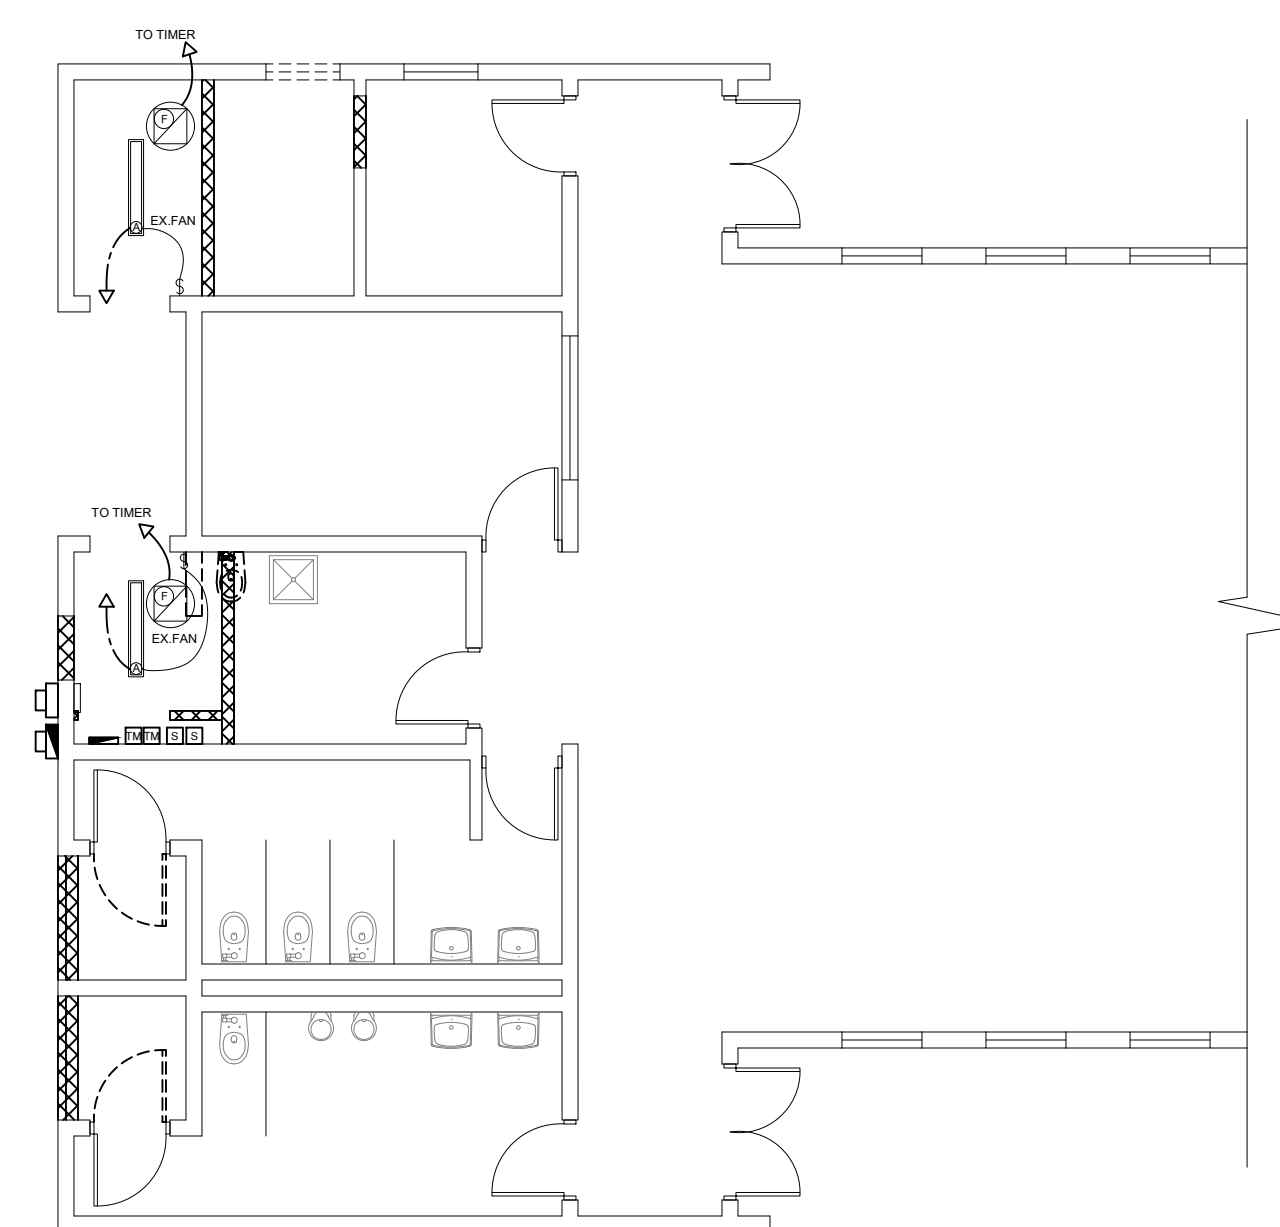

LIGHTING PLAN
SCALE: 1/8" = 1'-0"

ISSUE	DATE
BID SET	4.24.19
ADDENDUM 2	5.16.19
ADDENDUM 4	5.23.19

Fixture Schedule					
MARK	MFR.	MFR'S #	PRODUCT / DESCRIPTION	LAMP	REMARKS
(C)					
(A)	LITHONIA	ZL1N L48 3000LM SBL MVOLT 35K 80CRI WH	48" LED STRIP LIGHT /W BATTERY BACKUP	3000 LUMEN LED	WHITE COLOR / BLADE LOUVER
(F)	SOLER & PALAU	SDBD06JH1AS	DIRECT DRIVE ROOF EXHAUST FAN	N/A	INCLUDE 115V SPEED CONTROL AND MOUNTING CURB PER MANUF. INSTALL INSTRUCTIONS (SPEED CONTROLS FOR BOTH FANS TO BE LOCATED IN ELECTRICAL CLOSET)

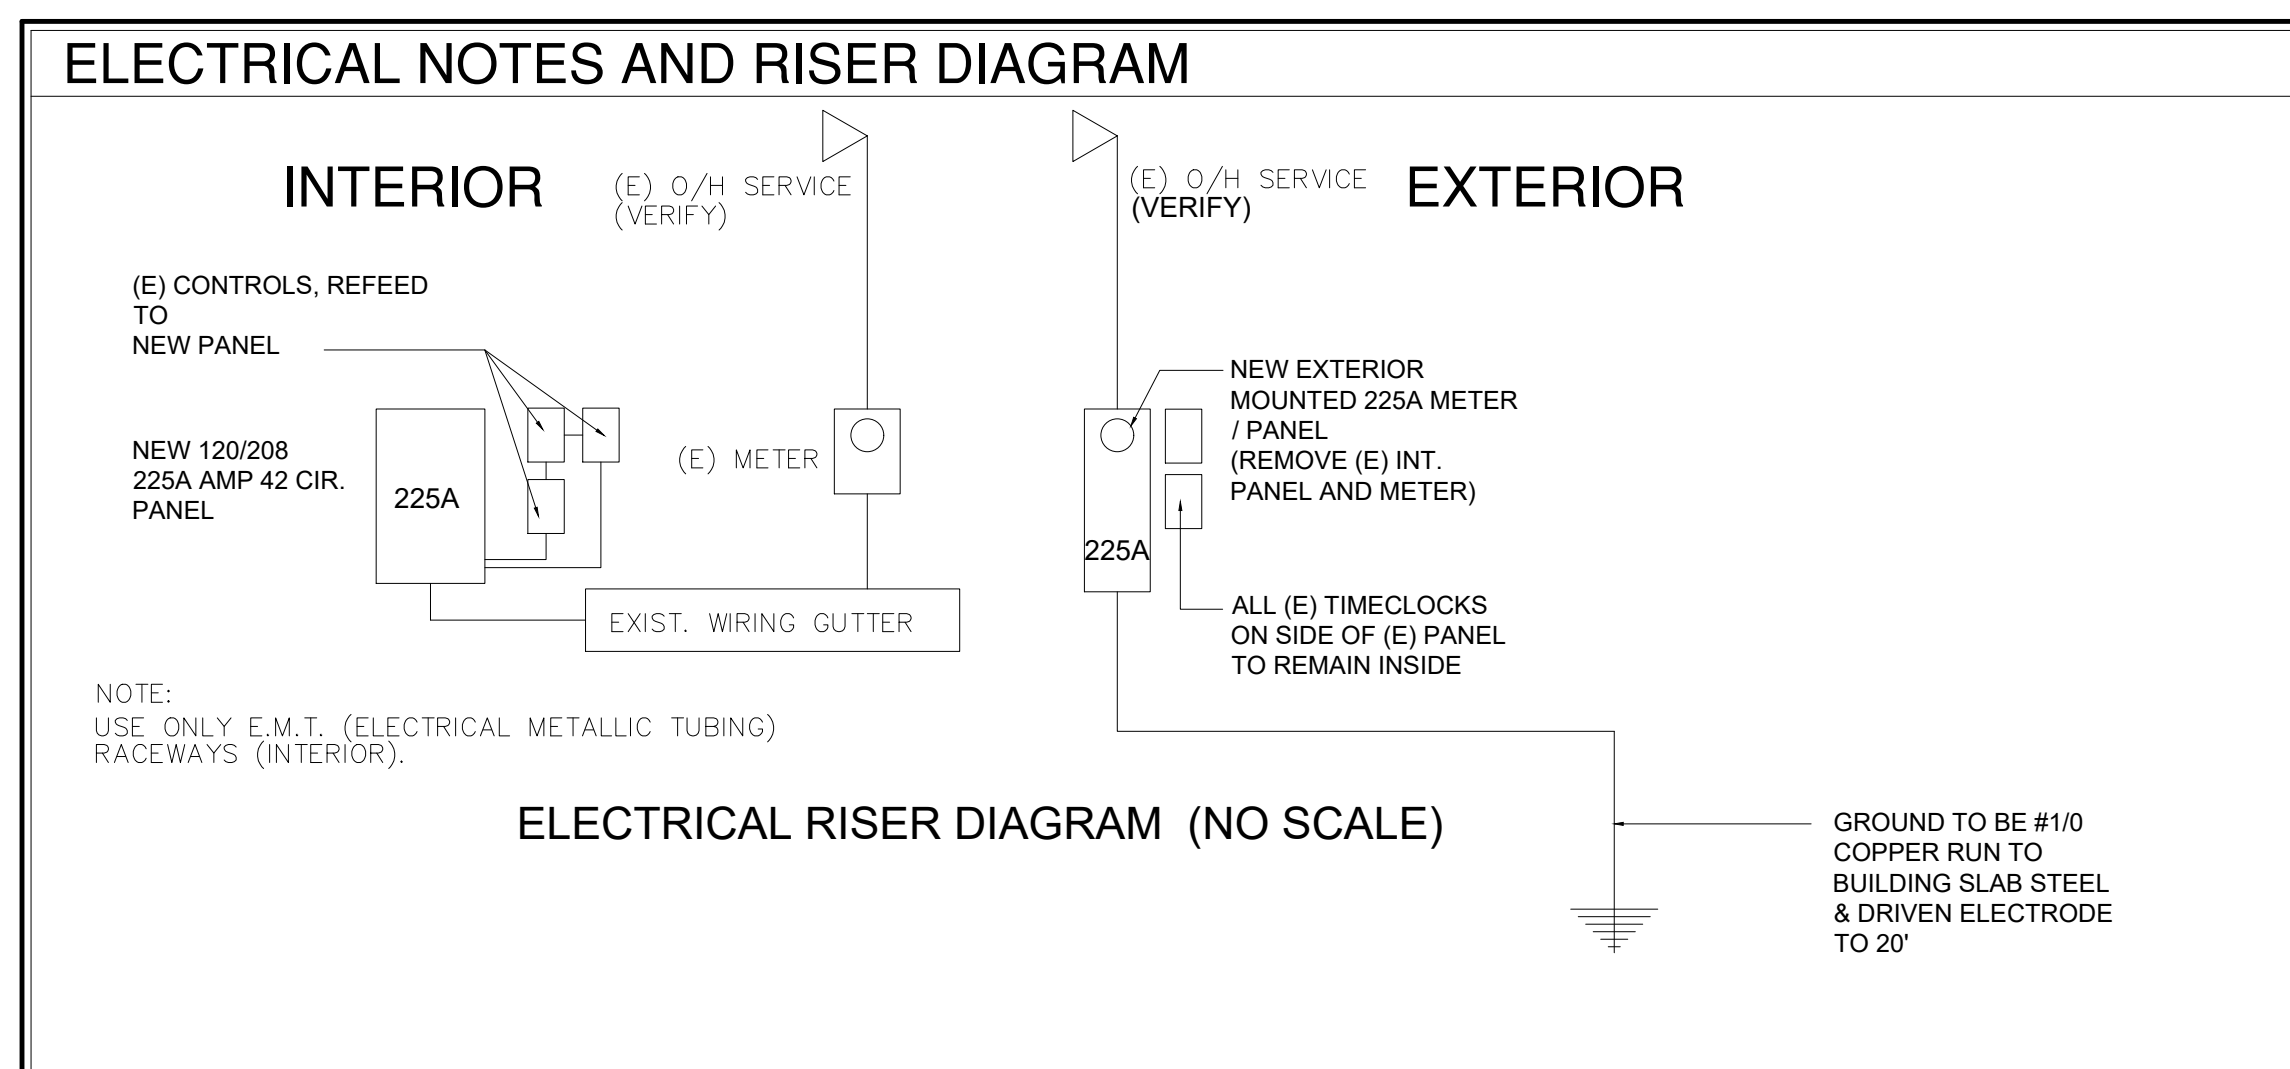

BUILDING REMODEL, SITE IMPROVEMENTS AND PAVILIONS FOR SUNNYLAND PARK

825 WASHINGTON ST.
DAYTONA BEACH, FL 32114

SCALE: AS NOTED
DRAWN: BCC
CHECKED: BCC
PROJECT NO: 2019-010

EP1.1