
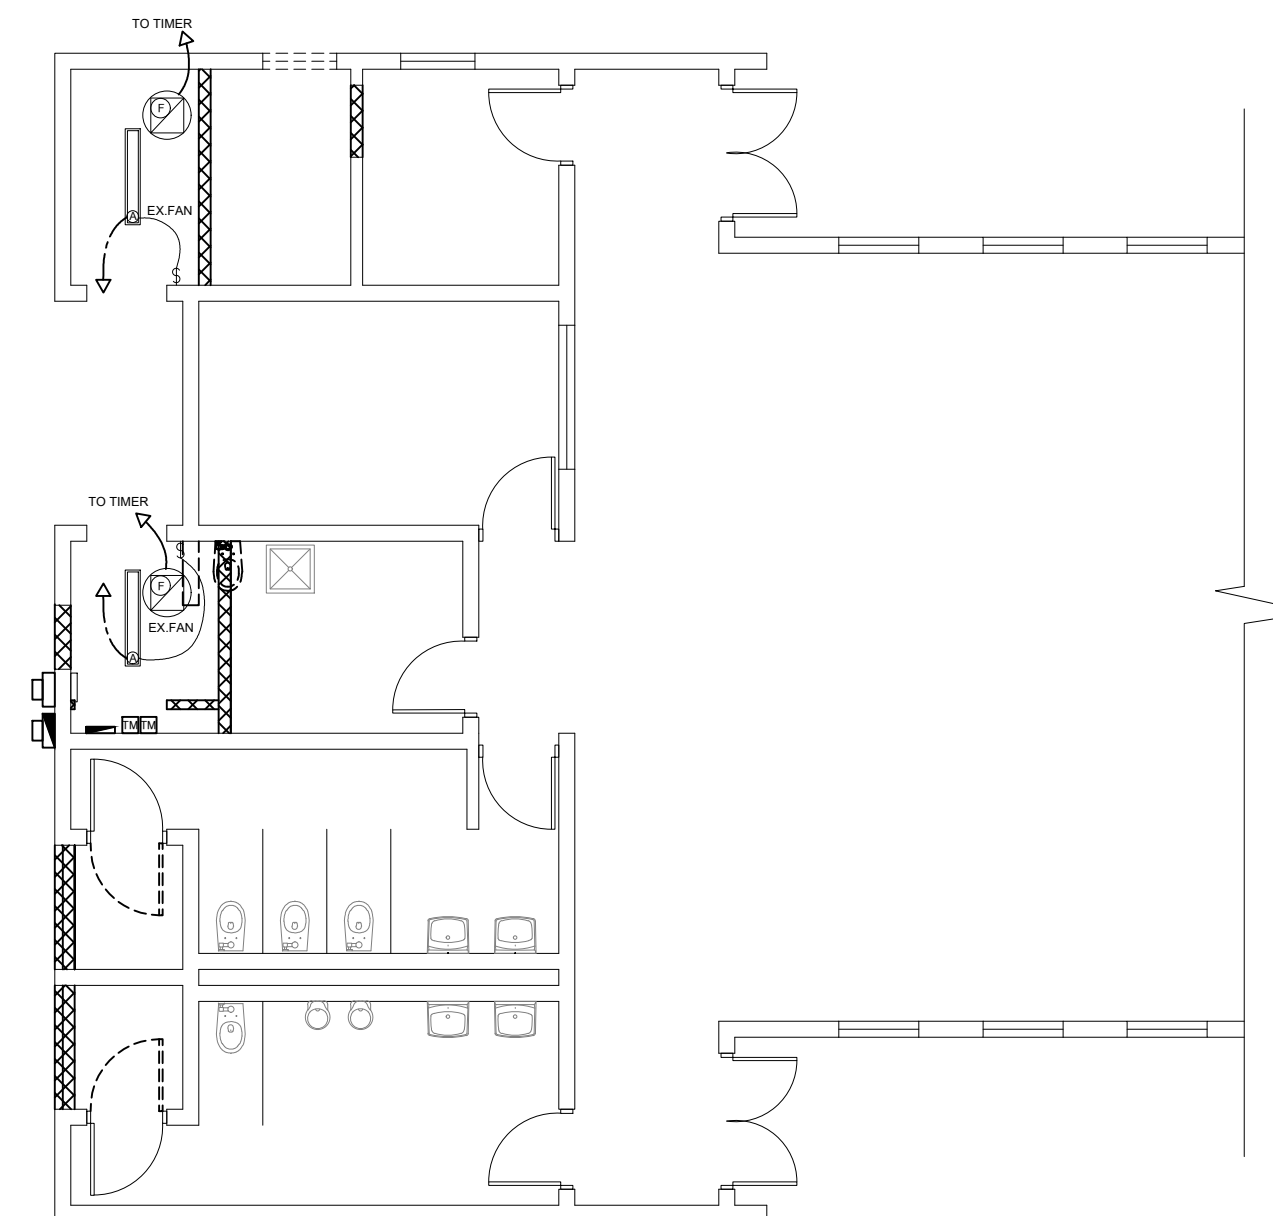


ISSUE	DATE
BID SET	4.24.19
ADDENDUM 2	5.16.19

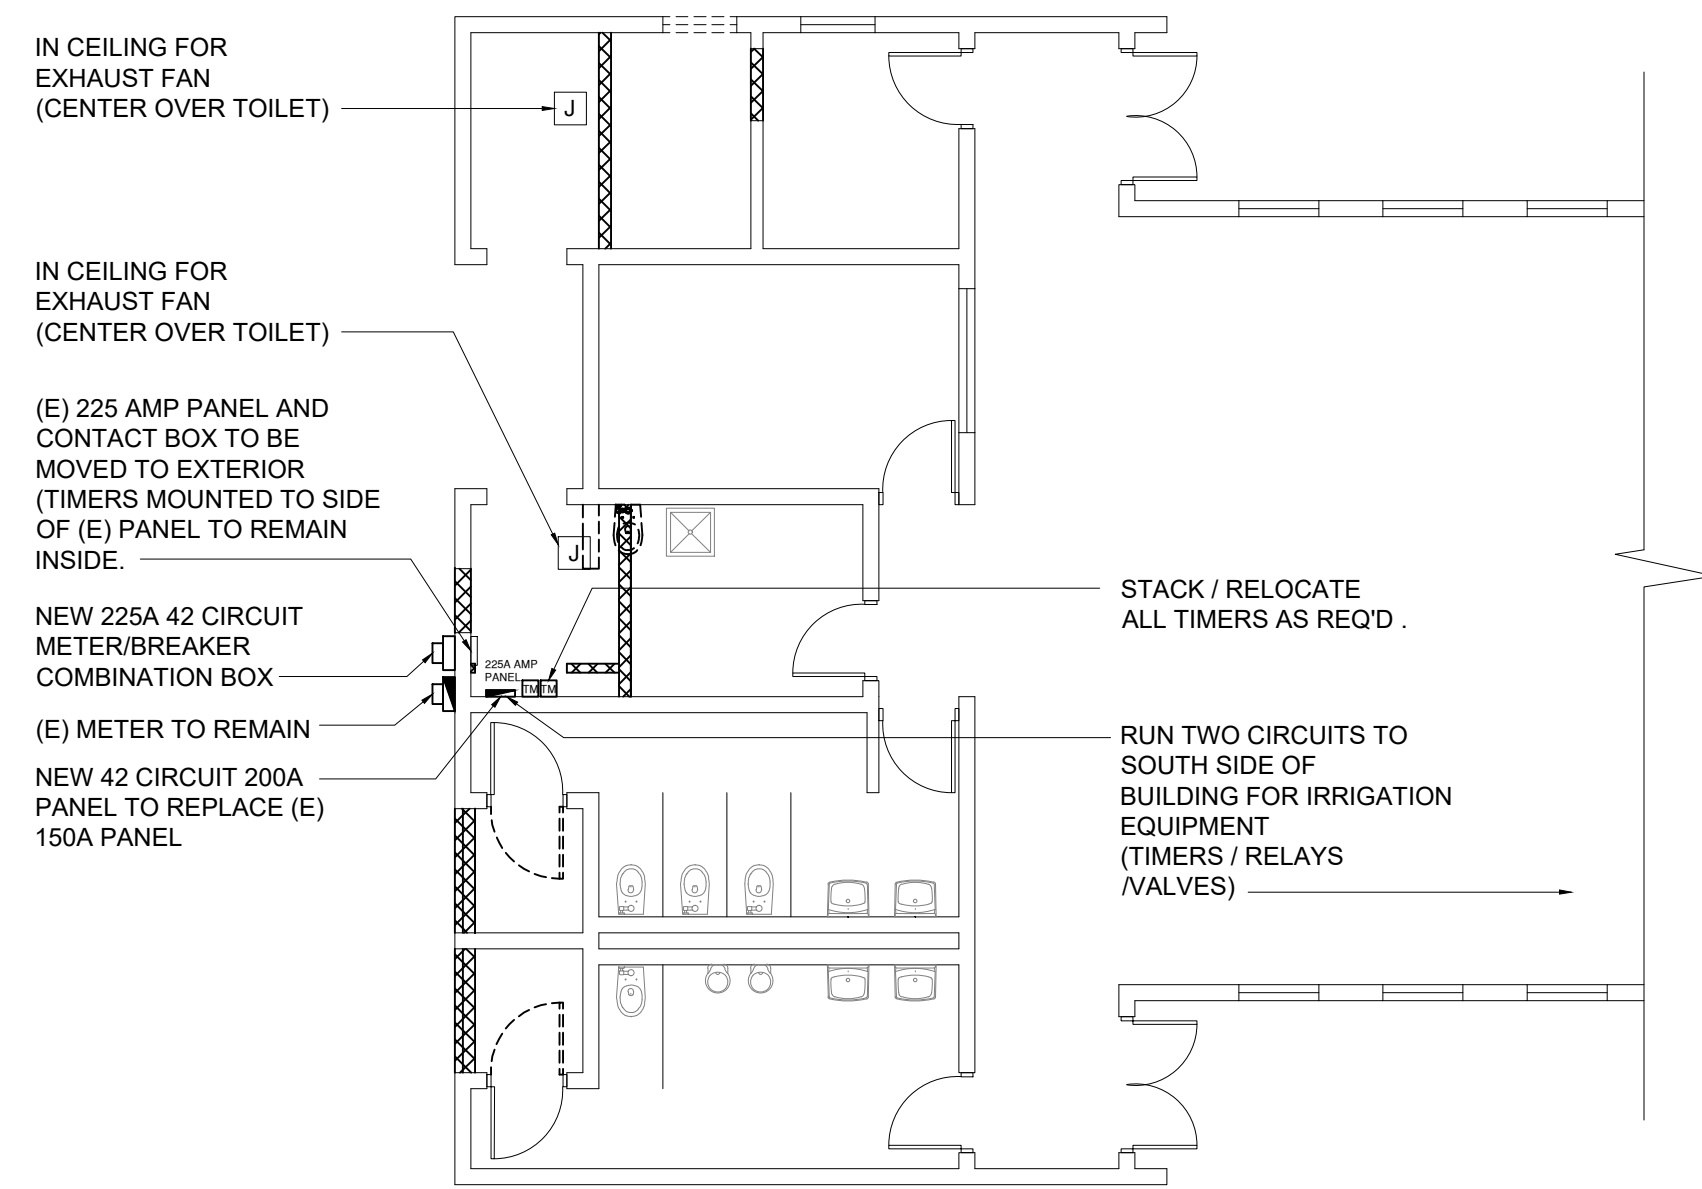

POWER PLAN
SCALE: 1/8" = 1'-0"

LIGHTING PLAN
SCALE: 1/8" = 1'-0"

NOTE:


ALL CONDUIT AND SWITCHES TO BE IN SURFACE MOUNTED.
ALL NEW WIRING TO BE RUN IN EMT

ALL PANEL HARDWARE TO BE SQUARE D (GO BREAKER BOXES)

Fixture Schedule

MARK	MFR.	MFR'S #	PRODUCT / DESCRIPTION	LAMP	REMARKS
(C)					
(A)	LITHONIA	ZL1N L48 3000LM SBL MVOLT 35K 80CRI WH	48" LED STRIP LIGHT /W BATTERY BACKUP	3000 LUMEN LED	WHITE COLOR / BLADE LOUVER
(F)	SOLER & PALAU	RED15QM1AS	DIRECT DRIVE ROOF EXHAUST FAN	N/A	ON TIMER

ELECTRICAL NOTES AND RISER DIAGRAM

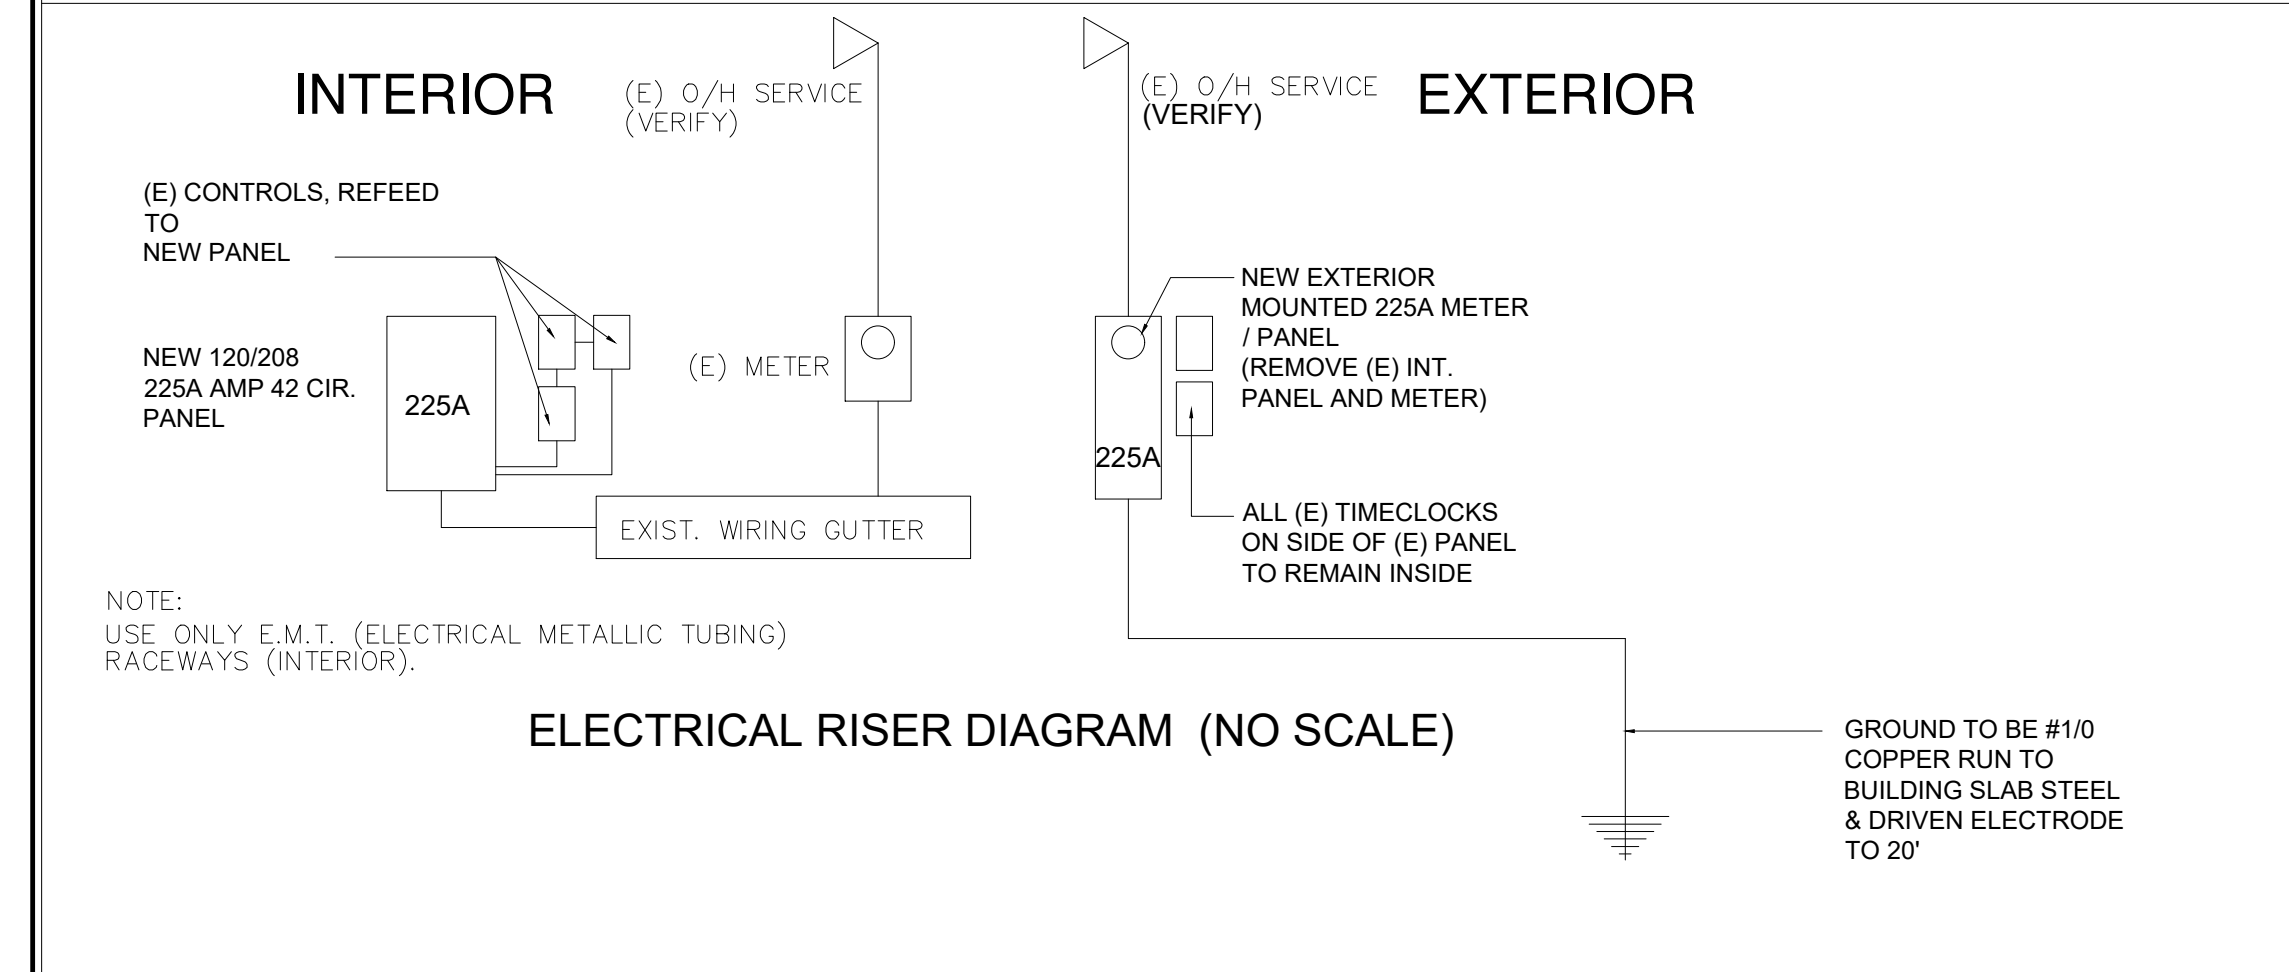

**BUILDING
REMODEL, SITE
IMPROVEMENTS
AND PAVILIONS
FOR
SUNNYLAND
PARK**

825 WASHINGTON ST.
DAYTONA BEACH, FL
32114

SCALE:	AS NOTED
DRAWN:	BCC
CHECKED:	BCC
PROJECT NO:	2019-010