

Baseball / Softball Concession / Toilet Building
MF Fixture Count required per IBC
Bleacher Total - 652 326/326

	Male	Female
WC's	2	8
Urinals	3	-
Lavatories	2	3
Drinking Service	1	-
Sink	1	-

Home Concession / Toilet Building
MF Fixture Count required per IBC
Home Grandstand - 2000 seating 1000/1000

	Male	Female
WC's	6	25
Urinals	9	-
Lavatories	5	7
Drinking Service	2	-
Sink	1	-

Visitor Concession / Toilet Building
MF Fixture Count required per IBC
Visitor Grandstand - 1500 seating 750/750

	Male	Female
WC's	4	15
Urinals	6	-
Lavatories	4	5
Drinking Service	1	-
Sink	1	-


Description	Male	Female	Lav - Male	Lav - Female
Stadiums, amusement parks, bleachers and grandstands for outdoor sporting events and activities	1 per 75 for the first 1,500 and 1 per 120 for the remainder exceeding 1,500	1 per 40 for the first 1,500 and 1 per 60 for the remainder exceeding 1,500	1 per 200	1 per 150

419.2 Substitution for water closets. In each bathroom or toilet room, urinals shall not be substituted for more than 5% percent of the required water closets in assembly and educational occupancies. Urinals shall not be substituted for more than 50 percent of the required water closets in all other occupancies.

Auto Queuing lane 1800 L.F. +/-

TOTAL PARKING: _____
(Parking at Football, Baseball and Softball Fields not included in Total)

001.1 OVERALL SITE PLAN
SCALE: 1" = 100'-0"

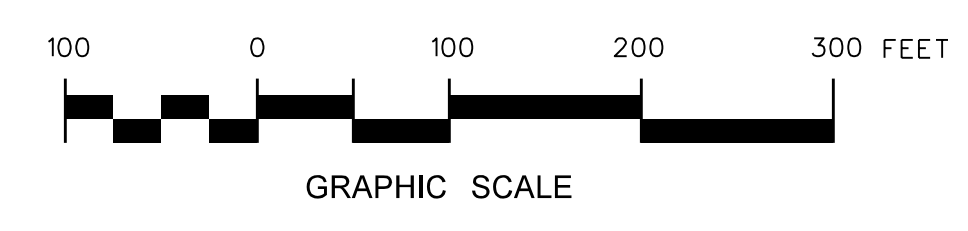

No.	Date

Hite associates
ARCHITECTURE / ENGINEERING / TECHNOLOGY
2600 Meridian Drive / Greenville, NC 27834 / tel (252) 757-0333

STATE OF SOUTH CAROLINA
JAMES C. HITE
ARCHITECTURE, P.C.
ARCHITECT, N.C.
100823
REGISTERED

STATE OF SOUTH CAROLINA
JAMES C. HITE
ARCHITECTURE, P.C.
ARCHITECT, N.C.
4846
REGISTERED

New Riverside High School
Beaufort County Schools
New Riverside Road
Bluffton / Beaufort County / South Carolina

Project No: 21328
Date: 12 February 2014
Drawing No: **C 001**