


Vreeland Engineers Inc.
3107 Sutherland Ave.
P.O. Box 106489
Knox 37610-0489
Knox 865-637-4451
vreelandengineers.com

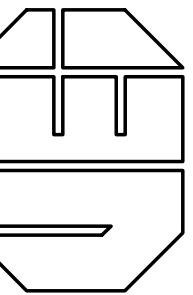

UNION COUNTY HIGH SCHOOL
FIRE ALARM UPGRADES
UNION COUNTY, TENNESSEE
T.F.M. #09158 / PROJECT # 2019-11-26-03


DRAWING DESCRIPTION:
OVERALL FIRST
FLOOR PLAN -
ELECTRICAL

DATE:
11-22-2019
REVISIONS:
1 TFM COMMENTS 12-5-19
2 ADDENDUM #1 04-09-20

SHEET NUMBER

E1

E1A - UCHS First Floor Plan - Part A - Electrical.dwg
C.W.L. 04/10/20 8:00 AM CL19316(L6)

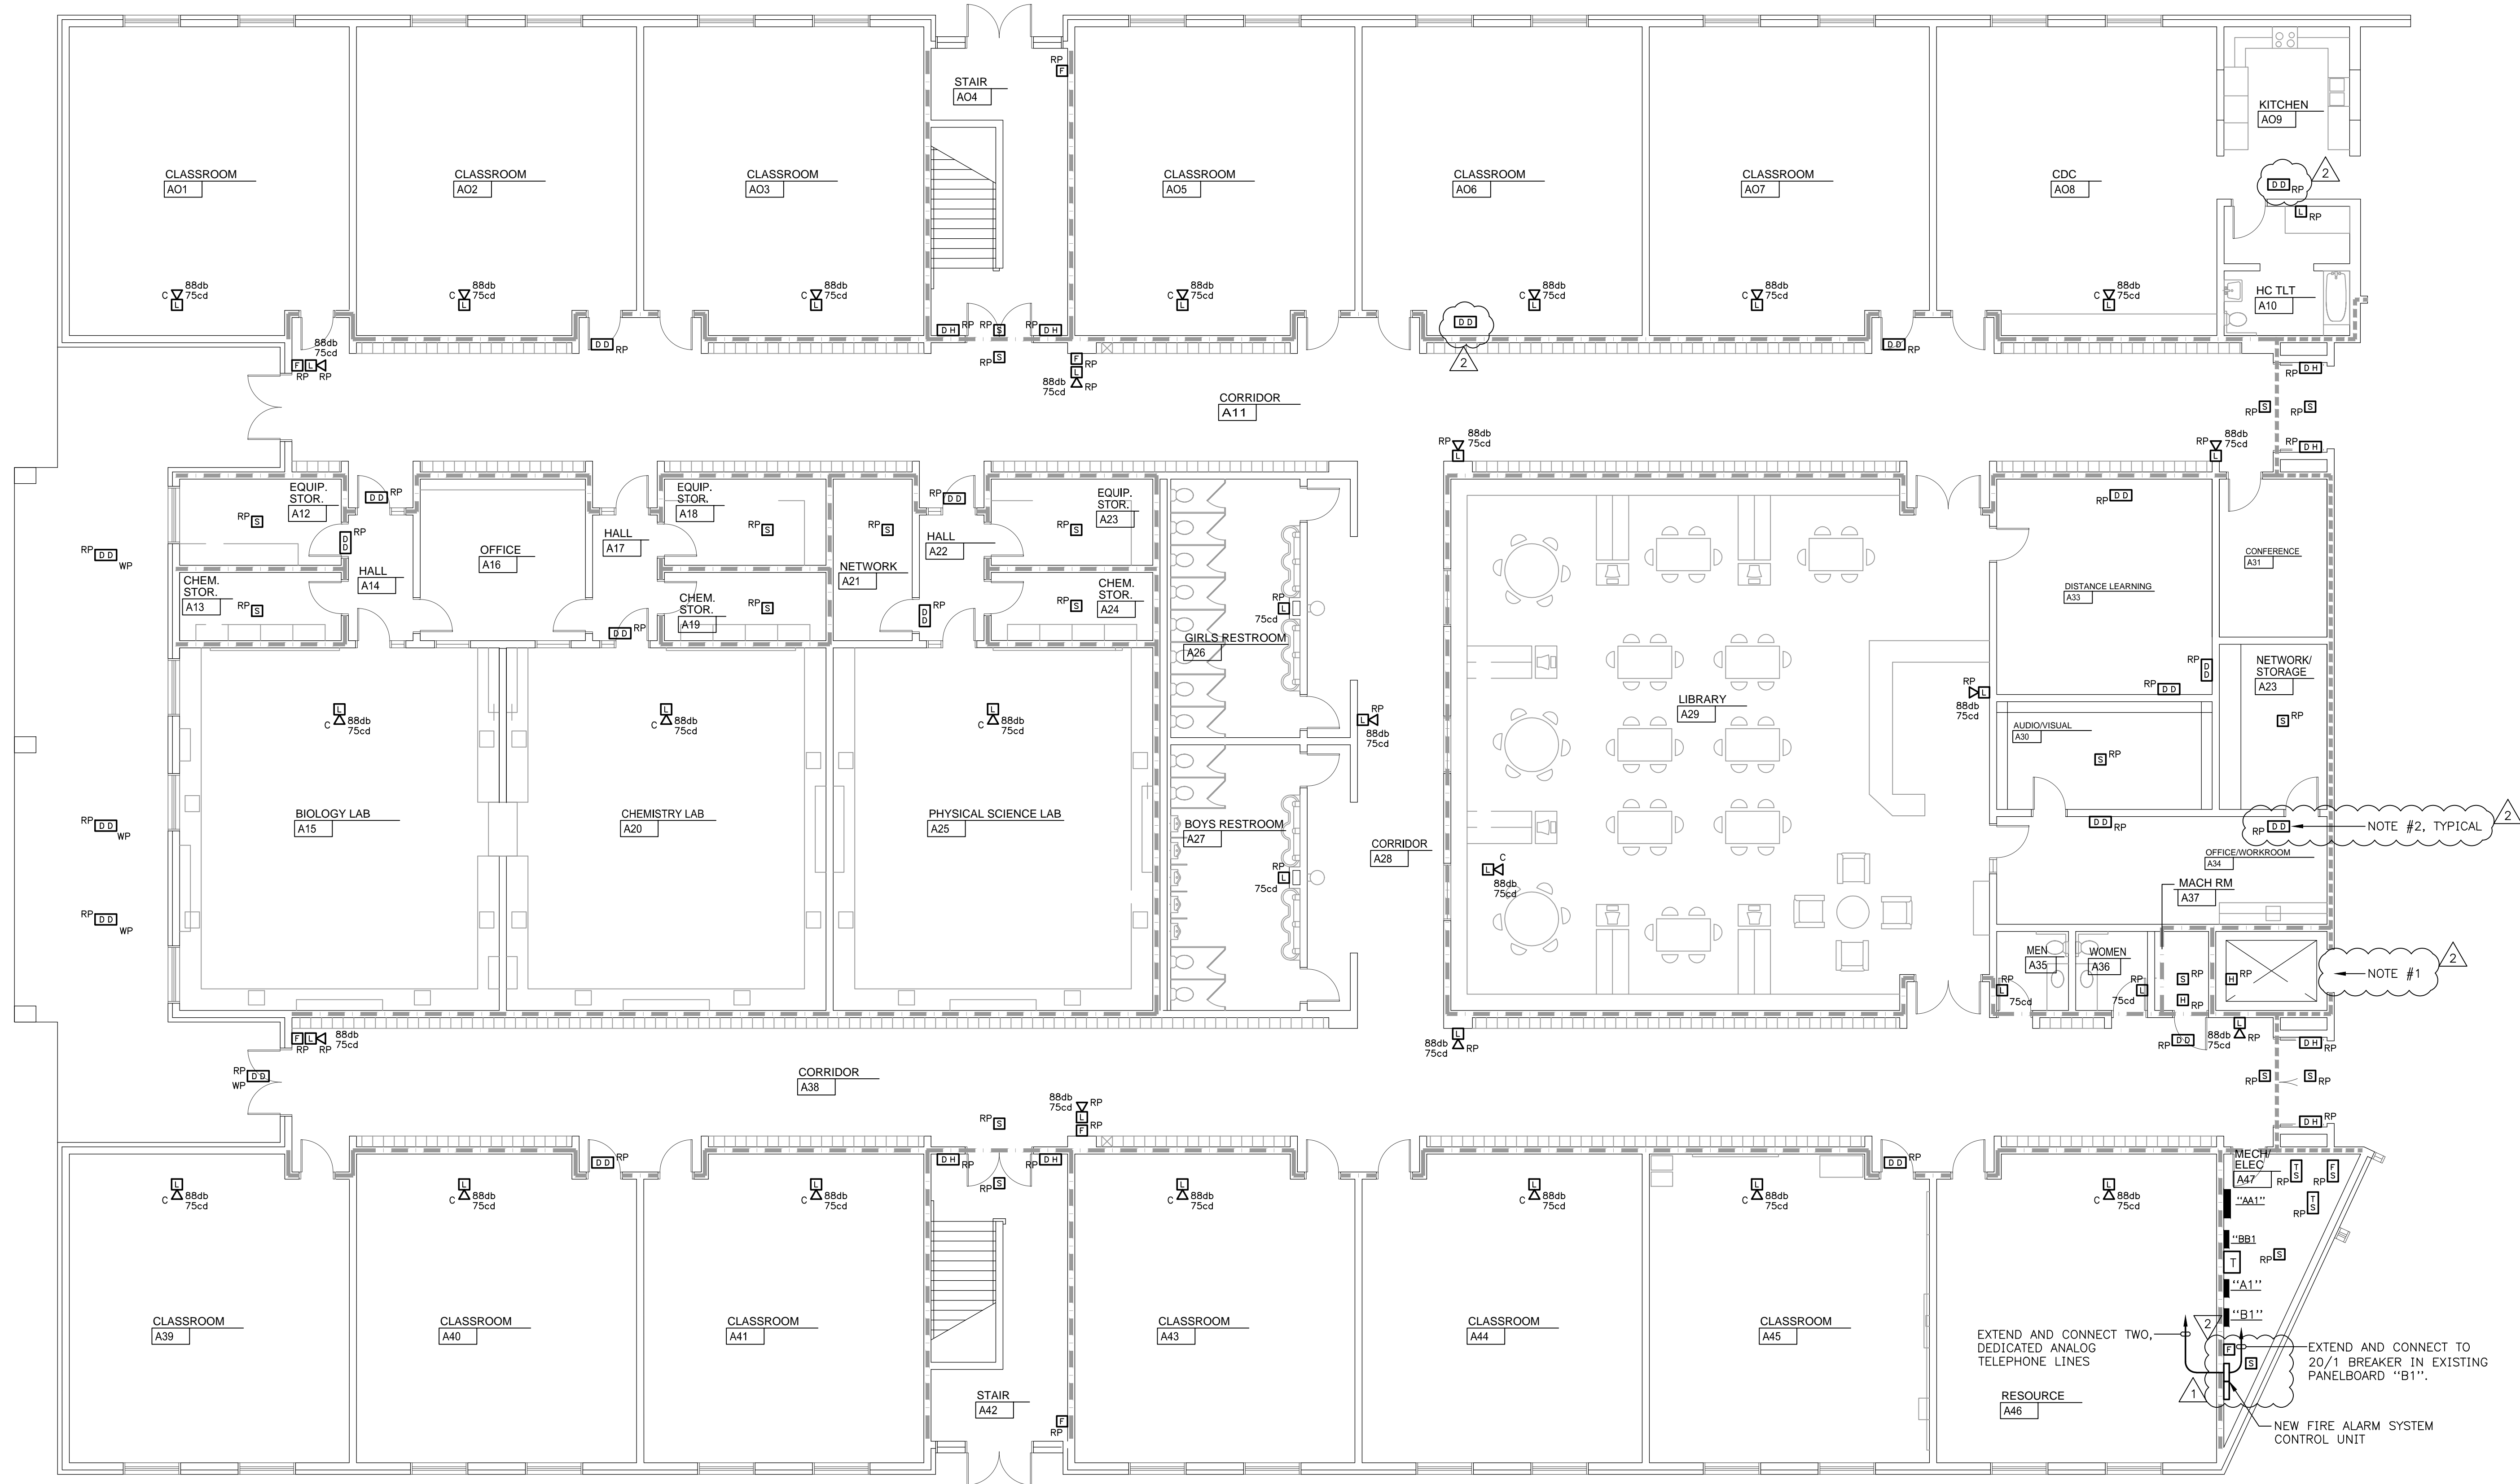

FIRST FLOOR PLAN - PART A - ELECTRICAL

SCALE: 1/8" = 1'-0"

0' 4' 8' 16'

2


NOTES:

1. PER EXISTING FIRE ALARM REPORTS TWO FIRE ALARM RELAYS CURRENTLY EXIST FOR ELEVATOR RECALL. REPLACE EXISTING RELAYS AND CONNECT TO NEW FIRE ALARM SYSTEM AND EXISTING ELEVATOR RECALL/CAPTURE AS REQUIRED.
2. DUCT MOUNTED SMOKE DETECTORS ILLUSTRATED CONTROL EXISTING SMOKE DAMPERS OR EXISTING HVAC UNITS. FIELD VERIFY EXACT LOCATION, QUANTITY, AND FUNCTION. CONNECT NEW DUCT DETECTORS TO FUNCTION AS DID EXISTING DUCT DETECTORS.


WALL LEGEND

- 1 HOUR FIRE WALL
- 2 HOUR FIRE WALL
- 4 HOUR FIRE WALL

INFORMATION REGARDING WALL RATINGS / WALL TYPES HAS BEEN TAKEN FROM EXISTING ARCHITECTURAL CONSTRUCTION DOCUMENTS FOR THE EXISTING UNION CO. HIGH SCHOOL.

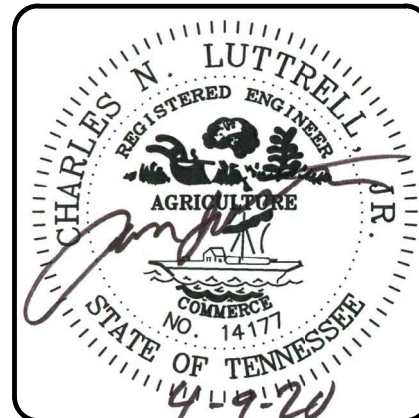

Vreeland Engineers Inc.
3107 Sutherland Ave.
P.O. Box 1064839
Knox 37603-4451
vreelandengineers.com

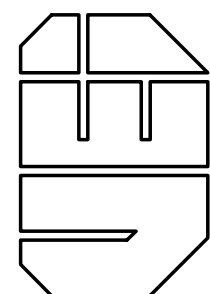

UNION COUNTY HIGH SCHOOL
FIRE ALARM UPGRADES
UNION COUNTY, TENNESSEE
T.F.M. #09158 / PROJECT # 2019-11-26-03


DRAWING DESCRIPTION:
FIRST FLOOR PLAN -
PART A - ELECTRICAL

DATE:	11-22-2019
REVISIONS:	
1	ITEM COMMENTS 12-5-19
2	ADDENDUM #1 04-09-20

SHEET NUMBER

E1A

OF

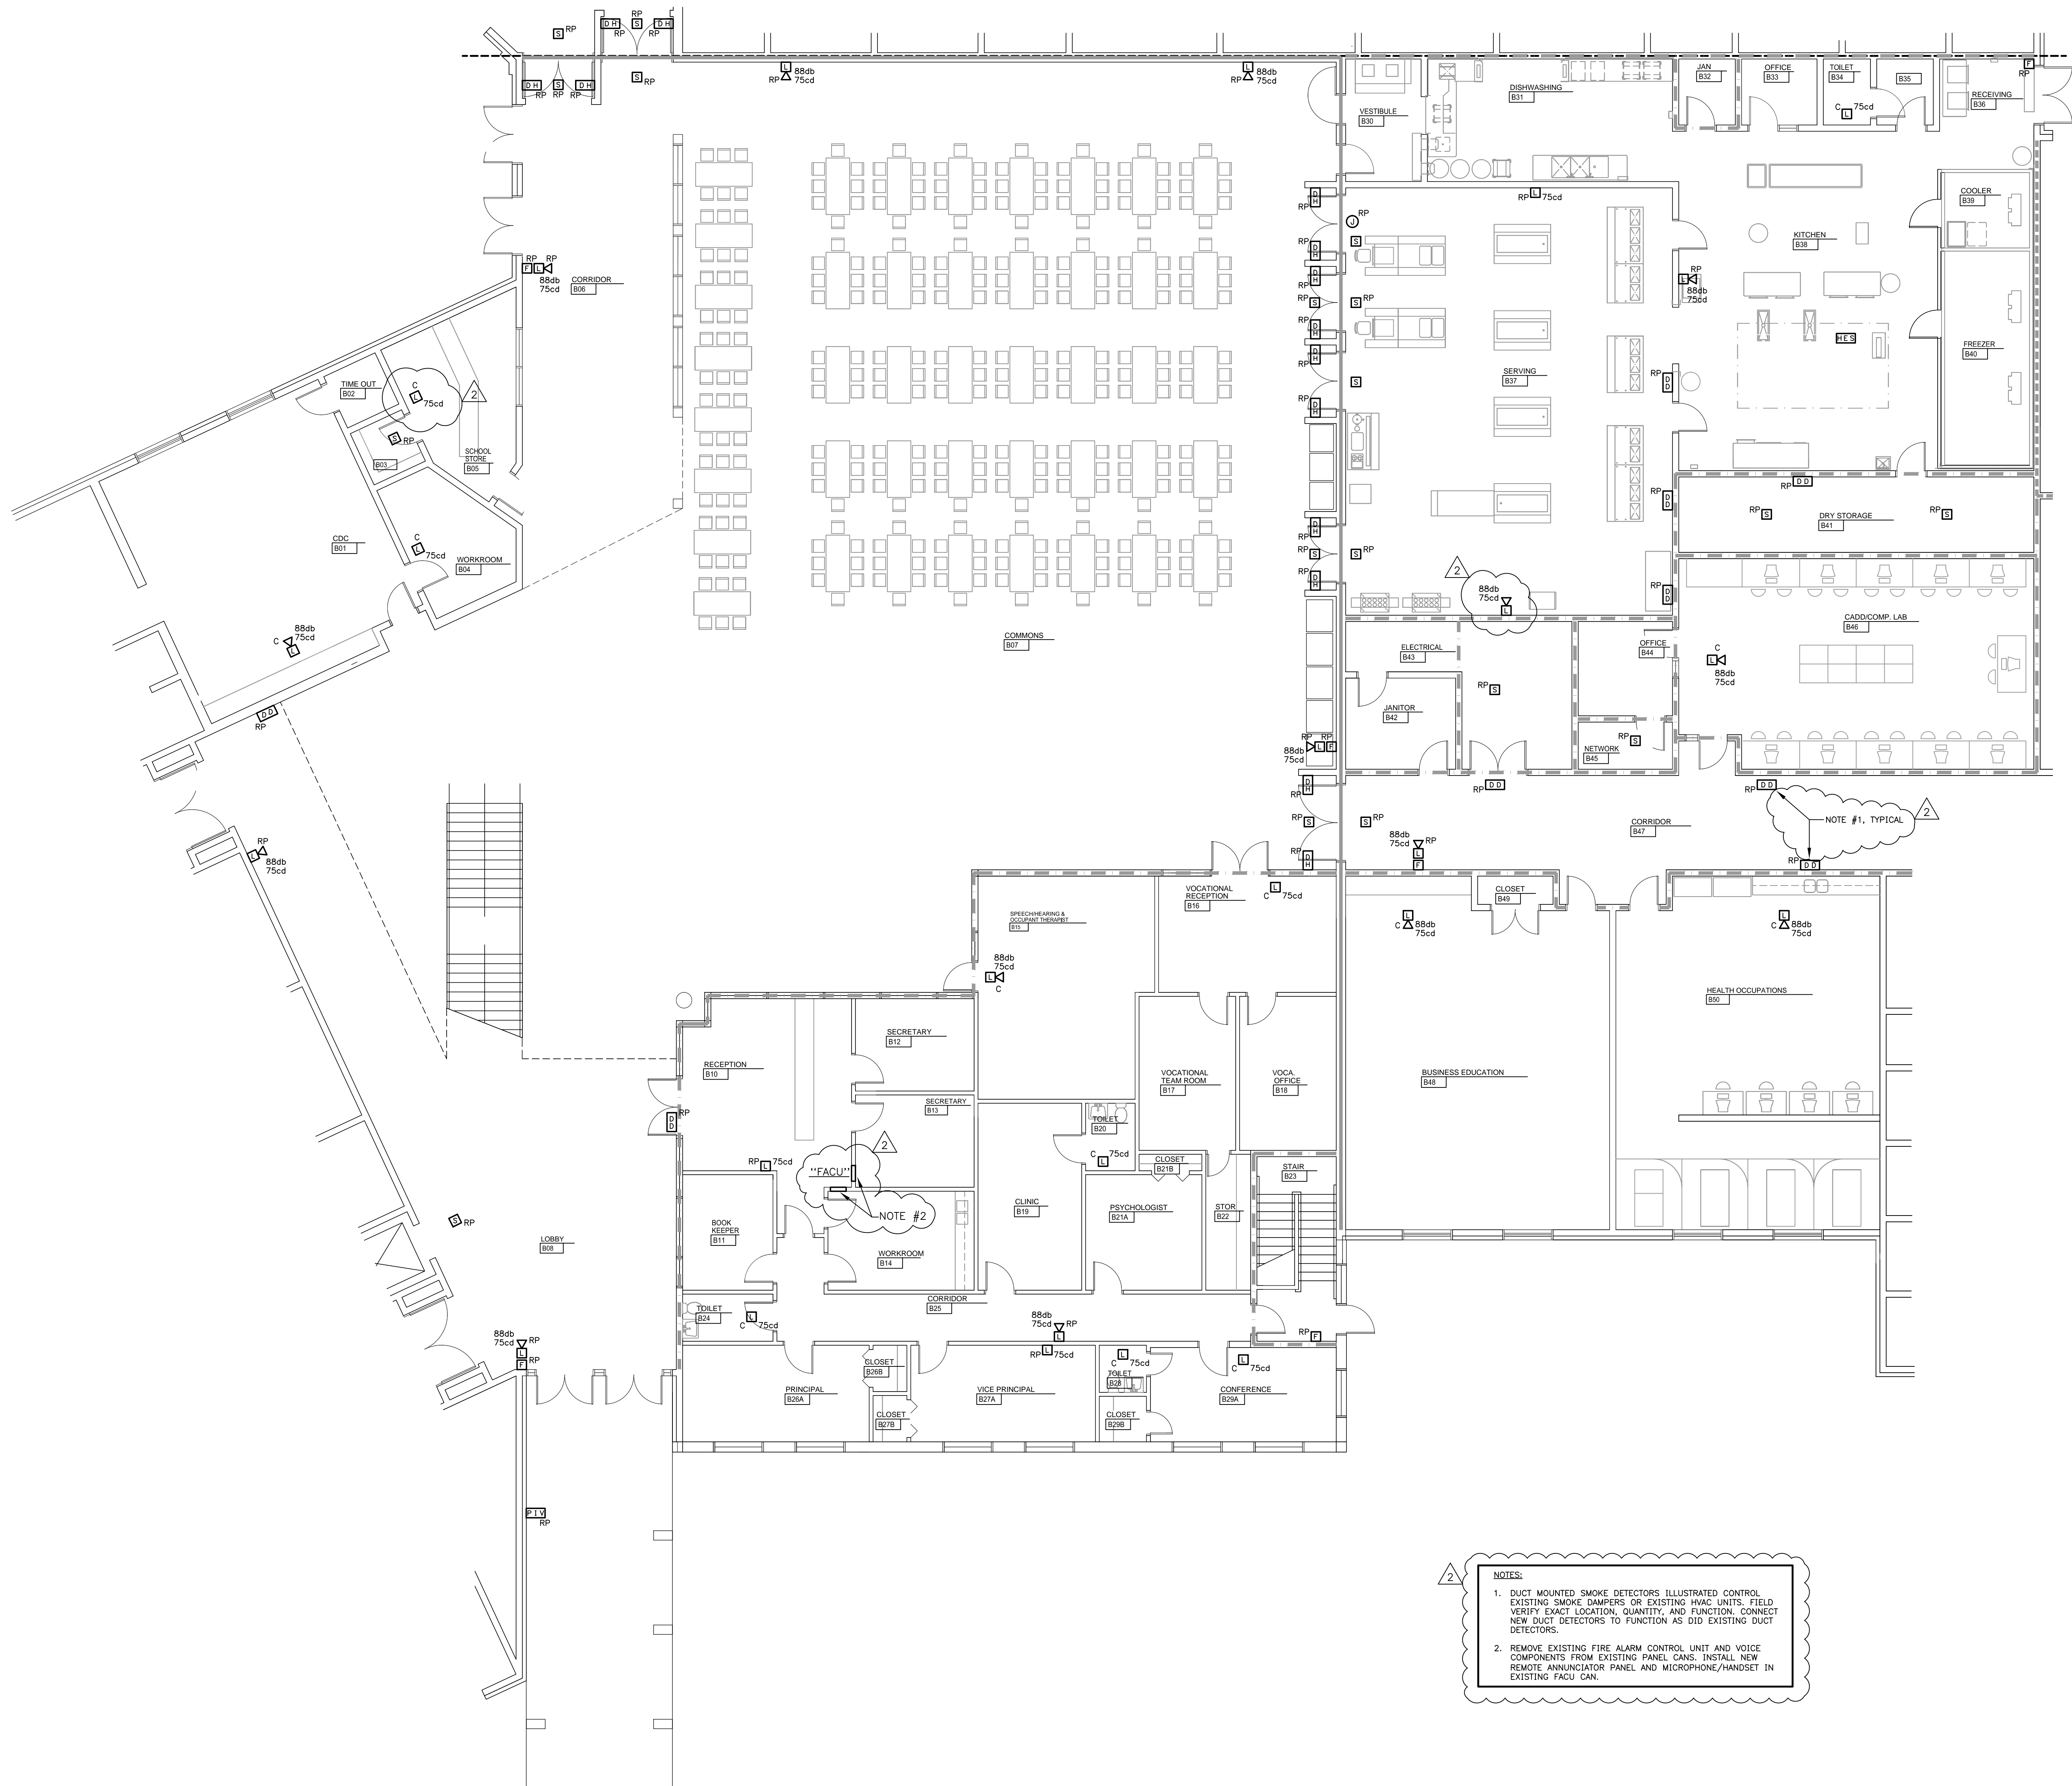


FIRST FLOOR PLAN - PART B - ELECTRICAL
SCALE: 1/8" = 1'-0"


WALL LEGEND

1 HOUR FIRE WALL
2 HOUR FIRE WALL
4 HOUR FIRE WALL

INFORMATION REGARDING WALL RATINGS / WALL TYPES HAS BEEN TAKEN FROM EXISTING ARCHITECTURAL CONSTRUCTION DOCUMENTS FOR THE EXISTING UNION CO. HIGH SCHOOL.

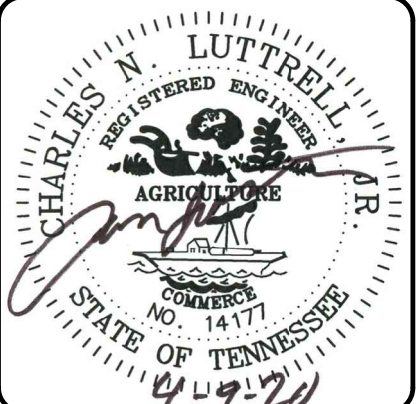

Vreeland Engineers Inc.
3107 Sutherland Ave.
P.O. Box 10645
Knoxville, TN 37939
Knox 865-637-4451
vreelandengineers.com

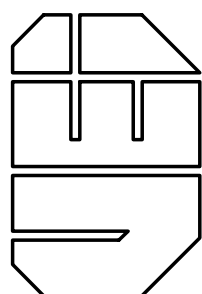

**UNION COUNTY HIGH SCHOOL
FIRE ALARM UPGRADES
UNION COUNTY, TENNESSEE
T.F.M. #09158 / PROJECT # 2019-11-26-03**


DRAWING DESCRIPTION:
**FIRST FLOOR PLAN -
PART B - ELECTRICAL**

DATE:	11-22-2019
REVISIONS:	
1	TFM COMMENTS 12-5-19
2	ADDENDUM #1 04-09-20

SHEET NUMBER

E1B

E1C - UCHS First Floor Plan - Part C - Electrical.dwg
C.W.L. 04/10/20 8:19 AM CL19516(L6)

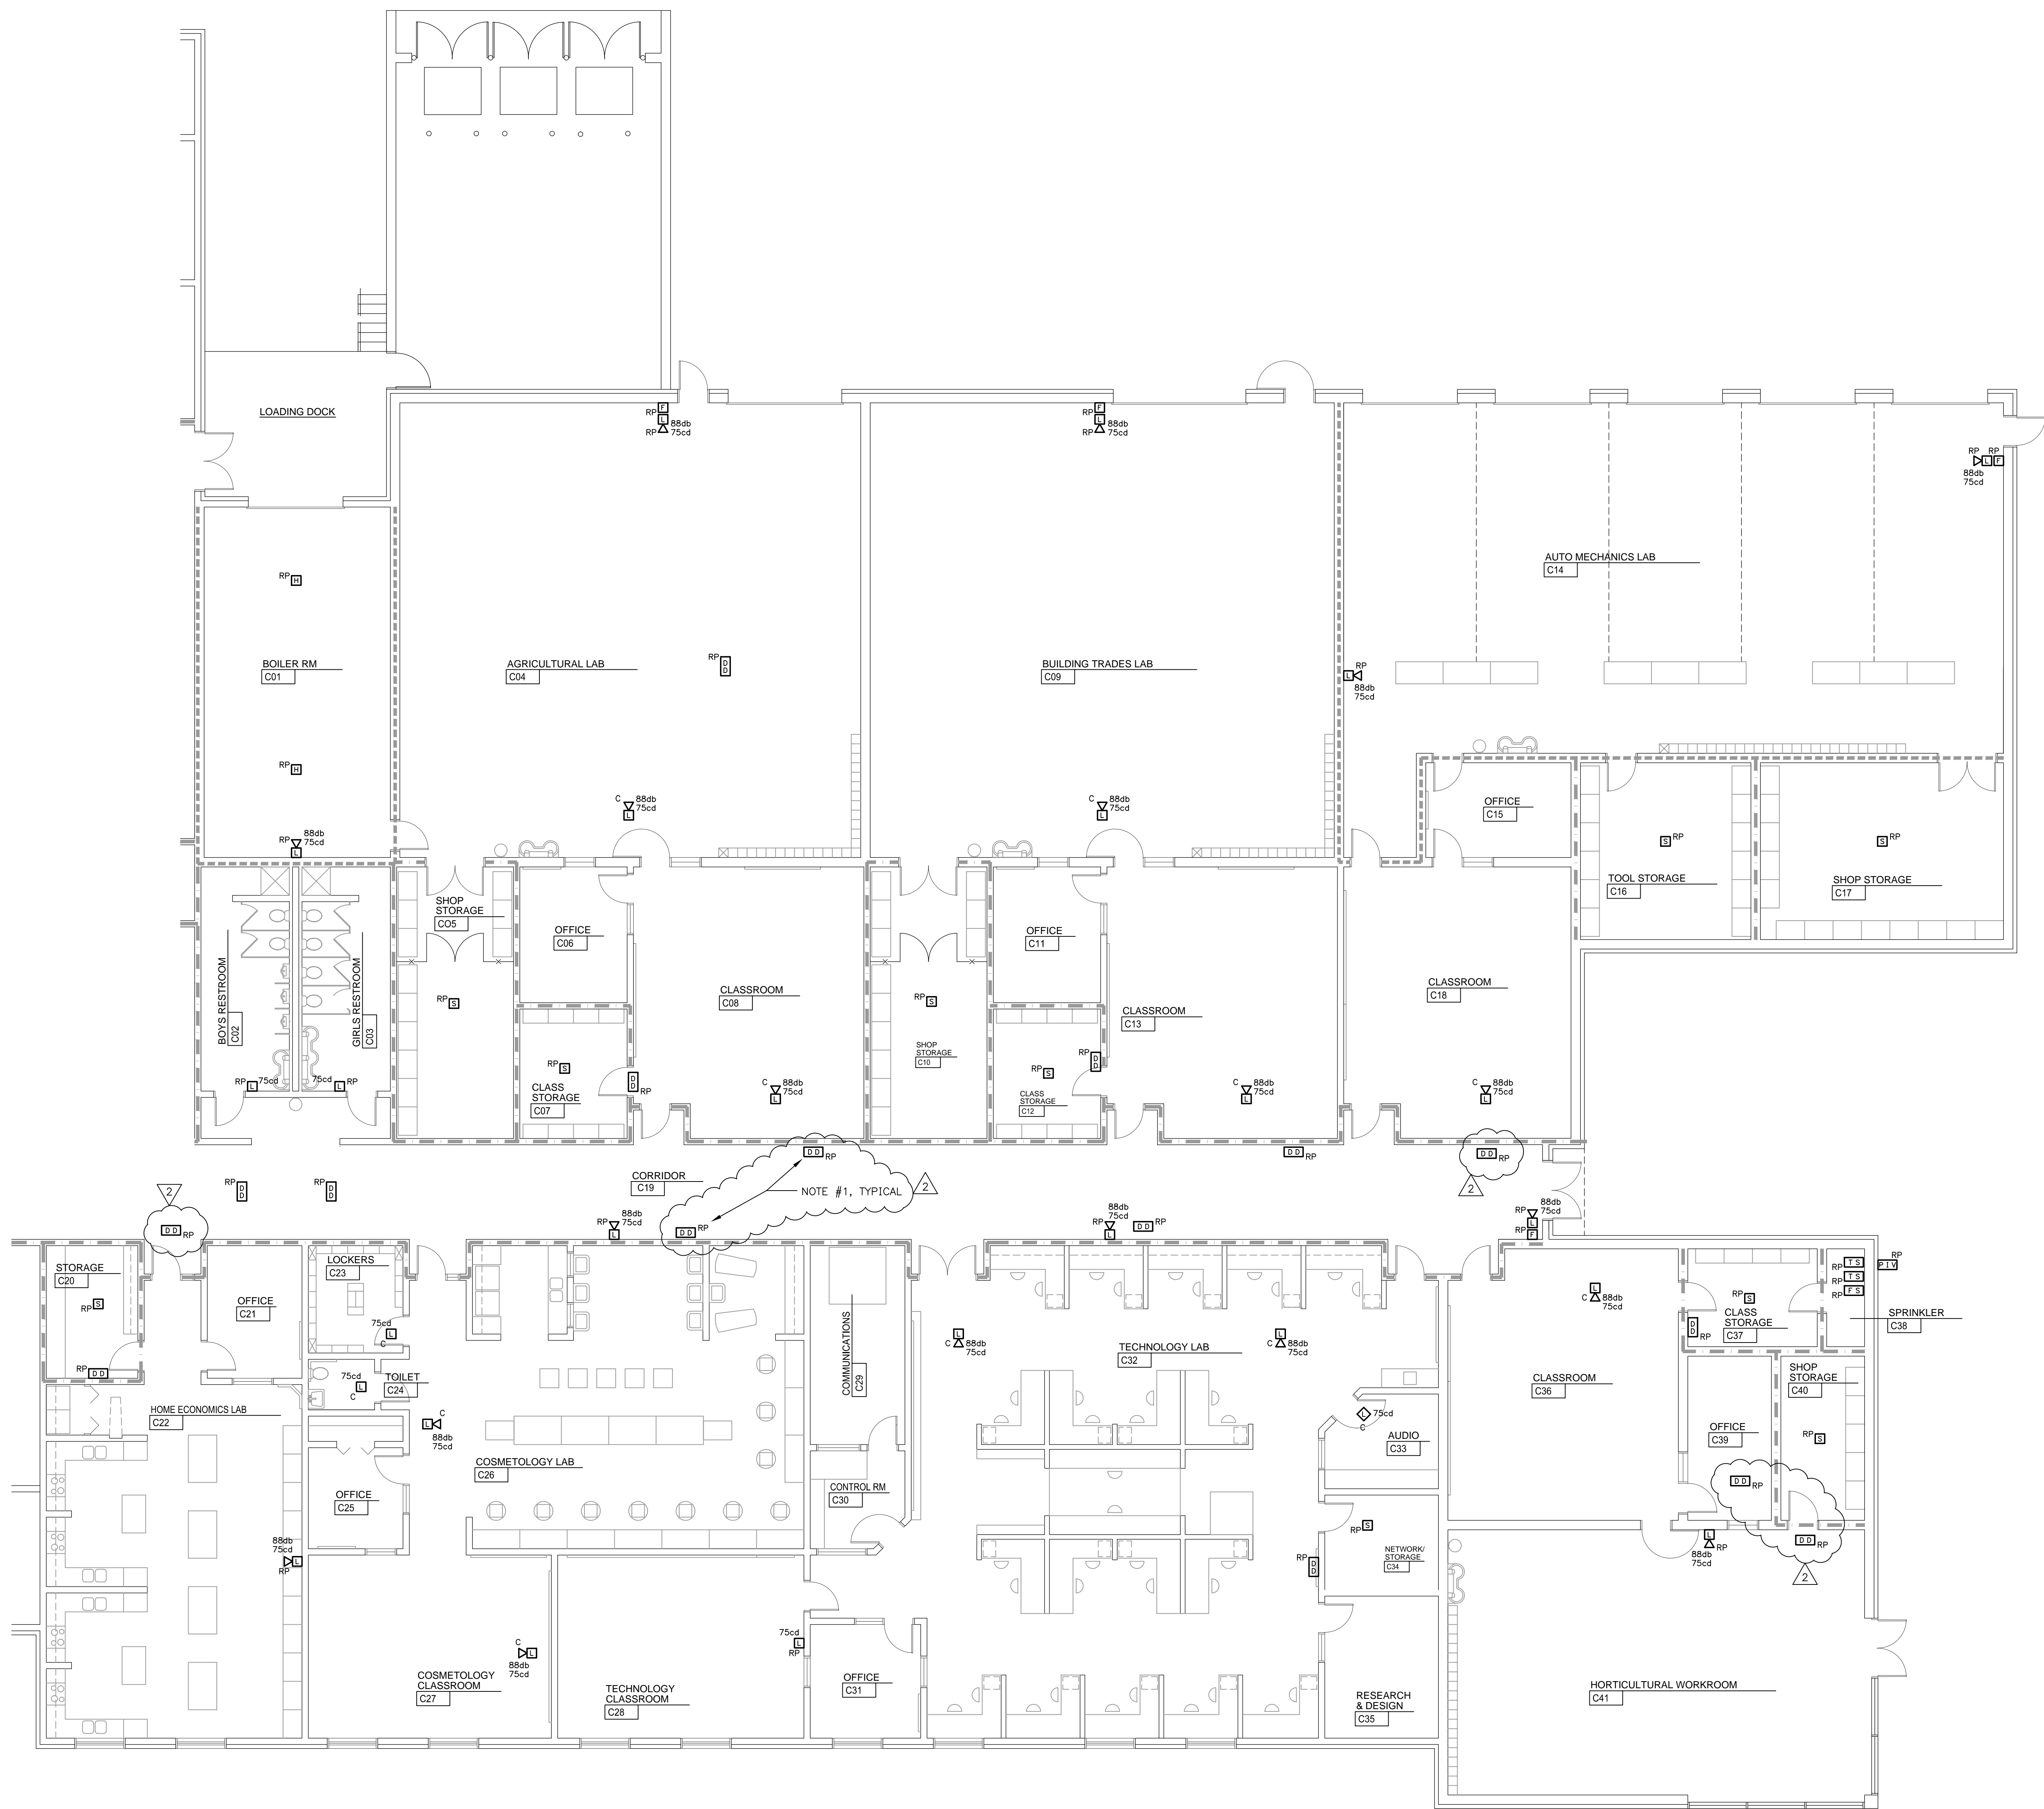

FIRST FLOOR PLAN - PART C - ELECTRICAL

SCALE: 1/8"=1'-0"

NOTE:
1. DUCT MOUNTED SMOKE DETECTORS ILLUSTRATED CONTROL EXISTING SMOKE DAMPERS OR EXISTING HVAC UNITS. FIELD VERIFY EXACT LOCATION, QUANTITY, AND FUNCTION. CONNECT NEW DUCT DETECTORS TO FUNCTION AS DID EXISTING DUCT DETECTORS.


WALL LEGEND

1 HOUR FIRE WALL
2 HOUR FIRE WALL
4 HOUR FIRE WALL

INFORMATION REGARDING WALL RATINGS / WALL TYPES HAS BEEN TAKEN FROM EXISTING ARCHITECTURAL CONSTRUCTION DOCUMENTS FOR THE EXISTING UNION CO. HIGH SCHOOL.



Vreeland Engineers Inc.
3107 Sutherland Ave.
P.O. Box 10648
Knox, TN 37602-0648
Knox 865-637-4451
vreelandengineers.com

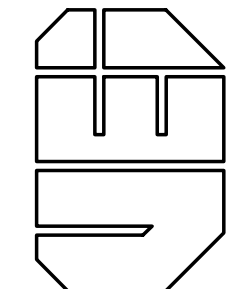

UNION COUNTY HIGH SCHOOL
FIRE ALARM UPGRADES
UNION COUNTY, TENNESSEE
T.F.M. #09158 / PROJECT # 2019-11-26-03

DRAWING DESCRIPTION:
FIRST FLOOR PLAN - PART C - ELECTRICAL


DATE:	11-22-2019
REVISIONS:	
1	TFM COMMENTS 12-5-19
2	ADDENDUM #1 04-09-20

SHEET NUMBER

E1C

OF

E1D - UCHS First Floor Plan - Part D - Electrical.dwg
C:\W.L. 04/10/20 8:24 AM CL19516(L6)

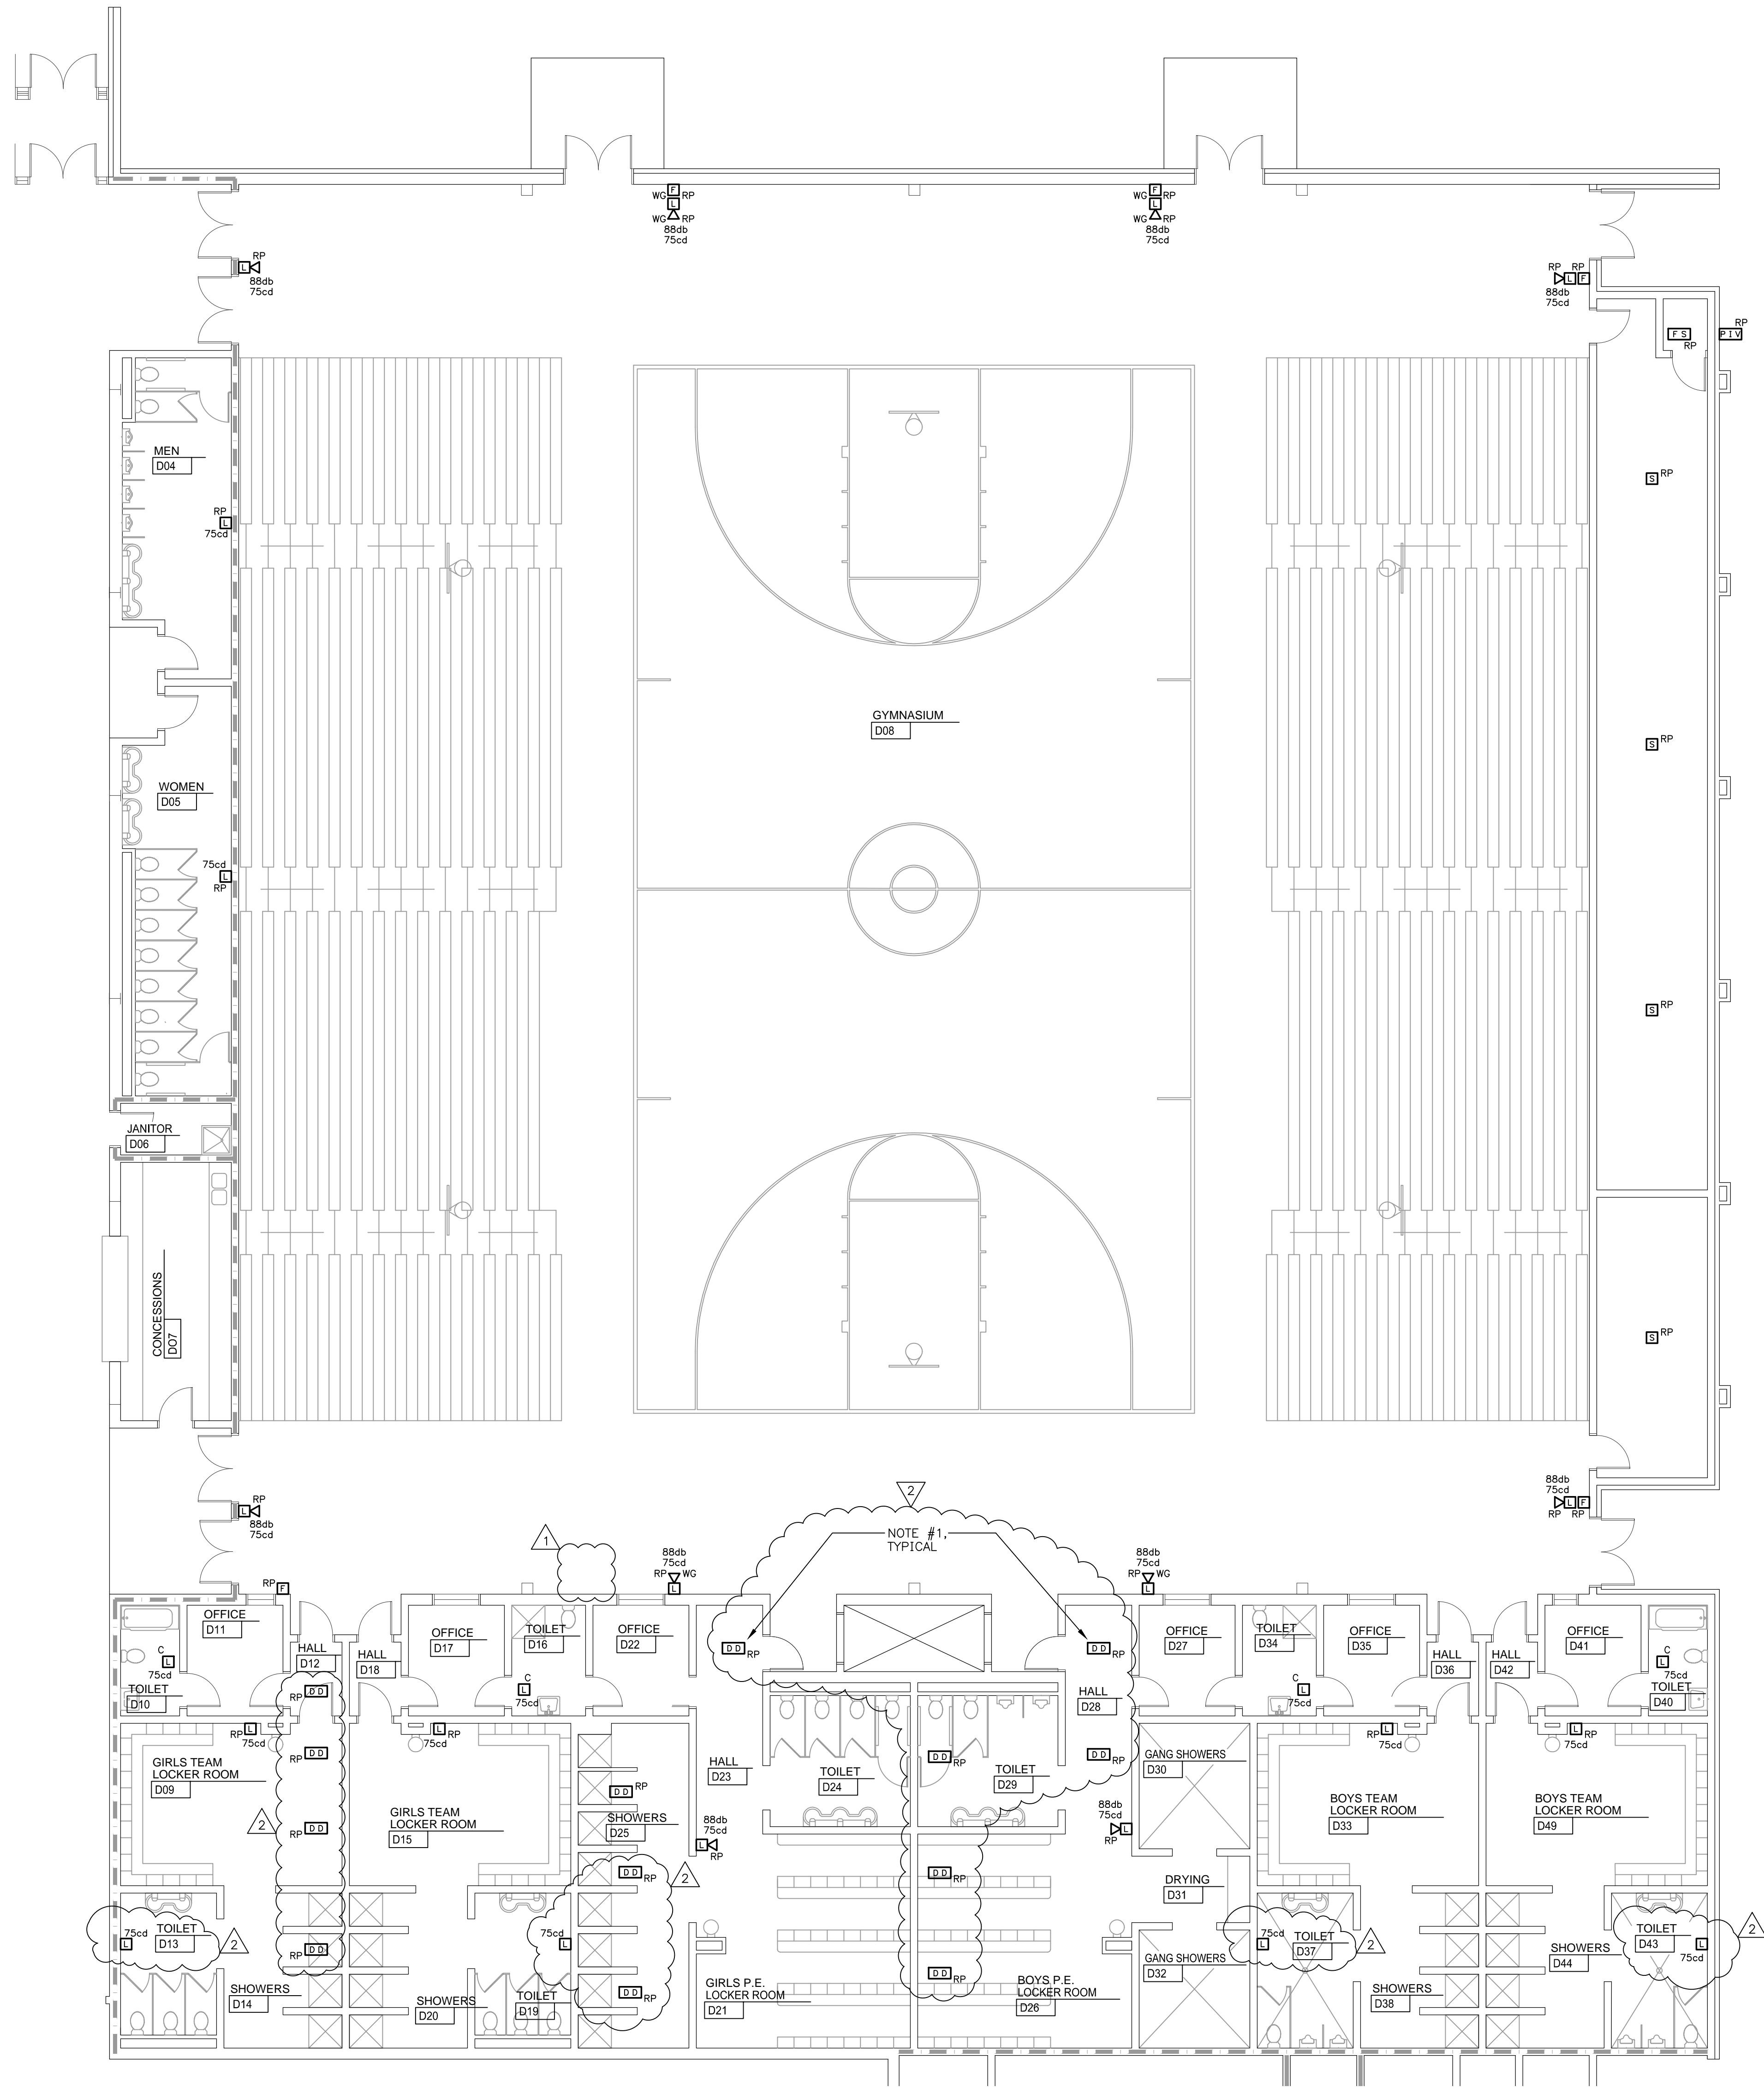

FIRST FLOOR PLAN - PART D - ELECTRICAL


SCALE: 1/8"=1'-0"
0' 4' 8' 16'

NOTE:
1. DUCT MOUNTED SMOKE DETECTORS ILLUSTRATED CONTROL EXISTING SMOKE DAMPERS OR EXISTING HVAC UNITS. FIELD VERIFY EXACT LOCATION, QUANTITY, AND FUNCTION. CONNECT NEW DUCT DETECTORS TO FUNCTION AS DID EXISTING DUCT DETECTORS.

WALL LEGEND	
1 HOUR FIRE WALL	----
2 HOUR FIRE WALL	-----
4 HOUR FIRE WALL	-----
INFORMATION REGARDING WALL RATINGS / WALL TYPES HAS BEEN TAKEN FROM EXISTING ARCHITECTURAL CONSTRUCTION DOCUMENTS FOR THE EXISTING UNION CO. HIGH SCHOOL.	



Vreeland Engineers Inc.
3107 Sutherland Ave.
P.O. Box 1064839
Knox, TN 37616-4839
865-637-4451
vreelandengineers.com

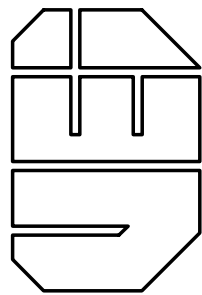

UNION COUNTY HIGH SCHOOL
FIRE ALARM UPGRADES
UNION COUNTY, TENNESSEE
T.F.M. #09158 / PROJECT # 2019-11-26-03


DRAWING DESCRIPTION:
FIRST FLOOR PLAN -
PART D - ELECTRICAL

DATE:	11-22-2019
REVISIONS:	
1	TFM COMMENTS 12-5-19
2	ADDENDUM #1 04-09-20

SHEET NUMBER

E1D

OF

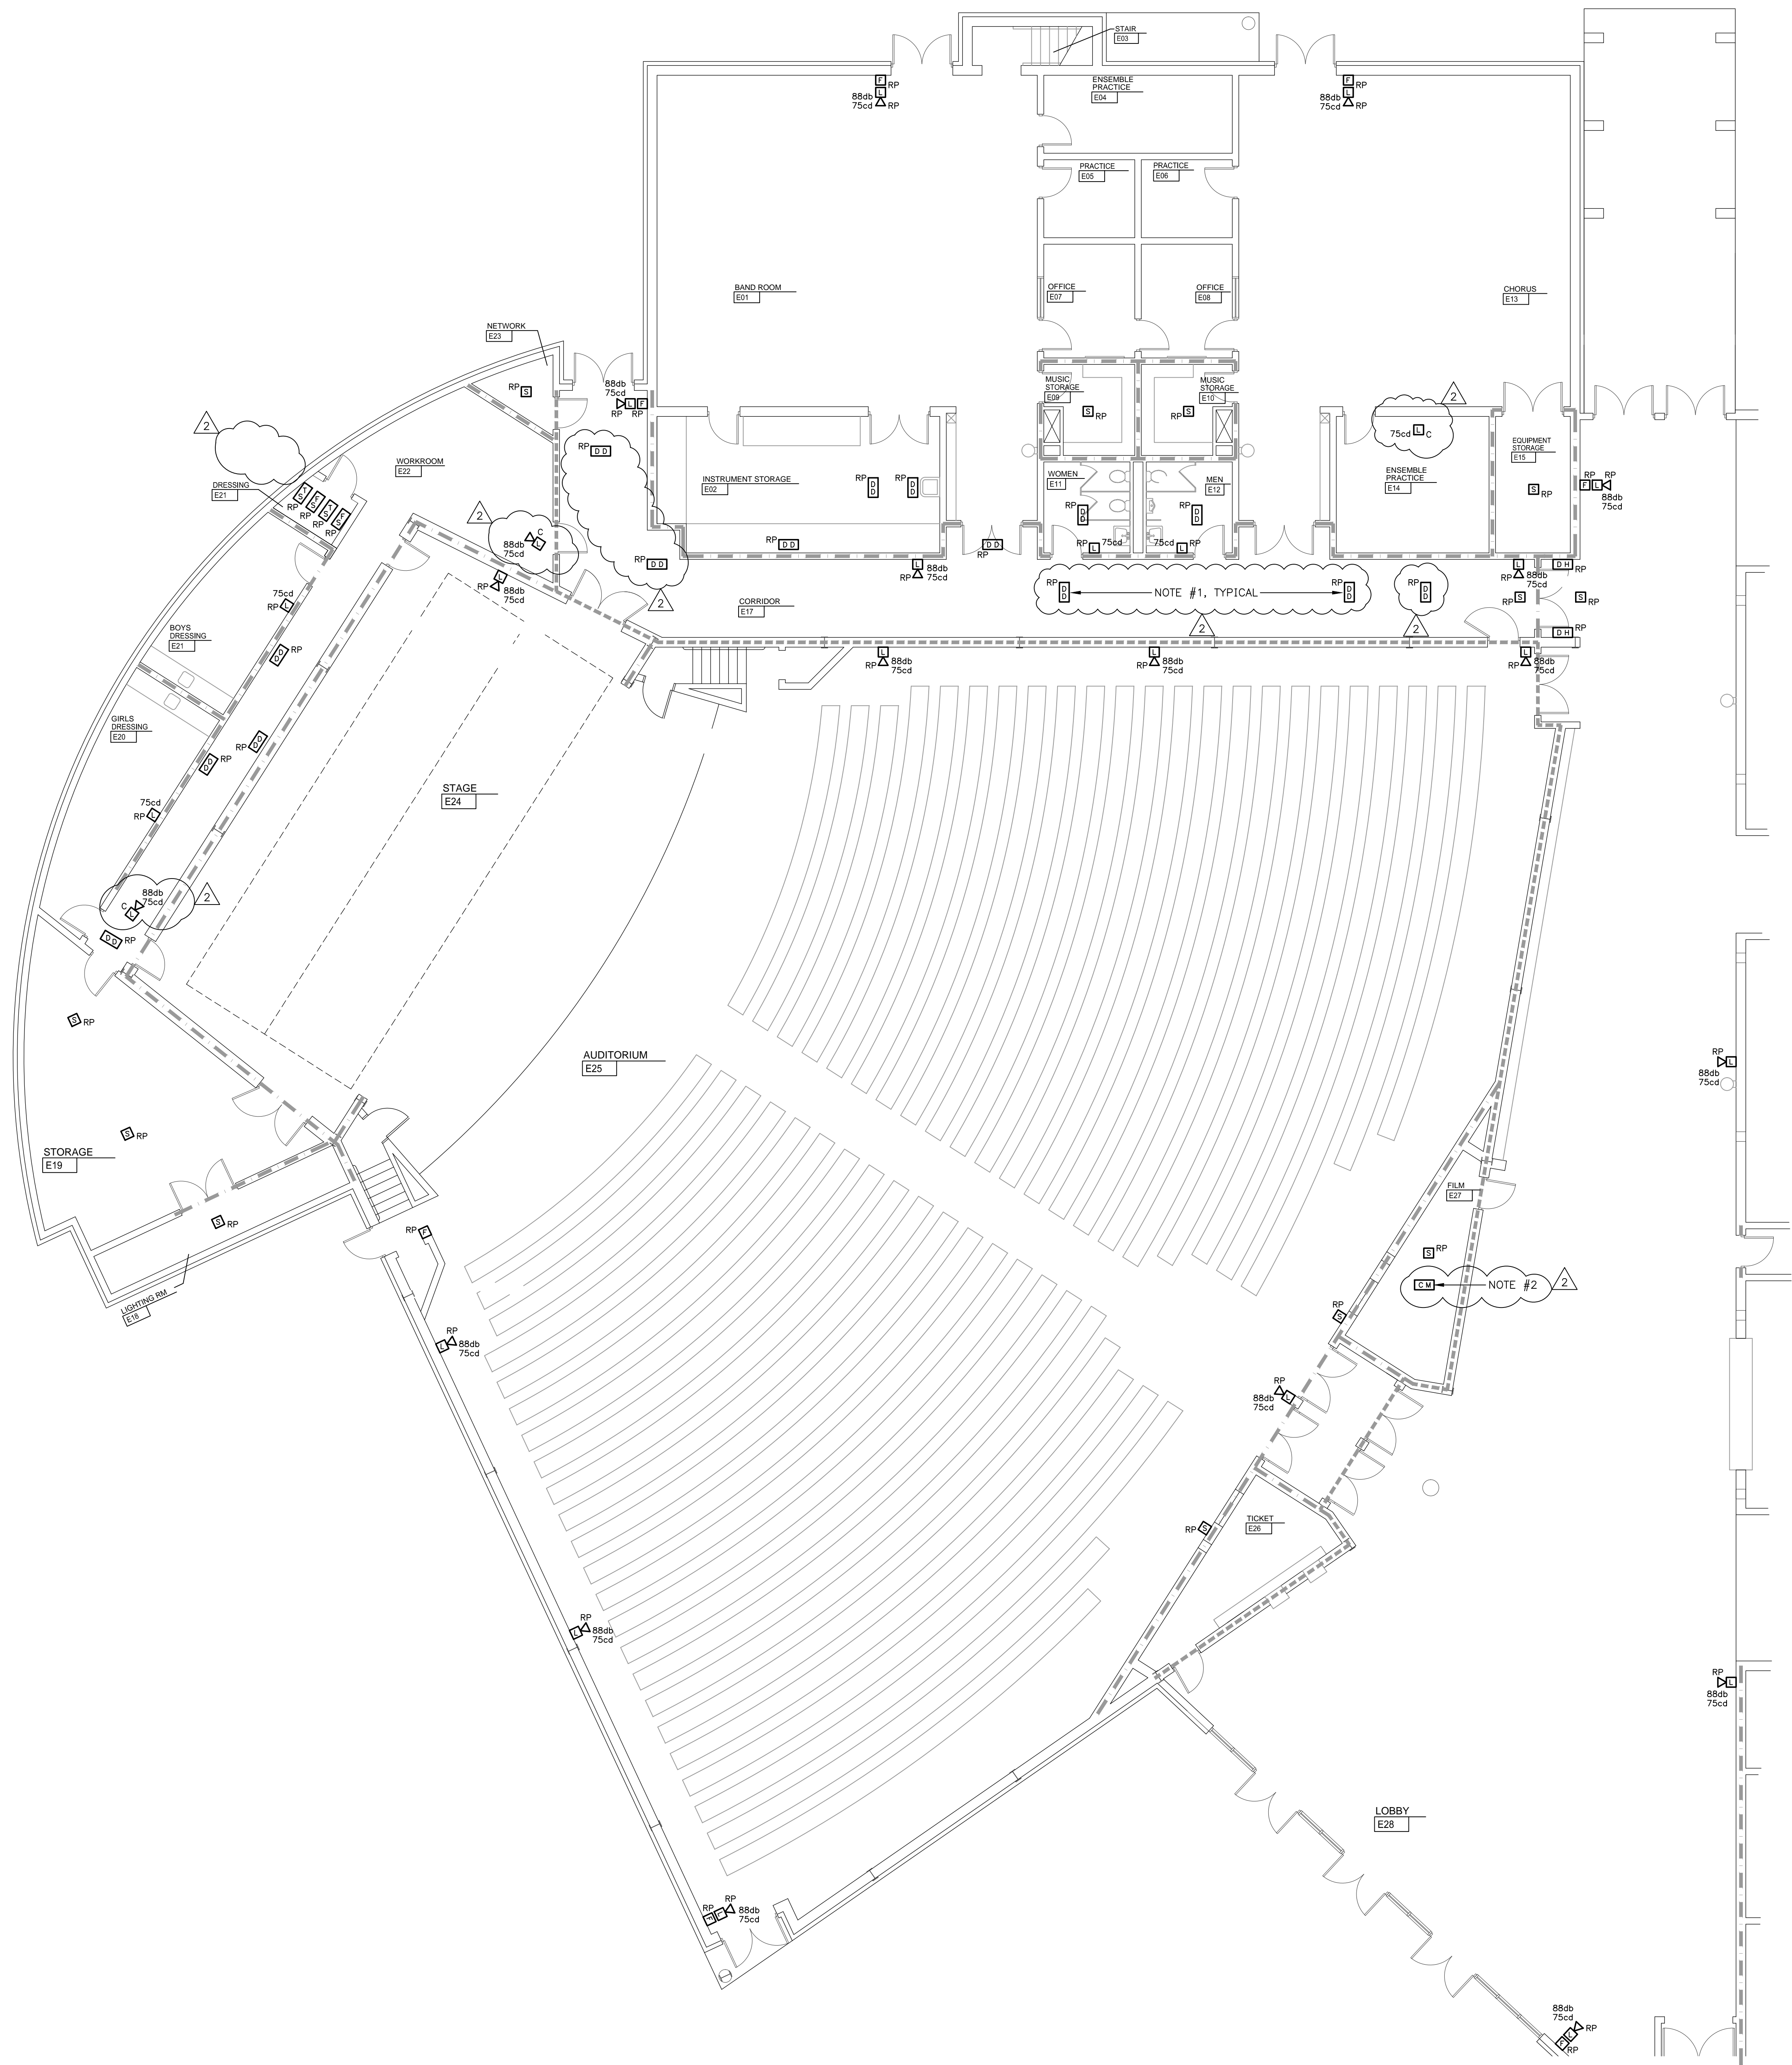

FIRST FLOOR PLAN - PART E - ELECTRICAL

SCALE: 1/8" = 1'-0"

0' 4' 8' 16'

- NOTE:
1. DUCT MOUNTED SMOKE DETECTORS ILLUSTRATED CONTROL EXISTING SMOKE DAMPERS OR EXISTING HVAC UNITS. FIELD VERIFY EXACT LOCATION, QUANTITY, AND FUNCTION. CONNECT NEW DUCT DETECTORS TO FUNCTION AS DID EXISTING DUCT DETECTORS.
 2. FURNISH AND INSTALL FIRE ALARM SYSTEM CONTROL MODULE(S) TO INTERFACE WITH EXISTING AUDITORIUM A/V SYSTEM. CONNECT TO FIRE ALARM SYSTEM SUCH THAT ACTIVATION OF FIRE ALARM SYSTEM SHALL OVER RIDE A/V SYSTEM AND PROHIBIT A/V SOUND SYSTEM FROM OPERATING DURING A FIRE ALARM NOTIFICATION.


WALL LEGEND

- 1 HOUR FIRE WALL
2 HOUR FIRE WALL
4 HOUR FIRE WALL

INFORMATION REGARDING WALL RATINGS / WALL TYPES HAS BEEN TAKEN FROM EXISTING ARCHITECTURAL CONSTRUCTION DOCUMENTS FOR THE EXISTING UNION CO. HIGH SCHOOL.



Vreeland Engineers Inc.
3107 Sutherland Ave.
P.O. Box 10648
Knox, TN 37628-0648
865-637-4451
vreelandengineers.com

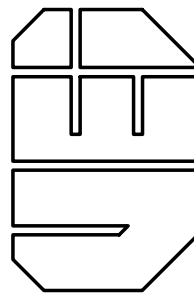

UNION COUNTY HIGH SCHOOL
FIRE ALARM UPGRADES
UNION COUNTY, TENNESSEE
T.F.M. #09158 / PROJECT # 2019-11-26-03

DRAWING DESCRIPTION:
FIRST FLOOR PLAN -
PART E - ELECTRICAL

DATE:	11-22-2019
REVISIONS:	
1	TFM COMMENTS 12-5-19
2	ADDENDUM #1 04-09-20

SHEET NUMBER

E1E