 



LANDSCAPE NOTES:
 AN AUTOMATIC IRRIGATION SYSTEM IS TO BE PROVIDED GIVING 100% COVERAGE OF ALL PROPOSED LAWN AND LANDSCAPE AREAS. WATER CONSERVING SYSTEMS SUCH AS DRIP IRRIGATION SYSTEMS WITH MOISTURE SENSORS AREA ENCOURAGED.

- SPRINKLERS TO BE SPACED AT A MAXIMUM OF 90% OF THEIR RADIUS OF THROW.
- DRIP TUBING TO BE INSTALLED IN ROWS 18" APART AND INTERCONNECTED WITH A SUPPLY HEADER.
- 24" MINIMUM COVER FOR MAINLINE PIPING.
- LANDSCAPE BEDS ARE TO BE ZONED SEPARATELY FROM TURF AREAS.

SEE FINAL PALMETTO ELECTRIC CONDUIT PLAN FOR ADDITIONAL CONDUIT ROUTING REQUIREMENTS

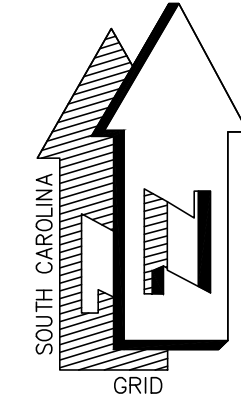

C:\GAAA-ACTIVE_JOBS\2019\2019-0441_BUCKWALTER PLACE LEC EXPANSION.AA - DRAWINGS\CIVIL\2019-0441_OV.DWG 5/15/2020 9:39 AM



REV #	DATE	DESCRIPTION
2	5/15/2020	BID ADDENDUM 3
1	3/20/2020	BID ADDENDUM 2

**BUCKWALTER PLACE LEC
 EXPANSION - PHASE 1
 UTILITY PLAN**

DRAWN BY:	NLS
CHECKED BY:	AJB
APPROVED BY:	AJB
DATE:	03/10/2020
SCALE:	1" = 20'
JOB No.	2019-0441
DRAWING No.	C9.0