


LIGHTING PLAN


SCALE: 1/4"=1'-0"

REFERENCE NOTES:
 1. INSTALL SURFACE ATTIC LIGHT (TYPE G), TOGGLE SWITCH, AND ATTIC RECEPTACLE. RUN CONDUIT AND WIRING BACK TO PANEL A, CIRCUIT 31.

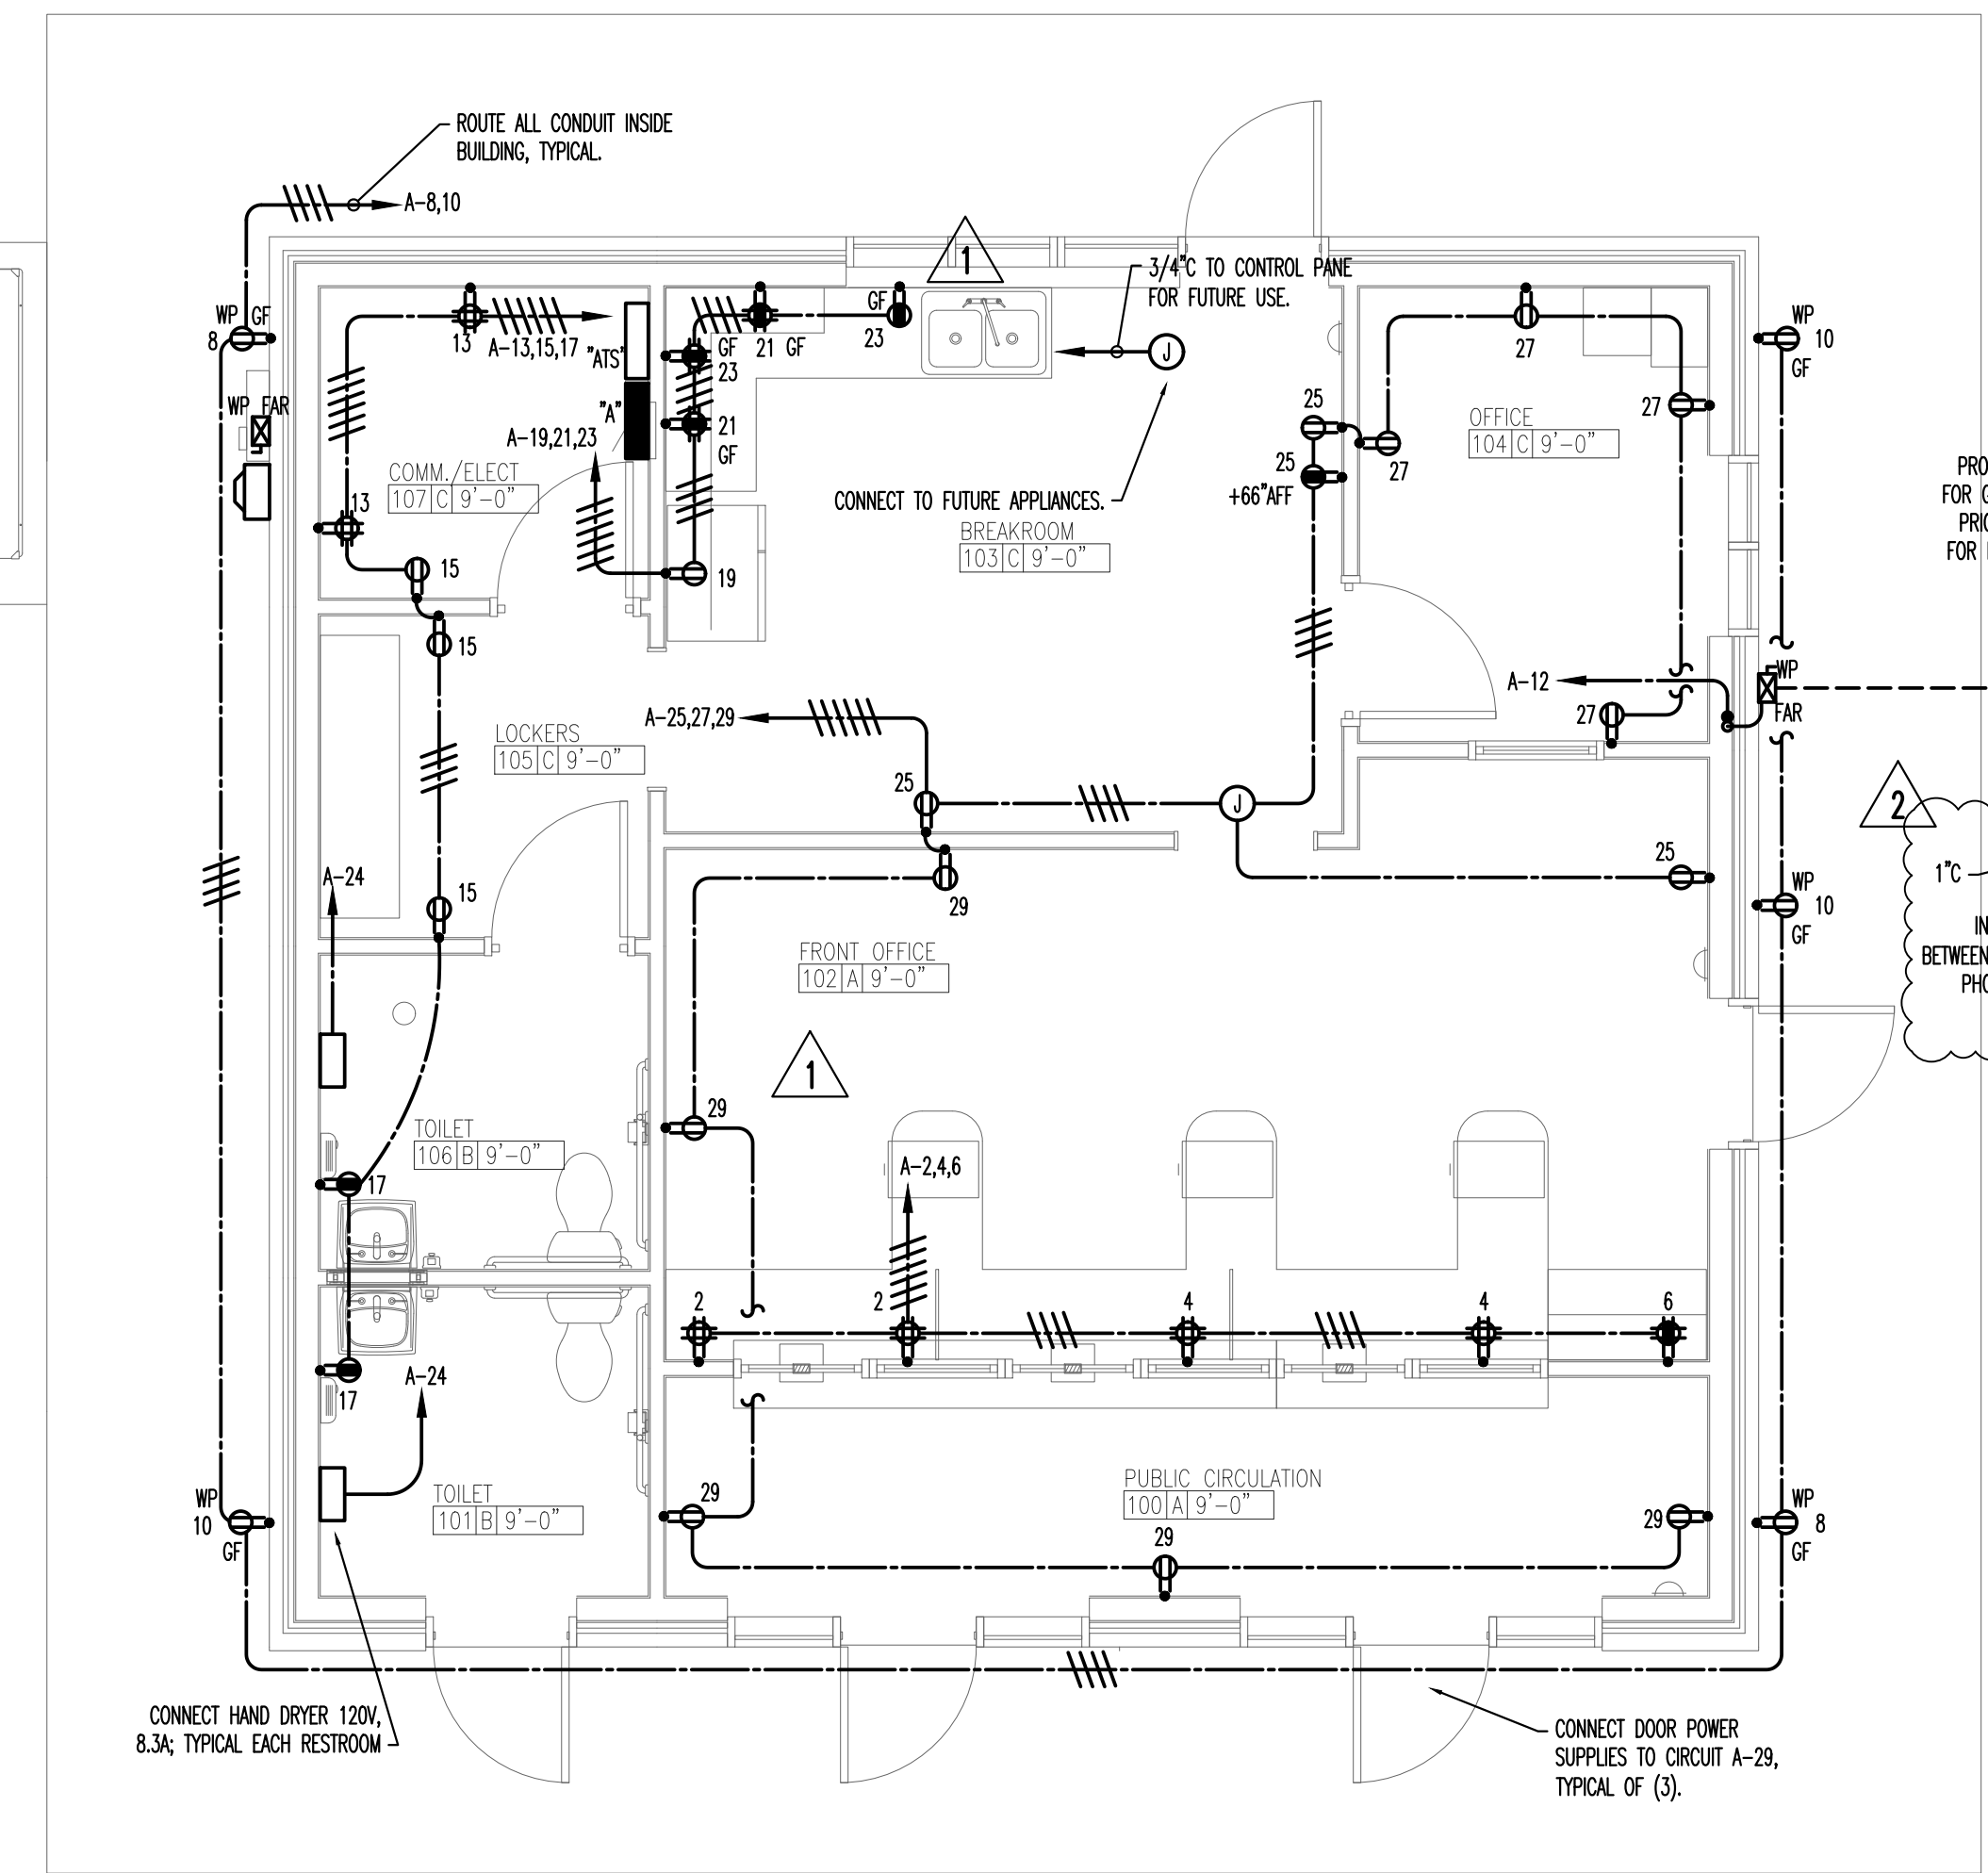


POWER PLAN

SCALE: 1/4"=1'-0"

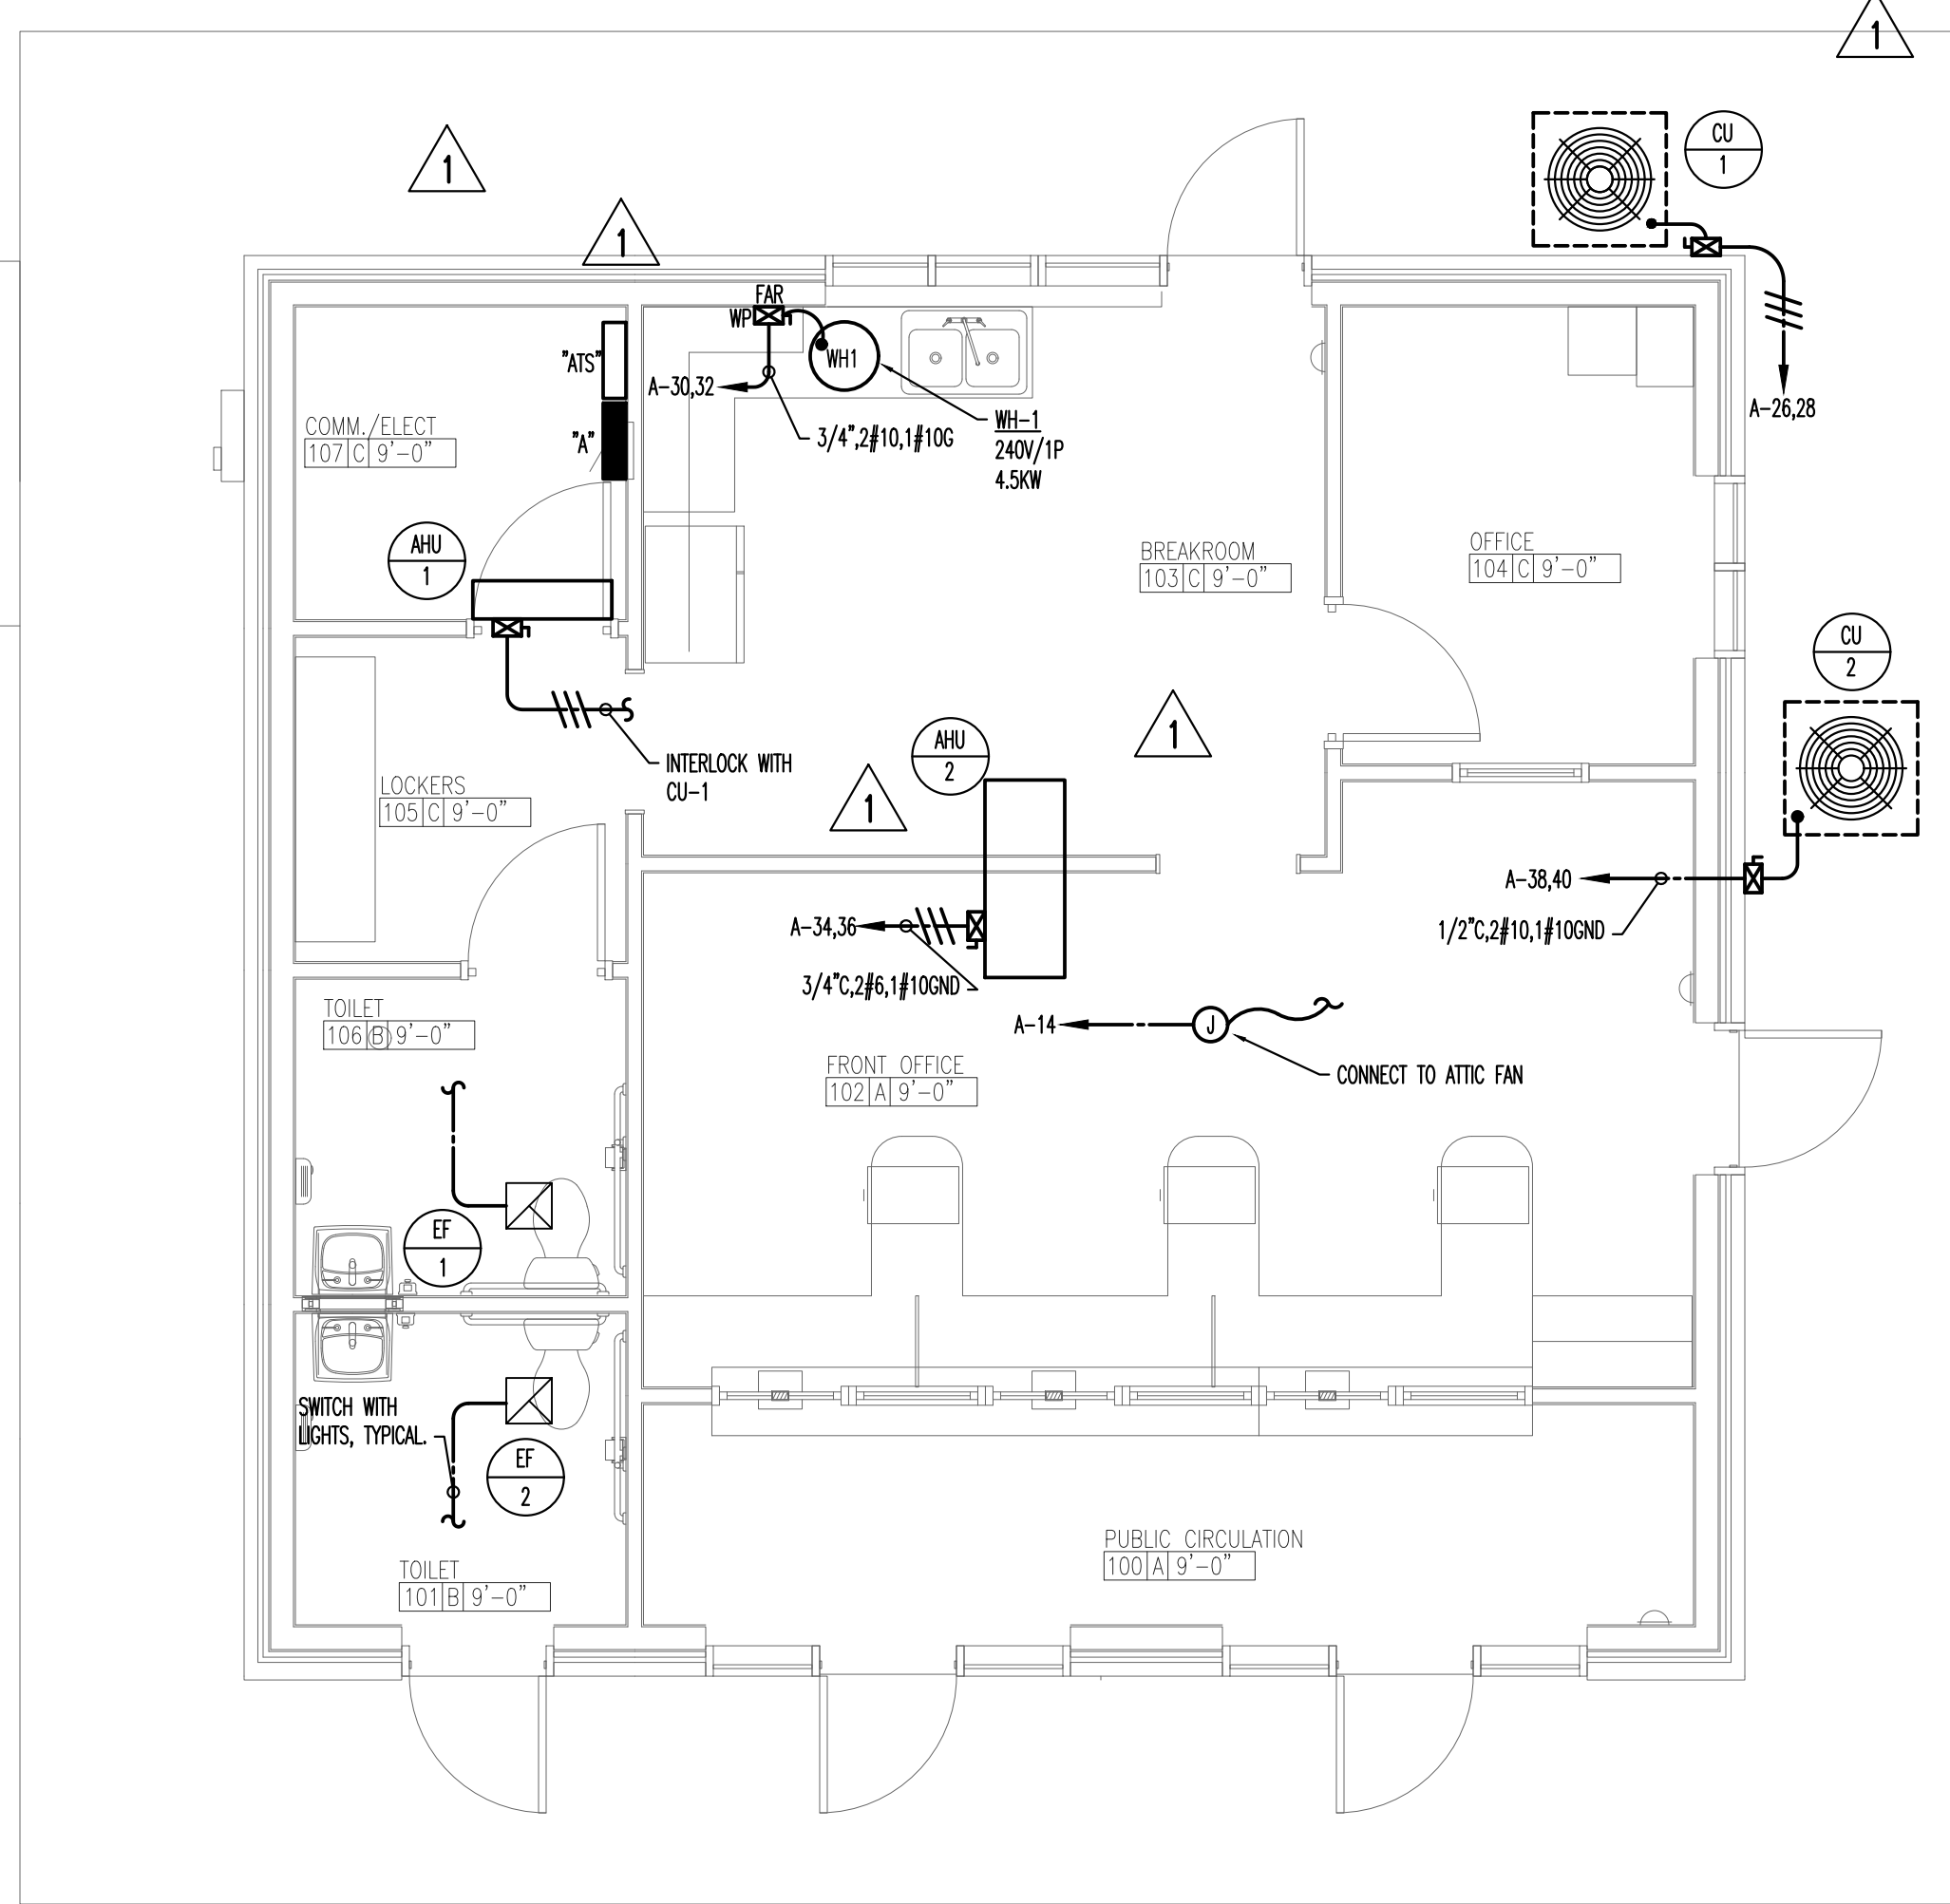

HVAC POWER PLAN

SCALE: 1/4"=1'-0"

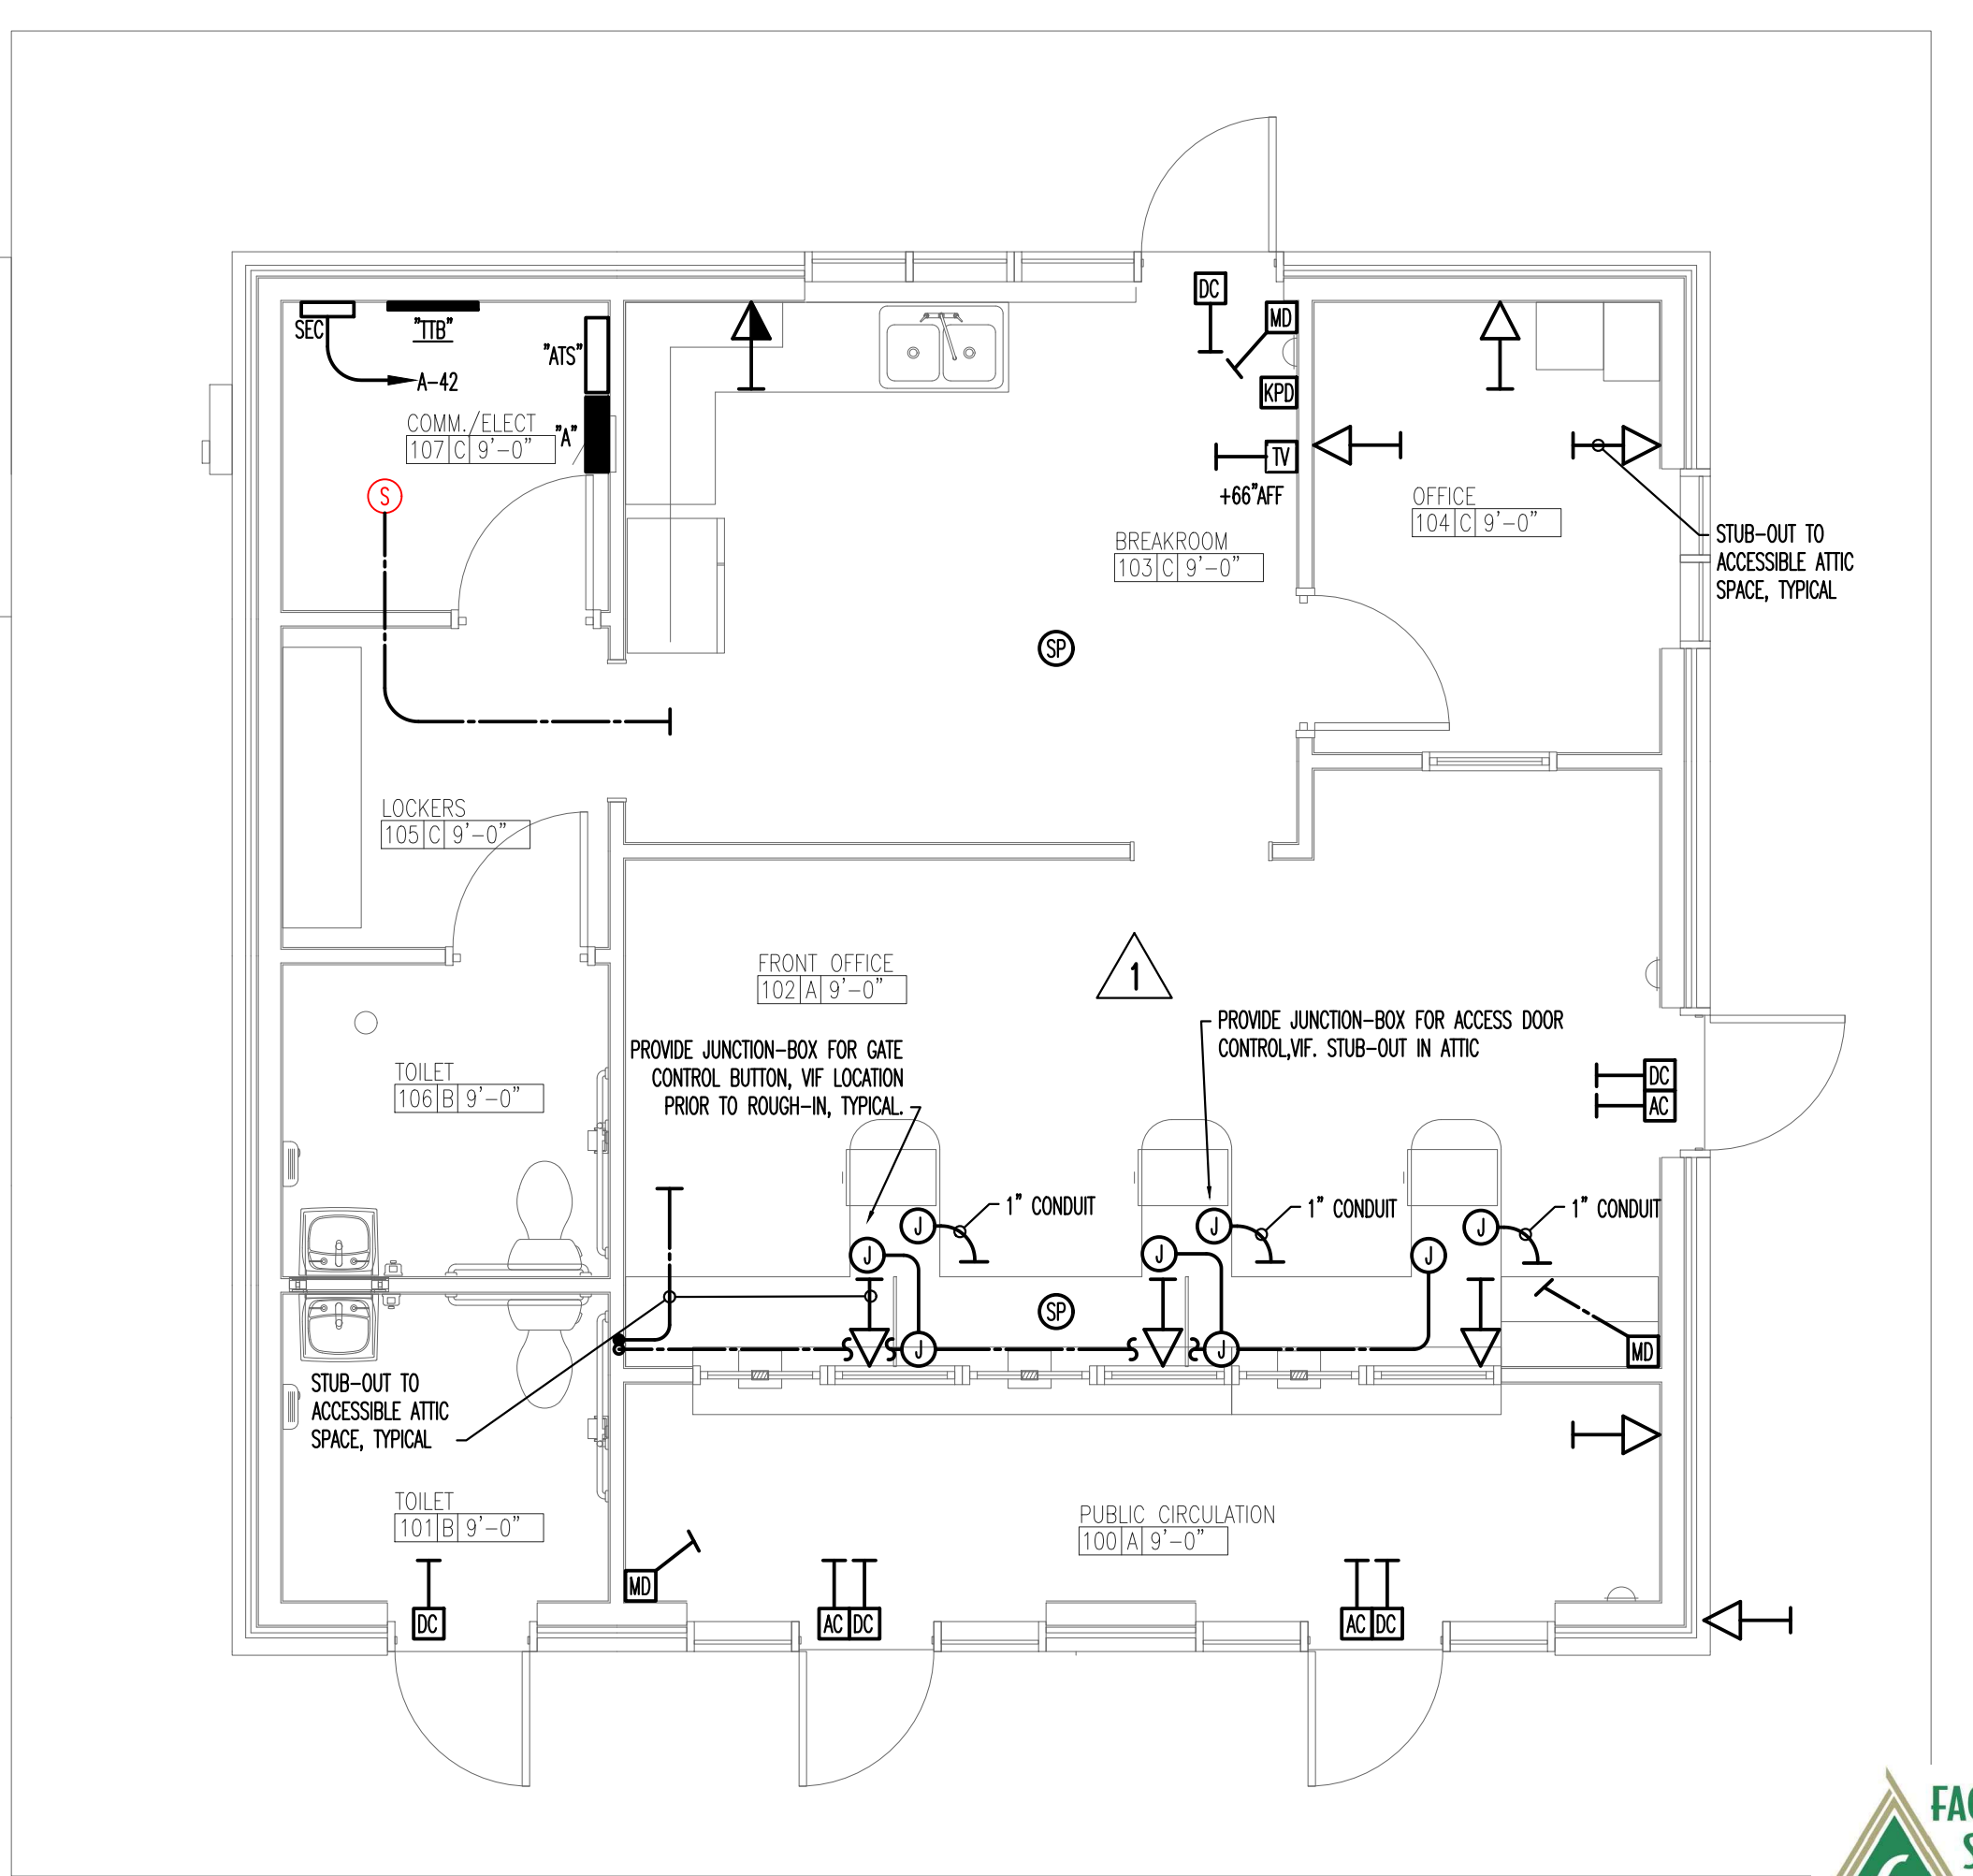


COMMUNICATIONS PLAN

SCALE: 1/4"=1'-0"

A NEW FACILITY FOR:
CITY OF KNOXVILLE
VEHICLE IMPOUNDMENT
 KNOXVILLE, TENNESSEE

WE DESIGN PROFESSIONAL WIRING AND ALL LABOR FOR ANY PROBLEMS WHICH MAY ARISE FROM FAILURE TO FOLLOW THESE PLANS, SPECIFICATIONS AND THE DESIGN OTHERS FAILURE TO OBTAIN AND/OR FOLLOW THE DESIGN PROFESSIONAL'S GUIDANCE WITH RESPECT TO ANY INCONSISTENCIES, AMBIGUITIES OR CONFLICTS WHICH ARE ALLEGED.

THOMAS CALDWELL, ARCHITECT
 6500 PAPERMILL DRIVE, SUITE 211
 KNOXVILLE, TENNESSEE 37919-4819
 (865) 588-0860 (865) 558-9844/FAX
 HTTP://WWW.TSCARCHITECT.COM

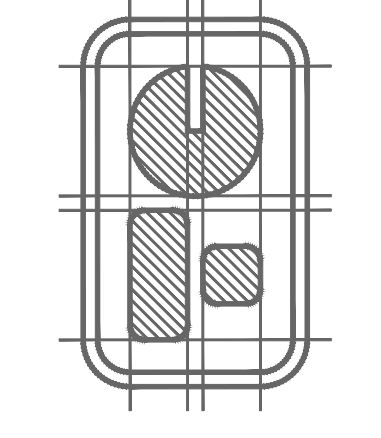

DRAWING NAME:
 ELECTRICAL PLAN

COPYRIGHT 2019

REVISION DATE:

1	04/26/19
2	05/23/19

DATE: 12/31/18

DRAWN BY: MTR

COMM. NO.: 1612

SHEET: 25 OF 25

DRAWING NO.: E101

