
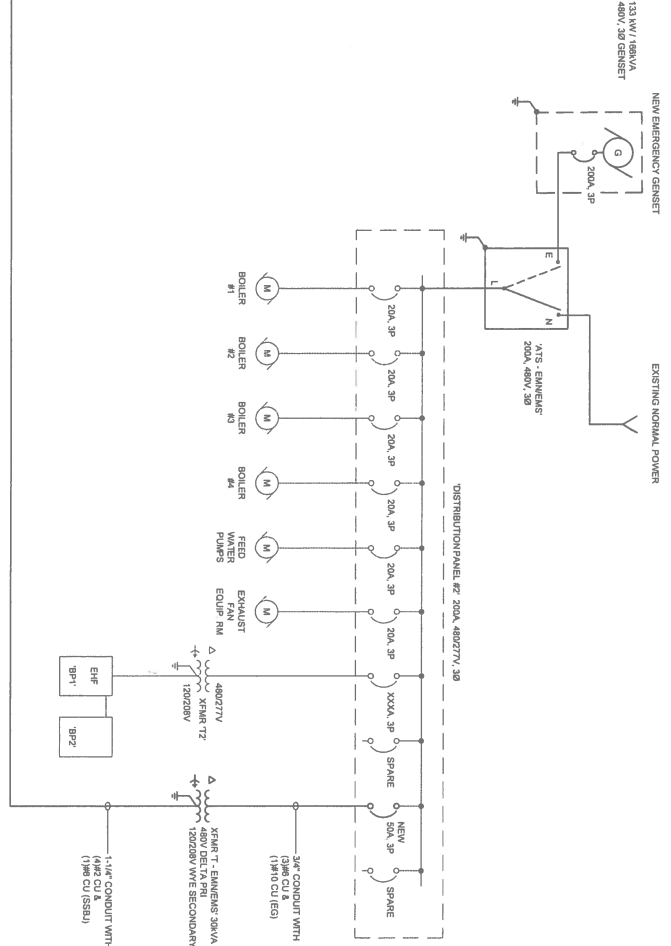
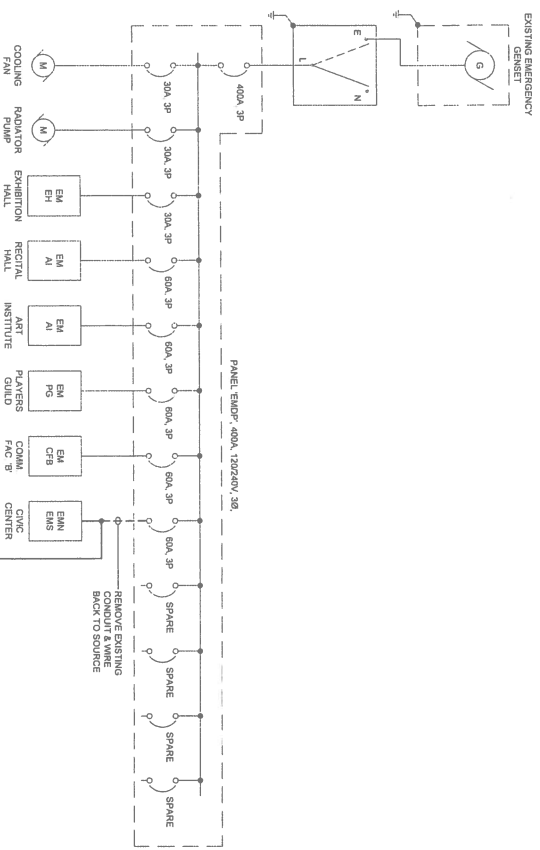


EXISTING POWER RISER DIAGRAM
NOT TO SCALE

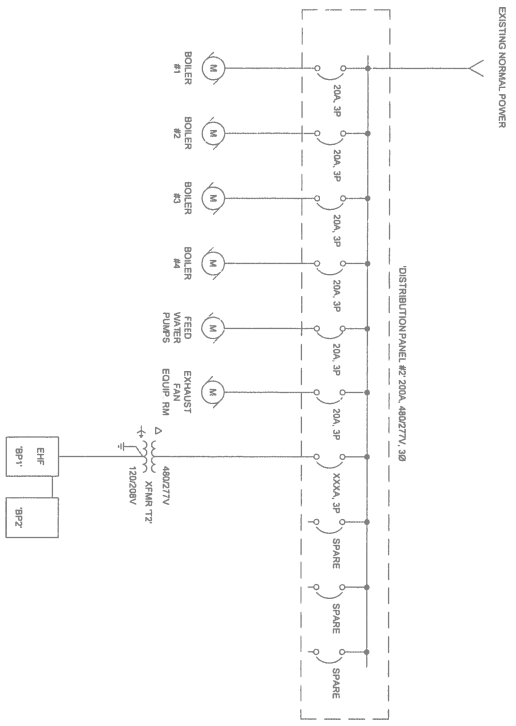

PROPOSED POWER RISER DIAGRAM OPTION #1
NOT TO SCALE

ENGINEER'S SEAL

CITY OF CANTON
CIVIC CENTER
1101 MARKET AVENUE NORTH
CANTON, OHIO 44702

PROJECT
GENERATOR
POWER

DESCRIPTION	DATE
DRAWING ISSUES/REVISIONS	
PRELIMINARY ONLY	XX-XX-XX
DRAWN BY PAQI CHECKED BY RBE	
JOB NO XXXXX SCALE AS NOTED	

TITLE
EXISTING PARTIAL
POWER RISER
WITH OPTION #1

SHEET
E 100

TRANSFER SWITCH


ATS
MDP-1

BPS
24 Hour Emergency Service
820.586.2825
KOHLER


POSITION
N OFF E
AVAILABLE

LAMP TEST	TIME DELAY	EXERCISE	TEST
TEST LAMP PRESS TO TEST LAMP OPERATION	PRESS TO DELAY	PRESS TO EXERCISE	PRESS TO TEST

330-633-1410
330-966-2500

DANGER
PELIGRO

WARNING: This equipment contains high voltage electrical components. Improper handling or maintenance can result in severe injury or death. Only qualified personnel should perform maintenance on this equipment.

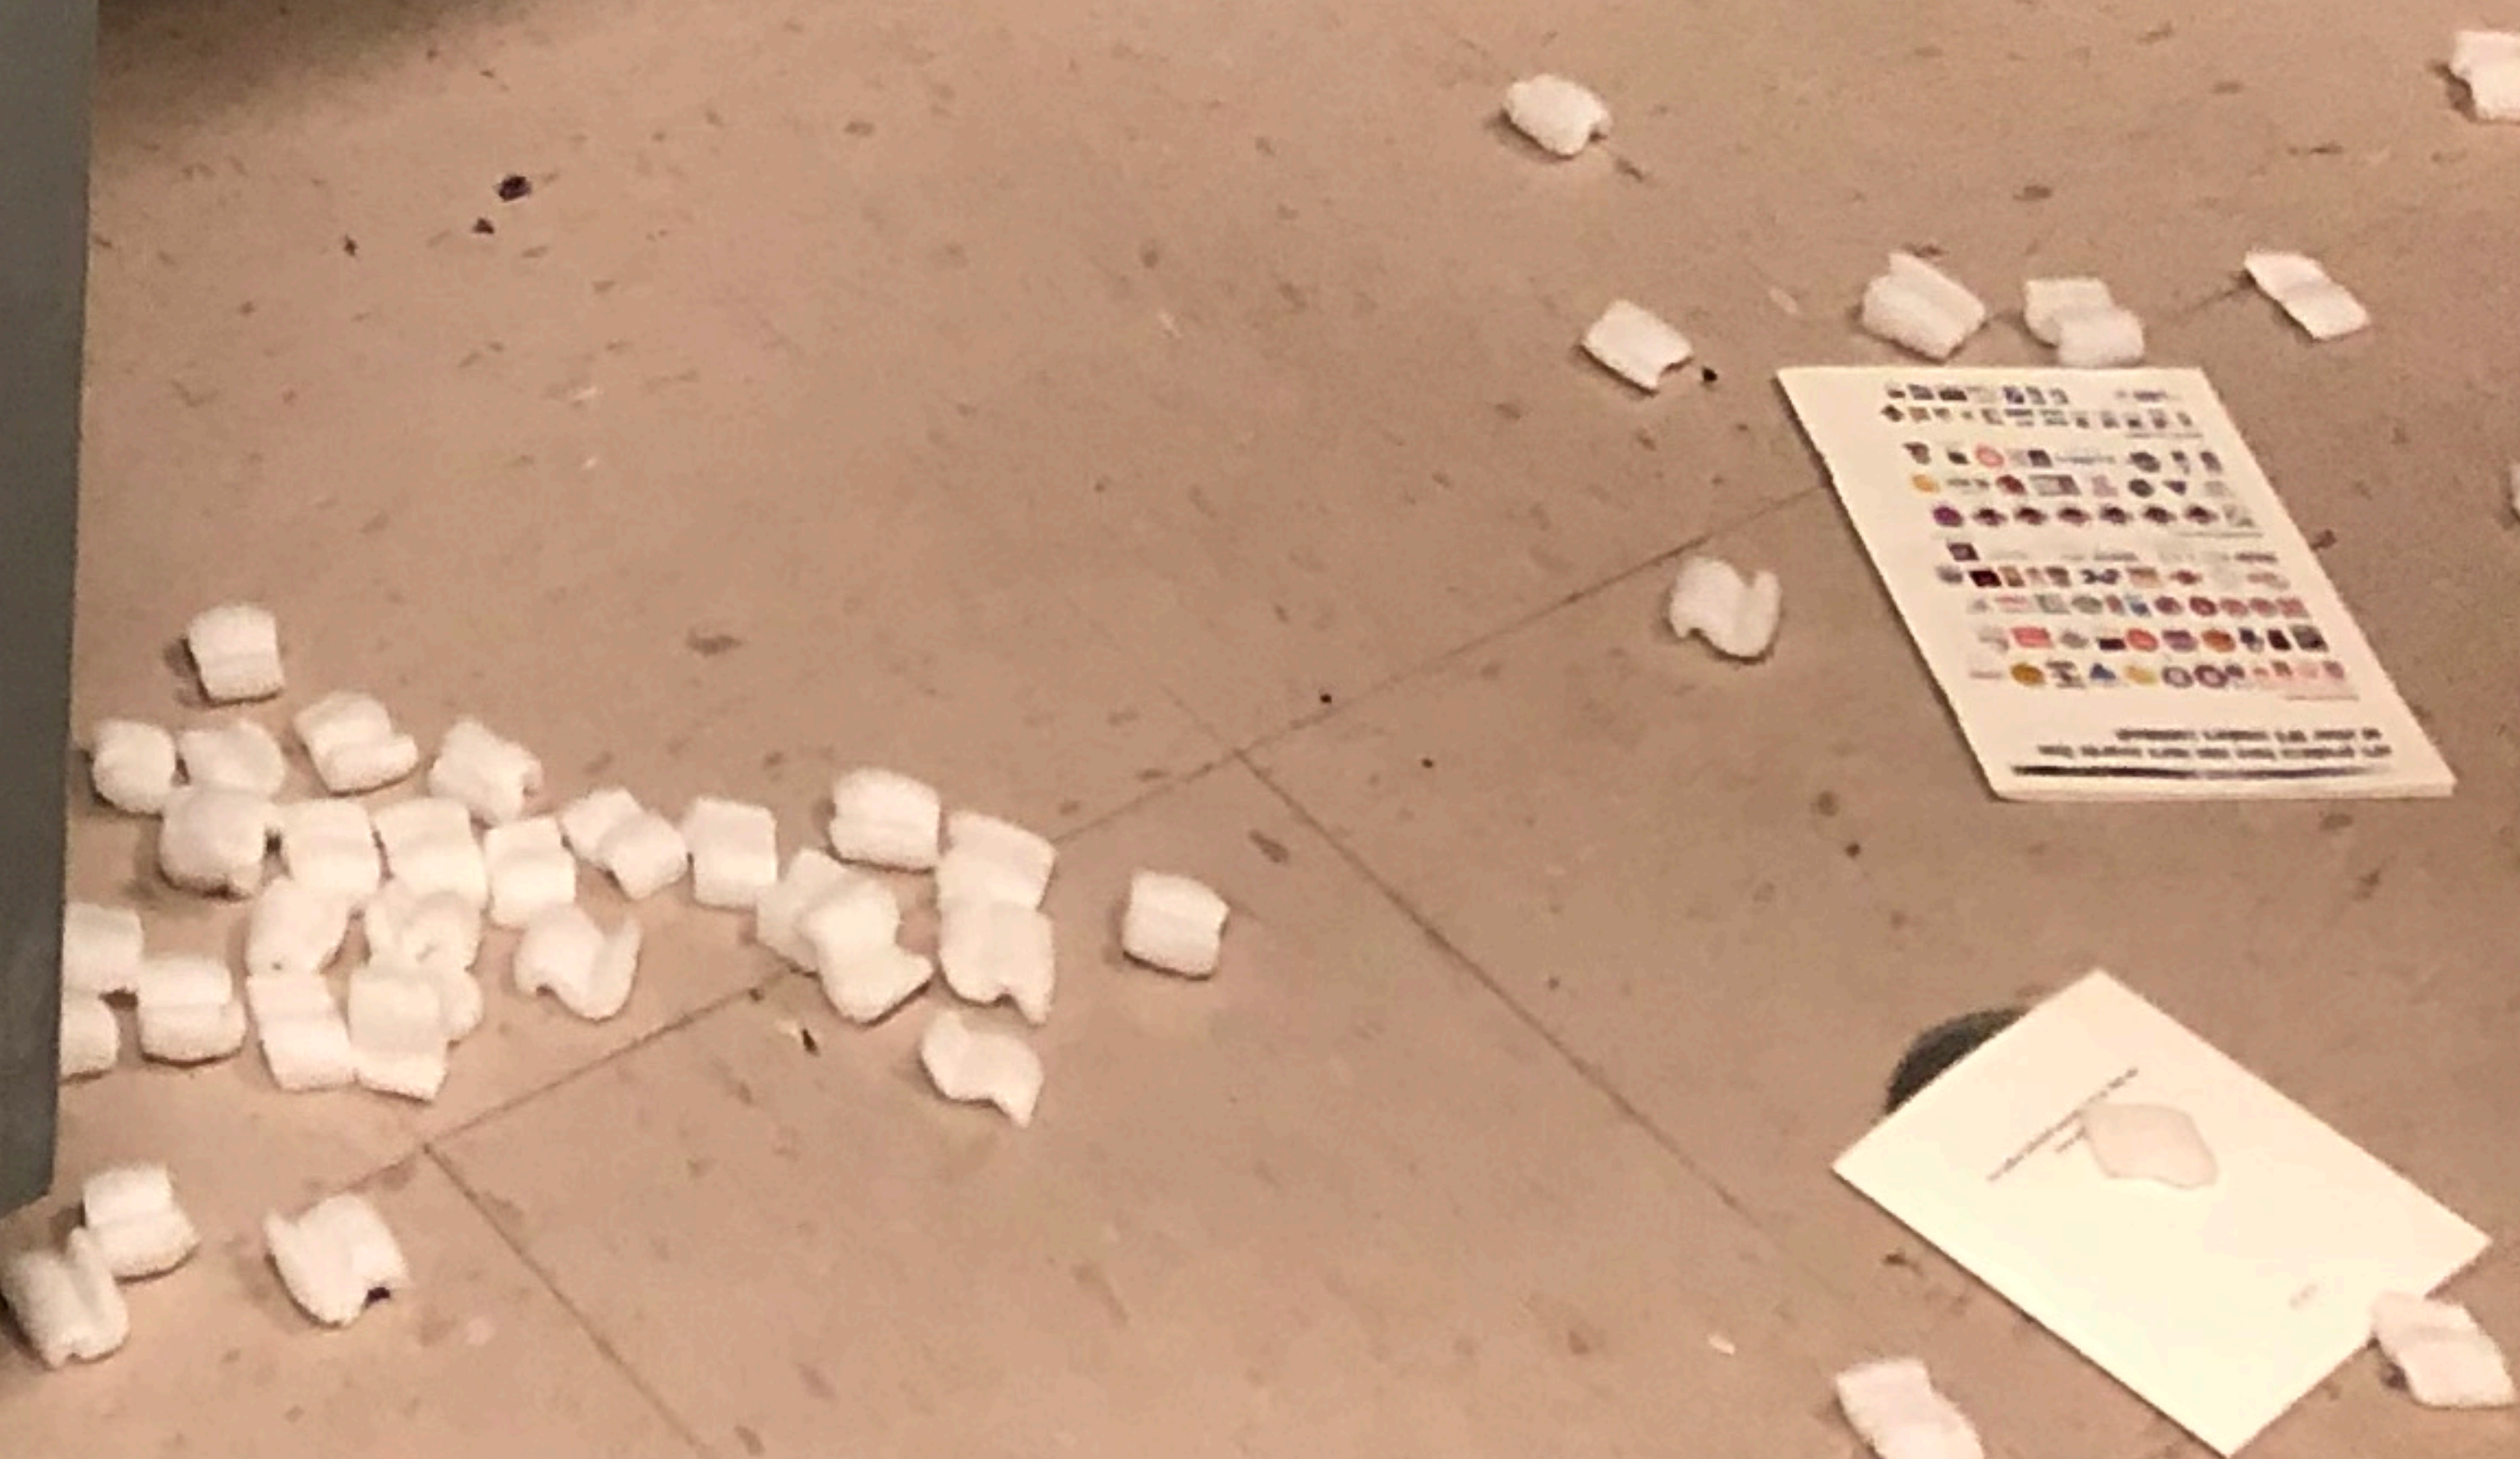KOHLER® SYSTEMS



TRANSFER SWITCH

ATS
MDP-1

BPS
Buckley Power Solutions
SALES SERVICE PARTS RENTAL
24 Hour Emergency Service
800 966 2825
FACTORY AUTHORIZED TECHNICIAN
KOHLER POWER SYSTEMS

POSITION
SOURCE N OFF SOURCE E
AVAILABLE


SERVICE REQUIRED LOAD CONTROL TEST AT PLANT


LAMP TEST HOLD FOR 5 SEC TO RESET SERVICE RESET FAULT REJECTION PUSH TO TEST / RESET	TIME DELAY 100% 75% 50% 25% PUSH TO STOP	EXERCISE NO LOAD PUSH TO TEST / STOP	TEST NO LOAD PUSH TO TEST / STOP
---	--	---	---

330-633-1410
330-966-2500

⚠ DANGER
⚡ PELIGRO
WARNING: This equipment contains high voltage electrical components. Only qualified personnel should perform maintenance or repair work. Failure to follow safety procedures may result in severe injury or death.


KOHLER® POWER SYSTEMS

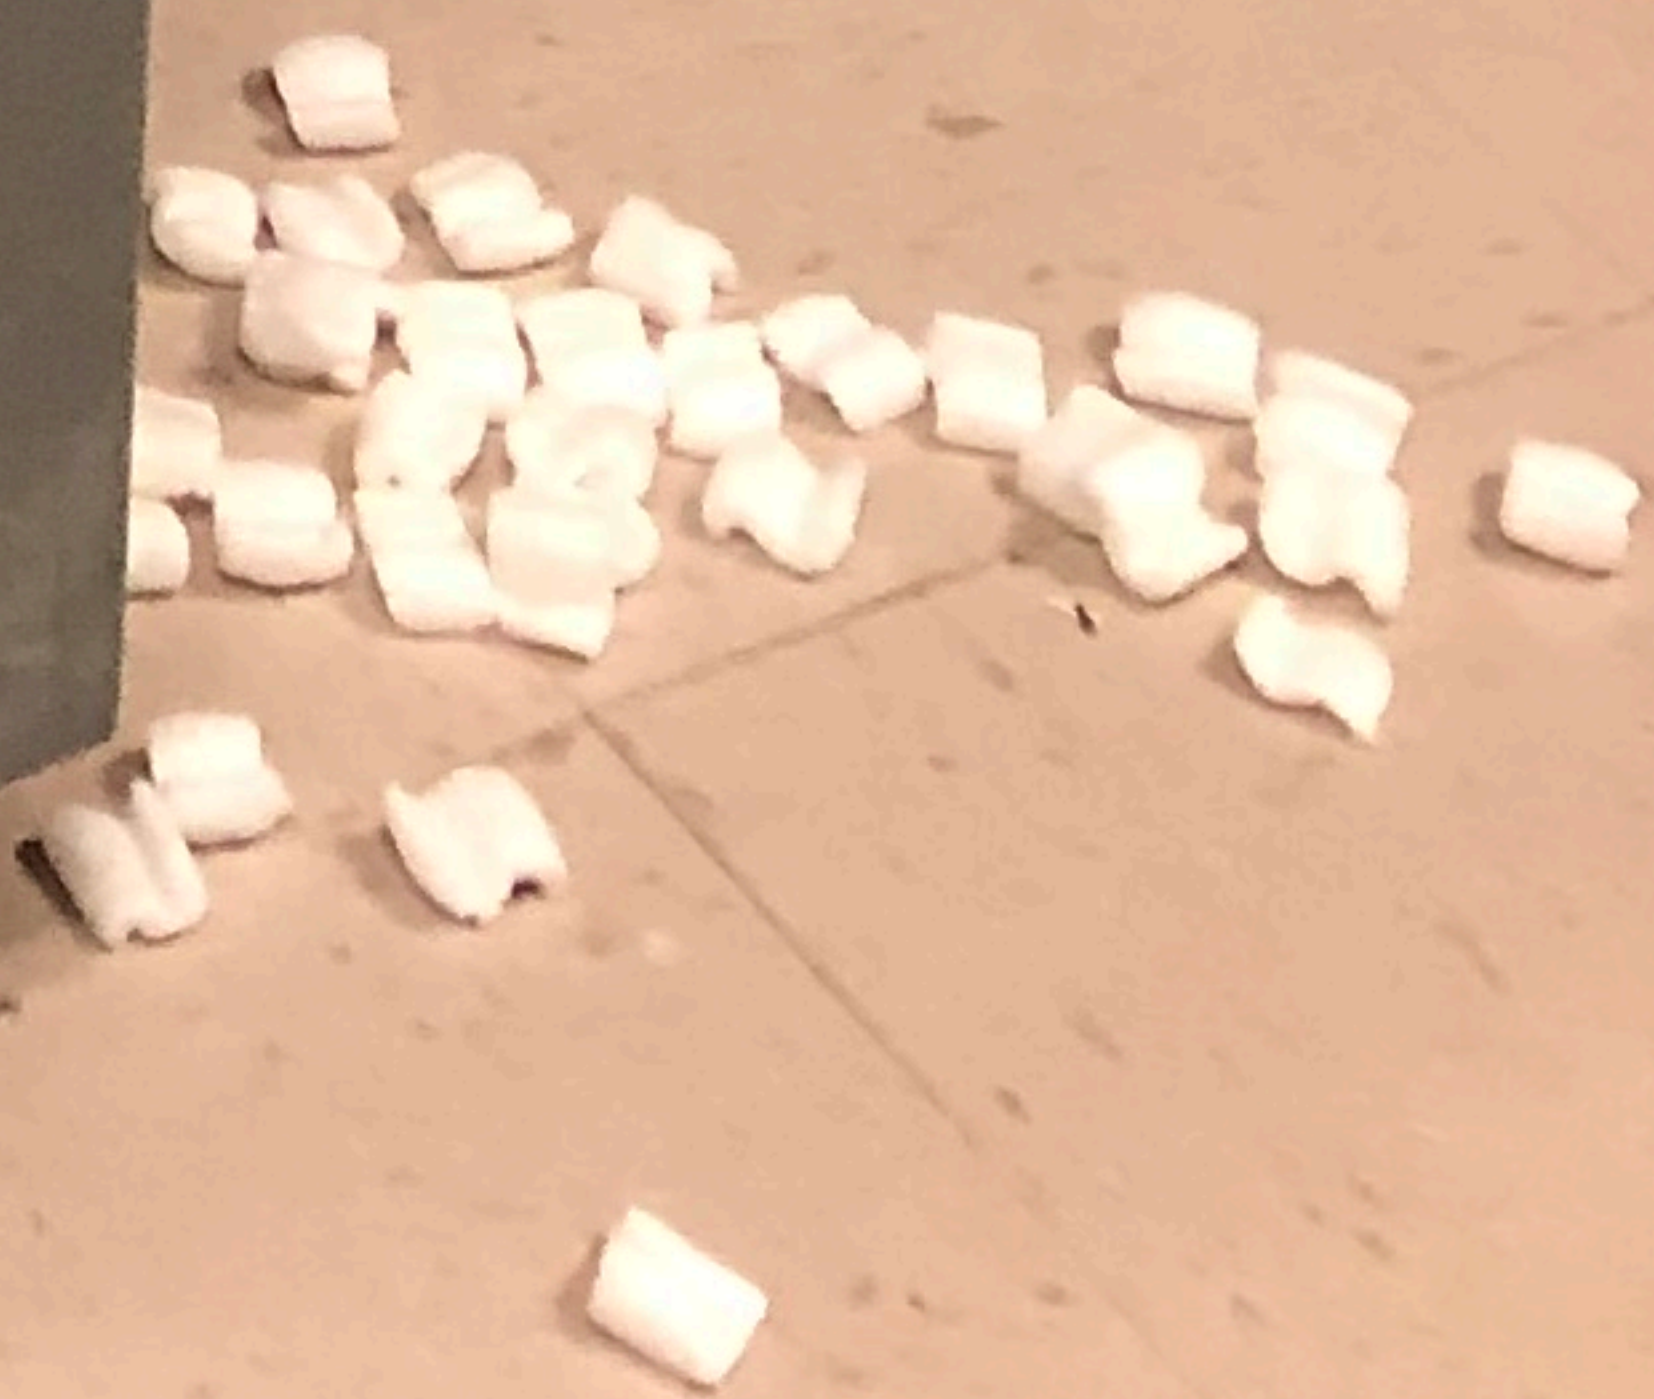

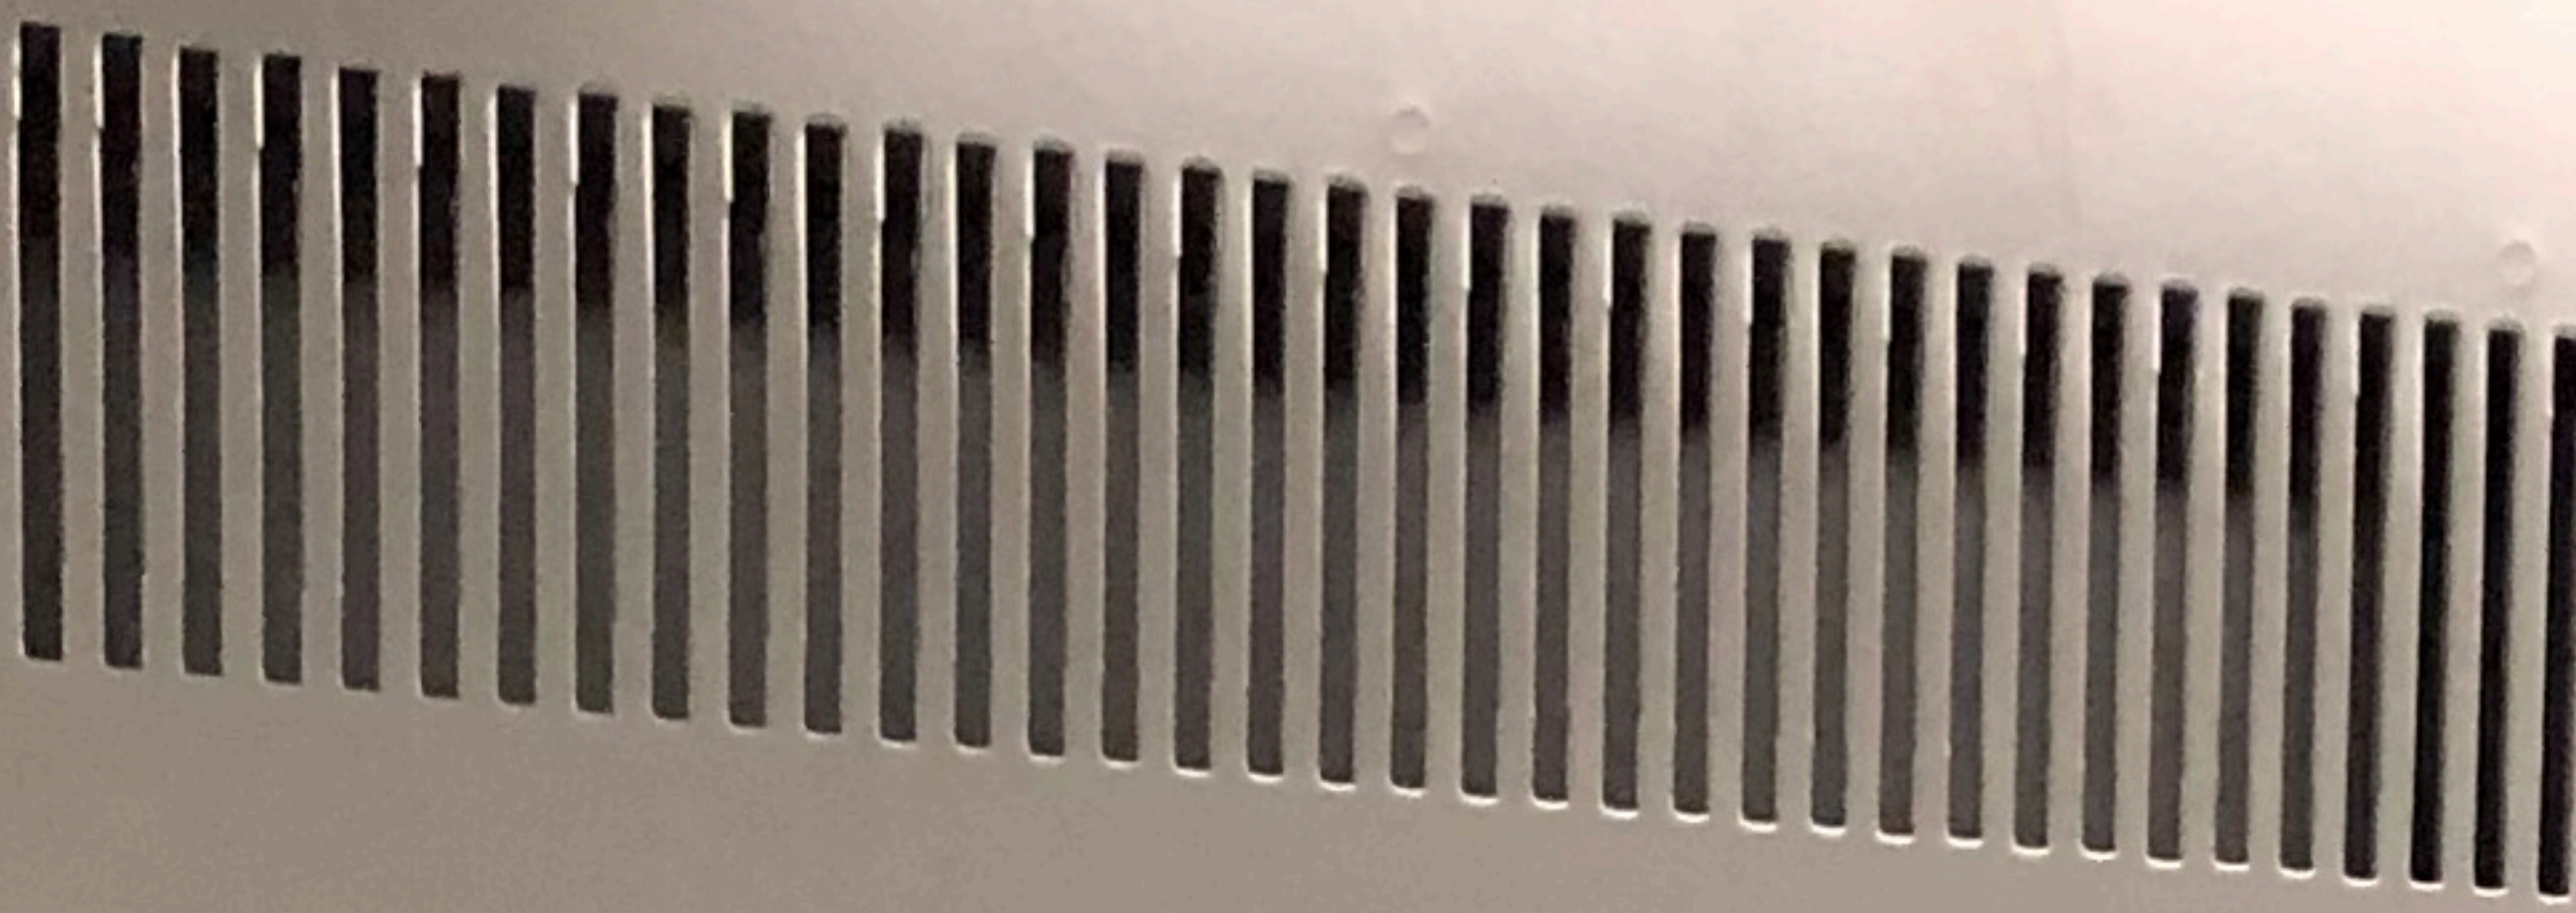


MDP-1

24 HOUR EMERGENCY SERVICE
SPEELMAN ELECTRIC
Creating Comfort for Life
 www.speelmanelectric.com
 TALLMADGE
330-633-1410
 CANTON
330-966-2500

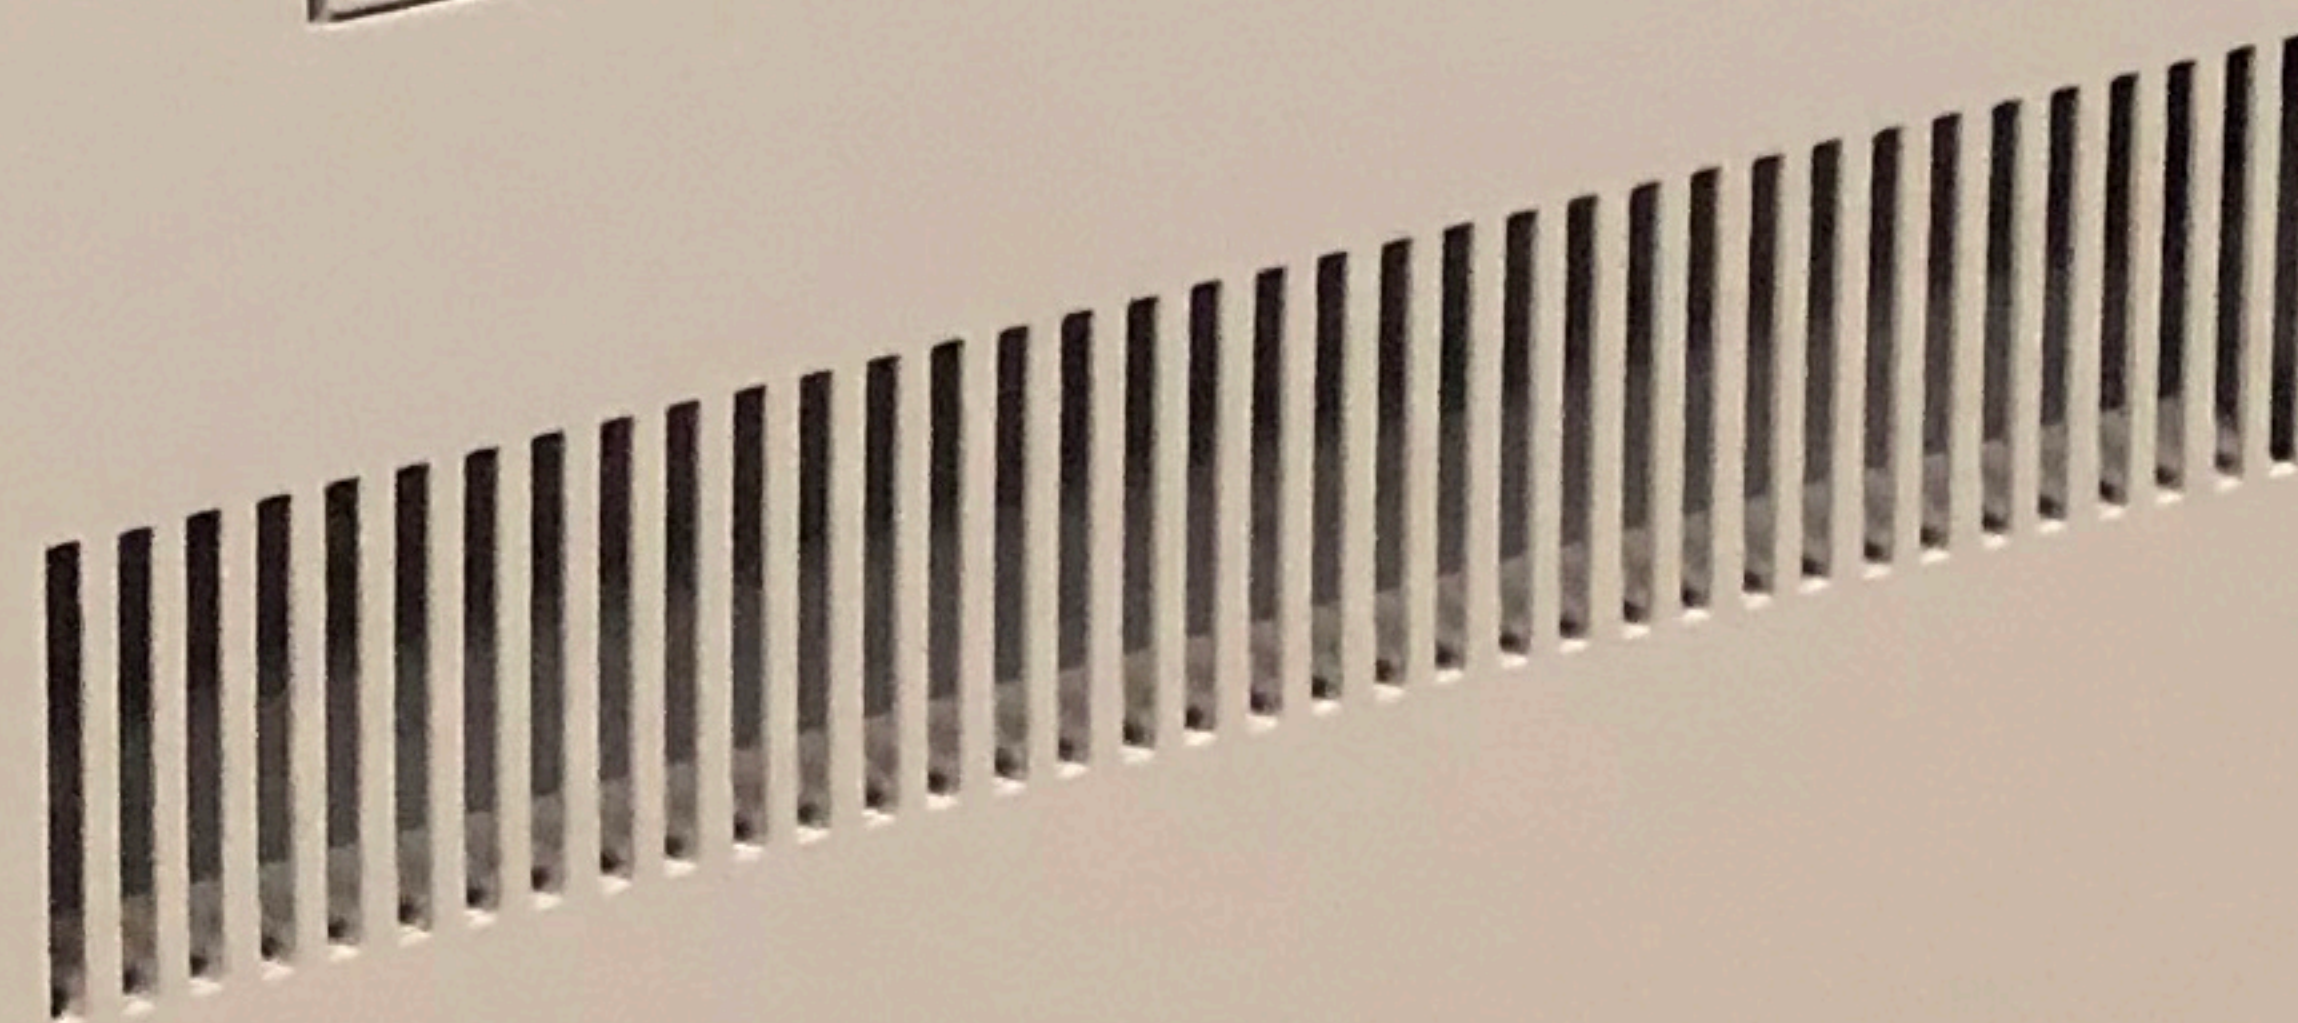

SIGN &
OUT-
SIDE
LIGHT-
TABS
UNIT

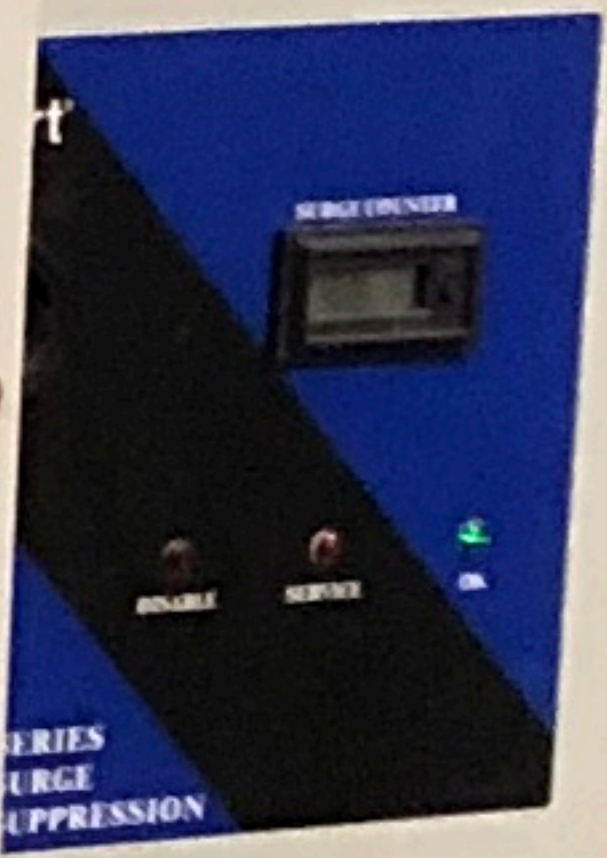

Panel G

 LI