
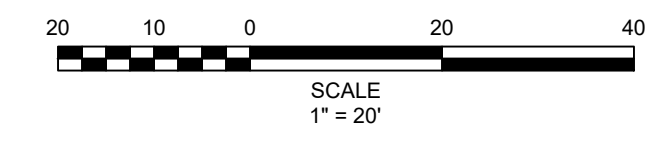


LEGEND:

---	EXISTING SINGLE PHASE SECONDARY/SERVICE	SS	SANITARY SEWER
---	EXISTING THREE PHASE SECONDARY/SERVICE	SD	STORM DRAIN
---	EXISTING THREE PHASE PRIMARY	G	GAS
⊕	ELECTRIC METER	UGT	UG TELEPHONE
⊙	DECORATIVE LIGHT	CB	CATCH BASIN
P	OH POWER	MH	MANHOLE
T	OH TELEPHONE	FH	FIRE HYDRANT
P&T	OH POWER & TELEPHONE	PP	POWER POLE
W	WATER	#####	DOCKS

NOTES:

1. THIS DRAWING BASED ON DOWNTOWN GEORGETOWN REVITALIZATION PROJECT, PLAN - FRONT STREET ELECTRICAL, DRAWINGS 1-14.

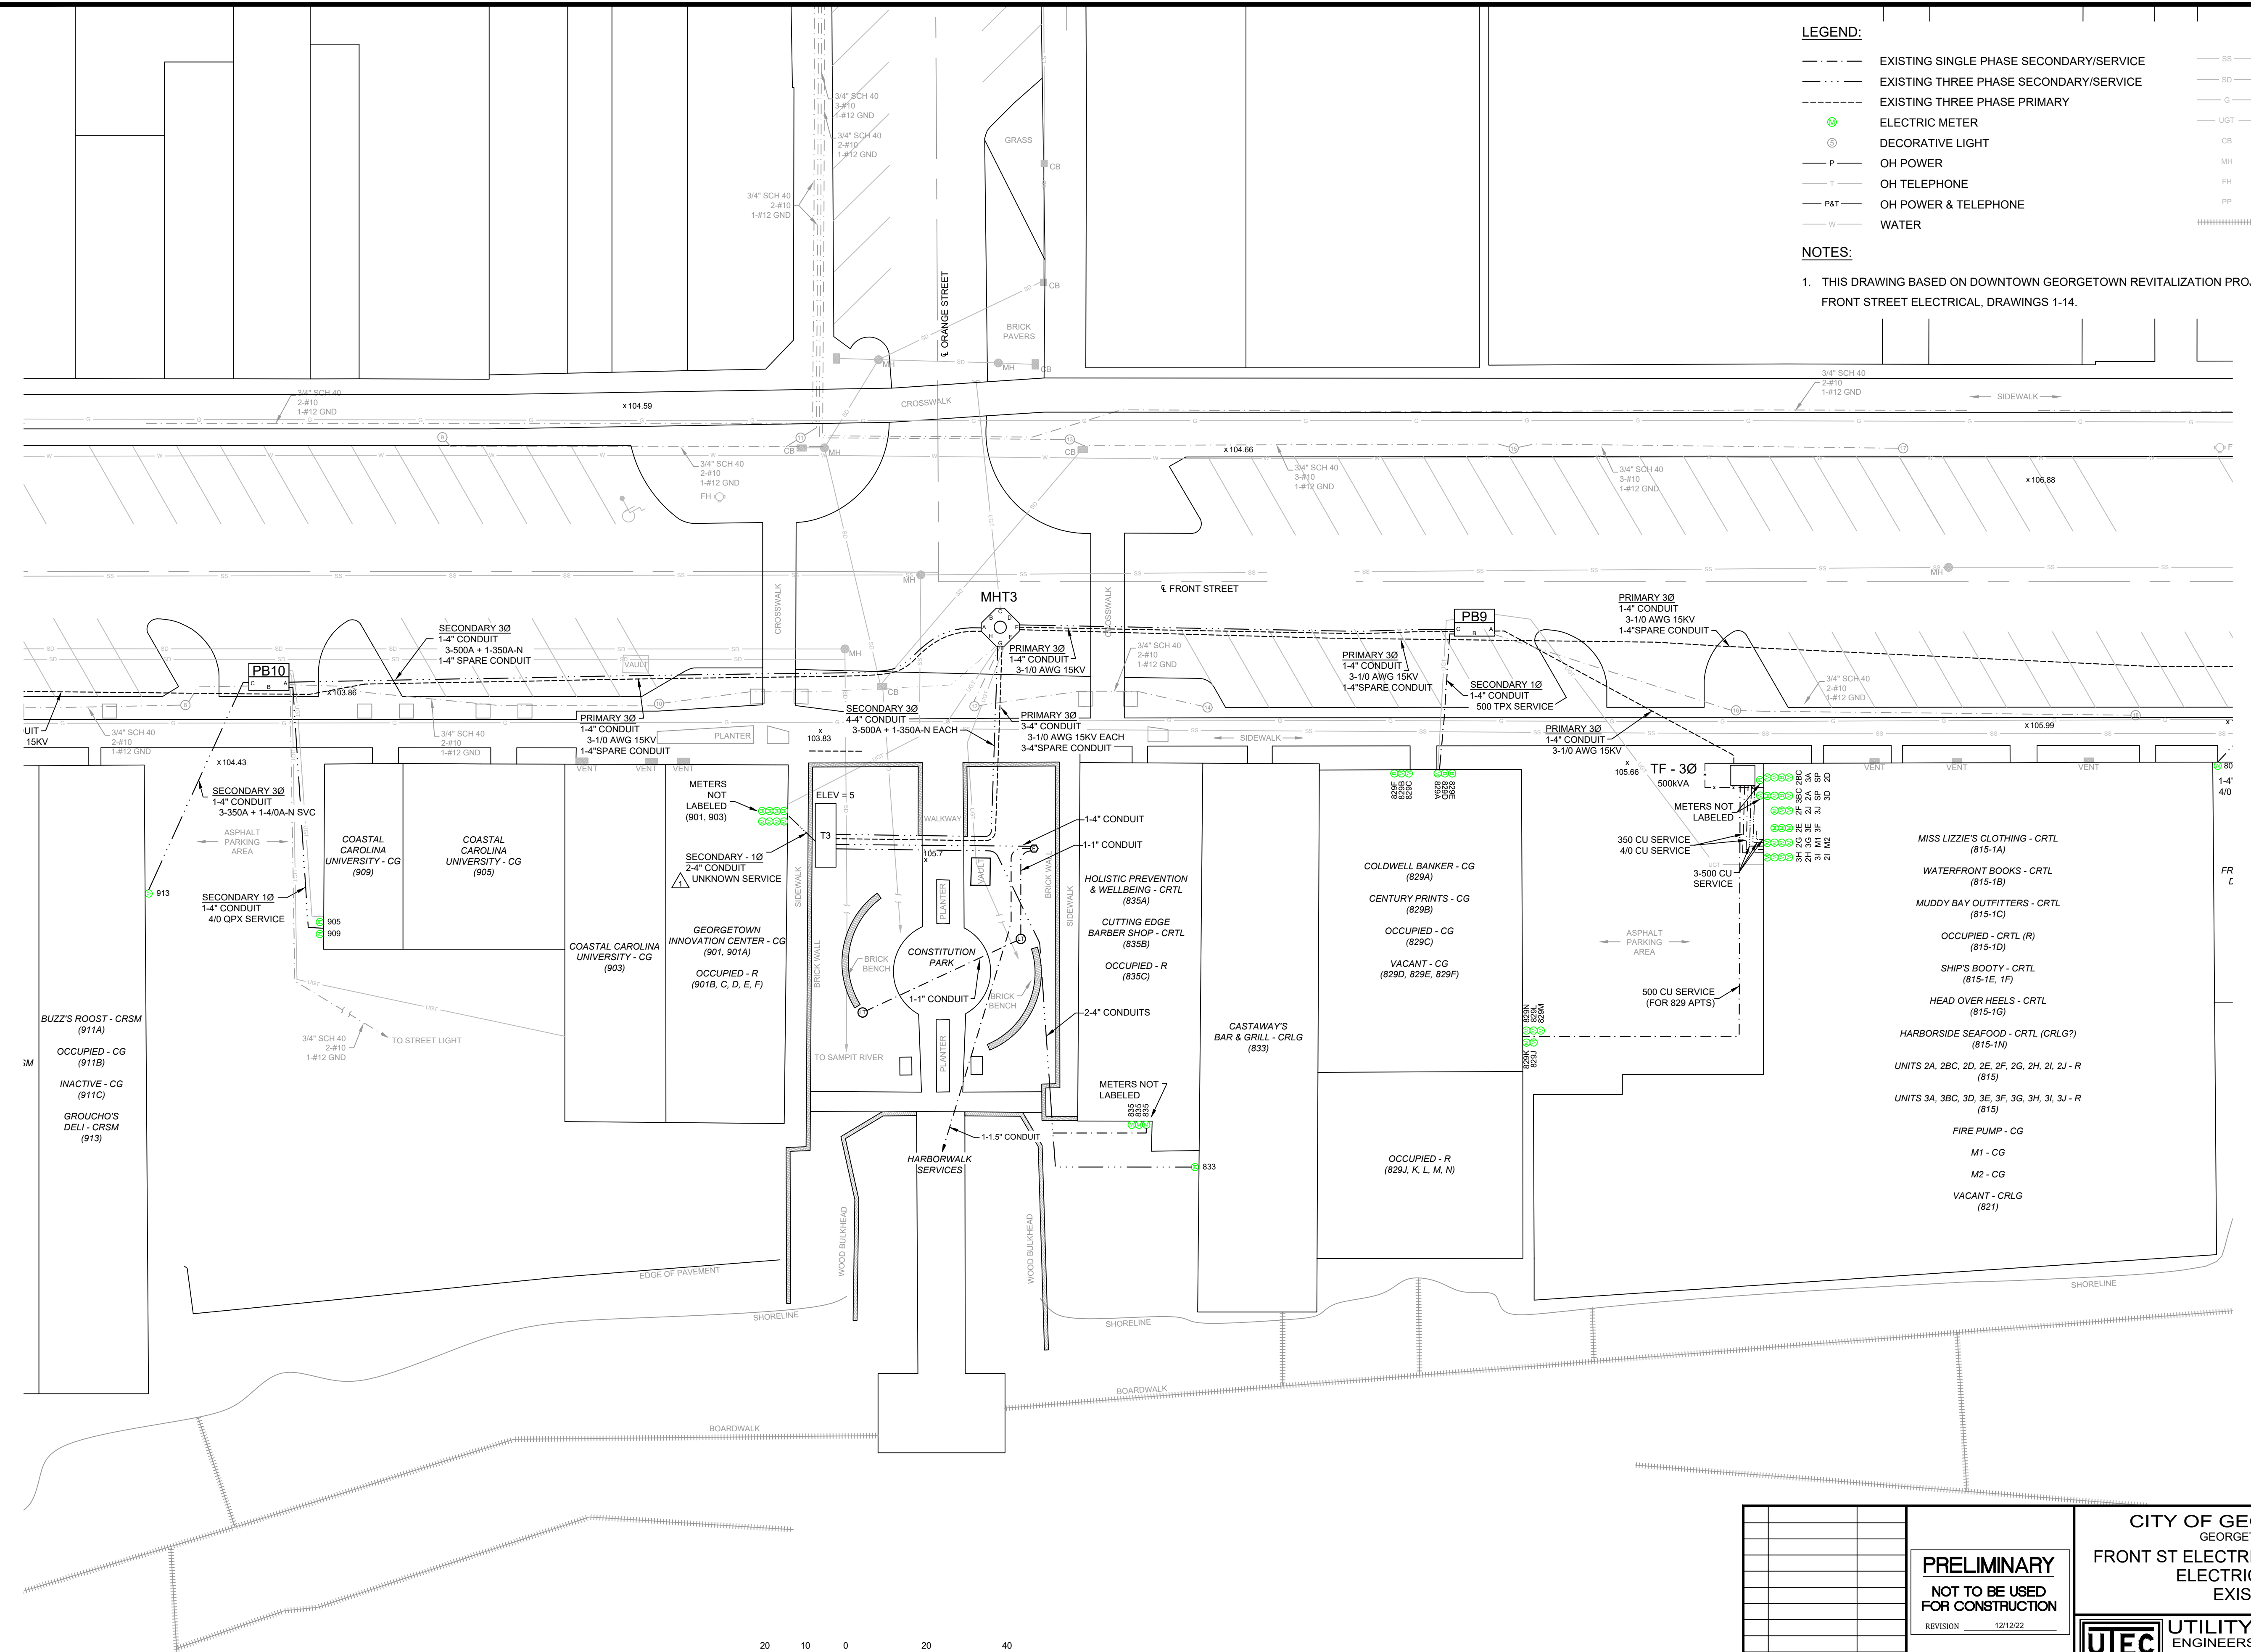

NO.	REVISIONS	DATE
1	ADDENDUM 1	12/15/22
0	BID ISSUE	12/01/22

PRELIMINARY
NOT TO BE USED FOR CONSTRUCTION
 REVISION 12/12/22

CITY OF GEORGETOWN
 GEORGETOWN, SC
FRONT ST ELECTRIC UPGRADE - PH. 2
ELECTRICAL PLAN
EXISTING

UTEC UTILITY TECHNOLOGY ENGINEERS - CONSULTANTS, PLLC
 P.O. Box 2629 • Asheboro, North Carolina • 27204

EDW	LMB	DATE: 10/31/22	DWG. NO. E2002
SCALE: 1" = 20'	JOB NO. 220901	SHEET NO. 1 OF 1	

Dec 14, 2022 - 2:24pm X:\Georgetown\Front St\Phase 2\E2002\FSD Electrical Plan Existing Rev 1.dwg Layout E2002