
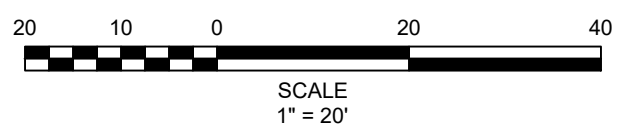


NOTES:

- THIS DRAWING BASED ON DOWNTOWN GEORGETOWN REVITALIZATION PROJECT, PLAN - FRONT STREET ELECTRICAL, DRAWINGS 1-14.

LEGEND:

- | | | | |
|-------|------------------------------------|---------|----------------------|
| --- | EXISTING SINGLE PHASE SERVICE | — P&T — | OH POWER & TELEPHONE |
| --- | EXISTING THREE PHASE SERVICE | — W — | WATER |
| --- | EXISTING THREE PHASE PRIMARY | — SS — | SANITARY SEWER |
| --- | NEW SINGLE PHASE SECONDARY/SERVICE | — SD — | STORM DRAIN |
| --- | NEW THREE PHASE SECONDARY/SERVICE | — G — | GAS |
| --- | NEW THREE PHASE PRIMARY | — UGT — | UG TELEPHONE |
| ⊙ | ELECTRIC METER | CB | CATCH BASIN |
| ⊙ | DECORATIVE LIGHT | MH | MANHOLE |
| — P — | OH POWER | FH | FIRE HYDRANT |
| ○ | NEW 6" CONCRETE BOLLARD | PP | POWER POLE |
| — T — | OH TELEPHONE | | DOCKS |

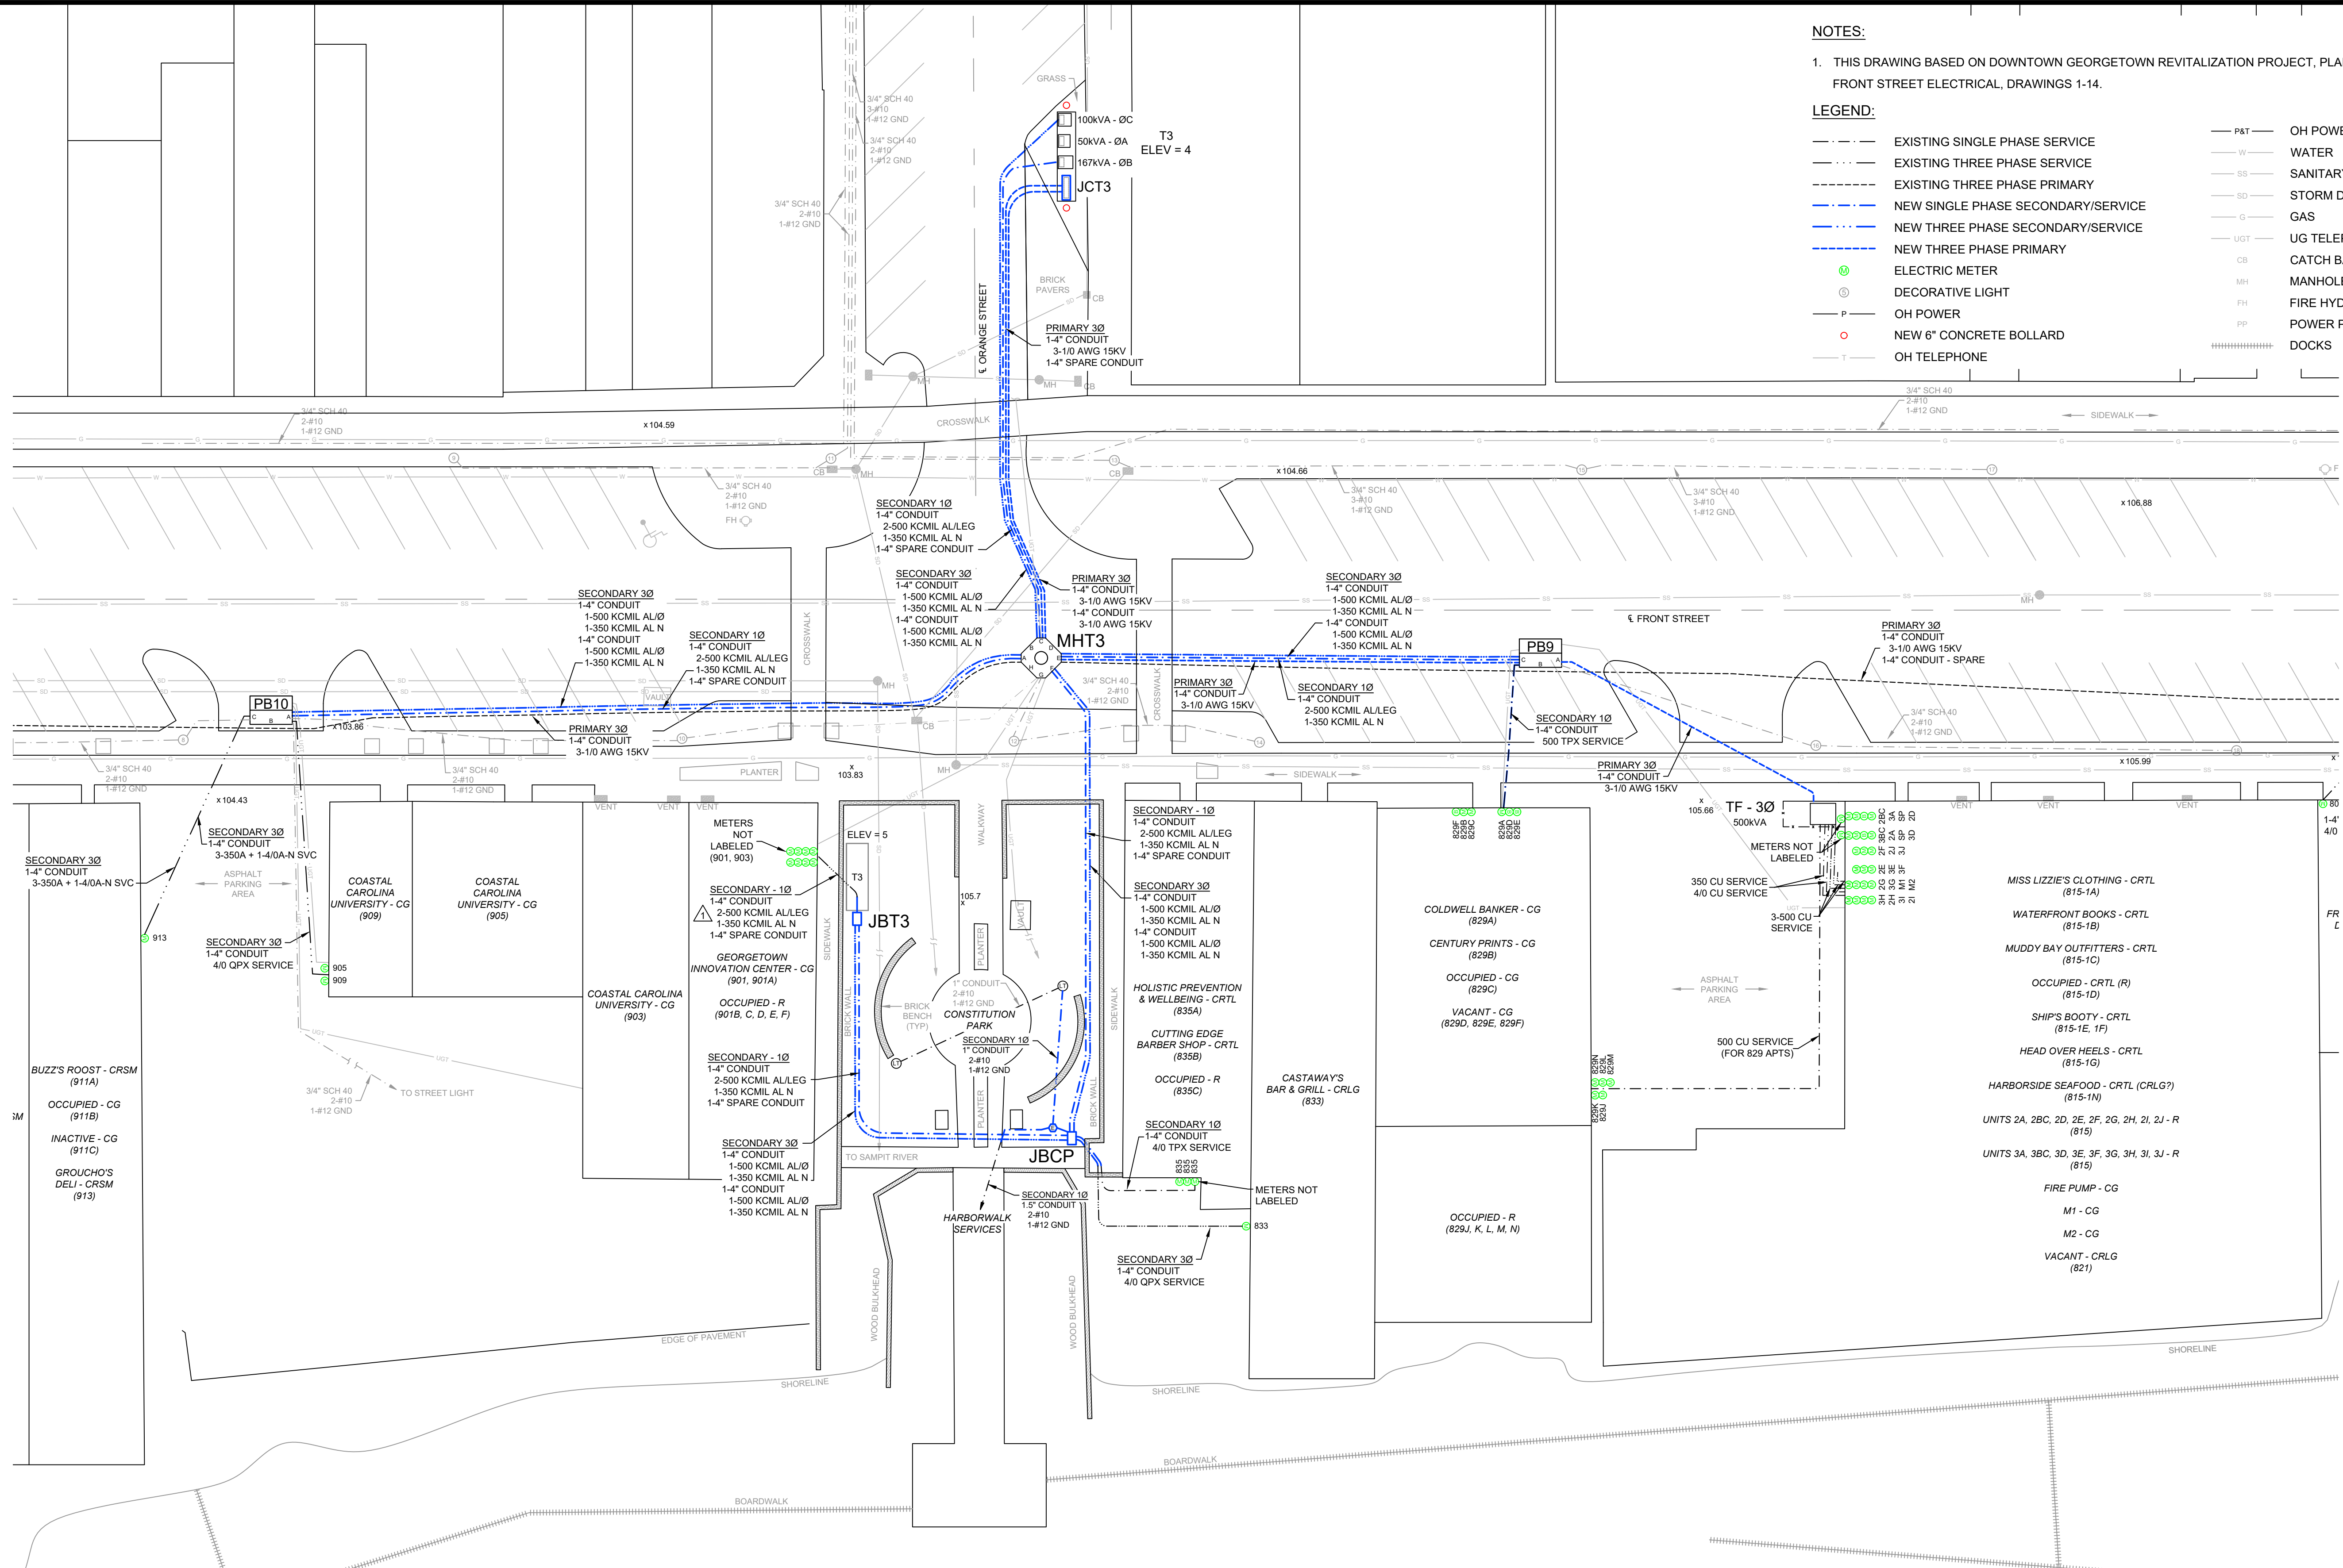

NO.	REVISIONS	DATE
1	ADDENDUM 1	12/15/22
0	BID ISSUE	12/01/22

PRELIMINARY
NOT TO BE USED FOR CONSTRUCTION
 REVISION 12/12/22

CITY OF GEORGETOWN
 GEORGETOWN, SC
FRONT ST ELECTRIC UPGRADE - PH. 2
ELECTRICAL PLAN
NEW

UTILITY TECHNOLOGY ENGINEERS - CONSULTANTS, PLLC
 P.O. Box 2629 • Asheboro, North Carolina • 27204

E2003
 SCALE: 1" = 20'
 JOB NO. 220901
 SHEET NO. 1 OF 1

Y:\Georgetown\Phase 2\2020\ESB\Electrical\Plan New Rev 1.dwg Layer: E2003
 Dec 14, 2022 2:22pm