


ELECTRICAL PLAN 1/4"=1'-0"

ELECTRICAL SCHEDULE		
ITEM	K. WATTS	REMARKS
GEN. LTG. @ 3W. =	5.1	
A.C.	10.0	
RANGE	10.0	
REF.	1.0	
D.W.	1.2	
DISP	1.0	
W.H.	4.5	
WASH & DRY	5.0	
SM. APPL.	3.0	
SPARES	3.0	
CEILING FANS	1.6	
TOTAL K.W./S	45.4	
RANGE + A.C. + 10 =	30	
REM. @ 40%	6.2	
TOTAL L/D/D	36.2	
TOTAL AMPS	157.4	INSTALL 200AMP SERVICE

ELECTRICAL LEGEND

SYMBOL	DESCRIPTION
○	RECESSED LIGHT FIXTURE
○	CEILING LIGHT FIXTURE
○	WALL MOUNTED LIGHT FIX.
⚡	ONE POLE SWITCH
⚡	SWAY SWITCH
⚡	DUPLEX OUTLET
⚡	DUPLEX OUTLET-SPLIT WIRE
⚡	GROUND-FULTI DUPLEX OUTLET
⚡	GROUND-FULTI DUPLEX OUTLET WATER PROOF
⚡	SPECIAL PURPOSE 250V OUTLET
⚡	TELEPHONE OUTLET
⚡	FLOOR LIGHTS
⚡	SMOKE DET.
⚡	2X4 FLOOR FIX.
⚡	1X4 FLOOR FIX.
⚡	EXHAUST FAN
⚡	GARAGE DOOR OPE. RECPER.
⚡	A/C DISCONNECT
⚡	CARBON MONOXIDE DETECTOR

NOTES:  
 1. ELECTRICAL CONTRACTOR SHALL COORDINATE ELECTRICAL METERS AND MAIN DISCONNECT WITH LOCAL POWER COMPANY REPRESENTATIVE.  
 2. MAIN DISCONNECT SHALL BE INSTALLED IN THE GARAGE ABOVE THE ELECTRICAL PANEL BOX.  
 3. SMOKE DETECTORS SHALL BE INTERCONNECTED SO THAT THE DETECTOR ALARMS TO SOUND BELL OR SMALL CHIME ALL THROUGHOUT THE ENTIRE SPACE.  
 4. PROVIDE ARCH-FULT PROTECTION ON ALL BEDROOM AND OUTSIDE ALL BEDROOMS.  
 5. ELECTRICAL NOTE: ALL SMOKE DET. TO BE HARD WIRED, W/ BATTERY BACK-UP AND SOUND ALARM IN ALL BEDROOMS AND OUTSIDE ALL BEDROOMS.

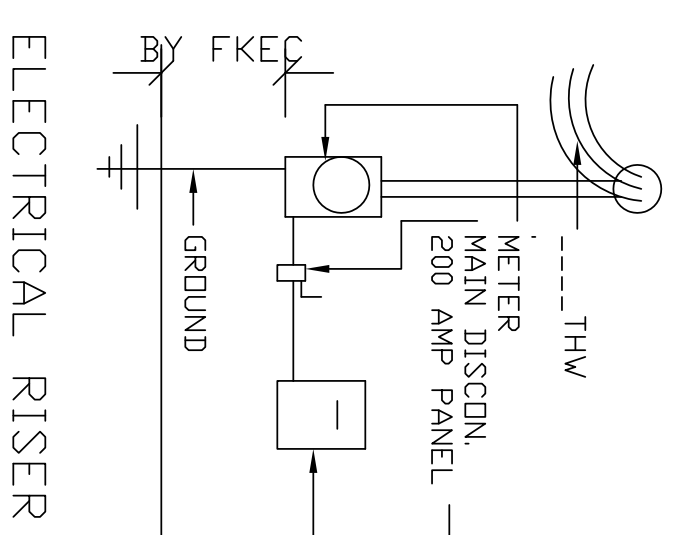

COMM NUMBER

DATE  
 REVISED

HANDY HELPER DRAFTING  
 386-846-2450

CERTIFIED BY:  
 DAVID C. LEETE  
 ARO00731

DUHART ULYSSES & ETHEL  
 332 ELLSWORTH ST.  
 DAYTONA BEACH, FL. 32114

SHEET NO. 19142  
 Sheet No. E-1