



**PROCUREMENT  
AND MATERIALS  
MANAGEMENT**

**City of Myrtle Beach  
SOUTH CAROLINA**

**(843) 918-2170  
FAX: (843) 918-2182  
www.cityofmyrtlebeach.com**

**Addendum #04  
June 8, 2023  
IFB 23-B0048  
Myrtle Beach World War II Memorial**

The purpose of this Addendum #04 to IFB 23-B0048 for Myrtle Beach World War II Memorial, dated April, 2023, and previously amended on May 11, 2023; May 25, 2023; and May 31, 2023 is to clarify the bid documents.

The following items clarify, modify, change, delete from, or add to the bidding documents. When any paragraph, subparagraph, or sub-subparagraph, thereof is modified or deleted by this addendum, the unaltered provisions of that paragraph, subparagraph, or sub-subparagraph shall remain in effect. When any portion of a drawing is modified or deleted, the unaltered provisions of that drawing shall remain in effect.

This addendum modifies the contract documents as follows:

- PART 1 – CLARIFICATIONS
- PART 2 – SPECIFICATIONS
- PART 3 – CONSTRUCTION DOCUMENTS

**PART 1 - CLARIFICATIONS**

- 1.01 Confirmed quantities for bronze plaques and medallions are as follows: (3) bronze plaques and (16) medallions. Refer to Sheet C2.05.
- 1.02 Trash receptacles representative is as follows: Lauren Wilson at Anova Furnishings (314-755-1264). Trash receptacle with City of Myrtle Beach logo shall match existing trash receptacles previously procured by the City. Vector image required shall be provided by Engineer upon award of contract.
- 1.03 Per specification section 321316 – Decorative Concrete, 3.10 Sandblasted Finish, Note 5, depth of cut shall expose decorative aggregate with occasional exposure of coarse aggregate, with maximum reveal of 1/16”.
- 1.04 Decorative Black Granite: Laser Design is fully aware of this project and the design of the decorative black granite. The necessary digital images will be provided by the Engineer to Laser Design upon the award of the project.
- 1.05 Kershaw Granite: The Engineer has been in contact with Toni Ramos, Granites of America, supplier of the Kershaw granite, throughout the design process and they are in possession of the drawings and details of the project.
- 1.06 Contractor shall be responsible for installing the 3” conduit from the existing transformer to the new meter base. Conduit to be provided by Santee Cooper. Conductors/wires from the transformer to the new meter base shall be installed by Santee Cooper.
- 1.07 Electrical panel box shall be a stainless steel NEMA 4x 12-circuit, with 100 amp main circuit breaker panel. Panel shall be lockable Eaton S4XPB, or approved equal.

**PART 2 – SPECIFICATIONS**

N/A

**PART 3 – CONSTRUCTION DOCUMENTS**

**3.01 SHEET L1.01 – LANDSCAPE PLAN:**

1. **REPLACE** Sheet L1.01 – Landscape Plan in its entirety with attached revised sheet. Previously labeled symbol TC has been updated to HV.

Contractors are responsible to acknowledge receipt of this addendum in the space provided in the bid documents. Failure to do so may subject the bidder to disqualification.

Bids are due no later than Thursday, June 15, 2023 at 2:00PM (local time.) No electronic submissions will be accepted. The City is not responsible for late or misdirected mail.

Please send in your sealed bid to the address below:

City of Myrtle Beach  
3231 Mr. Joe White Avenue  
Myrtle Beach, SC 29577  
Attn: Procurement Division/Brandon Hancock

Thank you,  
City of Myrtle Beach  
Brandon Hancock/Procurement Office/Buyer  
Email: bhancock@cityofmyrtlebeach.com




LEX33-CUST - EXPOSITION 33 GALLON TRASH RECEPTACLE/RECYCLER,  
CUSTOM SIDE DOOR WITH MYRTLE BEACH LOGO  
COLOR: TEXTURED BLACK

- NOTES:
1. INSTALLATION TO BE COMPLETED IN ACCORDANCE WITH MANUFACTURER'S SPECIFICATIONS.
  2. DO NOT SCALE DRAWING.
  3. THIS DRAWING IS INTENDED FOR USE BY ARCHITECTS, ENGINEERS, CONTRACTORS, CONSULTANTS AND DESIGN PROFESSIONALS FOR PLANNING PURPOSES ONLY. THIS DRAWING MAY NOT BE USED FOR CONSTRUCTION.
  4. ALL INFORMATION CONTAINED HEREIN WAS CURRENT AT THE TIME OF DEVELOPMENT BUT MUST BE REVIEWED AND APPROVED BY THE PRODUCT MANUFACTURER TO BE CONSIDERED ACCURATE.
  5. PRODUCT MUST MATCH EXISTING TRASH RECEPTACLES FABRICATED FOR THE CITY OF MYRTLE BEACH. CONFIRMATION AND COORDINATION OF PRODUCT AND LOGO VECTOR FILE THROUGH CITY OF MYRTLE REP - SEE BELOW FOR CONTACT INFORMATION.


CONTACT:  
LAUREN WILSON AT ANOVA FURNISHINGS (314-755-1264)

2

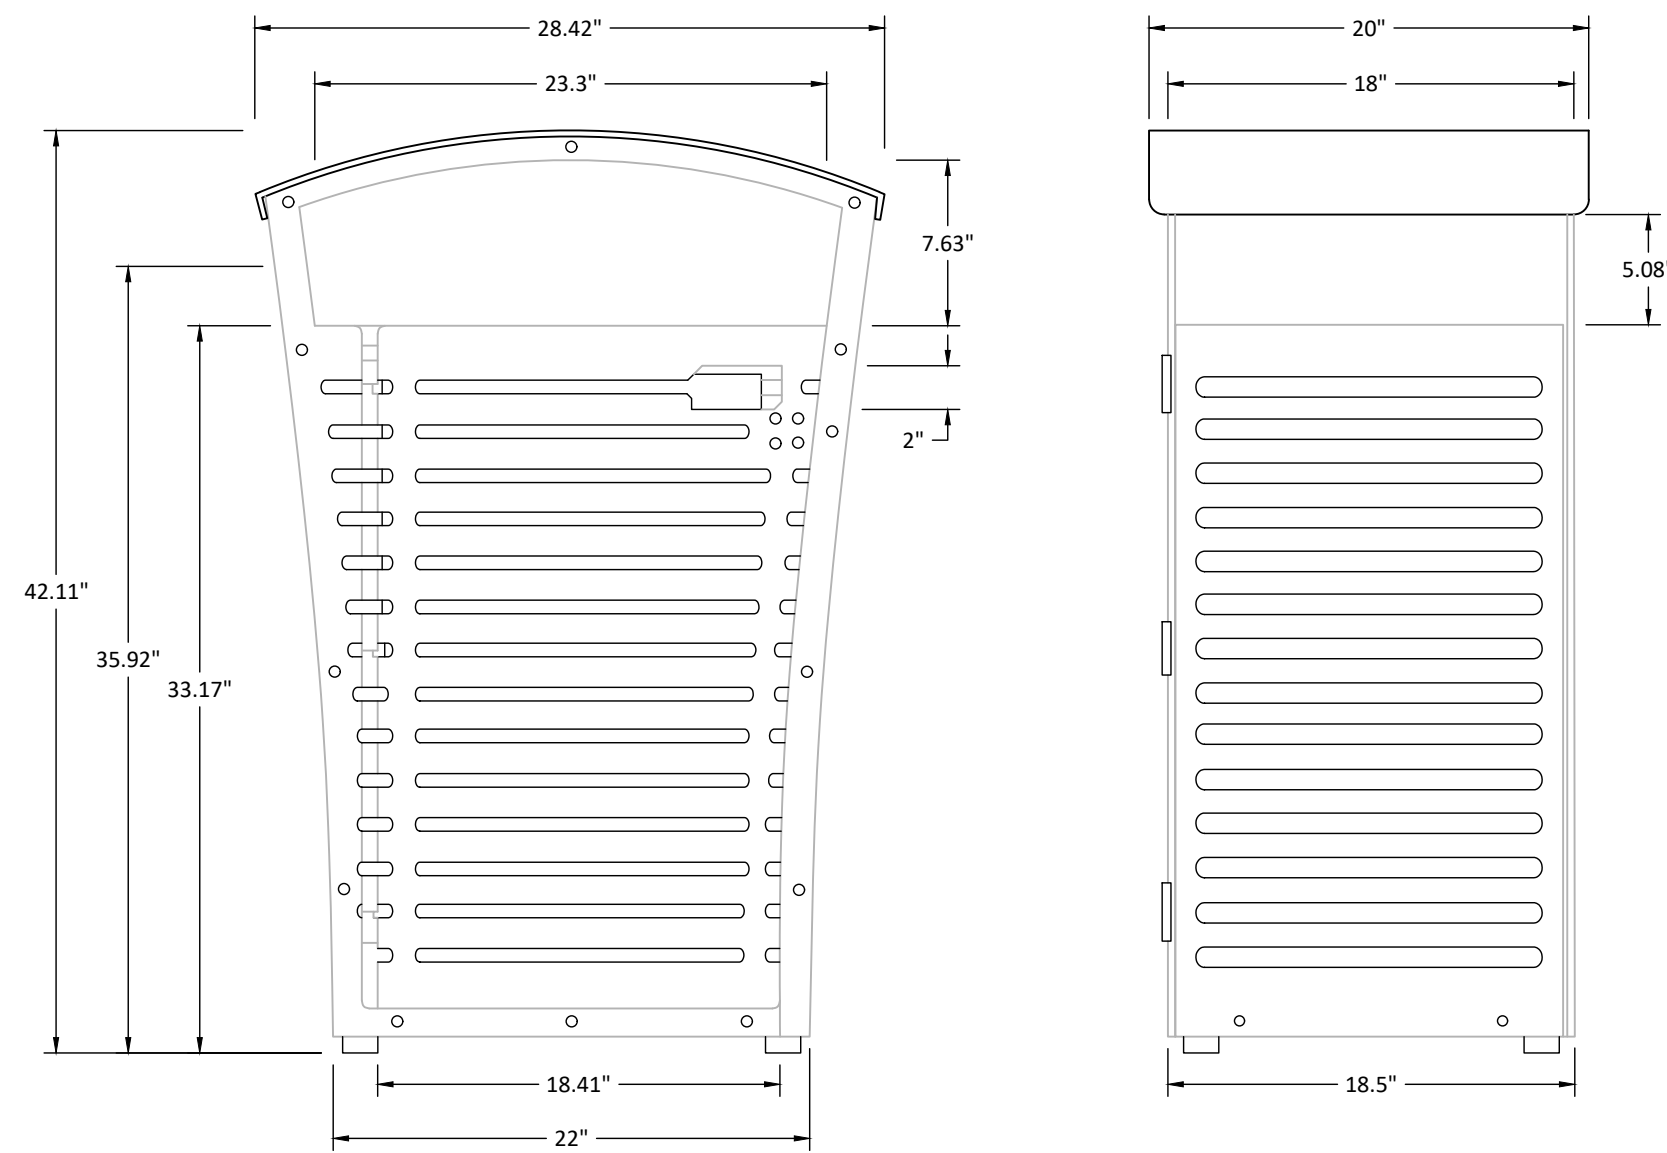


\*DETAIL FOR DIMENSIONAL PURPOSES ONLY, NOT FOR CONSTRUCTION. PRODUCT SPECIFIED SHALL HAVE CUSTOM DOOR WITH MYRTLE BEACH LOGO AS SEEN IN PHOTO RENDERING.

1 TRASH RECEPTACLE  
NTS

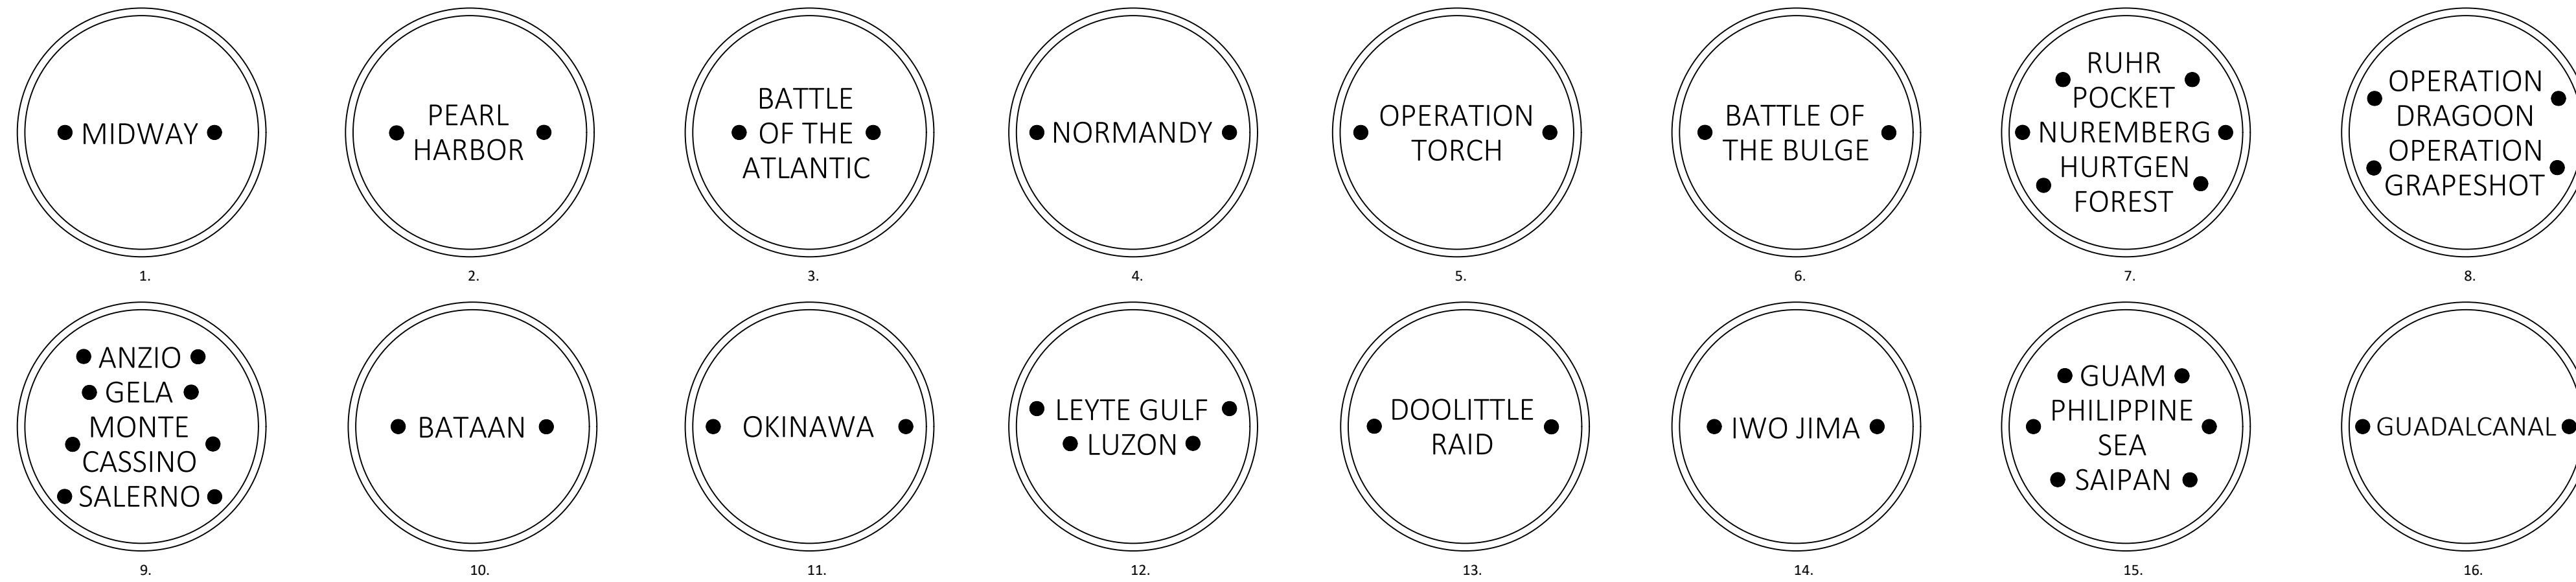




NOTES:  
TEXT SHALL BE CENTERED AT THE CENTER OF THE MEDALLION, WITH DECORATIVE BULLETS ON EACH SIDE. FOR MEDALLIONS WITH MORE THAN ONE CAMPAIGN LISTED, THE LIST WILL BE CENTERED, AND EACH CAMPAIGN MARKED WITH DECORATIVE BULLET POINTS.

2 BRONZE MEDALLION TEXT LAYOUT  
NTS

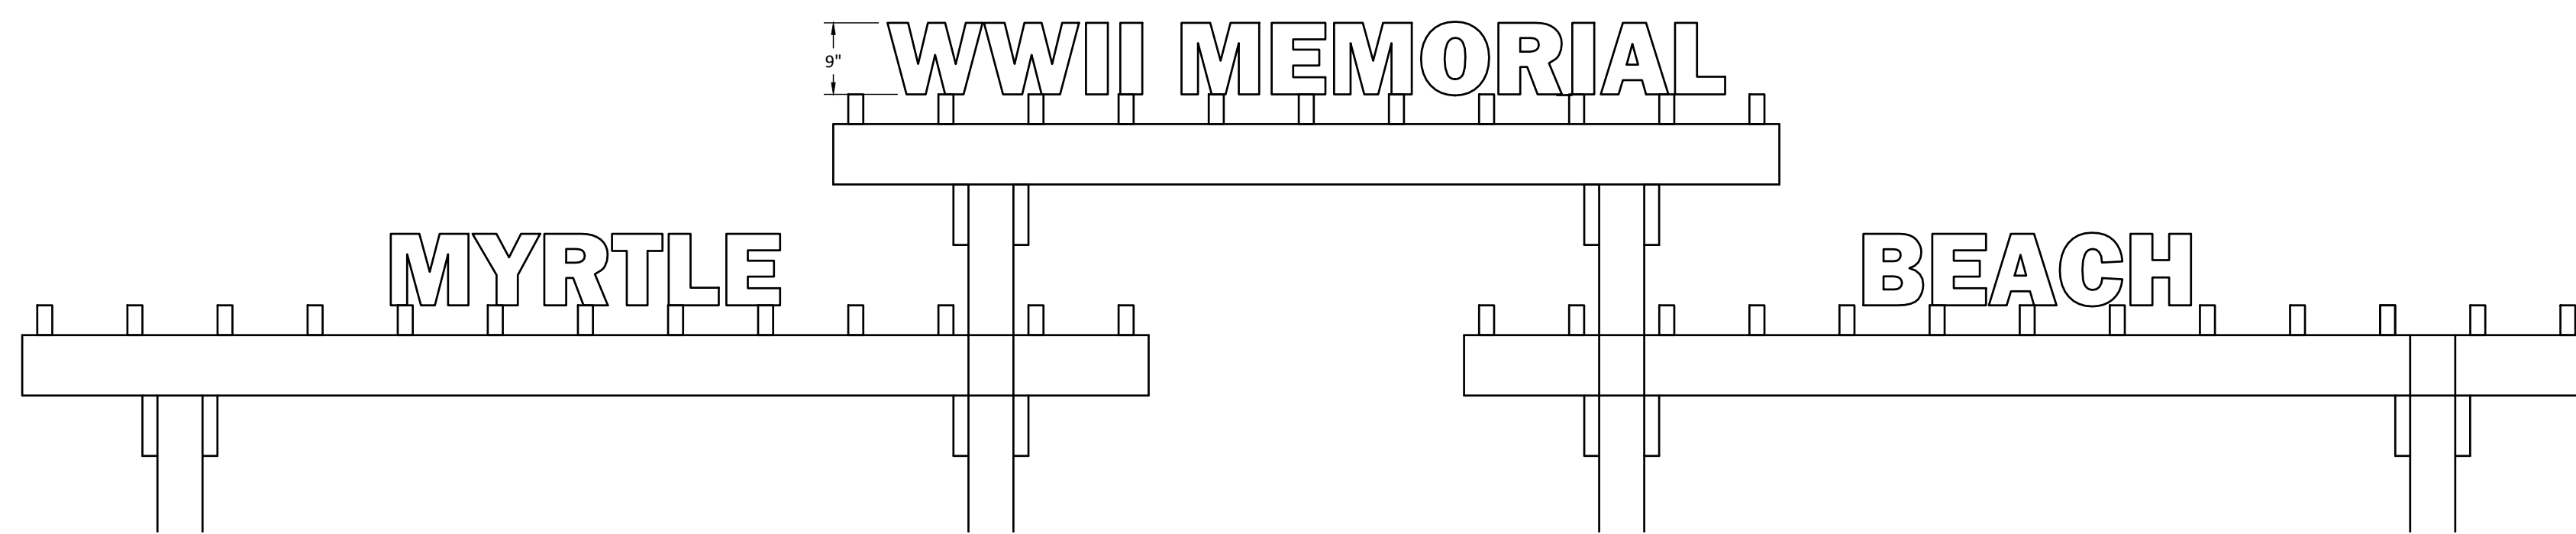

NOTE: (MATERIAL) TEXT, STYLE: AVENIR, 9" HEIGHT, CENTER JUSTIFIED ON PERGOLA. MOUNTED PER MANUFACTURER SPECIFICATIONS

3 PERGOLA SIGNAGE  
NTS

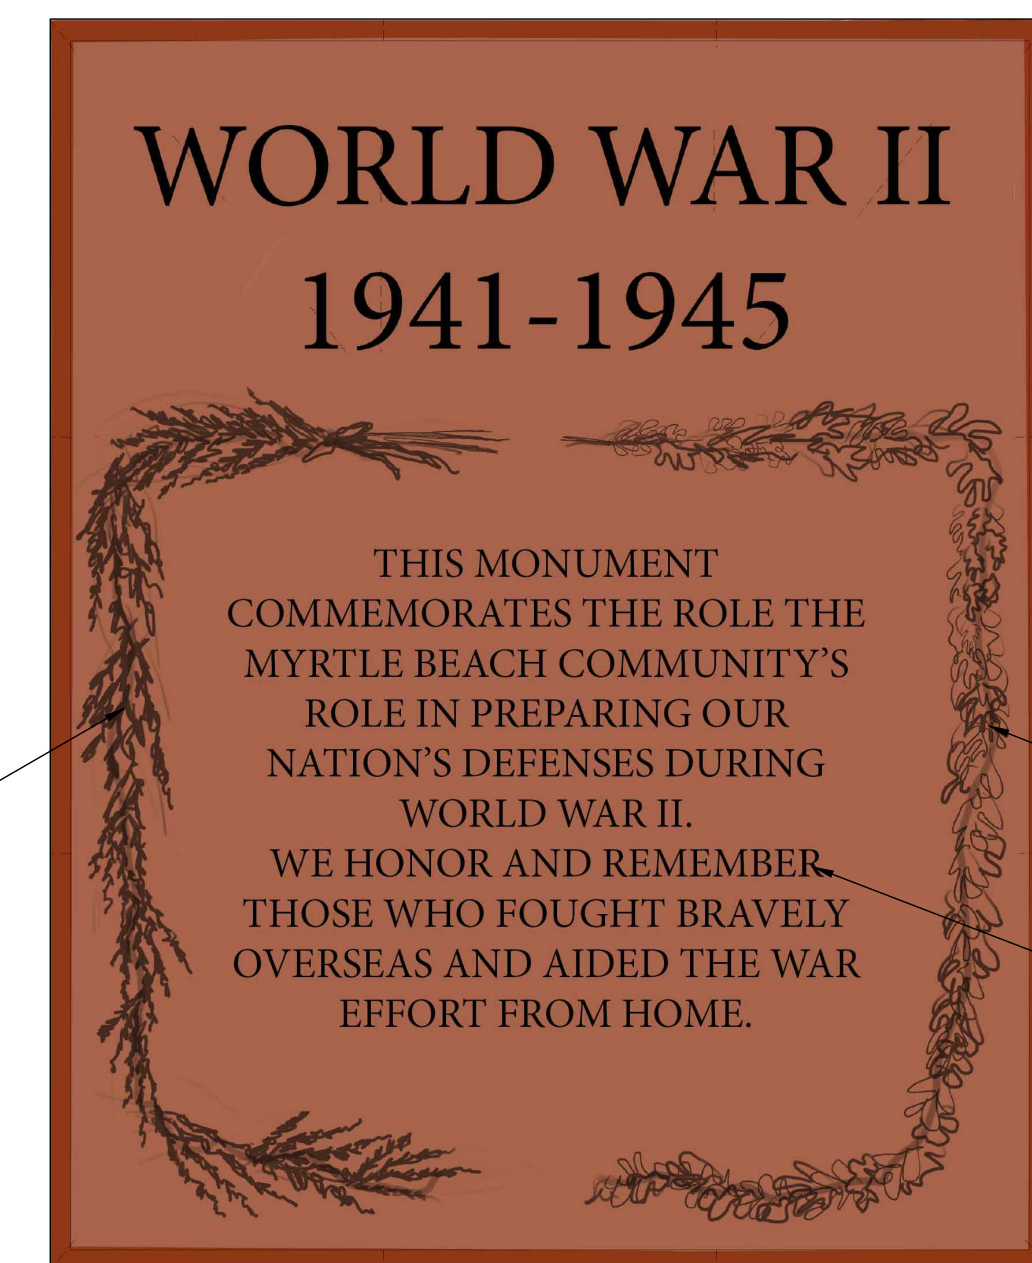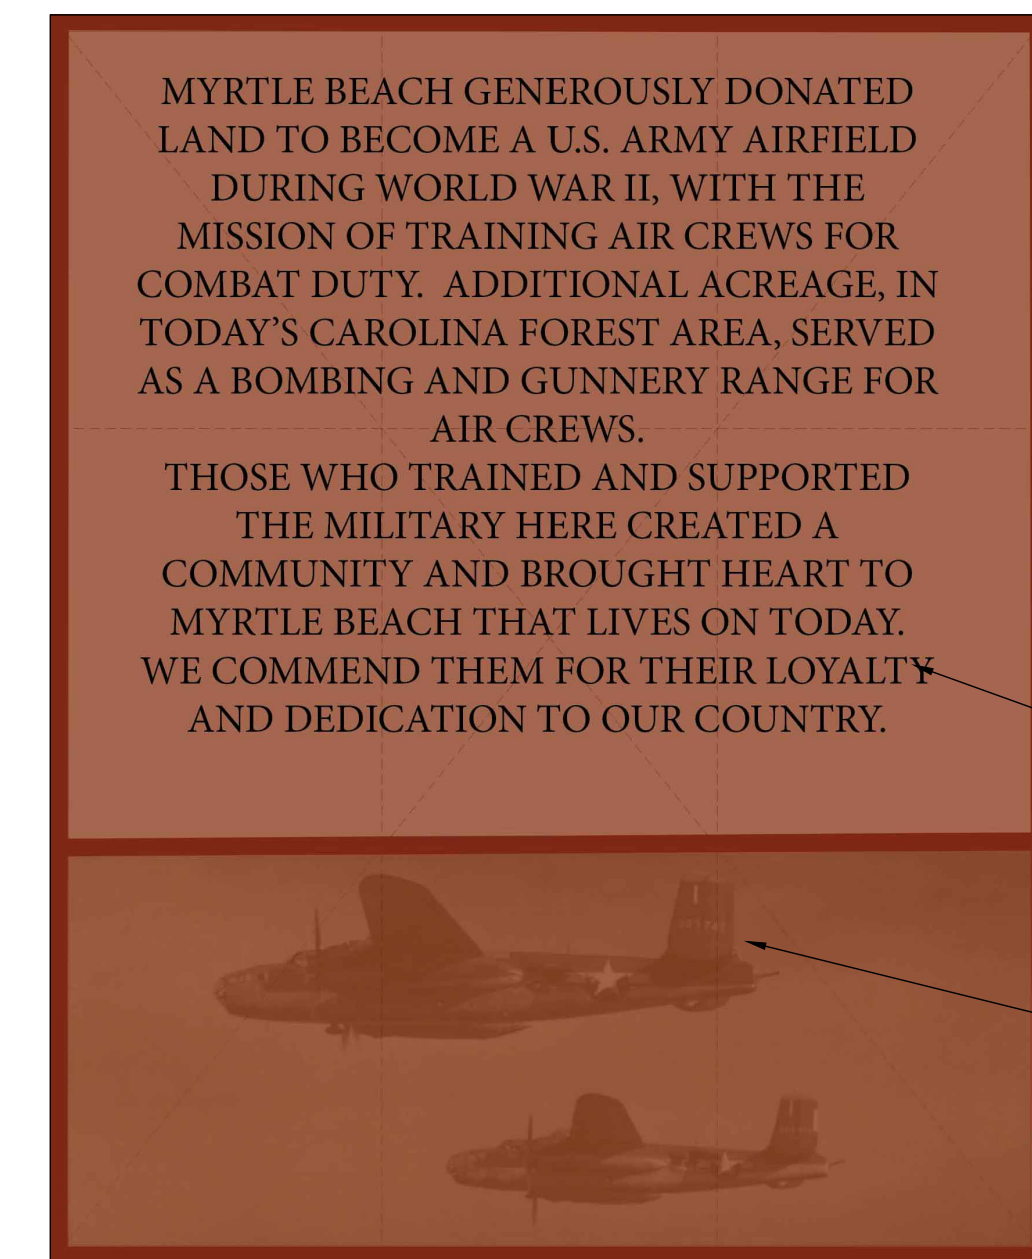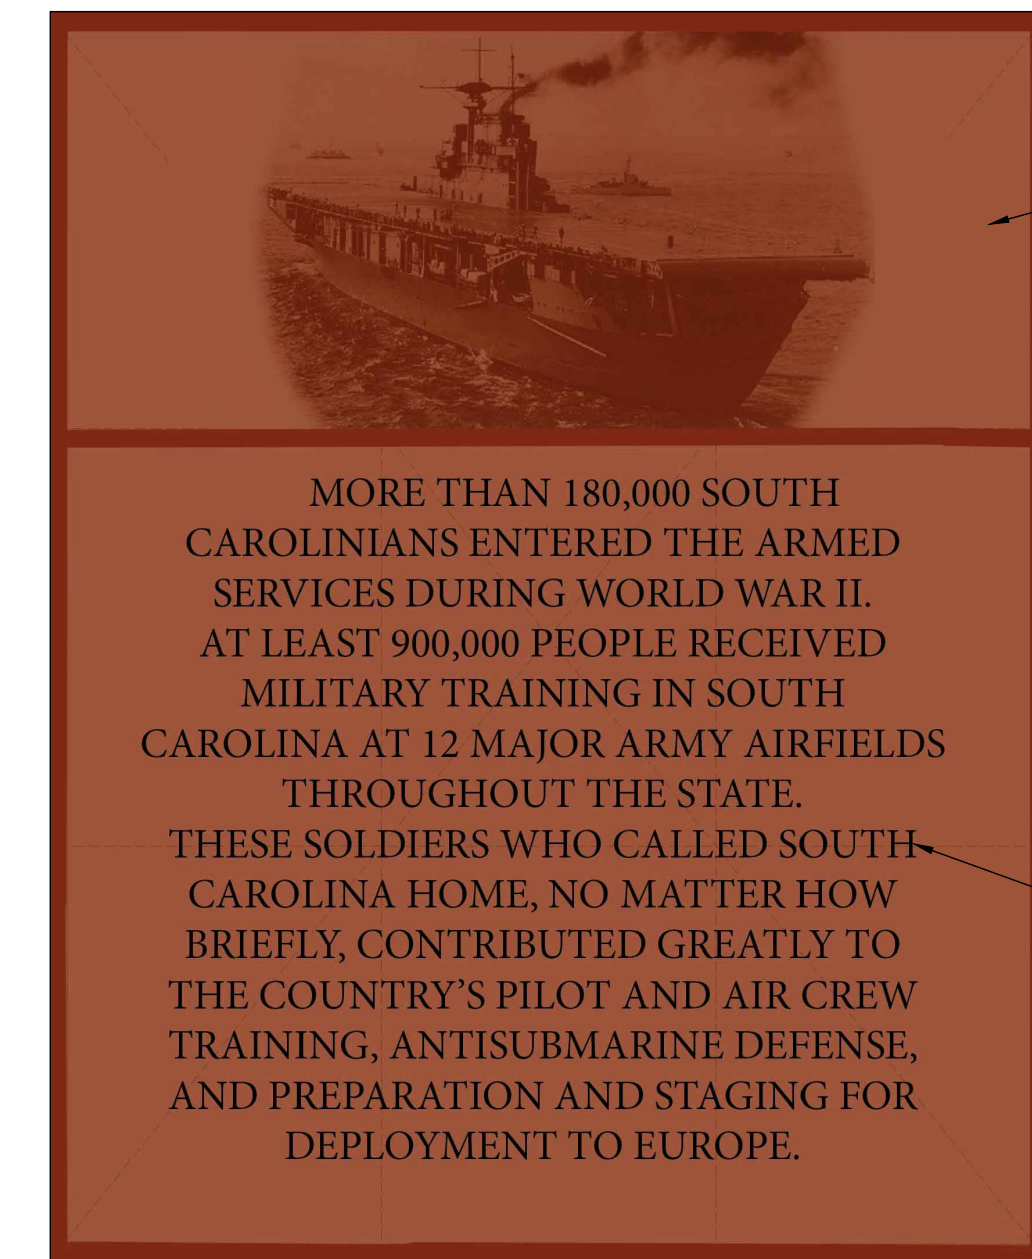

NOTES:  
GRAPHICS ARE FOR PRICING PURPOSES AND GENERAL AESTHETICS. DESIGN AND PROOFS MUST BE APPROVED BY LANDSCAPE ARCHITECT BEFORE FABRICATION. BRONZE PLAQUES BY CAROLINA BRONZE OR APPROVED EQUAL.

4 BRONZE PLAQUE GRAPHICS  
NTS

1



**DDC Engineers**  
BOLTON & MENK, INC.  
www.ddcinc.com

1298 PROFESSIONAL DRIVE  
MYRTLE BEACH, SOUTH CAROLINA 29577  
Phone: (843) 692-3200  
Email: myrtlebeach@bolton-menk.com  
www.bolton-menk.com

CITY OF  
MYRTLE BEACH



WORLD WAR II  
MEMORIAL

150 FARROW PARKWAY  
MYRTLE BEACH,  
SOUTH CAROLINA

MISC DETAILS

PROJECT NO:  
22090L


REVISIONS:  
1 5/19/23 ADDENDUM #2 REVISIONS  
2 6/6/23 ADDENDUM #4 REVISIONS

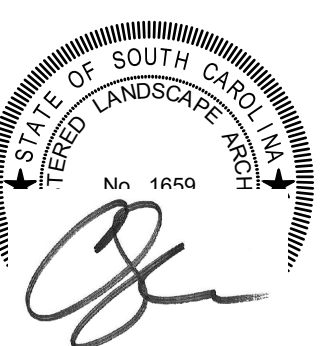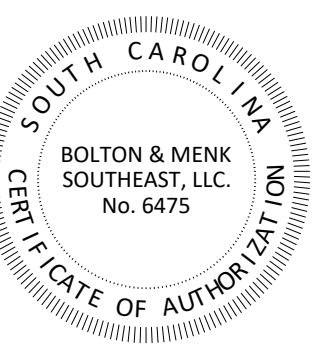

DATE: 4/24/2023  
DESIGNED BY: CRC  
DRAWN BY: MRM  
CHECKED BY: CRC



C2.05

© Bolton & Menk, Inc. 2023. All Rights Reserved.  
 h:\DDC\_PA220906\CAD\C3D\220906\_L1.01.dwg 6/16/2023 10:46:07 AM

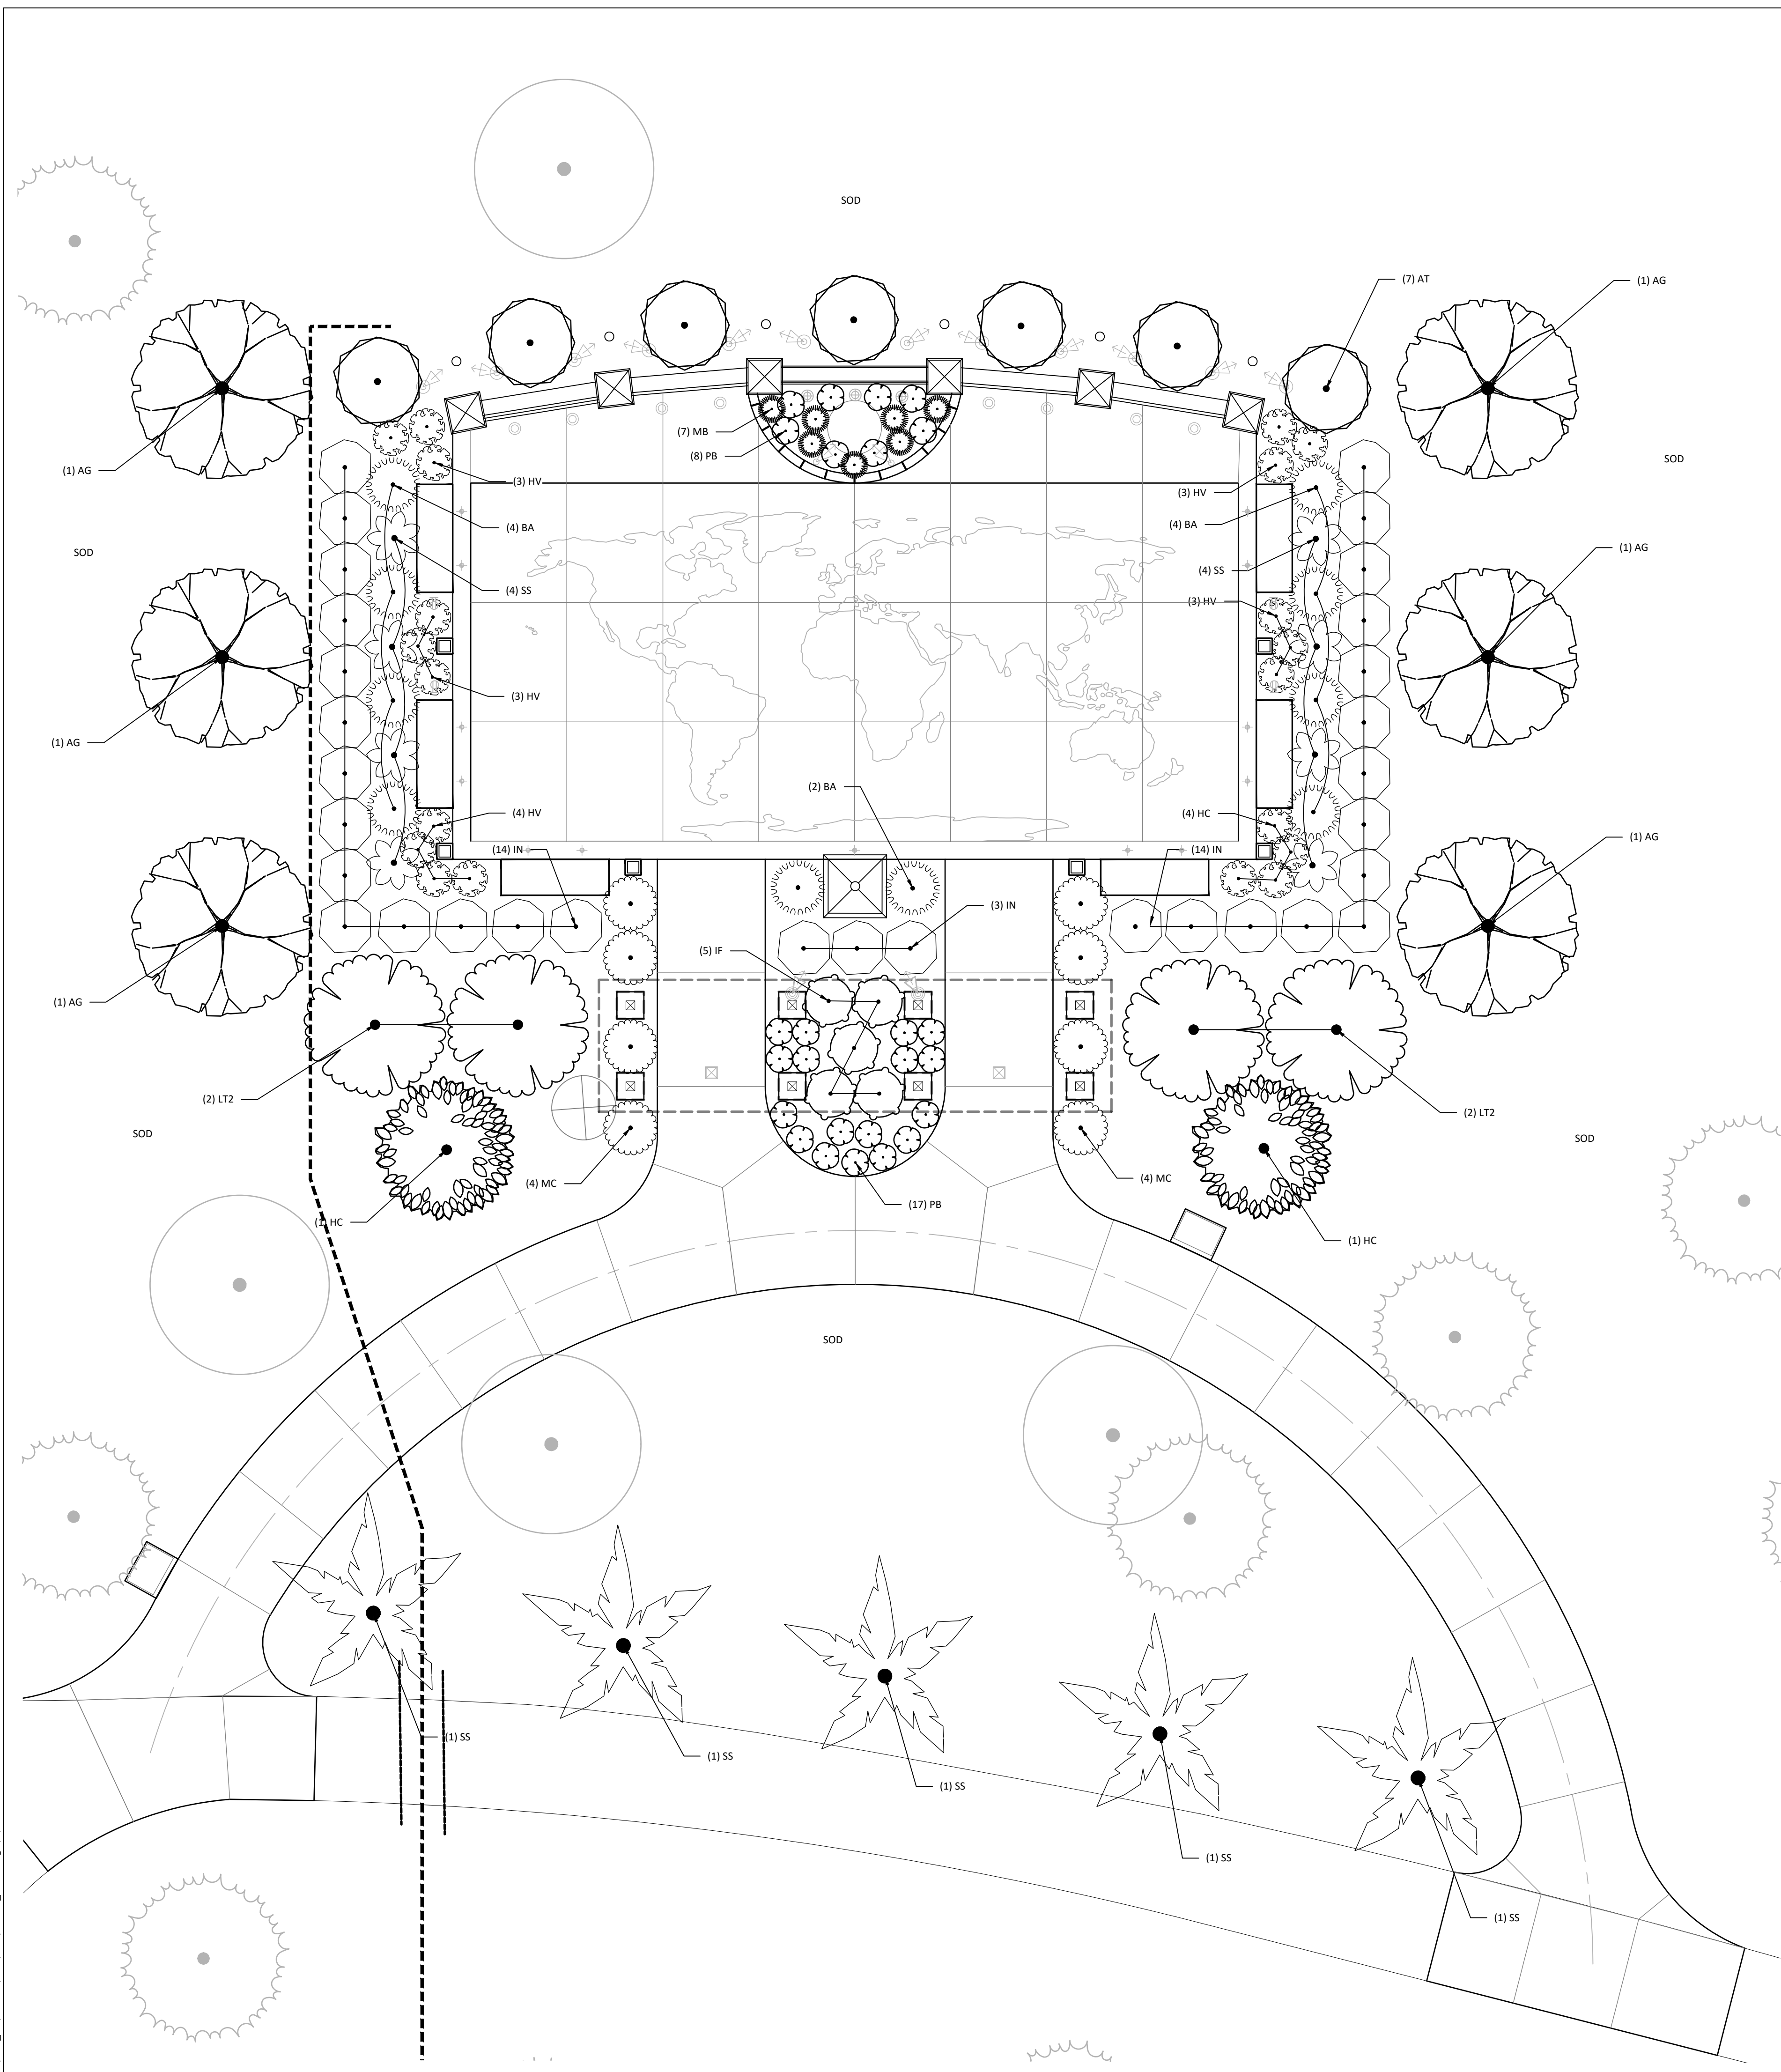

PLANT SCHEDULE						
TREES						
	CODE	QTY	BOTANICAL NAME	COMMON NAME	SIZE	REMARKS
	AG	6	ACER GRISEUM	PAPERBARK MAPLE	1' HT, 2.5" CAL.	LIMBED UP
	HC	2	HALESIA CAROLINA	SILVERBELL	5' HT, 1" CAL.	
	LT2	4	LAGERSTROEMIA INDICA X FAURIEI 'TONTO'	TONTO CRAPE MYRTLE	5' HT, 1" CAL.	MULTI-TRUNK
	SS	5	SABAL PALMETTO	CABBAGE PALMETTO	10' HT, 8&B	
SHRUBS						
	CODE	QTY	BOTANICAL NAME	COMMON NAME	SIZE	REMARKS
	AT	7	AZALEA X 'GEORGE L. TABER'	GEORGE L. TABER SOUTHERN INDICA AZALEA	30" HT, 5 GAL.	
	BA	10	BAPTISIA AUSTRALIS MINOR	DWARF BLUE WILD INDIGO	18-24" HT, 3 GAL.	
	IN	31	ILEX VOMITORIA 'NANA'	DWARF YAUPON	18-24" HT, 3 GAL.	
	IF	5	IRIS FULVA 'LOUISIANA'	RED LOUISIANA IRIS	18-24" HT, 3 GAL.	
	MB	7	MONARDA FISTULOSA	BERGAMOT	18-24" HT, 3 GAL.	
ORNAMENTAL GRASSES AND GROUND COVER						
	CODE	QTY	BOTANICAL NAME	COMMON NAME	SIZE	REMARKS
	HV	20	HYLOTELEPHUM X 'VERA JAMESON'	VERA JAMESON STONECROP	8-12" HT, 1 GAL.	
	MC	8	MUHLENBERGIA CAPILLARIS	PINK MUHLY GRASS	18-24" HT, 3 GAL.	
	PB	25	PHLOX CAROLINA	THICKLEAF PHLOX	12-18" HT, 1 GAL.	

- NOTES**
- REFER TO SHEET L1.02 FOR GENERAL NOTES.
  - LANDSCAPE ARCHITECT MUST INSPECT AND APPROVE FINISH GRADING BEFORE CONTRACTOR PROCEEDS WITH SODDING AND SEEDING.
  - ALL DISTURBED AREAS SHALL RECEIVE AT LEAST 6" OF TOPSOIL AND SHALL BE SODDED.
  - WHERE NEW SOD MEETS EXISTING TURF, EXISTING TURF EDGE SHALL BE CUT TO ALLOW FOR A CONSISTENT, UNIFORM STRAIGHT EDGE. JAGGED OR UNEVEN EDGES WILL NOT BE ACCEPTABLE. REMOVE TOPSOIL AT JOINT BETWEEN EXISTING AND NEW AS REQUIRED TO ALLOW NEW SOD SURFACE TO BE FLUSH WITH EXISTING.
  - FAILURE OF TURF DEVELOPMENT: IN THE EVENT THE CONTRACTOR FAILS TO PROVIDE AN ACCEPTABLE TURF, THE CONTRACTOR SHALL RE-SOD OR RE-SEED ALL APPLICABLE AREAS, AT NO ADDITIONAL COST TO THE OWNER, TO THE SATISFACTION OF THE LANDSCAPE ARCHITECT.
  - BEGIN TURF ESTABLISHMENT IMMEDIATELY AFTER SODDING, REFER TO SPECIFICATION FOR PROCEDURE.
  - ALL TREES TO BE BALLED AND BURLAPPED.
  - ALL TREES AND SHRUBS SHALL RECEIVE 4" DEPTH OF CLEAN SHREDDED HARDWOOD MULCH, UNLESS OTHERWISE SPECIFIED.
  - ALL PLANT MATERIALS SHALL BE NO. 1 QUALITY, NURSERY GROWN AND SPECIMENS MUST BE MATCHED. ALL OVERSTORY TREES ADJACENT TO DRIVE AND IN PARKING LOT SHALL BEGIN BRANCHING NO LOWER THAN 6'.

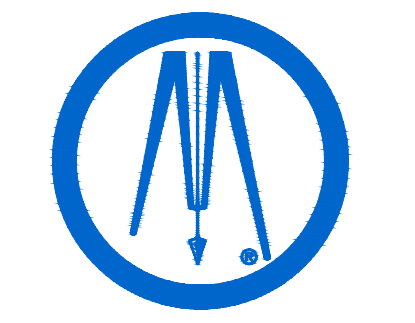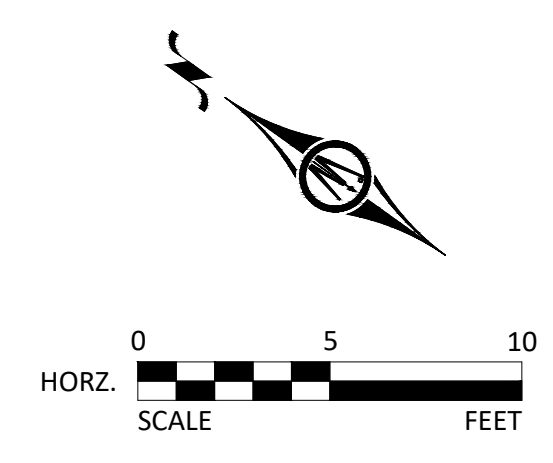

**DDC Engineers**  
 BOLTON & MENK, INC.  
 www.ddcinc.com

1298 PROFESSIONAL DRIVE  
 MYRTLE BEACH, SOUTH CAROLINA 29577  
 Phone: (843) 692-3200  
 Email: myrtlebeach@bolton-menk.com  
 www.bolton-menk.com

CITY OF  
 MYRTLE BEACH


**WORLD WAR II  
 MEMORIAL**

150 FARROW PARKWAY  
 MYRTLE BEACH,  
 SOUTH CAROLINA

**LANDSCAPE  
 PLAN**

PROJECT NO:  
 22090L

REVISIONS:  
 1 5/19/23 ADDENDUM #2 REVISIONS  
 2 6/6/23 ADDENDUM #4 REVISIONS

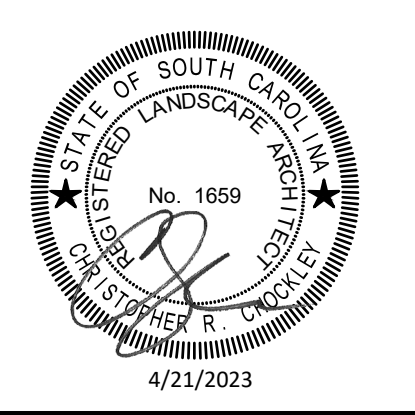

DATE: 4/24/2023  
 DESIGNED BY: CRC  
 DRAWN BY: MRM  
 CHECKED BY: CRC

L1.01