

EXAMPLE OF MANSRD

ABUTMENT TO OLD COURTHOUSE

- NOTE:
1. DRAIN BASINS CREATED BY ANGLED STRUCTURAL MEMBERS; ROOF MEMBRANE ASSEMBLY SHALL HAVE CONSTANT THICKNESS
 2. CRICKETS CREATED BY TAPERED INSULATION
 3. DRAIN PIPES 7" DIA. TYP.
 4. SCUPPERS 4"HT X 10" WD, TYP.

AREAS OUTLINED IN RED TO BE RE-ROOFED

1 ROOF PLAN
A1.5 SCALE: 3/32"=1'-0"




Hatch Mott MacDonald
 Engineers, Surveyors
 Architects
 Hatch Mott MacDonald Florida, L.L.C.
 AA-CO0009S, EA-CO00018S, LB-CO00073S
 9111 N. W. 25th St., Suite 200
 Fort Lauderdale, Florida 33309
 P. O. Box 2516 (32519-2516)
 Panama City, Florida
 Telephone: (850) 884-4011 • Fax: (850) 454-4198



SPENCER MAXWELL BULLOCK
 ARCHITECTS
 p00 27

DEVELOPMENT OF THE OLD
 COURTHOUSE BLOCK
 ESCAMBIA COUNTY, FLORIDA
NEW OFFICE BUILDING

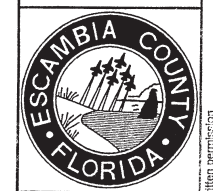

DATE: 12/08/04
 DESIGNED BY: MH
 DRAWN BY: JY
 CHECKED BY: JCR
 PROJECT ARCHITECT: MJH
 PROJECT NUMBER: 205753


NEW OFFICE BUILDING

SHEET TITLE:
ROOF PLAN


SHEET NUMBER:
A1.5

PERMIT SET: NOT FOR CONSTRUCTION


This drawing is the property of Hatch Mott MacDonald Florida, Inc., and may not be reproduced without written permission.

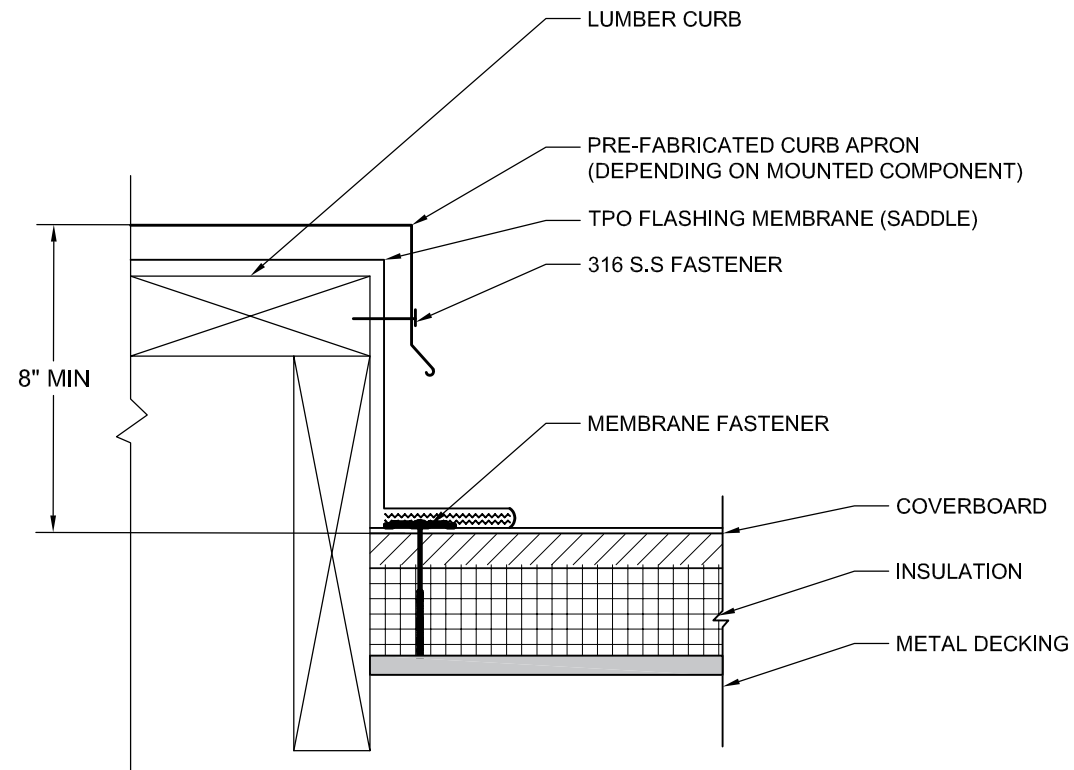


1 ROOFTOP CURB FLASHING
SCALE: NTS

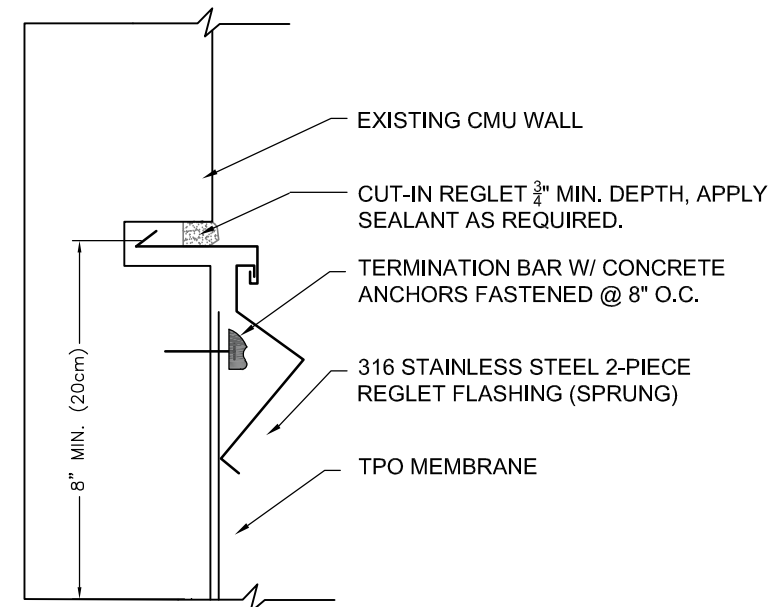

2 ROOF TO CMU WALL FLASHING
SCALE: NTS

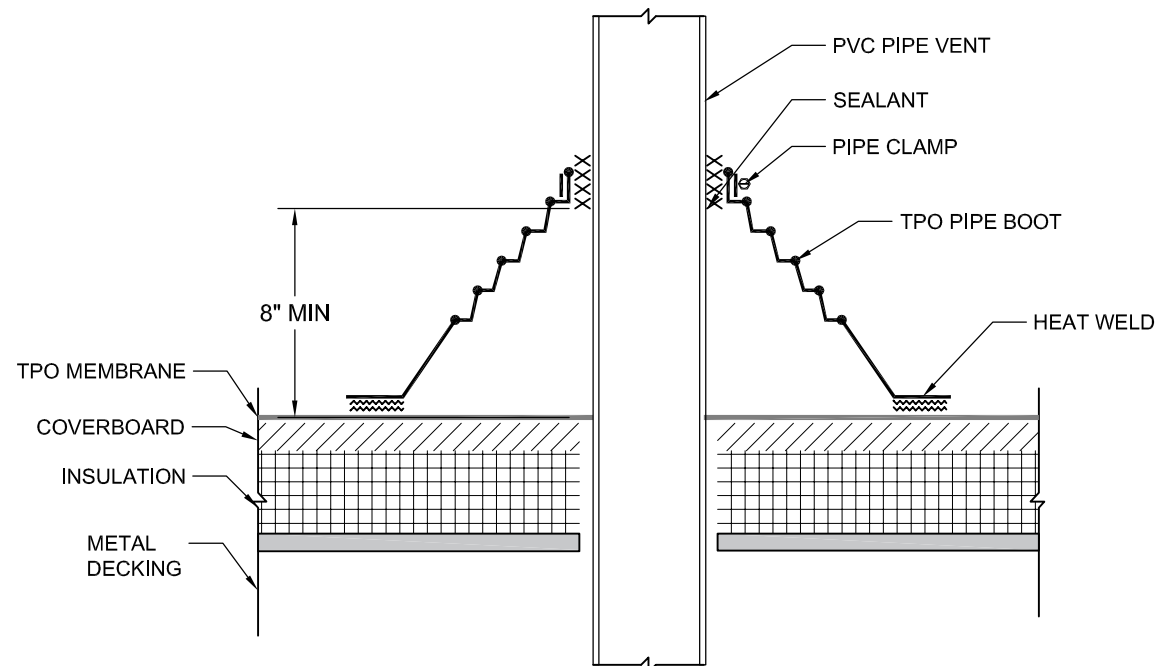

3 PIPE VENT FLASHING
SCALE: NTS

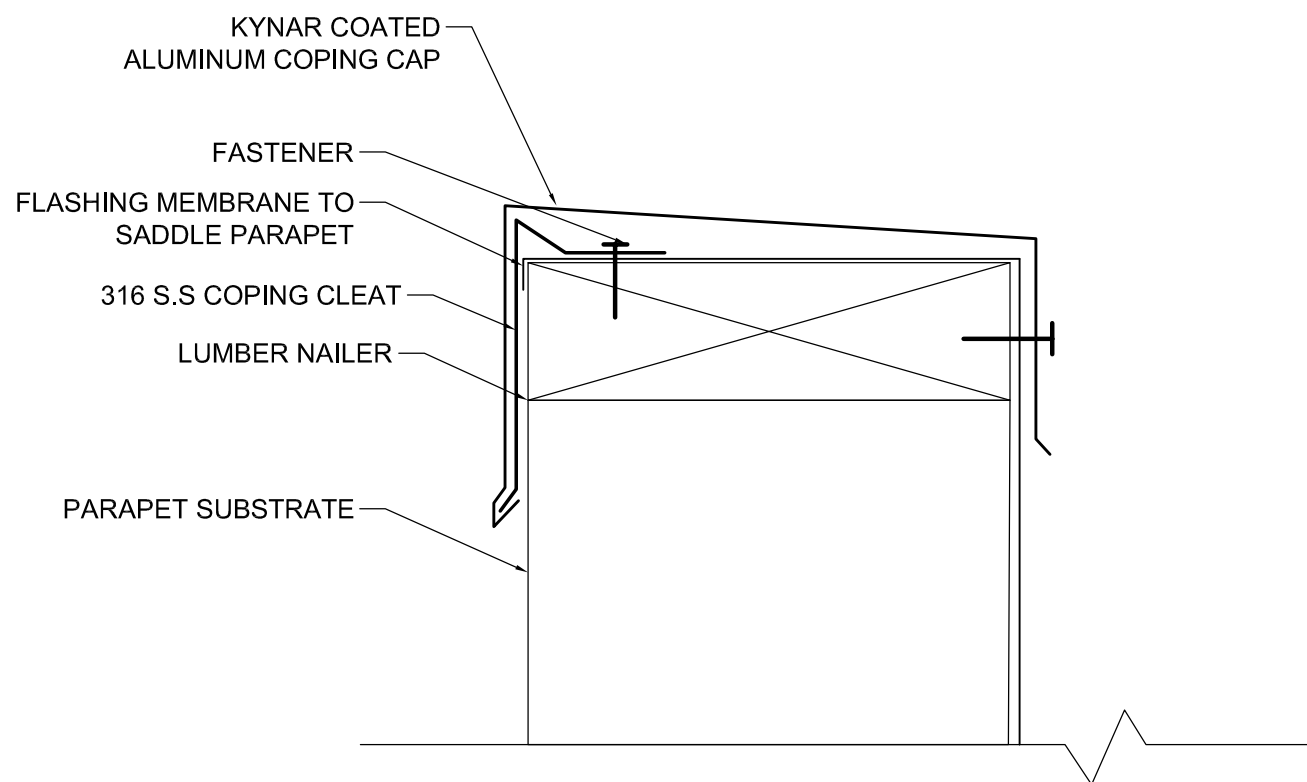

4 COPING CAP & CLEAT
SCALE: NTS

- P:\2021\Proposals\21221TCS FEMA Data\Recommended Scopes of Work\Ernie Lee\Drawings\Xr-300 ELM.dwg


THOMPSON ENGINEERING

ERNIE LEE MAGAHA BUILDING
PENSACOLA, FLORIDA


PROJECT NO:	
REVISIONS:	
ISSUE DATE: TBD	

THIS DRAWING REPRESENTS DESIGNS PREPARED BY WATERMARK DESIGN GROUP, LLC FOR SPECIFIC USE ON THIS PROJECT AND IS NOT TO BE COPIED, REPRODUCED, OR ALTERED WITHOUT THE EXPRESS WRITTEN CONSENT OF THE WATERMARK DESIGN GROUP. REPRESENTATIVE AUTHORIZED TO APPROVE THIS USE.
UNAUTHORIZED USE IS SUBJECT TO LEGAL ACTION UNDER STATE AND FEDERAL LAW.

- P:\2021\Proposals\21221TCS FEMA Data\Recommended Scopes of Work\Ernie Lee Drawings\Xr-300 ELM.dwg

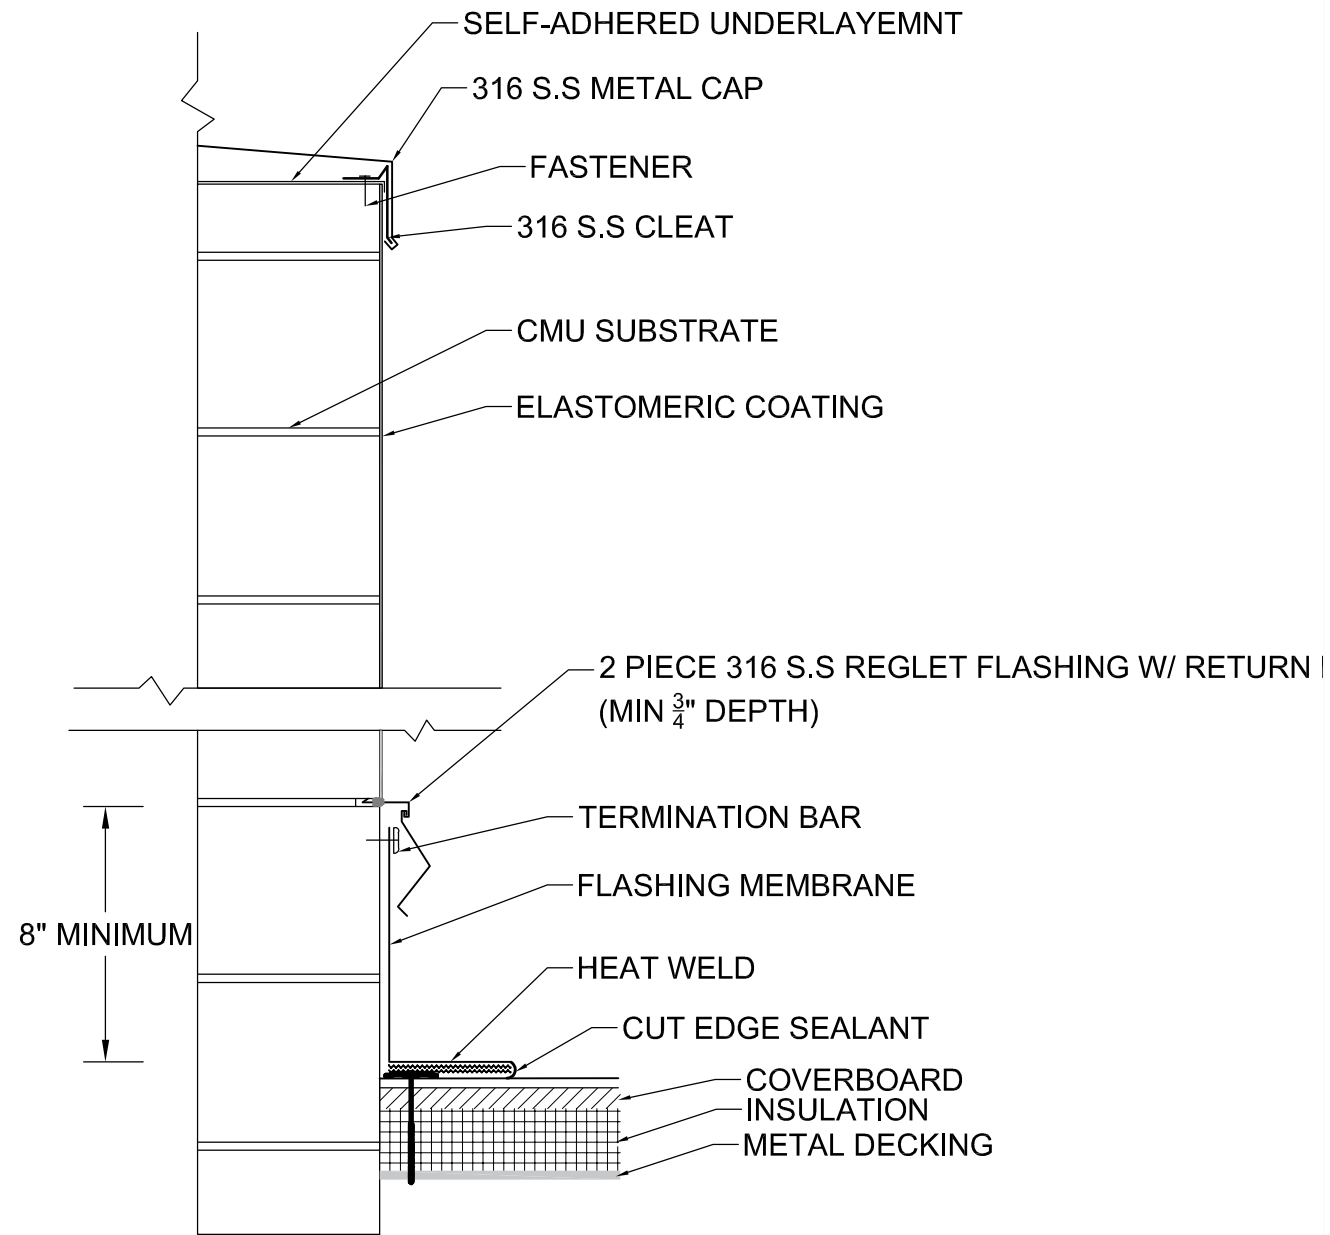

5 CMU ELEVATOR PENTHOUSE
SCALE: NTS

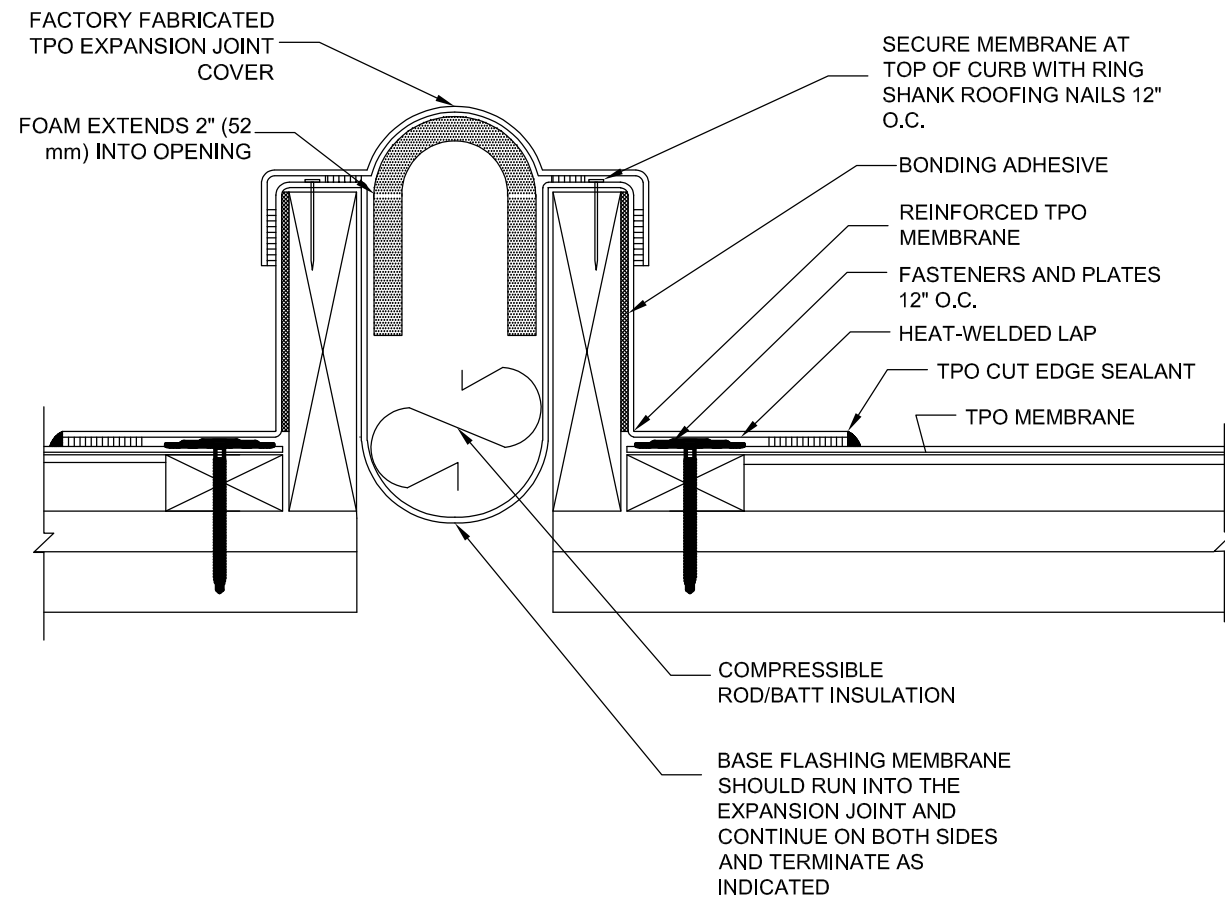


6 EXPANSION JOINT
SCALE: NTS

THOMPSON ENGINEERING


ERNIE LEE MAGAHA BUILDING
PENSACOLA, FLORIDA

PROJECT NO:	
REVISIONS:	
ISSUE DATE: TBD	


THIS DRAWING REPRESENTS DESIGNS PREPARED BY WATERMARK DESIGN GROUP, LLC FOR SPECIFIC USE ON THIS PROJECT AND IS NOT TO BE COPIED, REPRODUCED, OR ALTERED WITHOUT THE EXPRESS WRITTEN CONSENT OF THE WATERMARK DESIGN GROUP REPRESENTATIVE AUTHORIZED TO APPROVE THIS USE.
UNAUTHORIZED USE IS SUBJECT TO LEGAL ACTION UNDER STATE AND FEDERAL LAW.

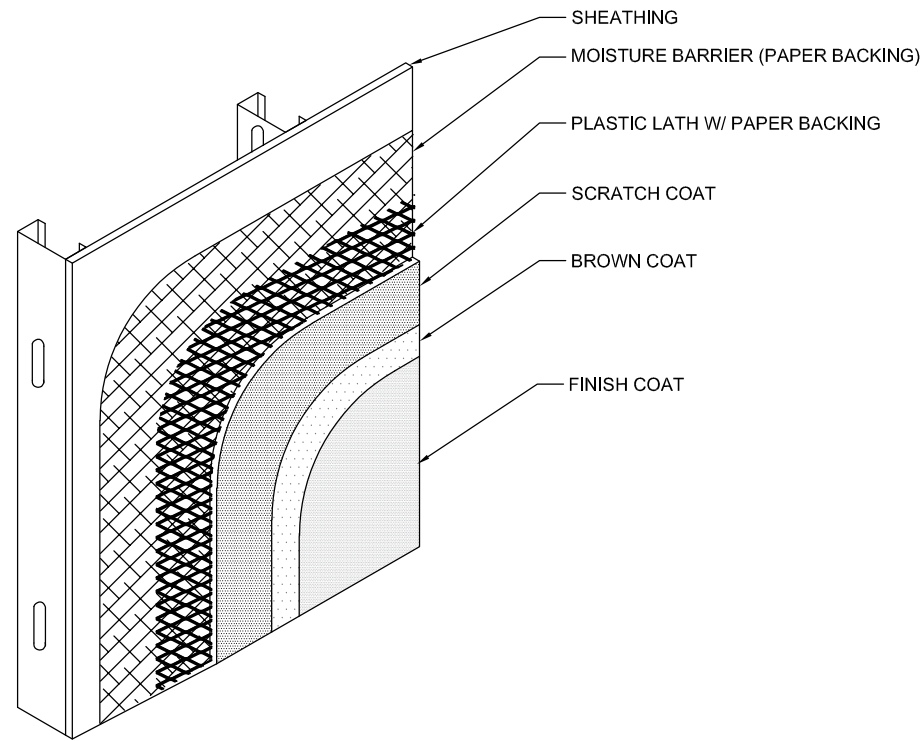


1 STUCCO WALL CLADDING
SCALE: NTS

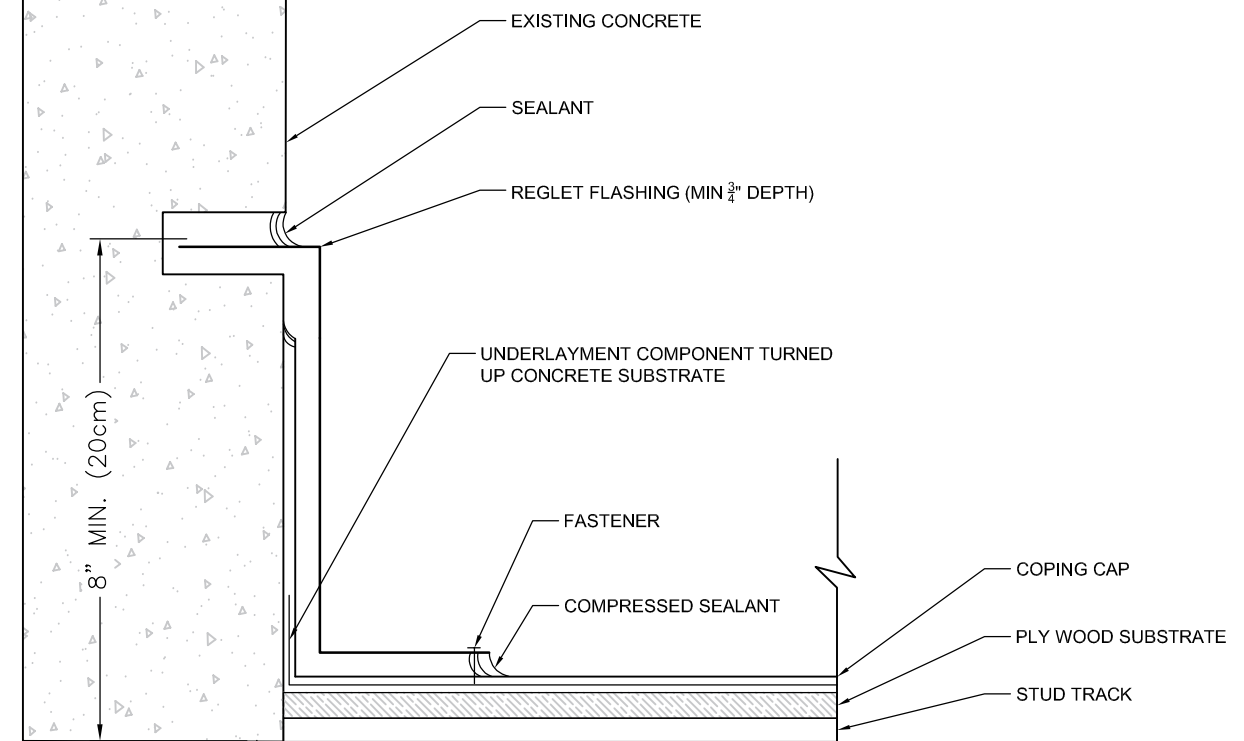

2 COPING TO CONCRETE WALL FLASHING
SCALE: NTS

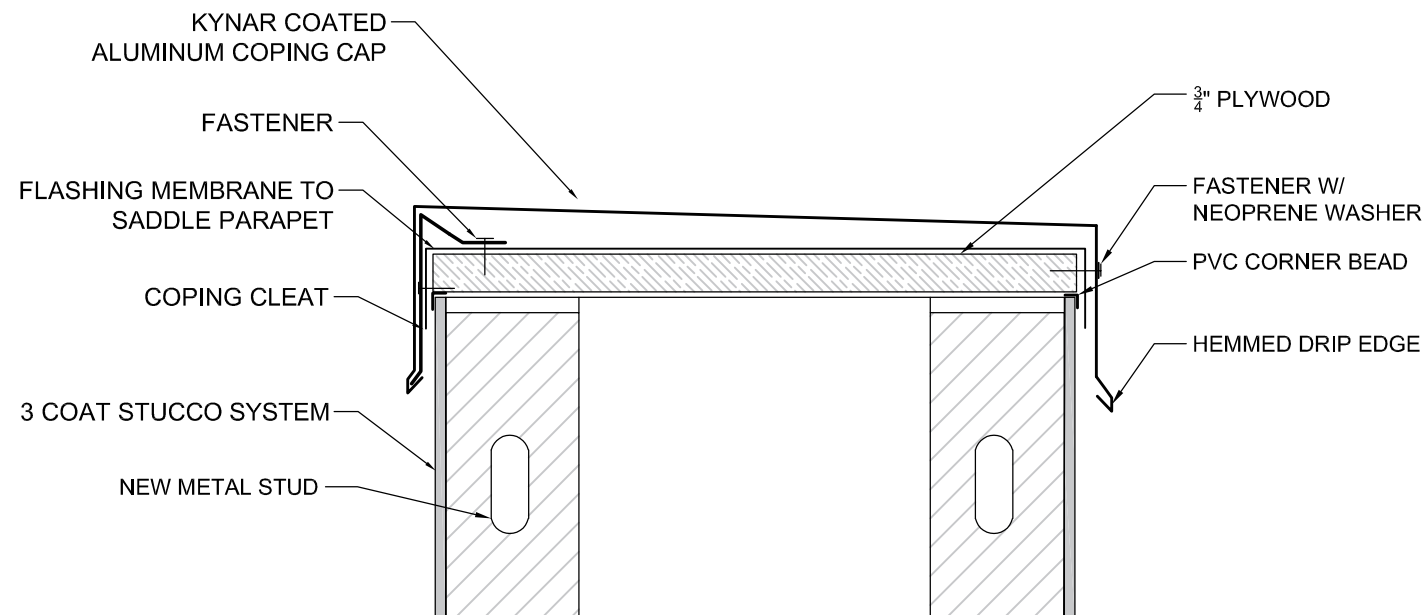

3 COPING CAP & CLEAT
SCALE: NTS

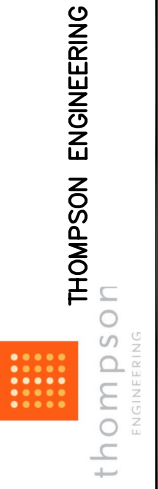

COUNTY COMMISSIONER PARKING GARAGE
 PENSACOLA, FLORIDA

PROJECT NO:
REVISIONS:

ISSUE DATE: TBD

THIS DRAWING REPRESENTS
 DESIGNS PREPARED BY WATERMARK
 DESIGN GROUP, LLC FOR SPECIFIC
 USE ON THIS PROJECT AND IS NOT
 TO BE COPIED, REPRODUCED, OR
 ALTERED WITHOUT THE EXPRESS
 WRITTEN CONSENT OF THE
 WATERMARK DESIGN GROUP
 REPRESENTATIVE AUTHORIZED TO
 APPROVE THIS USE.

UNAUTHORIZED USE IS SUBJECT TO
 LEGAL ACTION UNDER STATE AND
 FEDERAL LAW.