


2 PLATFORM PLAN - HVAC

SCALE: 3/32" = 1'-0"

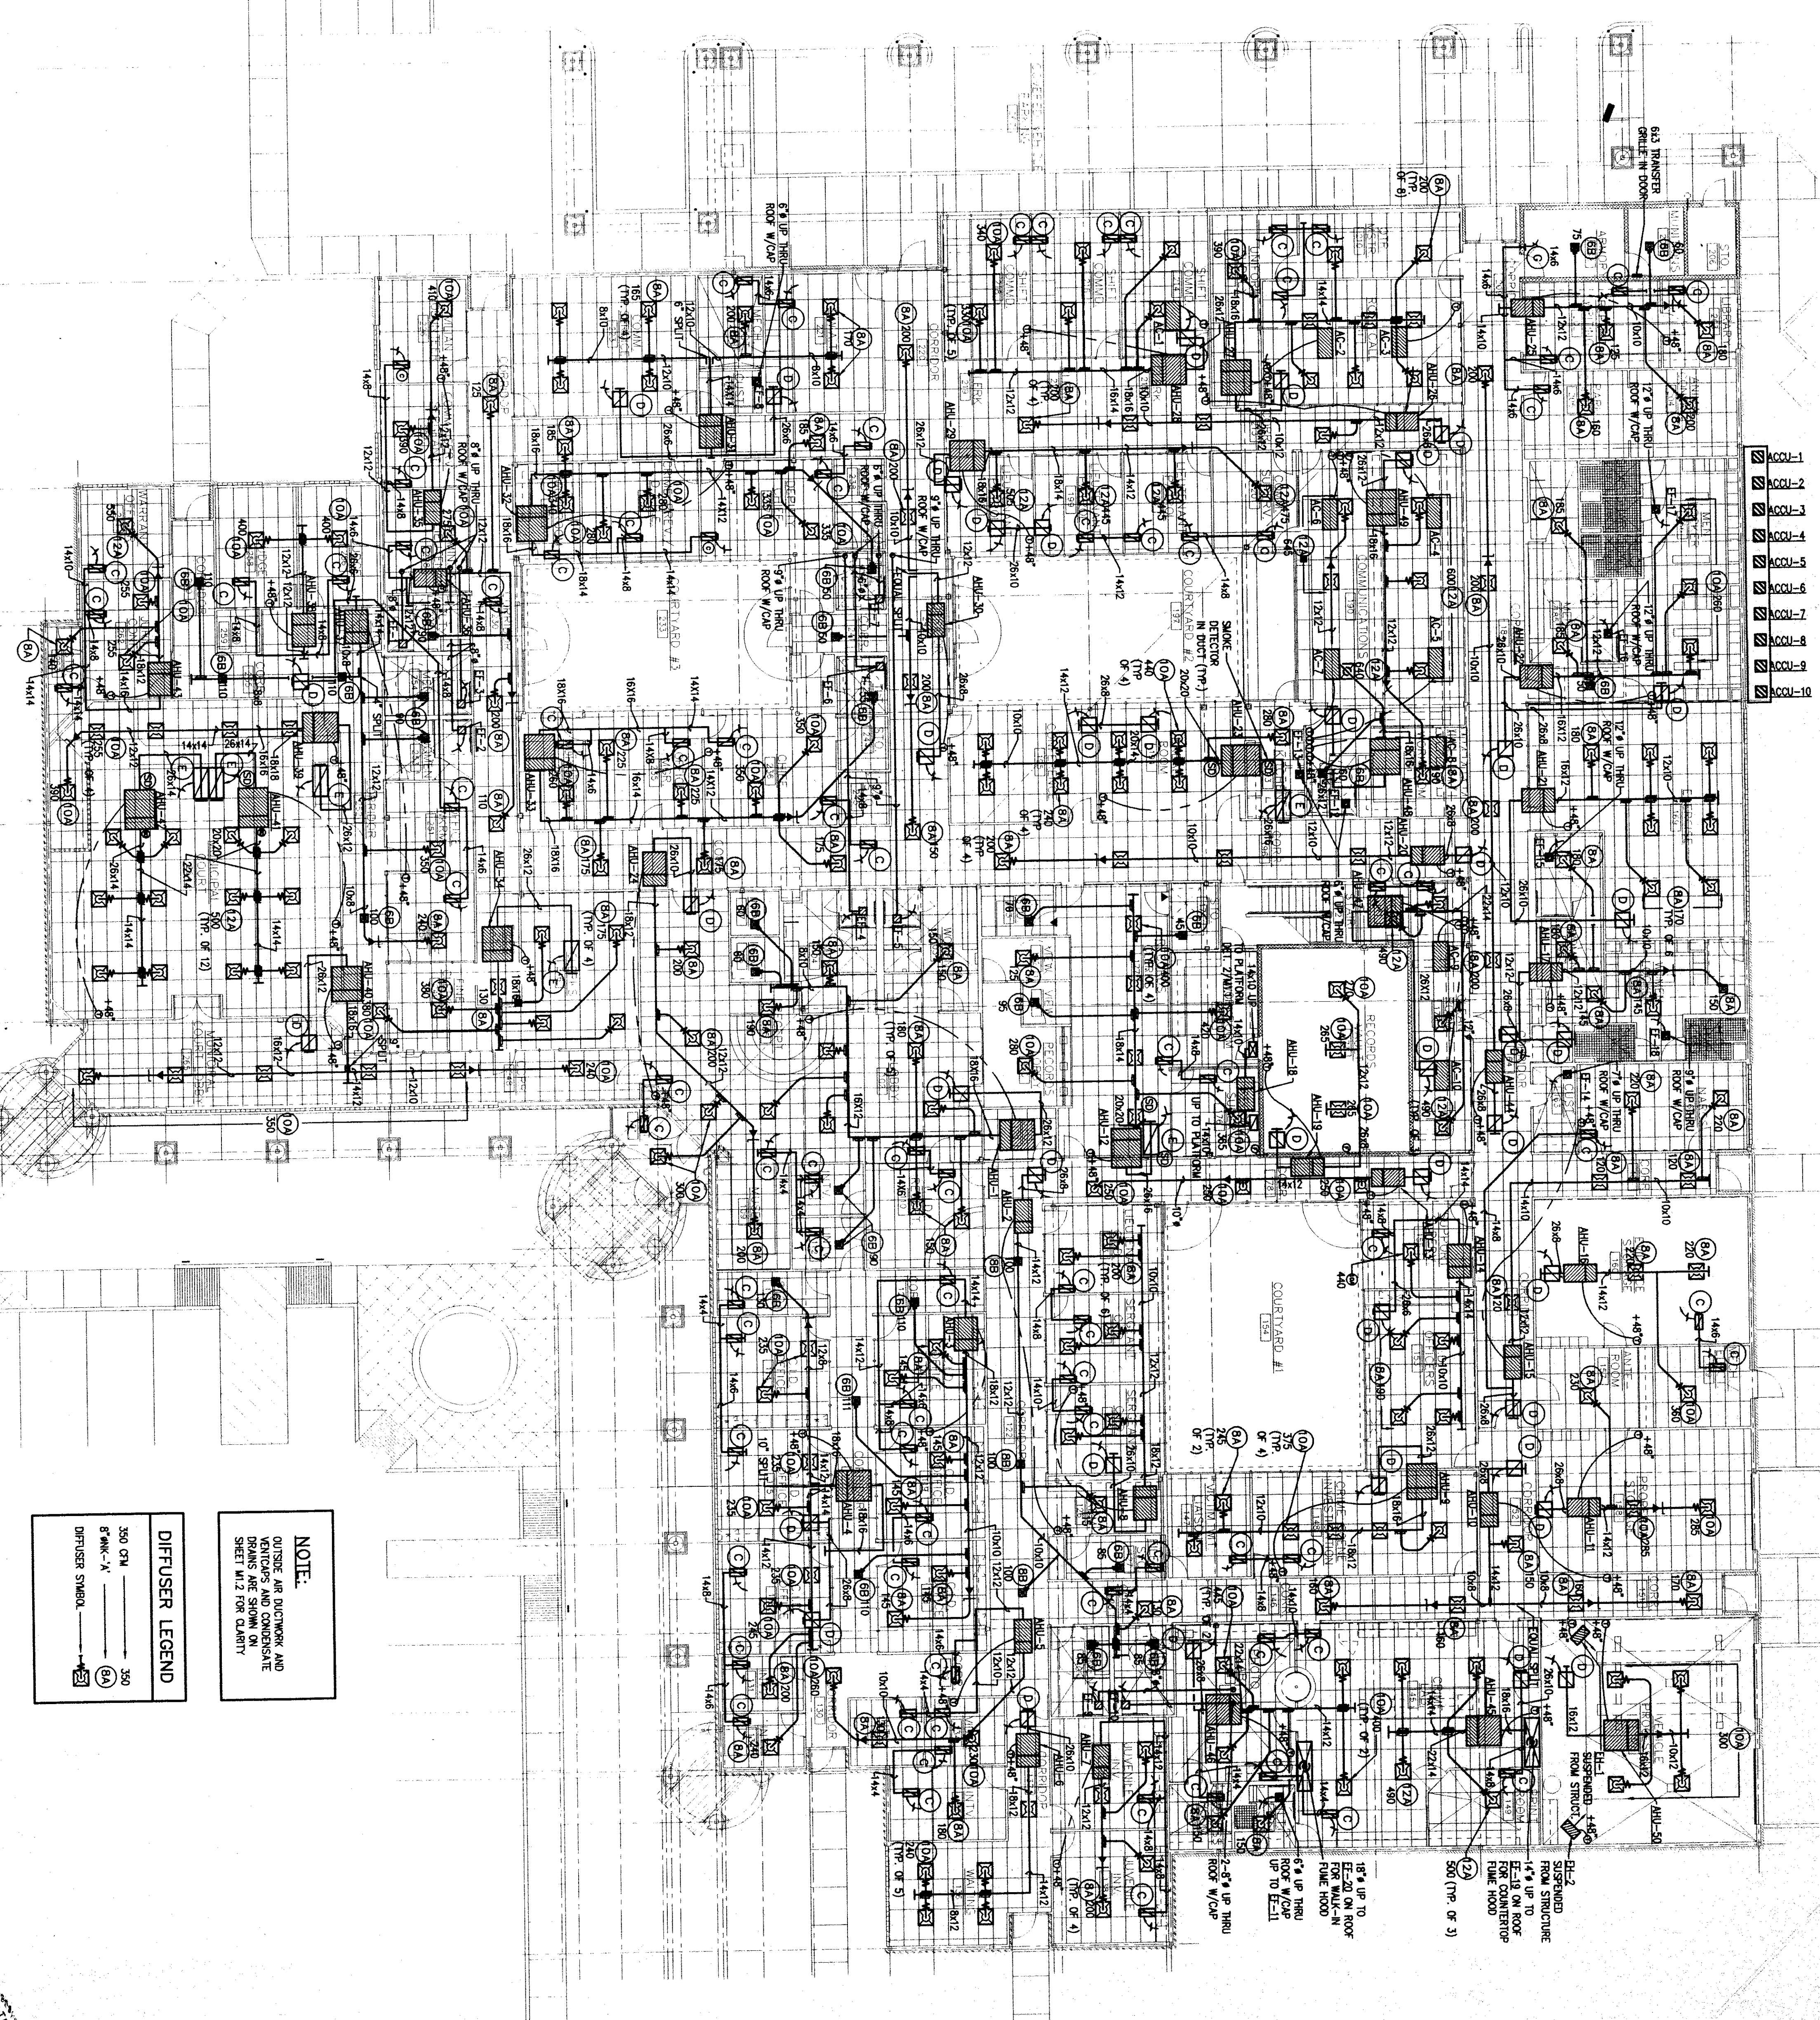

1 FLOOR PLAN - HVAC


SCALE: 3/32" = 1'-0"

NOTE:
OUTSIDE AIR DUCTWORK AND VENTILATION AIR CONDENSATE SLEEVES ARE NOT SHOWN.

DIFFUSER LEGEND

300 QM	300
5" MAK-V	300
DIFFUSER SYMBOL	(A)

TURNER ENGINEERS, INC.
Consulting Engineering Services
2277 N. Central Expressway, Suite 200, Dallas, TX 75208
TEL: 214/291-2800 FAX: 214/291-2801

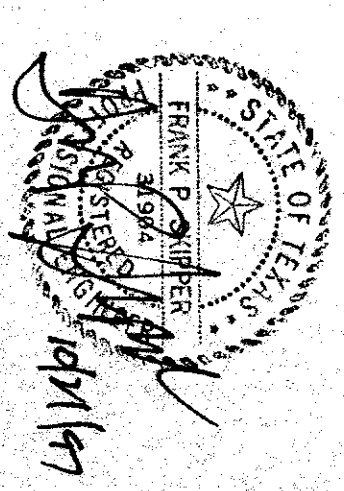

CITY OF CONROE AND MUNICIPAL COURT FACILITY FOR THE CITY OF CONROE, TEXAS

M1.1

FLOOR PLAN
HVAC
REVISIONS

DATE: 10/21/97
DRAWN BY: [Name]
CHECKED BY: [Name]
SCALE: AS SHOWN

WILSON/BSA INC. ARCHITECTS
7010 Greenleaf Ave., Suite 801
Dallas, Texas 75231
(214) 358-2504 Fax
1018 W. Broadway, Suite B
Port Neches, Texas 75884
(409) 338-0211 Fax

5/17/98