


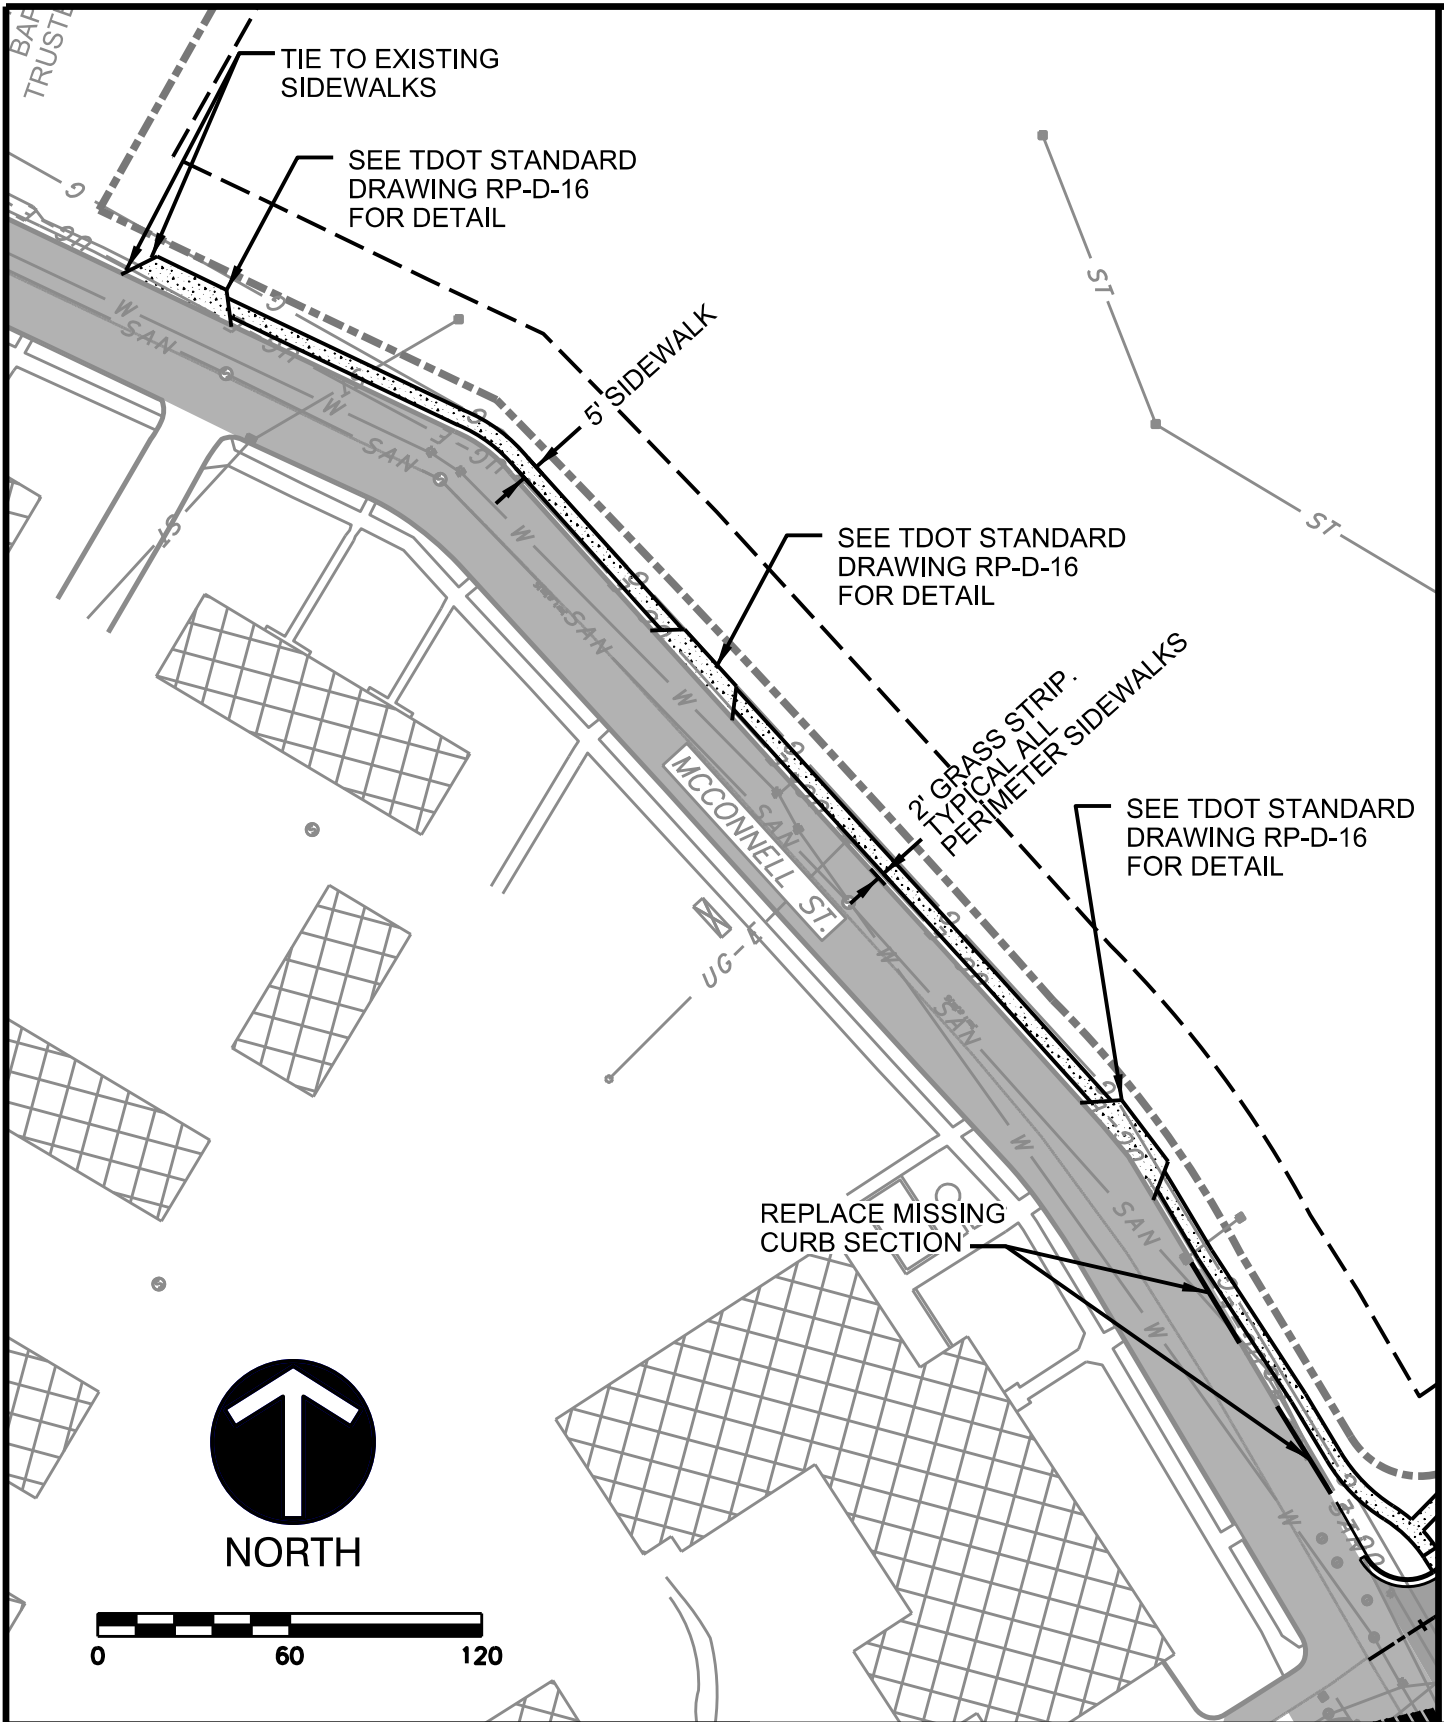
**Civil & Environmental Consultants, Inc.**

www.cecinc.com

FIVE POINTS PHASE 2  
INFRASTRUCTURE IMPROVEMENTS  
FIVE POINTS, KNOXVILLE, TN

SITE DEMOLITION PLAN ADDENDUM

DRAWN BY:	GMW	CHECKED BY:	GHP	APPROVED BY:	GMW	FIGURE NO.:	C112A 
DATE:	JULY 6, 2016	DWG SCALE:	AS SHOWN	PROJECT NO.:	140-828		



**CEC**  
**Civil & Environmental Consultants, Inc.**


www.cecinc.com

FIVE POINTS PHASE 2  
 INFRASTRUCTURE IMPROVEMENTS  
 FIVE POINTS, KNOXVILLE, TN

SITE LAYOUT PLAN ADDENDUM

DRAWN BY: GMW	CHECKED BY: GHP	APPROVED BY: GMW	FIGURE NO.:
DATE: JULY 6, 2016	DWG SCALE: AS SHOWN	PROJECT NO: 140-828	<b>C210A</b>

SEE SHEET C211 FOR CONTINUATION

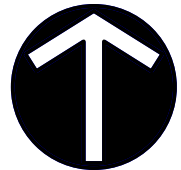


NORTH



KUB TO LOCATE  
NEW MASTER METER  
\$21,297.00 TAP FEE  
TO BE PAID BY  
CONTRACTOR

CONTRACTOR TO INSTALL NEW FIRE  
HYDRANT ASSEMBLY DOWNSTREAM  
OF WATER METER. HYDRANT TO BE  
PAINTED RED. HYDRANT TO BE FLOW  
TESTED AFTER INSTALLATION AND  
BONNET PAINTED ACCORDING TO  
CITY GUIDELINES

CONTRACTOR TO RECONNECT  
EXISTING 6" WATER SYSTEM TO  
KUB METER LOCATION. CONNECTION  
TO BE MADE UPSTREAM OF PRV.  
COORDINATE CONNECTION WITH KUB  
AND OWNER TO MINIMIZE WATER SHUT  
OFF DURATION

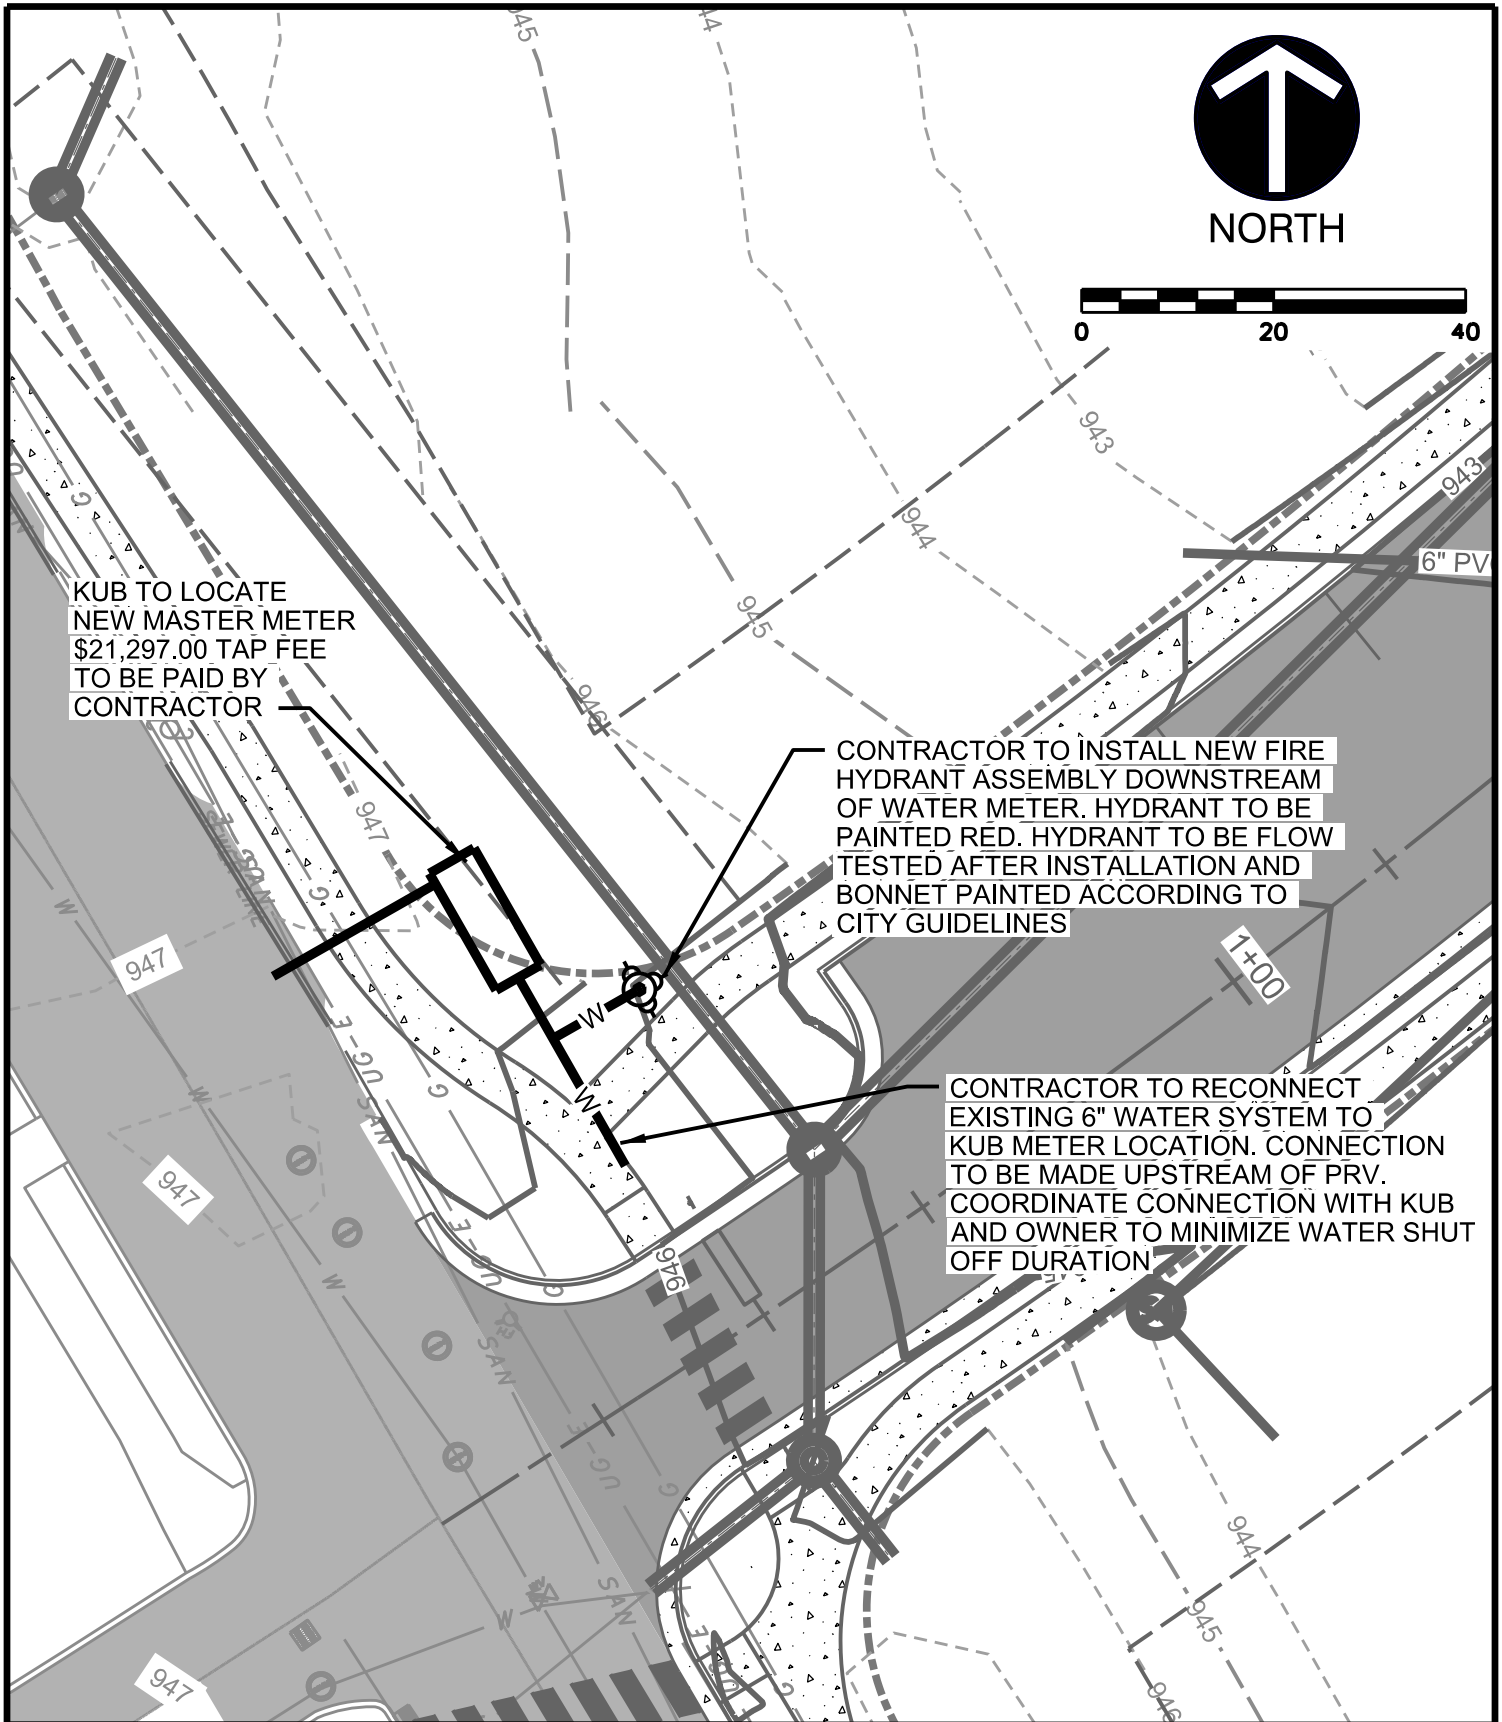

**Civil & Environmental Consultants, Inc.**

www.cecinc.com

FIVE POINTS PHASE 2  
INFRASTRUCTURE IMPROVEMENTS  
FIVE POINTS, KNOXVILLE, TN

SITE UTILITY PLAN ADDENDUM

DRAWN BY:	GMW	CHECKED BY:	GHP	APPROVED BY:	GMW	FIGURE NO.:	C511A
DATE:	JULY 6, 2016	DWG SCALE:	AS SHOWN	PROJECT NO.:	140-828		