



DRAWING NOTES

- 1 PROVIDE 200A/3P BRANCH CIRCUIT TO NEW NEMA 3R JUNCTION BOX TO BE INSTALLED ON COLUMN. JUNCTION BOX TO SERVE AS CONNECTION POINT FOR DISTRIB BOXES (PROVIDED BY OTHERS) AND CONTAIN CAM-LOCK CONNECTIONS AS WELL AS A DIRECT-CONNECT OPTION. OWNER'S AV PRODUCTION CONSULTANT TO PROVIDE SPECIFIC CONNECTOR SPECIFICATION. FIELD COORDINATE BOX MOUNTING HEIGHT WITH OWNER PRIOR TO ROUGH-IN. PROVIDE A \$3000 ALLOWANCE PER BOX IN BID.
- 2 PROVIDE JUNCTION BOX AND TERMINATE EXISTING CONDUITS STUBBED UP IN THIS AREA INTO BOX.
- 3 PROVIDE 3" FROM JUNCTION BOX IN DRAWING NOTE 2 TO BE ROUTED AS SHOWN ON GROUND ALONG BACK WALL BETWEEN WALL AND EXISTING FLOOR DRAIN. WHERE CONDUIT CROSSES FLOOR OVER TO COLUMN, PROVIDE PIPE COVER TO PROTECT CONDUIT.
- 4 INSTALL NEW METER SERVING PANEL 'PA2' ON UNISTRUT STAND IN THIS AREA.


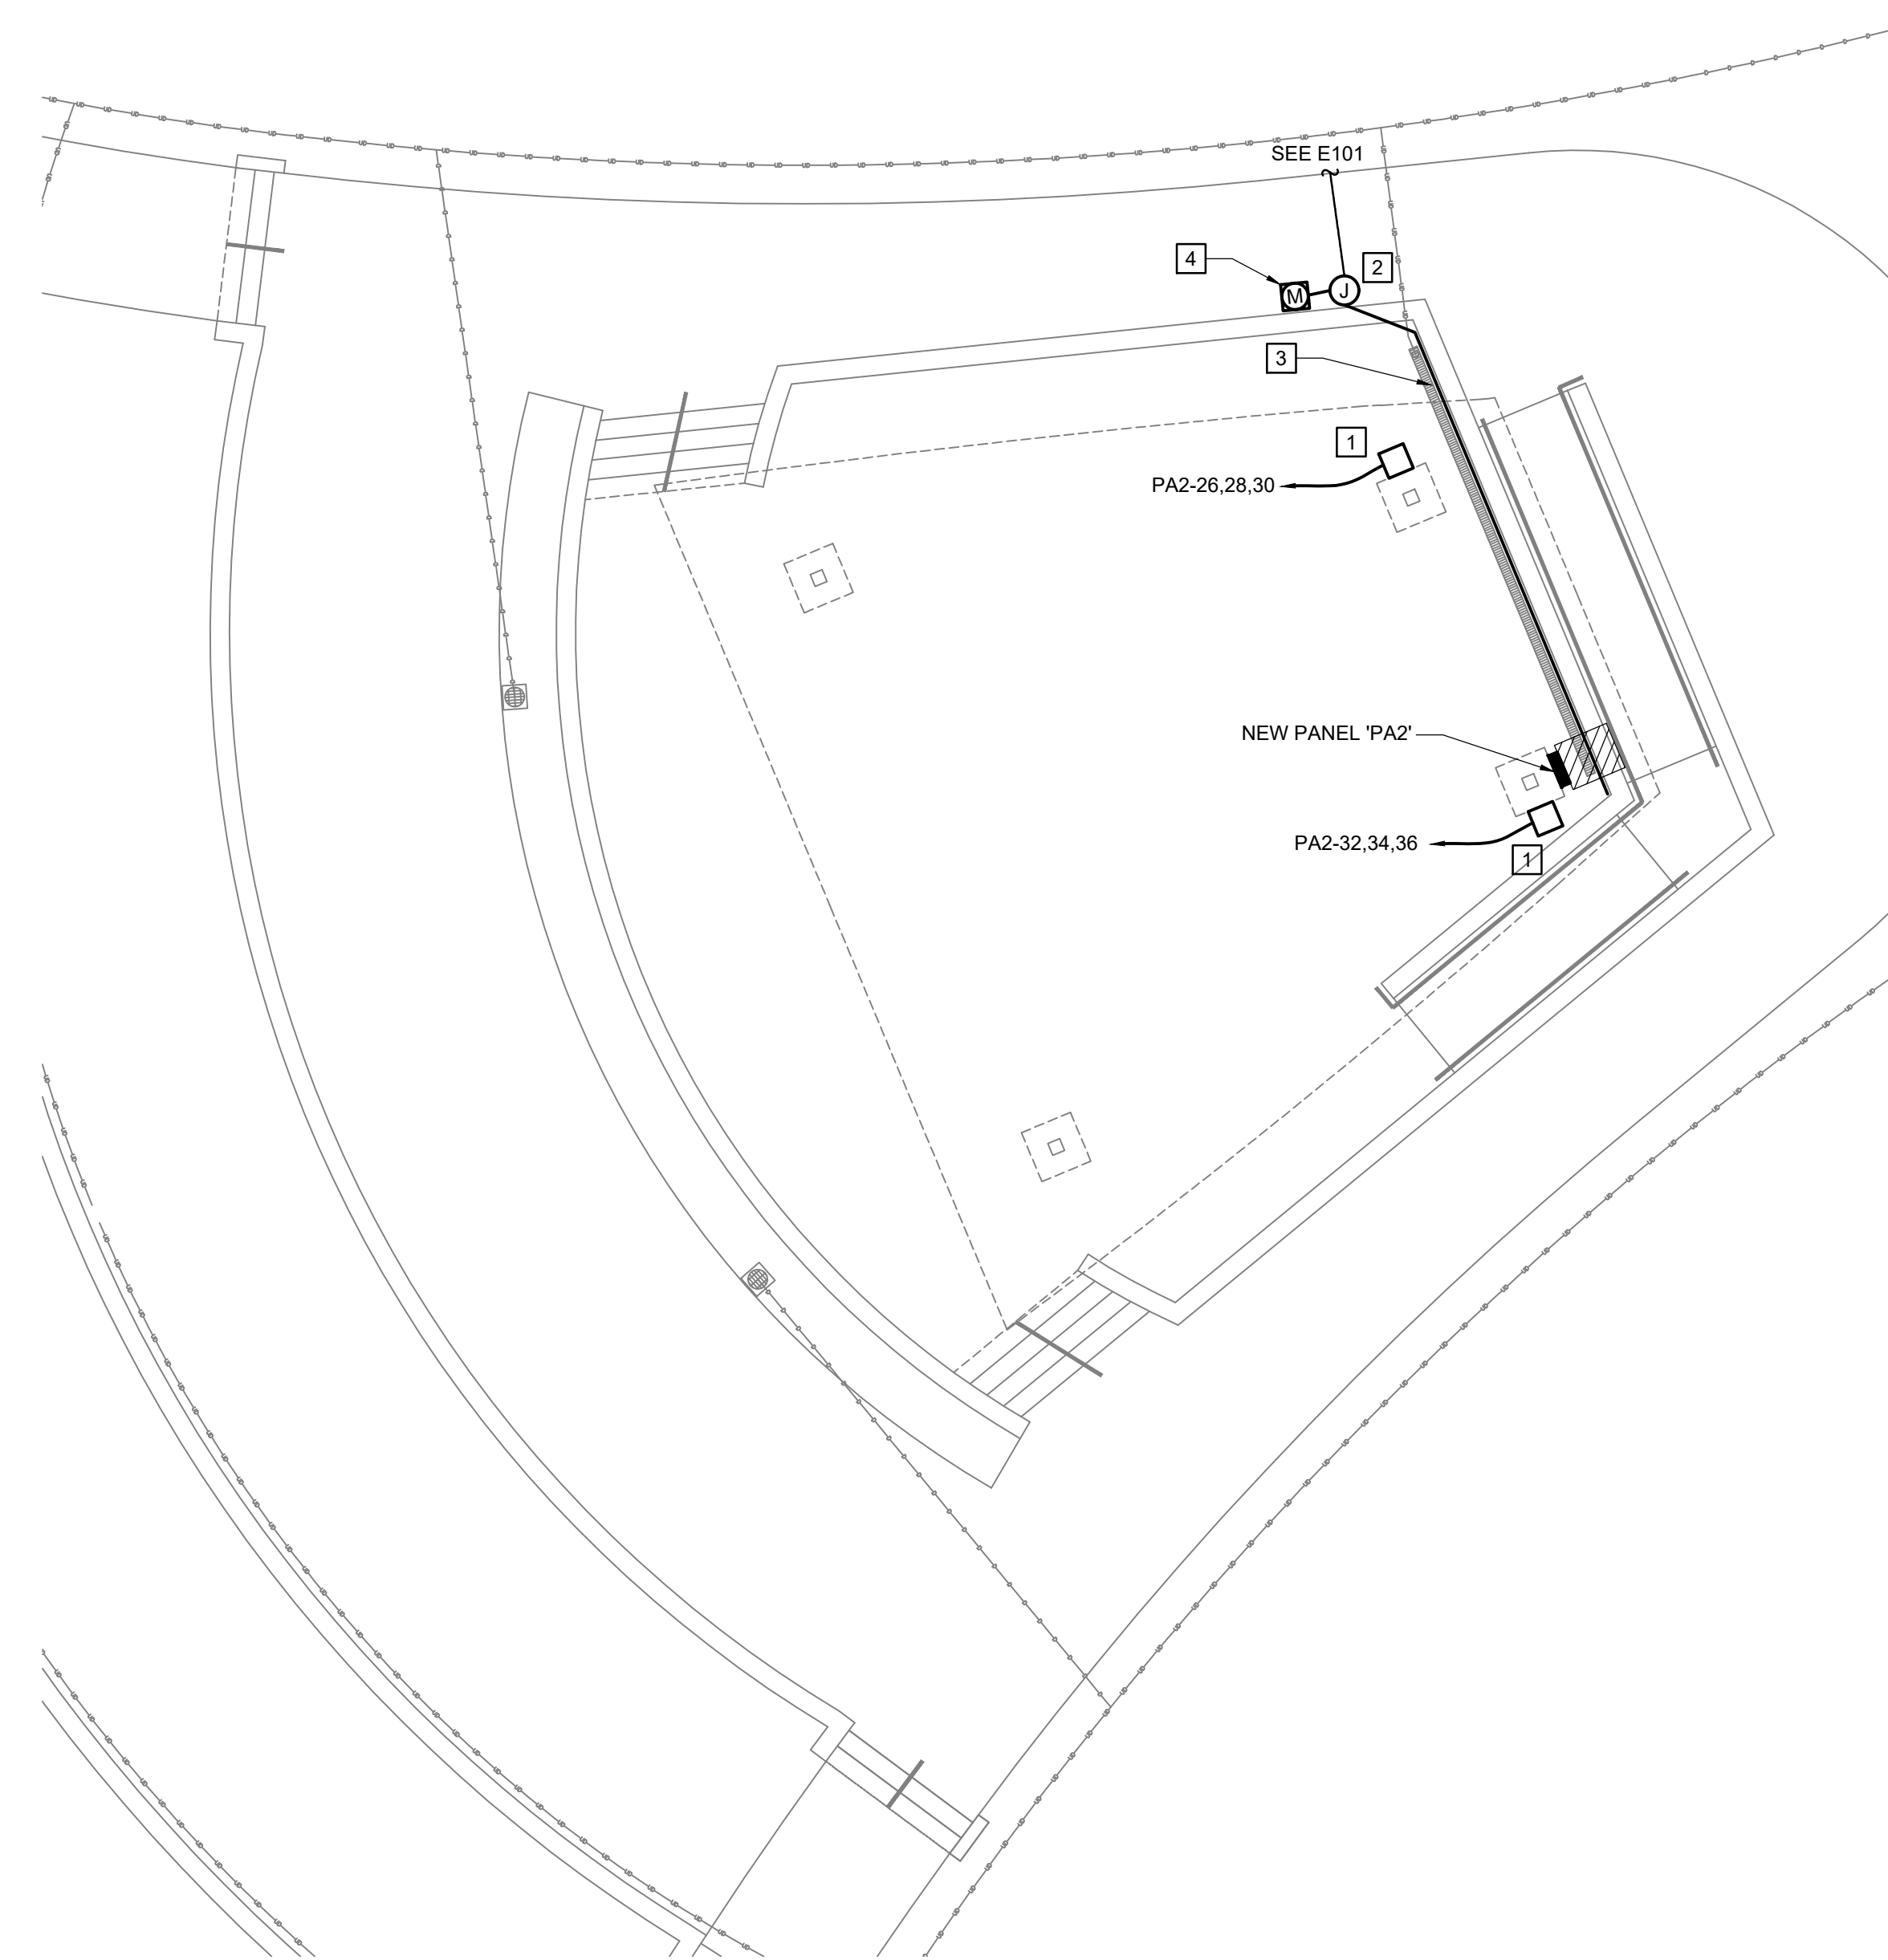


A3 AMPHITHEATER PLAN - ELECTRICAL

 SCALE: 1/8" = 1'-0"



**CONSTANTINE
ENGINEERING
ASSOCIATES, LLC**
1043B Swannah Hwy, #181, Charleston, SC 29407
Phone: 843.668.7878, Fax: 843.668.7881

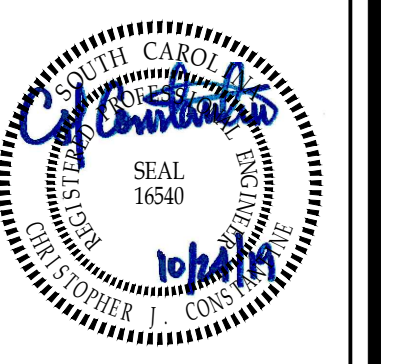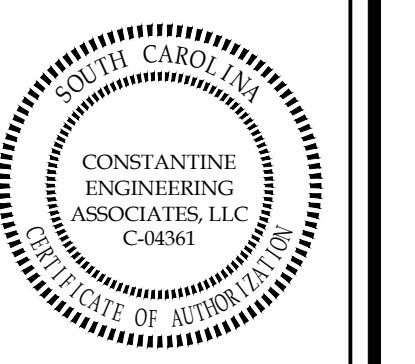

HANAHAN RECREATION CENTER
3100 MABELINE ROAD
HANAHAN, SC 29410

BUILDING AND AMPHITHEATER ELECTRICAL PLANS

REVISIONS:	DATE	BY	CLM
1	10/24/19	JPC	CLM

DESIGNED BY: CLM
DRAWN BY: JPC
CHECKED BY: CJC
DATE: 10/08/19

JOB NUMBER
19-080

SHEET NUMBER
E201