

printing log:


no. date remarks

revision log:

no. date remarks

FOLEY JUSTICE CENTER
foley, alabama

professional seal:

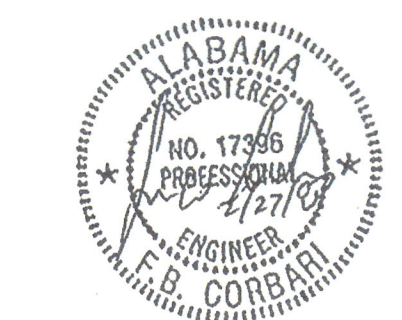

released for construction

CDC ENGINEERS
21 East Wright Street Panama City, Florida 32505-4800

job number:

7024


date:

23 FEB 98

sheet title & no.


ELEC. SITE PLAN

E1

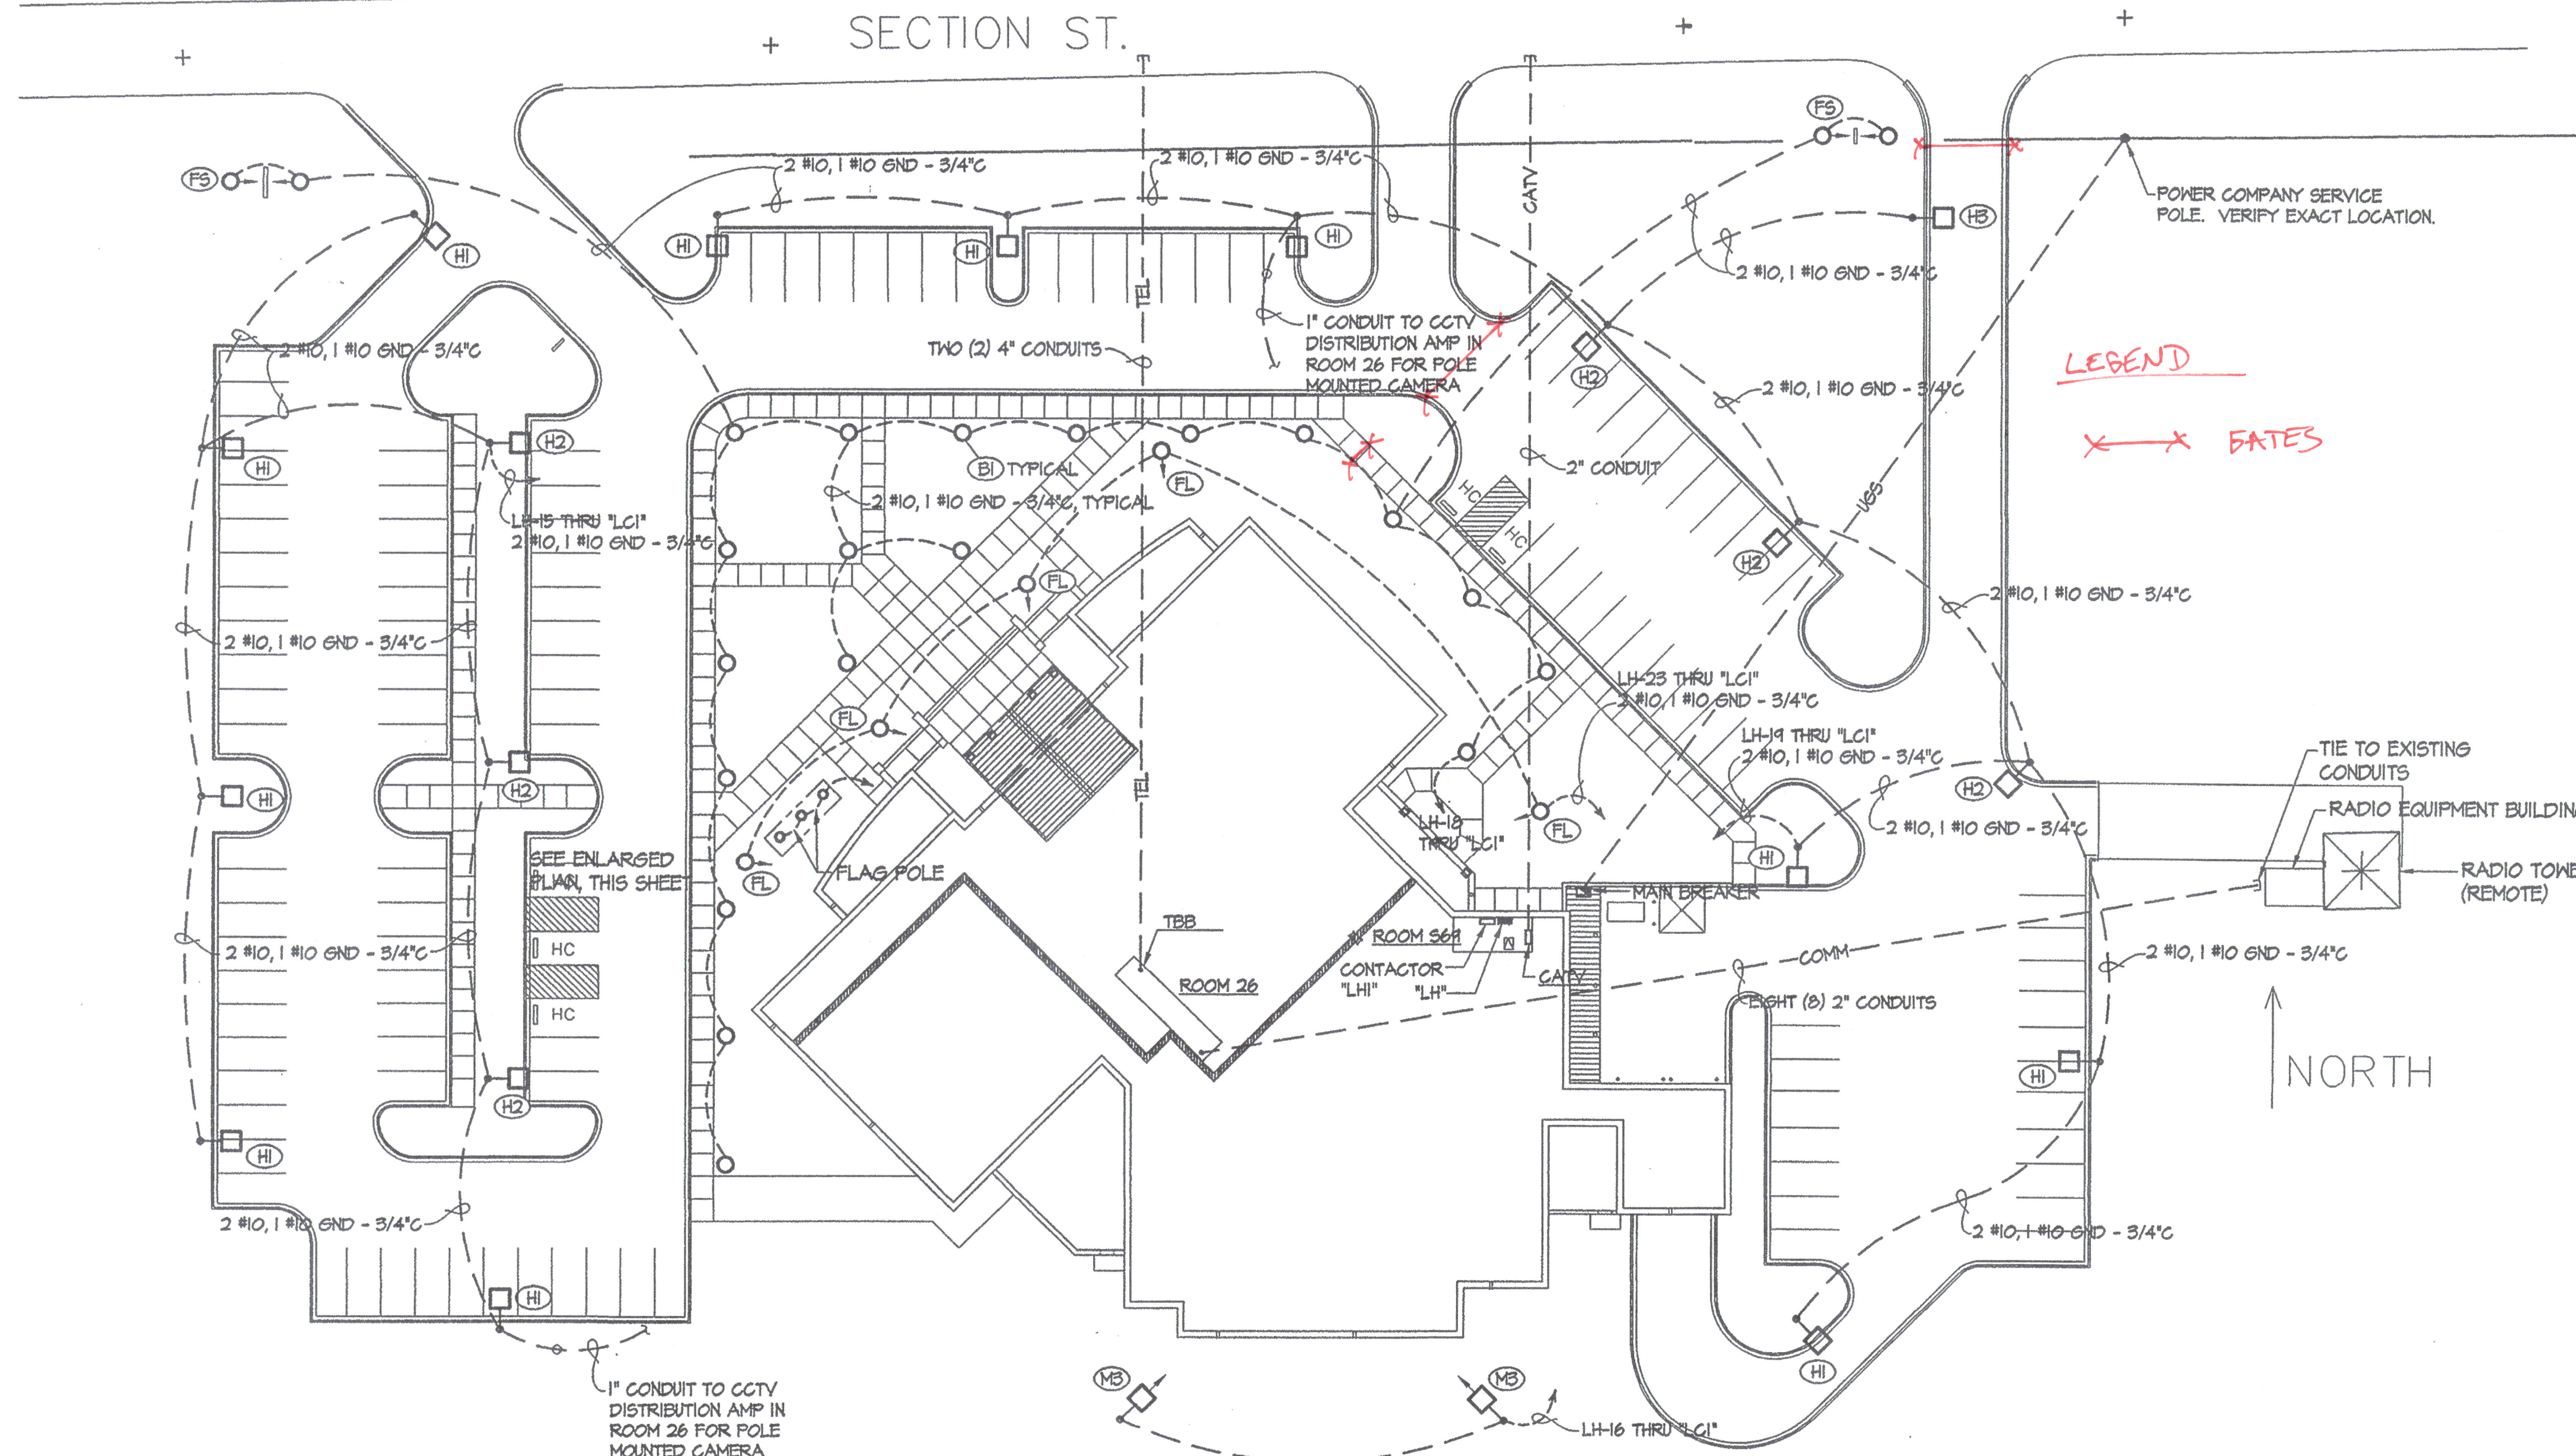


LEGEND
X X FATES


NORTH

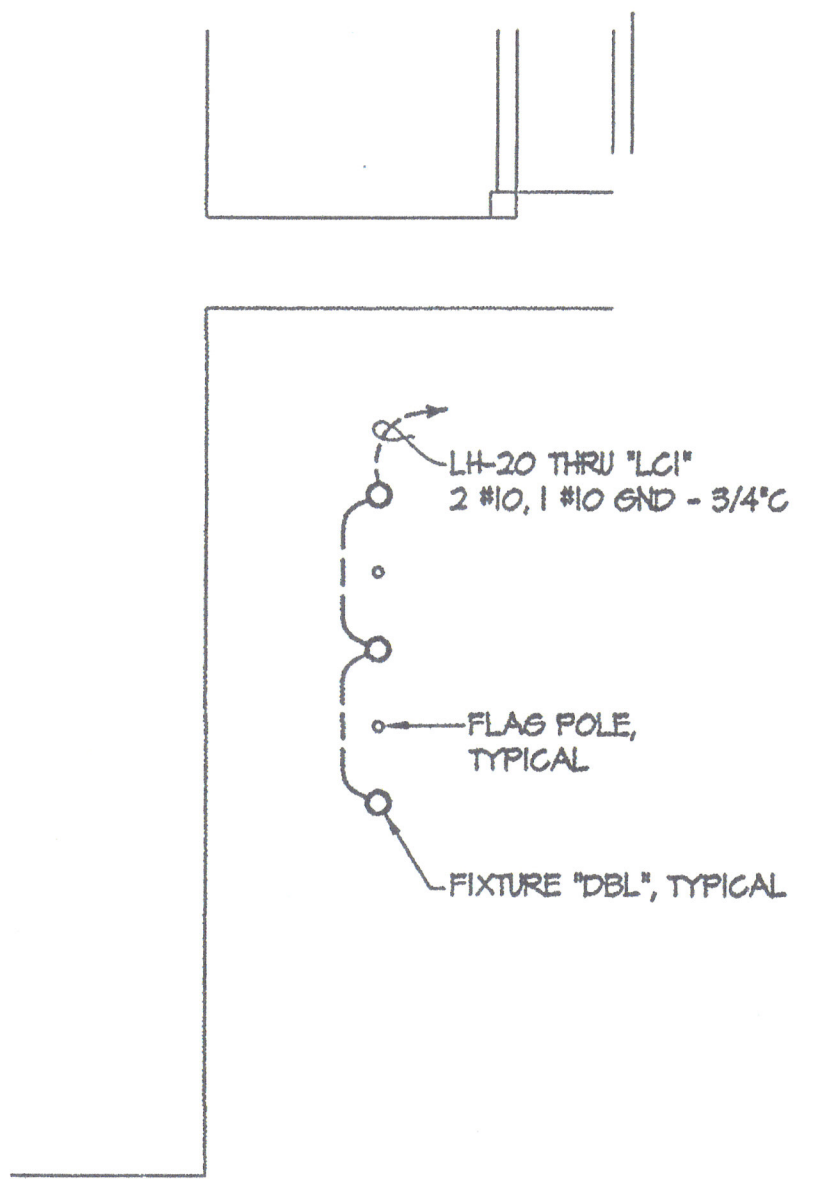


PARTIAL ELECTRICAL PLAN
SCALE: 1" = 10'-0"

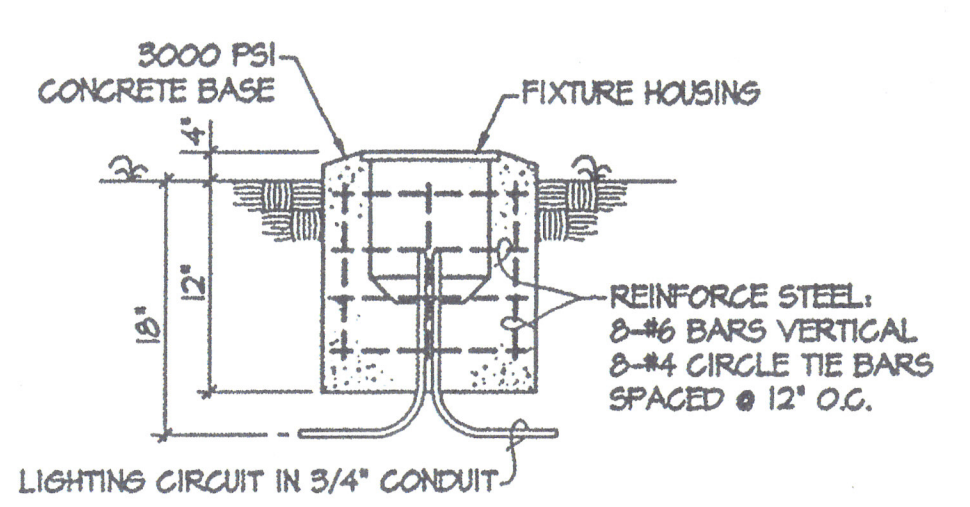

CONCRETE BASE DETAIL
FIXTURE "DBL"
NOT TO SCALE

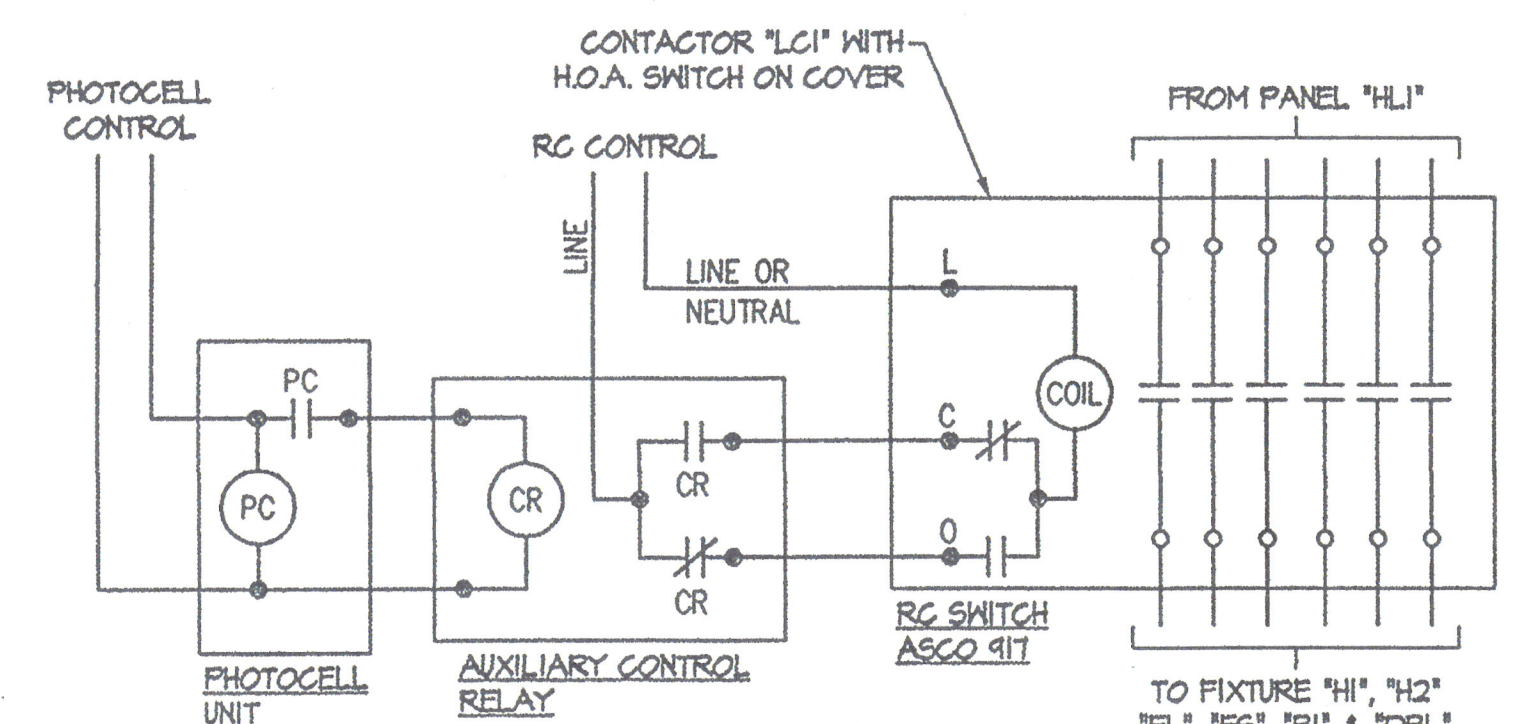


PARKING LOT LIGHTING CONTROL DIAGRAM
NOT TO SCALE

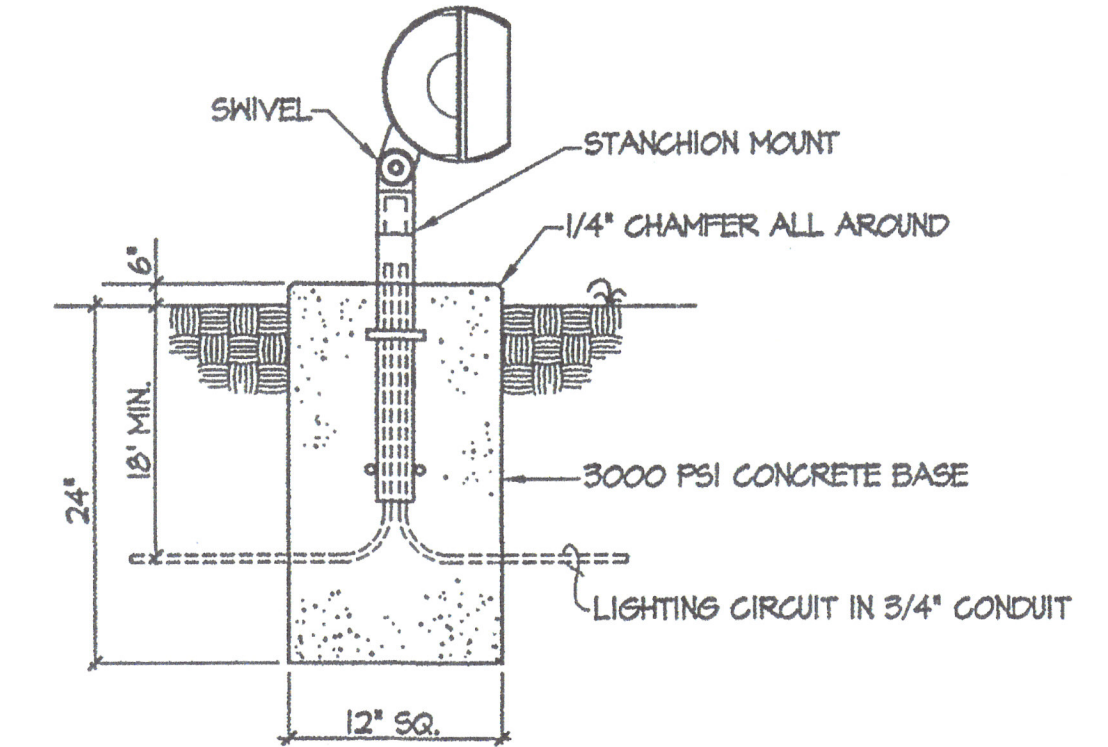


CONCRETE BASE DETAIL
FIXTURE "FL" & "FS"
NOT TO SCALE

ELECTRICAL SITE PLAN
SCALE: 1" = 30'-0"
SEE SHIT. C-1 FOR ACTUAL PARKING LAYOUT

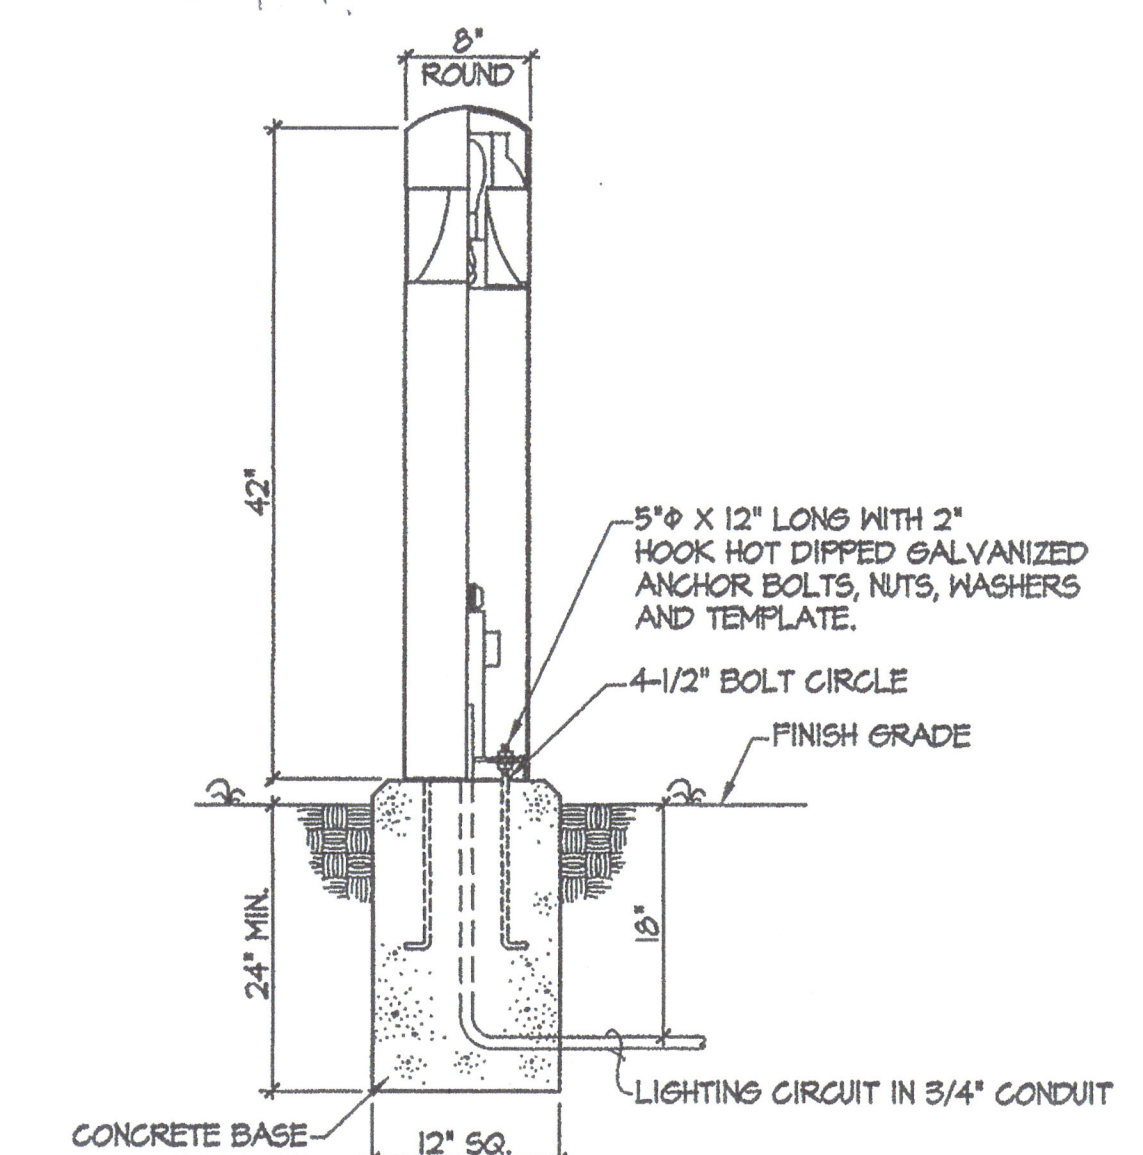

CONCRETE BASE DETAIL
FIXTURE "B1"
NOT TO SCALE

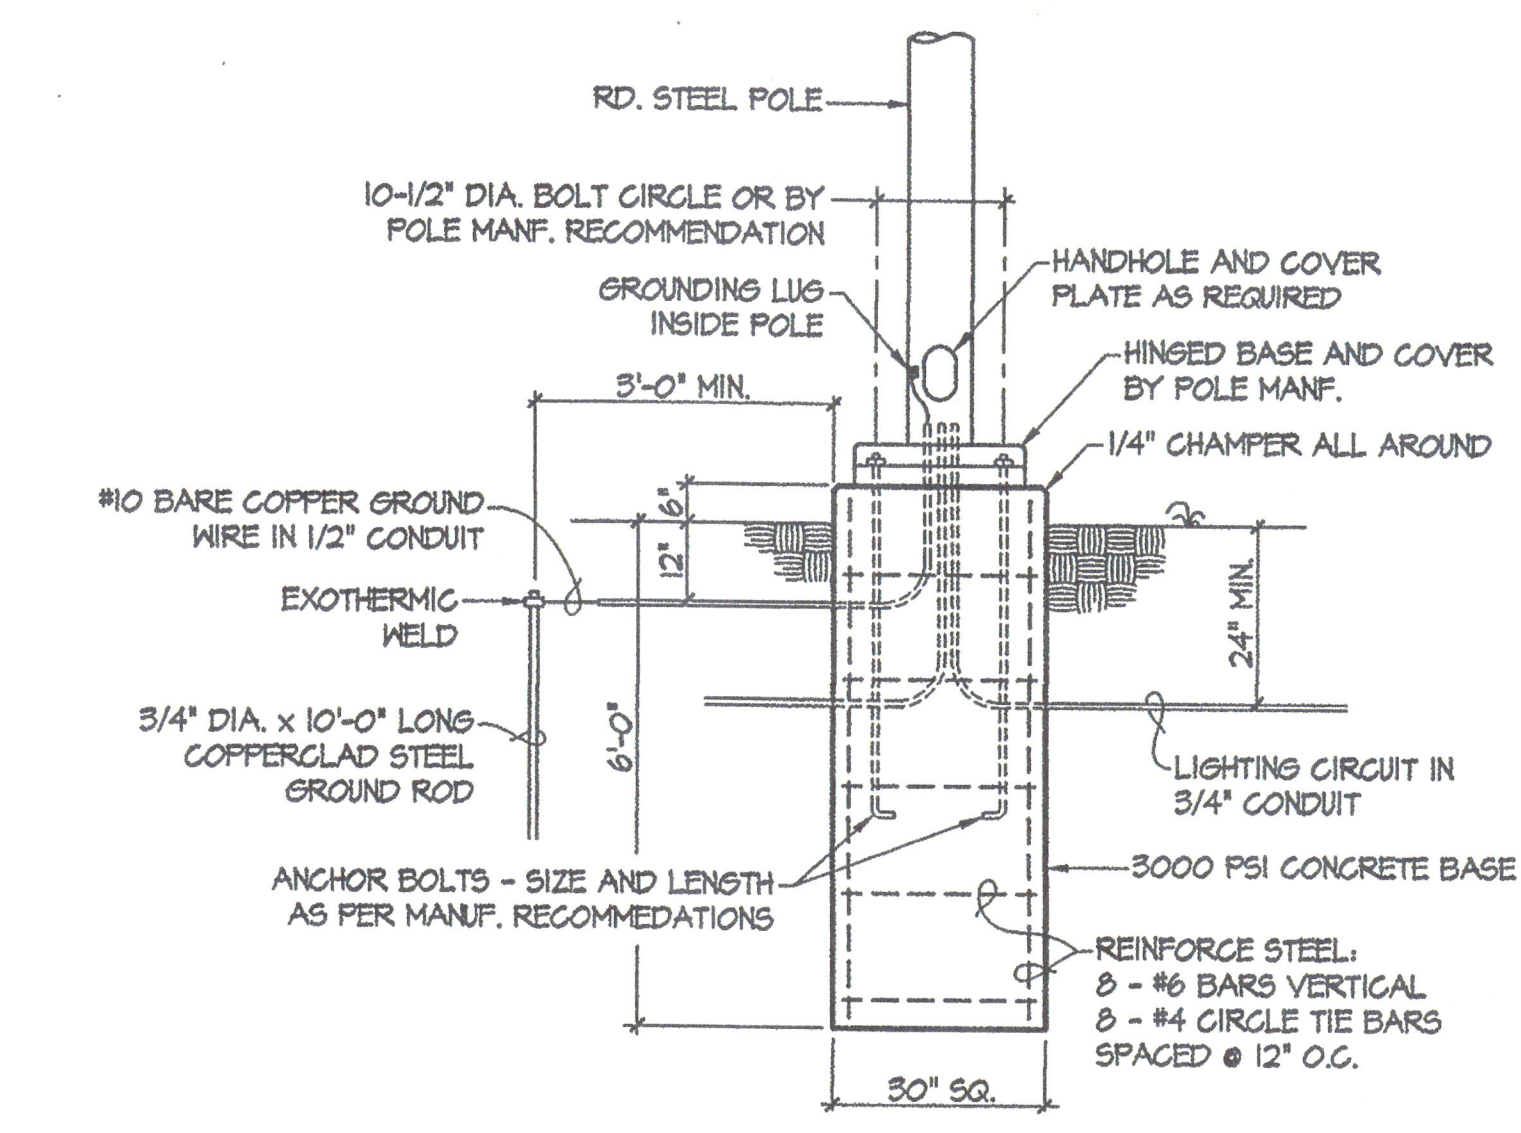

CONCRETE BASE DETAIL
FIXTURES "H1", "H2" & "M3"
NOT TO SCALE

