


GENERAL NOTE: EXTERIOR SCALL APPROXIMATE. INTERIOR FLOOR PLAN NOT AVAILABLE. CONFIRM EXACT CAMERA LOCATIONS WITH WITH NCC ADMINISTRATION/INSTRUCTORS PRIOR TO INSTALLATION.

2 NORTHLAND CAREER CENTER SECURITY PLAN ANNEX  
1/16" = 1'-0"

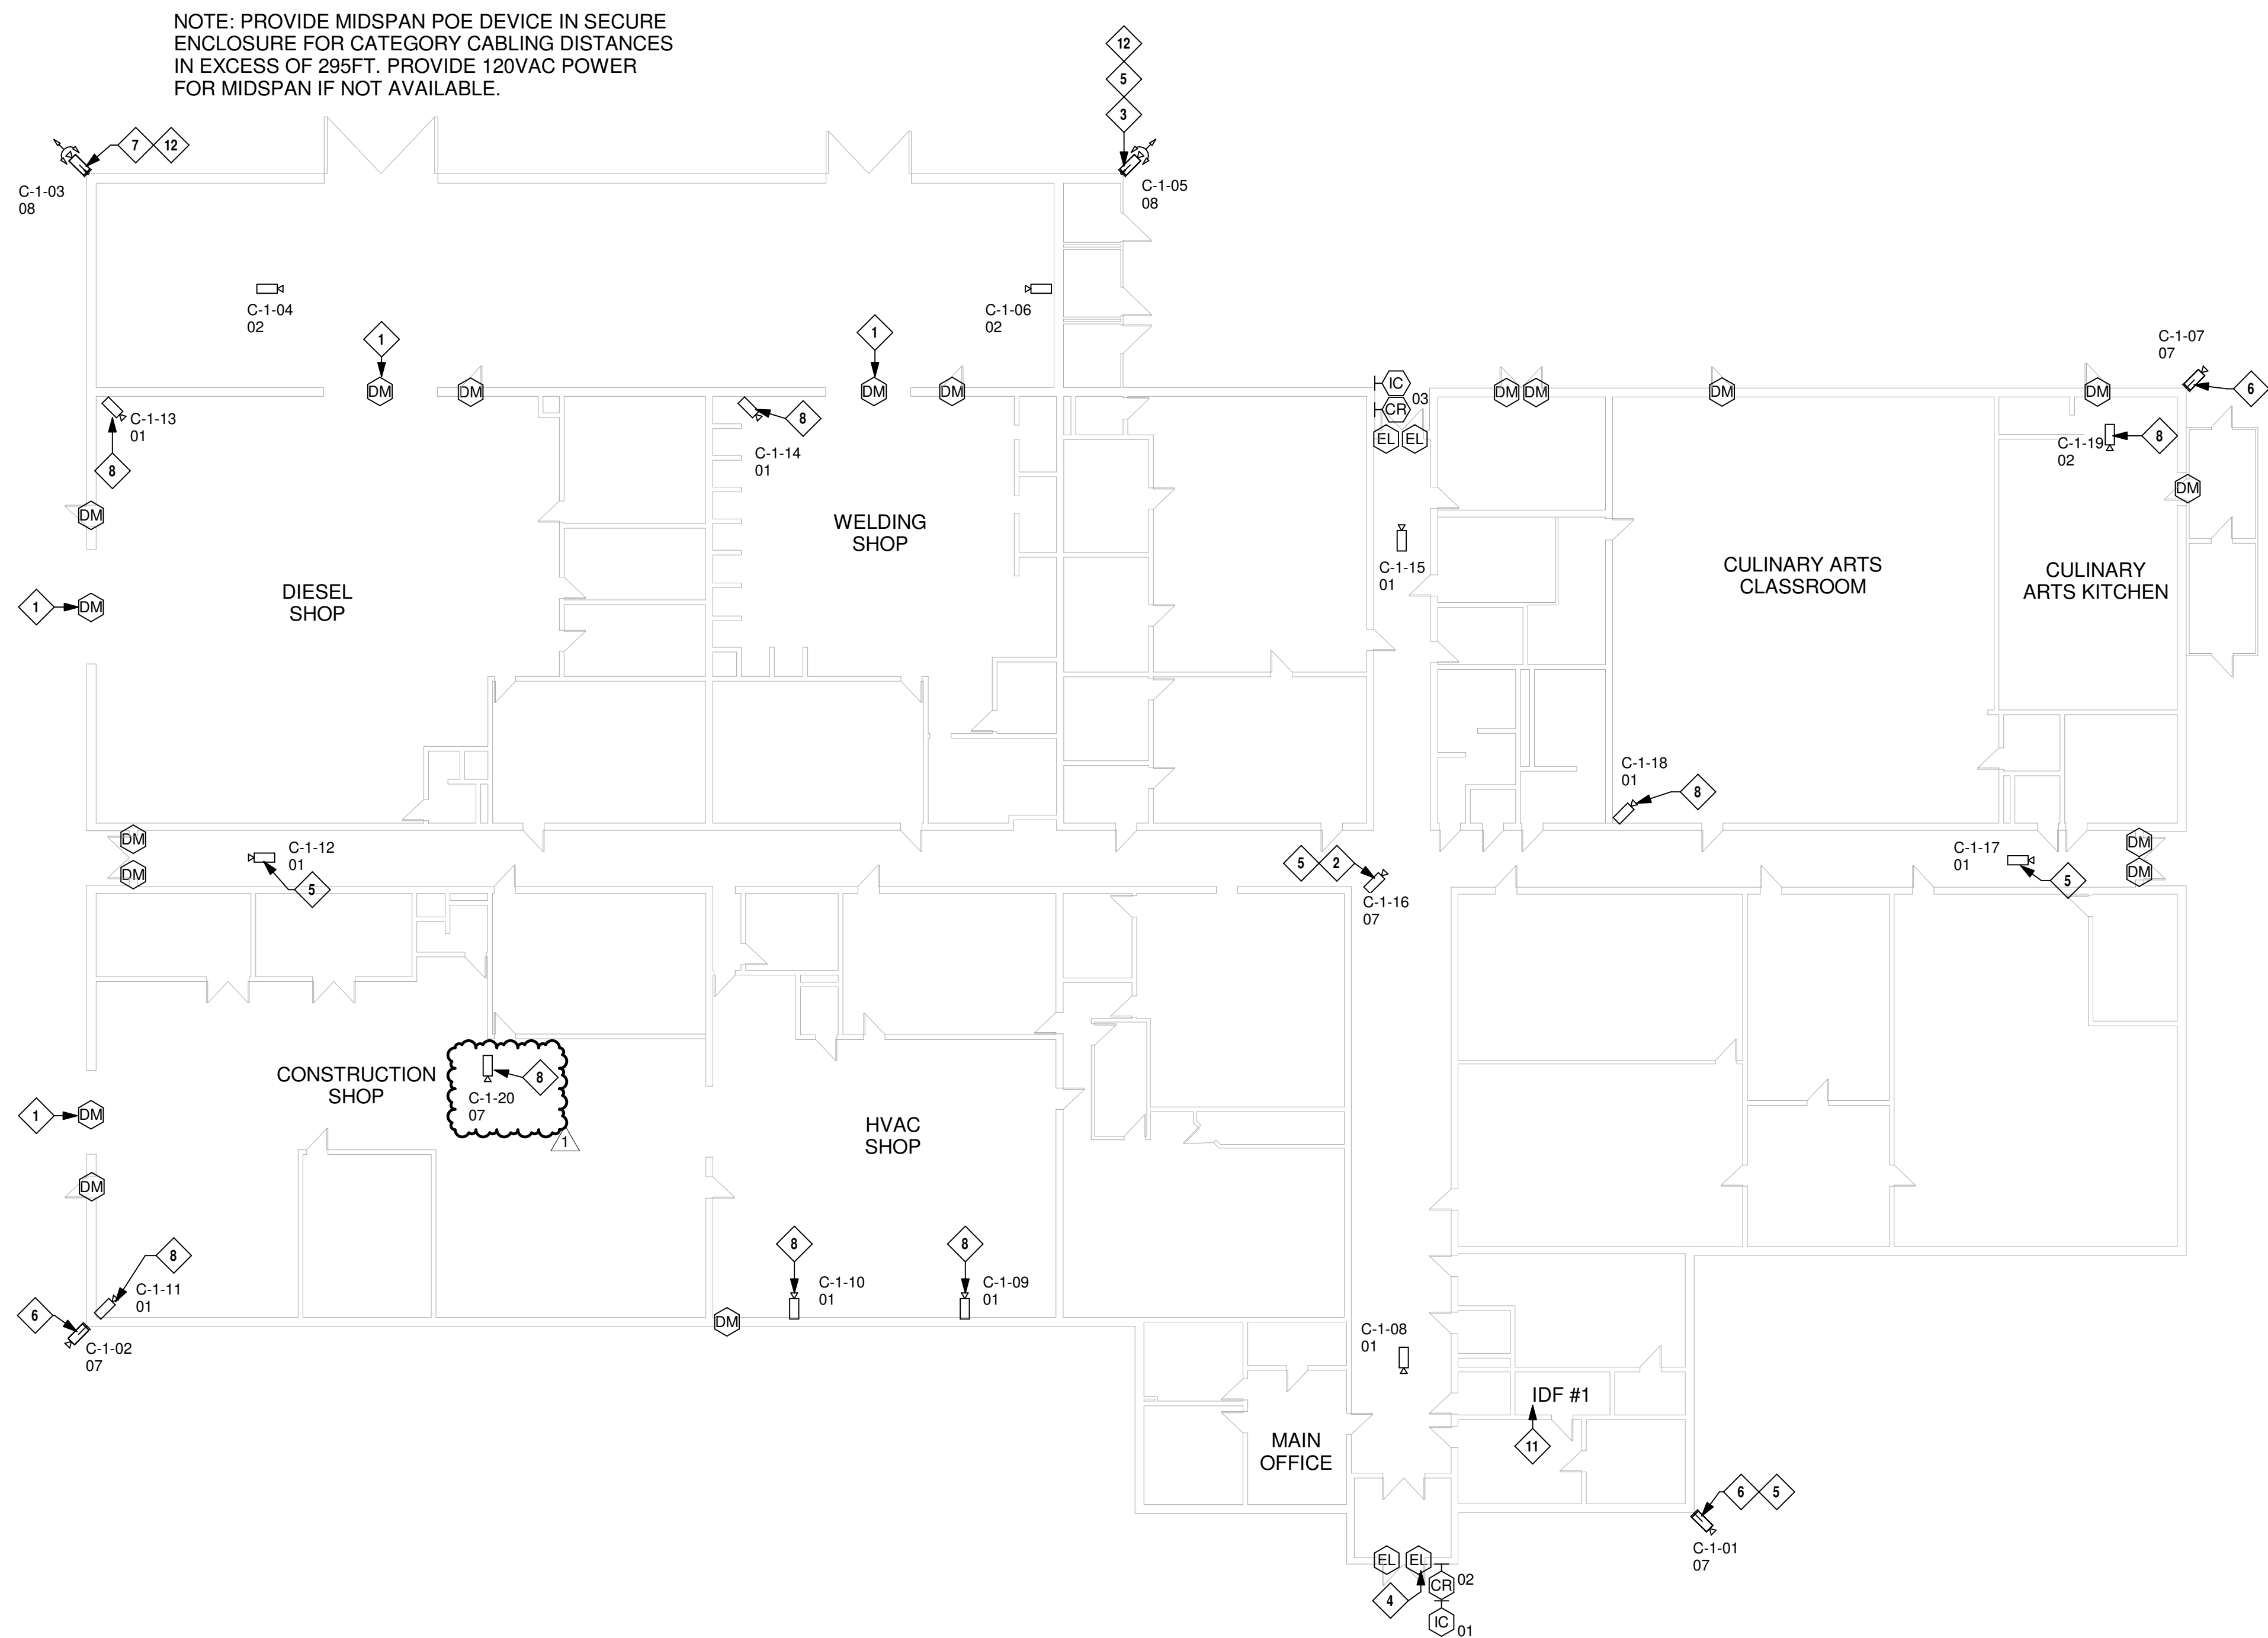

1 NORTHLAND CAREER CENTER SECURITY PLAN LEVEL 1  
1/16" = 1'-0"

**GENERAL NEW NOTES:**

1. ALL CAMERAS SHOWN ARE NEW UNLESS OTHERWISE NOTED. PROVIDE NEW CATEGORY 6 CABLE TO NEAREST IDF AND SALIENT LICENSING.
2. INTEGRATE EXISTING NEW CAMERAS AND VIDEO INTERCOMS WITH RS2 ACCESS CONTROL SYSTEM. PROVIDE ANY ADDITIONAL LICENSING REQUIRED TO COMPLETE INTEGRATION.

**SECURITY PLAN NOTES**

1. PROVIDE OVERHEAD DOOR MONITOR.
2. PROVIDE RECESSED MOUNT ACCESSORY.
3. PROVIDE WALL ARM AND CORNER MOUNT BRACKET.
4. EXISTING ADA OPERATOR. INTEGRATE ADA OPERATOR WITH ACCESS CONTROL SYSTEM.
5. REMOVE EXISTING ANALOG CAMERA. INSTALL NEW IP CAMERA.
6. PROVIDE P3717-PLC AND CORNER MOUNT BRACKET. PROVIDE NEW CATEGORY 6 CABLE TO NEAREST IDF.
7. PROVIDE CORNER MOUNT ADAPTER.
8. CONFIRM EXACT LOCATION OF CAMERA WITHIN SHOP CLASSES WITH SCHOOL ADMINISTRATION/INSTRUCTORS PRIOR TO INSTALLATION.
9. EXISTING FALCON ELECTRIFIED PANIC BAR, DOOR MONITOR AND PIR REQUEST TO EXIT. MODIFY, RETROFIT, OR REPLACE AS NECESSARY TO PROVIDE ELECTRIFIED LATCH RETRACTION AND ELECTRIC DOGGING FUNCTION. ADD ADDITIONAL DOOR POSITION MONITOR TO SECOND LEAF.
10. PROVIDE NEW DOOR MONITOR.
11. ALL EQUIPMENT SERVED FROM IDF. PROVIDE NEW SALIENT SERVER AND LICENSING FOR NORTHLAND CAREER CENTER CAMERAS.
12. MOUNT AT HIGHEST ELEVATION POSSIBLE.

<b>HENDERSON ENGINEERS</b> 8345 LENEKA DRIVE, SUITE 300 LENEKA, KS 66214 TEL (913) 742-5000 FAX (913) 742-5001 WWW.HENDERSONENGINEERS.COM 1550004765 MO. CORPORATE NO. E-556D EXPIRES 12/31/2020	
REVISIONS	
1 Addendum	01/30/20
#1	

**PLATTE COUNTY SCHOOL DISTRICT R-III**  
 NORTHLAND CAREER CENTER SECURITY UPGRADES  
 1804 BRANCH ST., PLATTE CITY, MO 64079

△ REVISION	DATE
1 Addendum	01/30/20
#1	

HEI JOB NO: 1950004765  
 DATE: 01/02/2020  
 DESIGNED BY: RNM

NORTHLAND CAREER CENTER SECURITY PLAN

SHEET NO.  
**TY102**