


GENERAL NEW NOTES:

1. ALL CAMERAS SHOWN ARE NEW UNLESS OTHERWISE NOTED. PROVIDE NEW CATEGORY 6 CABLE TO NEAREST IDF AND SALIENT LICENSING.
2. INTEGRATE EXISTING NEW CAMERAS AND VIDEO INTERCOMS WITH RS2 ACCESS CONTROL SYSTEM. PROVIDE ANY ADDITIONAL LICENSING REQUIRED TO COMPLETE INTEGRATION.

SECURITY PLAN NOTES

- PROVIDE AXIS Q6000-F WITH L6128E
2. CONTRACTOR SHALL PROPOSE AND SUBMIT DETAILS FOR A COMPLETE WORKING SYSTEM IN COMPLIANCE WITH NATIONAL ELECTRICAL CODE. ALL EQUIPMENT SHALL BE ENCLOSED AND ENVIRONMENTALLY RATED FOR LOCAL WEATHER EXTREMES. PERMISSIBLE NETWORK COMMUNICATION METHODS INCLUDE GIGABIT WIRELESS BRIDGE, COAXIAL MEDIA CONVERTOR (VERACITY OR EQUAL) OR NEW FIBER OPTIC CABLE. POWER SOURCE MUST BE CONTINUOUS. POWER MAY BE PROVIDED BY EXISTING PTZ LOW VOLTAGE CONDUCTORS OR LOCAL VAC SOURCE. POWER FROM REMOTELY SWITCHED VAC SOURCE, SUCH AS LIGHTING, MAYBE USED WITH DC BATTERY SYSTEMS SUCH AS COMNET NWKBB100. TEST ALL CABLING TO BE REUTILIZED AND SUBMIT TEST RESULTS TO DESIGN CONSULTANT PRIOR TO BID. TEST RESULTS SHALL INCLUDE AT MINIMUM CONTINUITY, FAULTS, SHORTS, AND LENGTH.

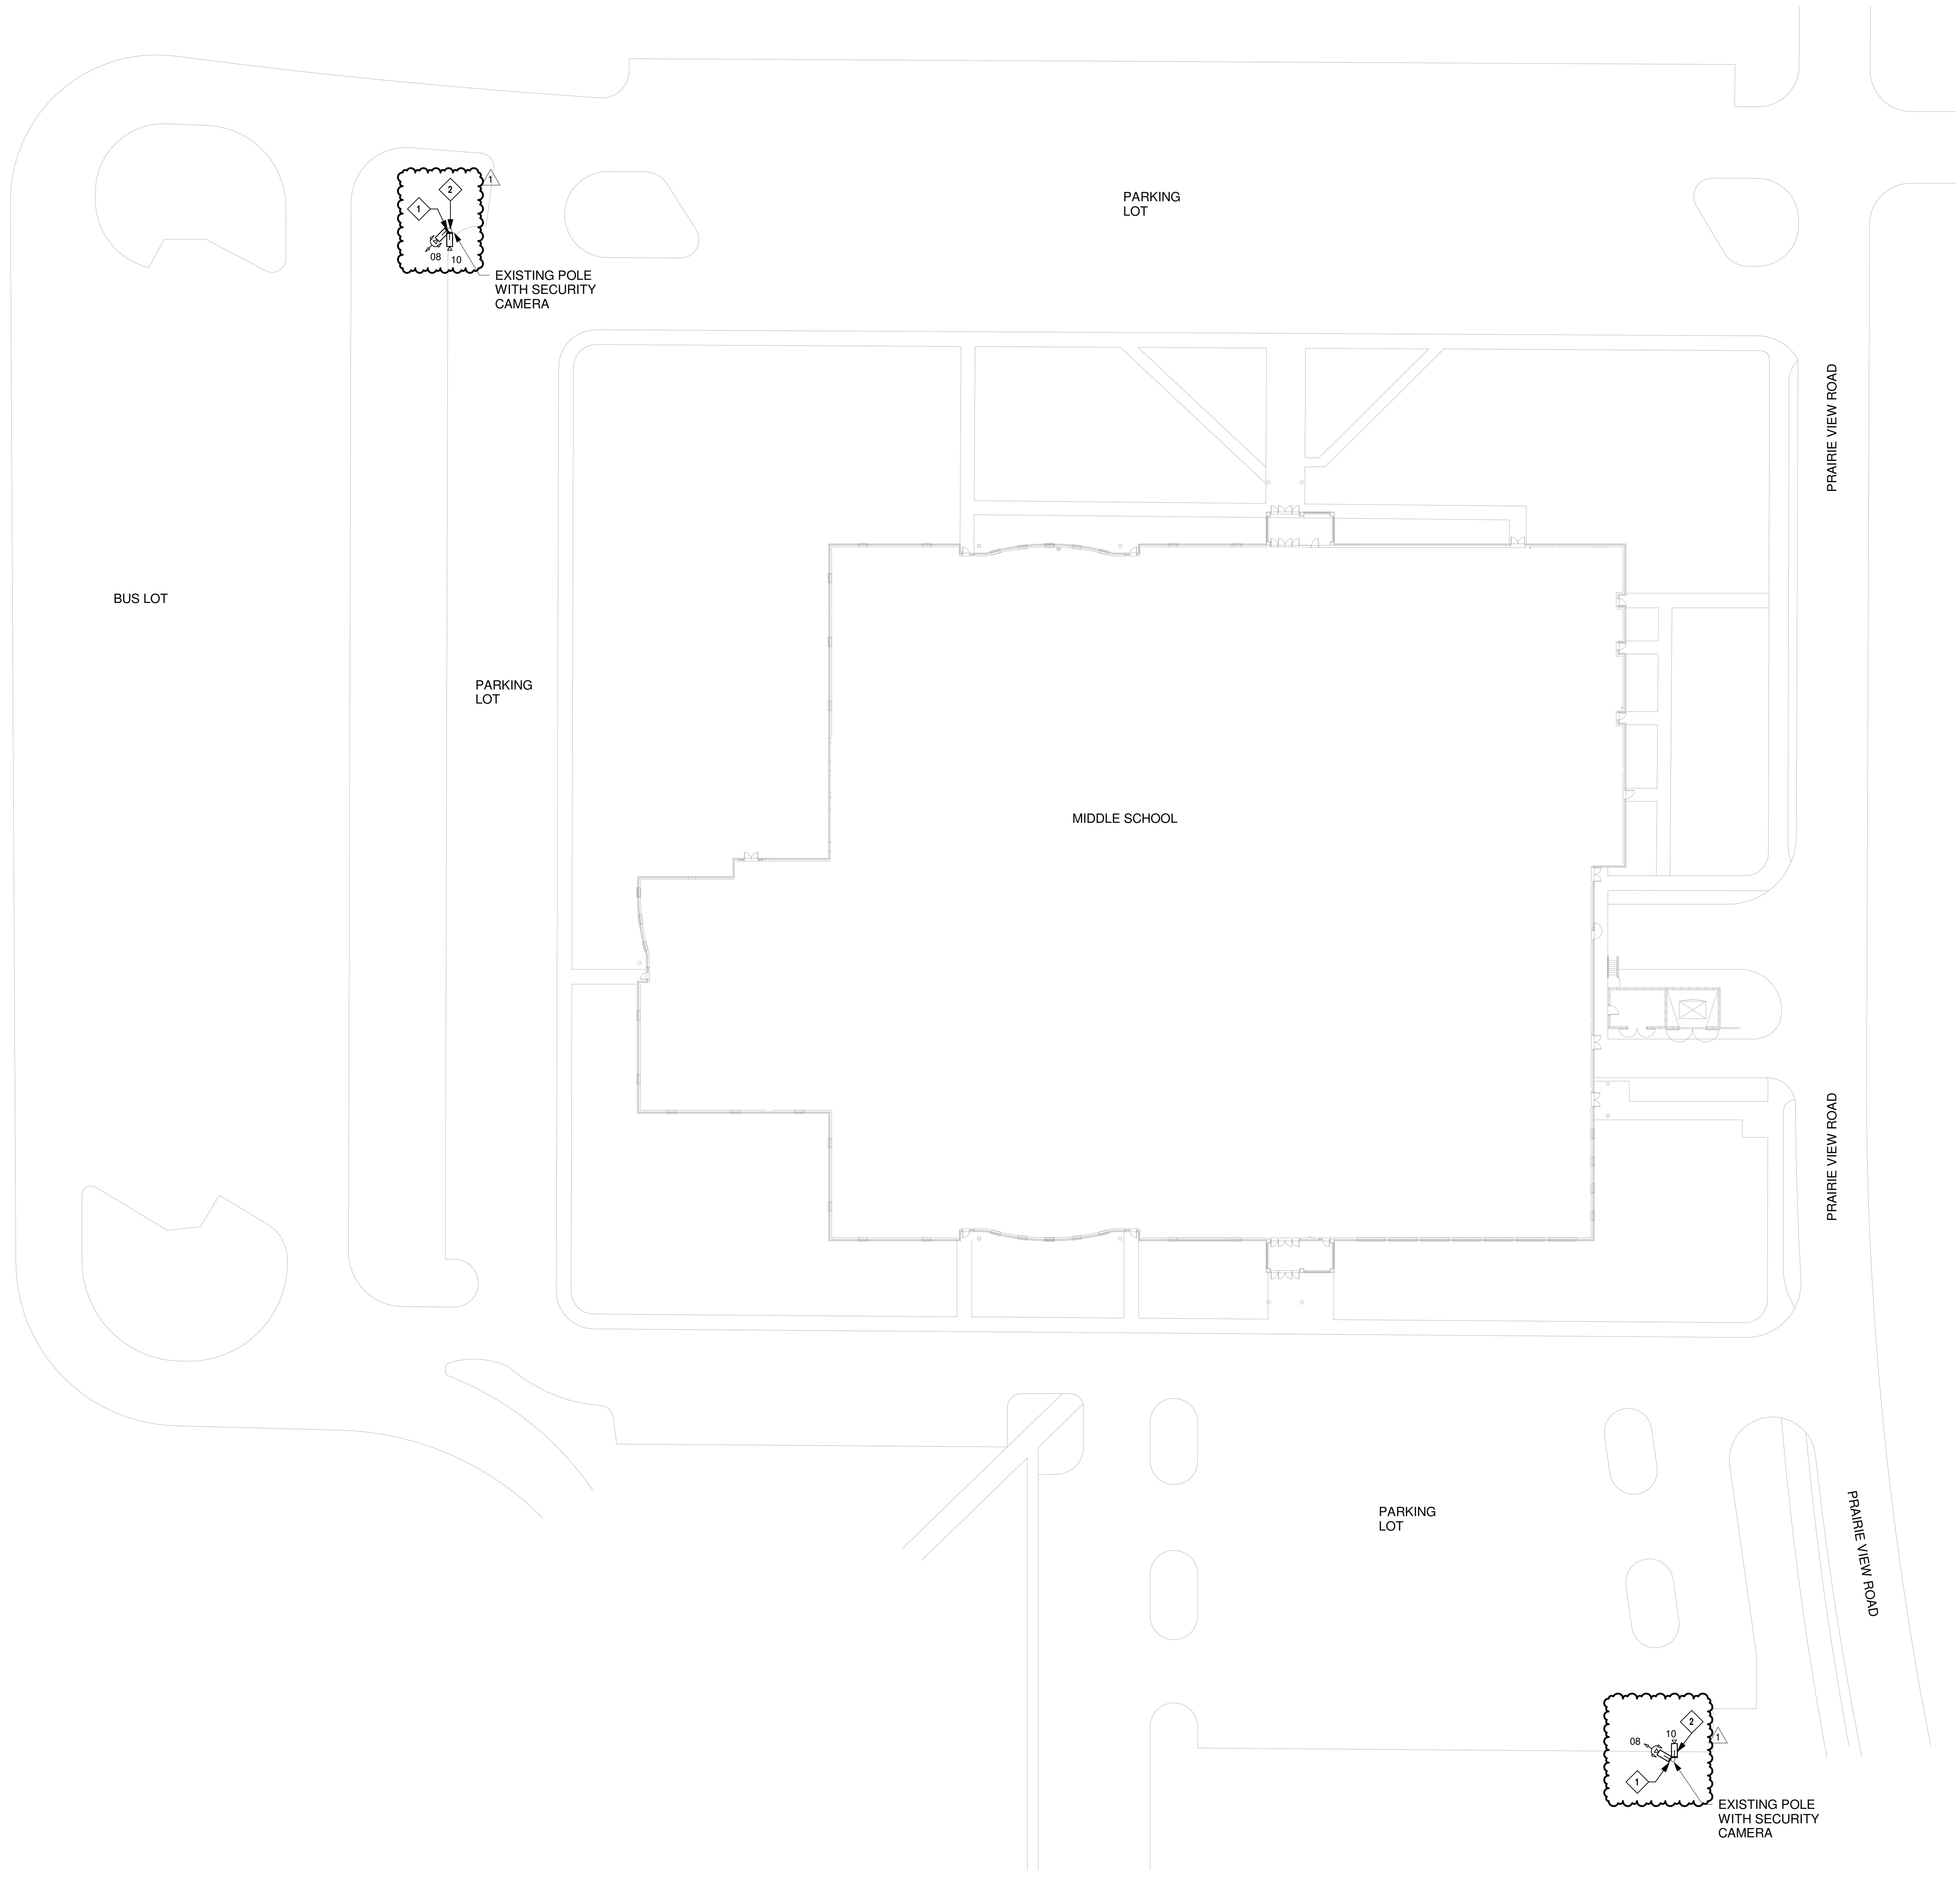

HENDERSON ENGINEERS
 8345 LENEKA DRIVE, SUITE 300
 LENEKA, KS 66214
 TEL (913) 742-5001 FAX (913) 742-5001
 WWW.HENDERSONENGINEERS.COM
 1950004765
 MO. CORPORATE NO. E-566D
 EXPIRES 12/31/2020

REVISIONS	DATE
1 Addendum #1	01/30/20

PLATTE COUNTY SCHOOL DISTRICT R-III
 PLATTE COUNTY MIDDLE SCHOOL SECURITY UPGRADES
 900 PIRATE DR, PLATTE CITY, MO 64154

REVISION	DATE
1 Addendum #1	01/30/20

HEI JOB NO: 1950004765
 DATE: 01/02/2020
 DESIGNED BY: Designer

MIDDLE SCHOOL SECURITY SITE PLAN

SHEET NO.
TY107