


NOTE:  
NO ELECTRICAL WORK REQUIRED AT FIRST  
FLOOR, SHOWN FOR REFERENCE ONLY.

**3** FIRST FLOOR PLAN - SANITARY NEW - BUILDING J  
SCALE: 1/4" = 1'-0"

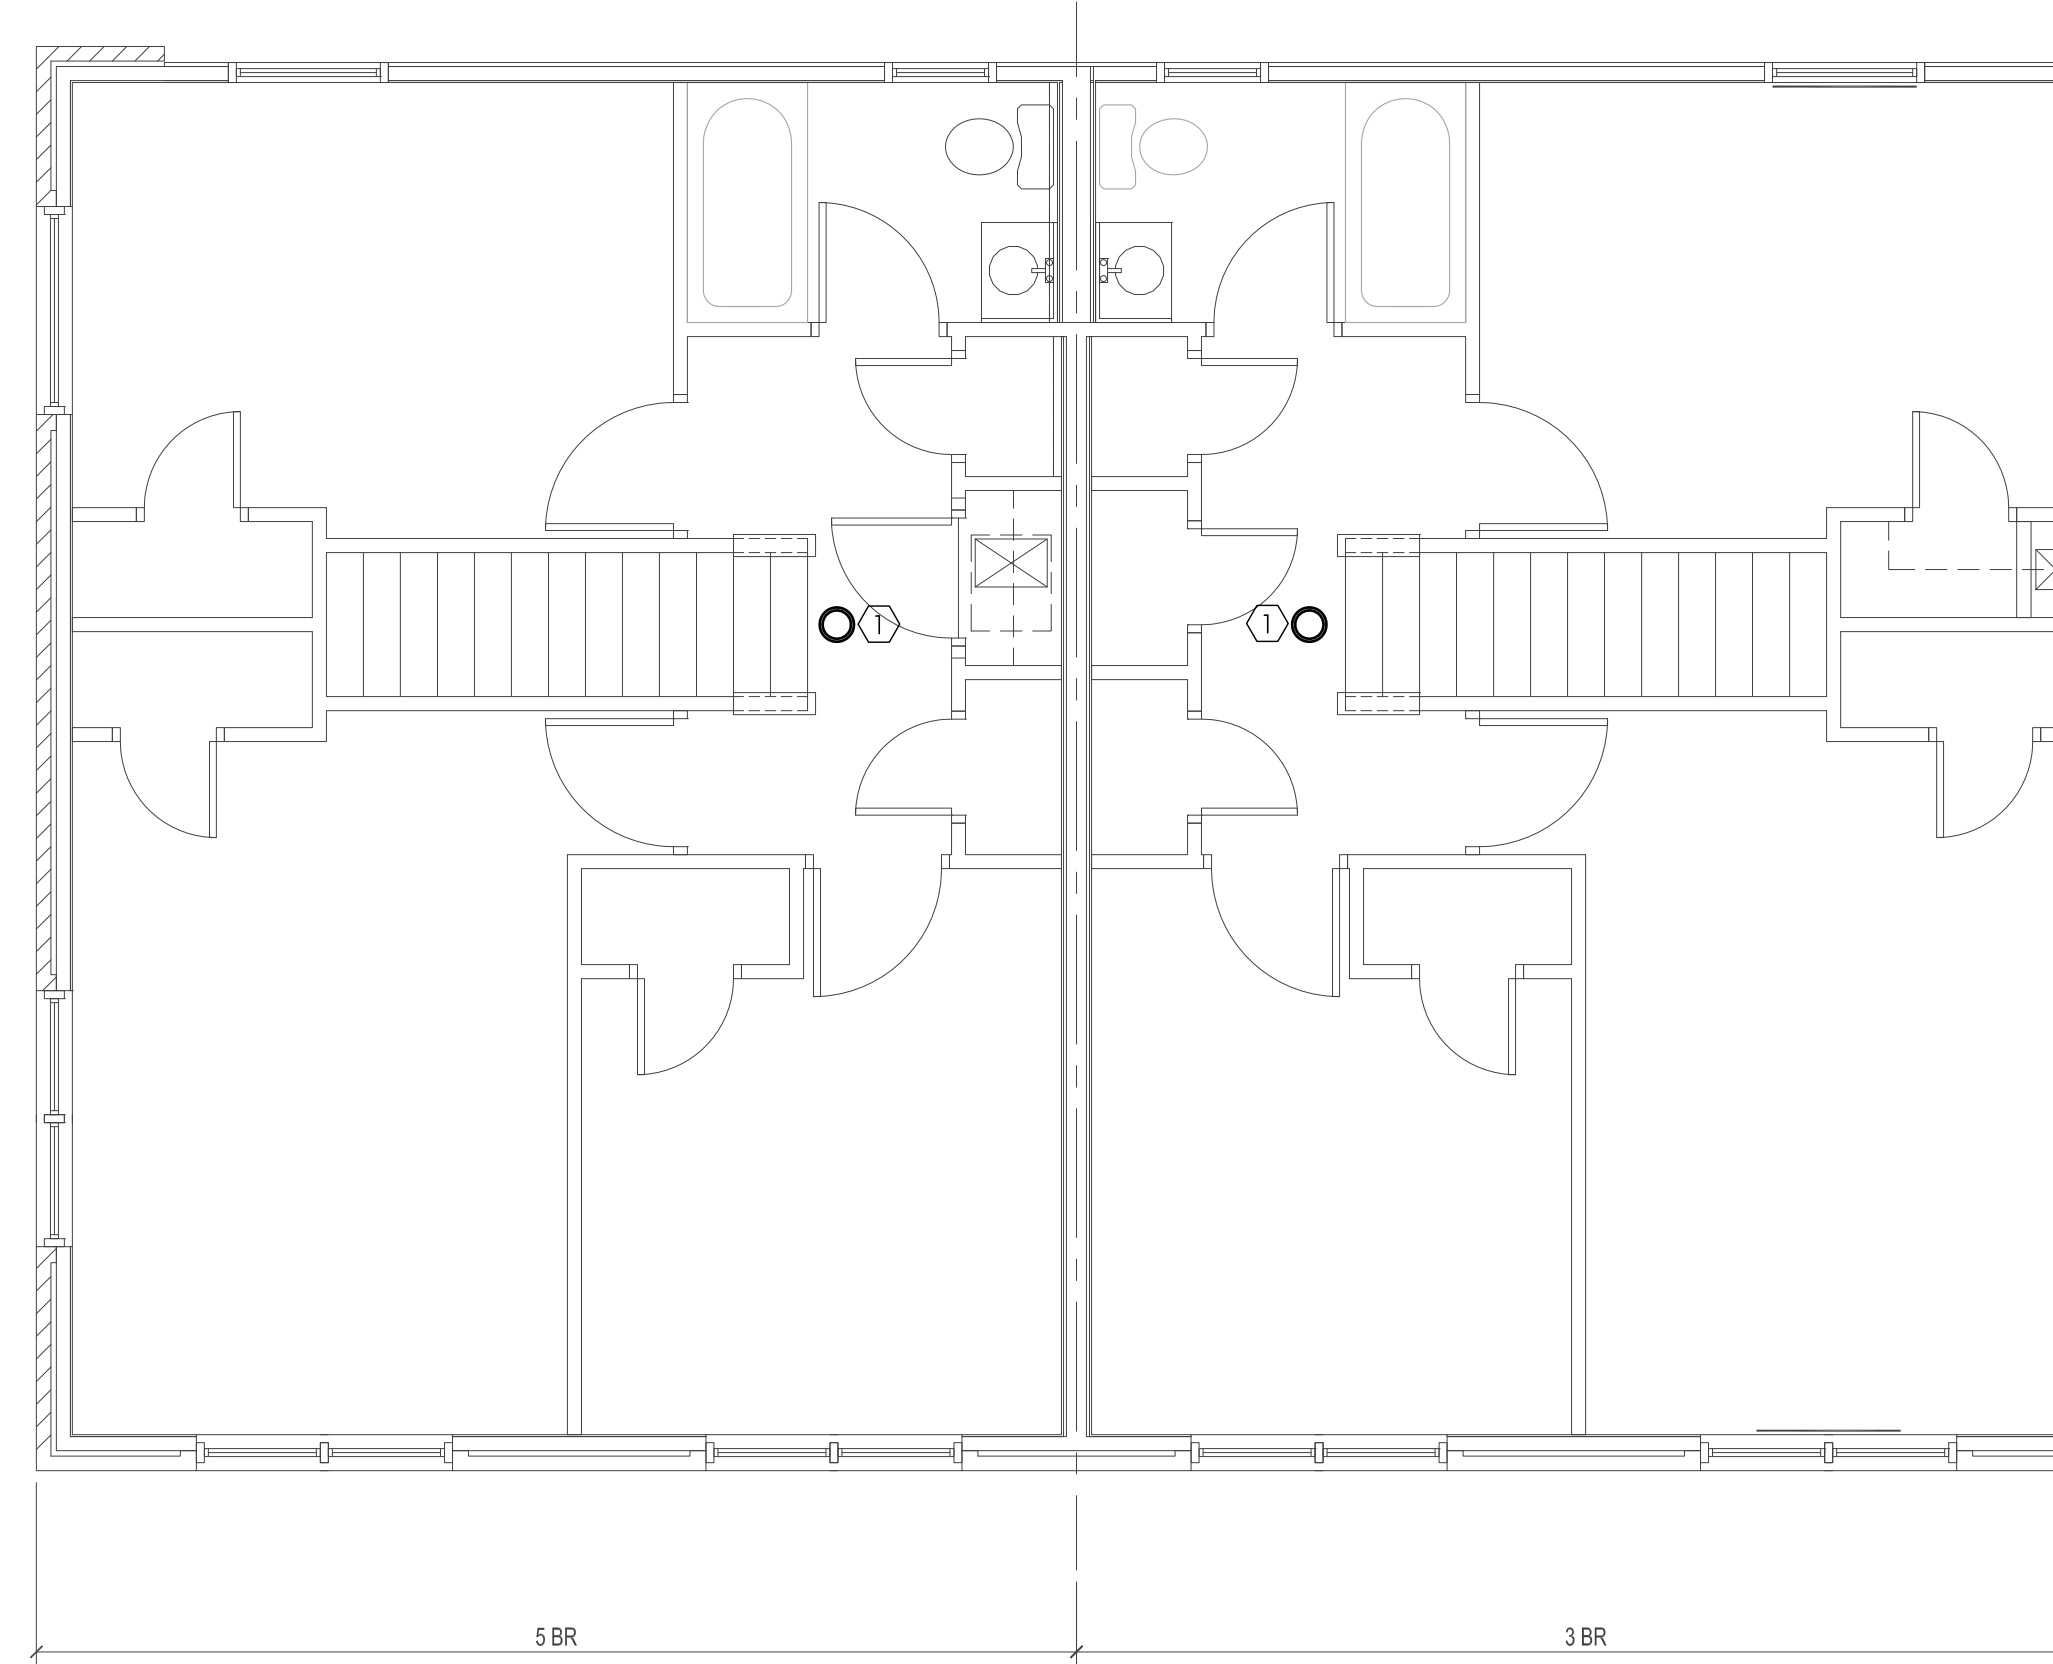

**4** SECOND FLOOR PLAN - SANITARY NEW - BUILDING J  
SCALE: 1/4" = 1'-0"

**GENERAL NOTES**


1. THIS DRAWING IS GENERALLY DIAGRAMMATIC IN NATURE AND EXCEPT WHERE SPECIFICALLY DIMENSIONED OR DETAILED, INDICATES THE GENERAL ARRANGEMENT OF THE WORK. THE CONTRACTOR SHALL INSTALL HIS WORK TO CONFORM AS NEARLY AS POSSIBLE TO THE LOCATIONS AND ARRANGEMENTS SHOWN, WITH ONLY SUCH MINOR ADJUSTMENTS AS NECESSARY. CONTRACTOR SHALL COORDINATE THE WORK WITH ALL OTHER TRADES TO AVOID INTERFERENCES.
2. ALL ELECTRICAL COMPONENTS EXTENDED THROUGH A FIRE RATED STRUCTURE SHALL BE PROTECTED OR SEALED AS REQUIRED TO MAINTAIN RATING OF THE STRUCTURE.
3. MAINTAIN CODE REQUIRED CLEARANCES AT ALL ELECTRICAL PANELS AND DISCONNECT SWITCHES. THERE SHALL BE NO EQUIPMENT, PIPING OR DUCT WORK INSTALLED IN OR ABOVE THE WORKING CLEARANCES.

**KEY NOTES**

- ① EXISTING CEILING MOUNTED LIGHT FIXTURE TO BE REPLACED WITH NEW LIGHT FIXTURE IN THE SAME LOCATION. MAINTAIN EXISTING CIRCUITRY AND CONTROLS.


**LEGEND**

- NEW TWO LIGHT CEILING FLUSH MOUNTED LIGHTING FIXTURE WITH TWO (2) A19 LED LAMPS AND WHITE SHATTER RESISTANT ACRYLIC DIFFUSER. USE SEA GULL LIGHTING MODEL NUMBER 7926EN3-15 OR EQUAL.

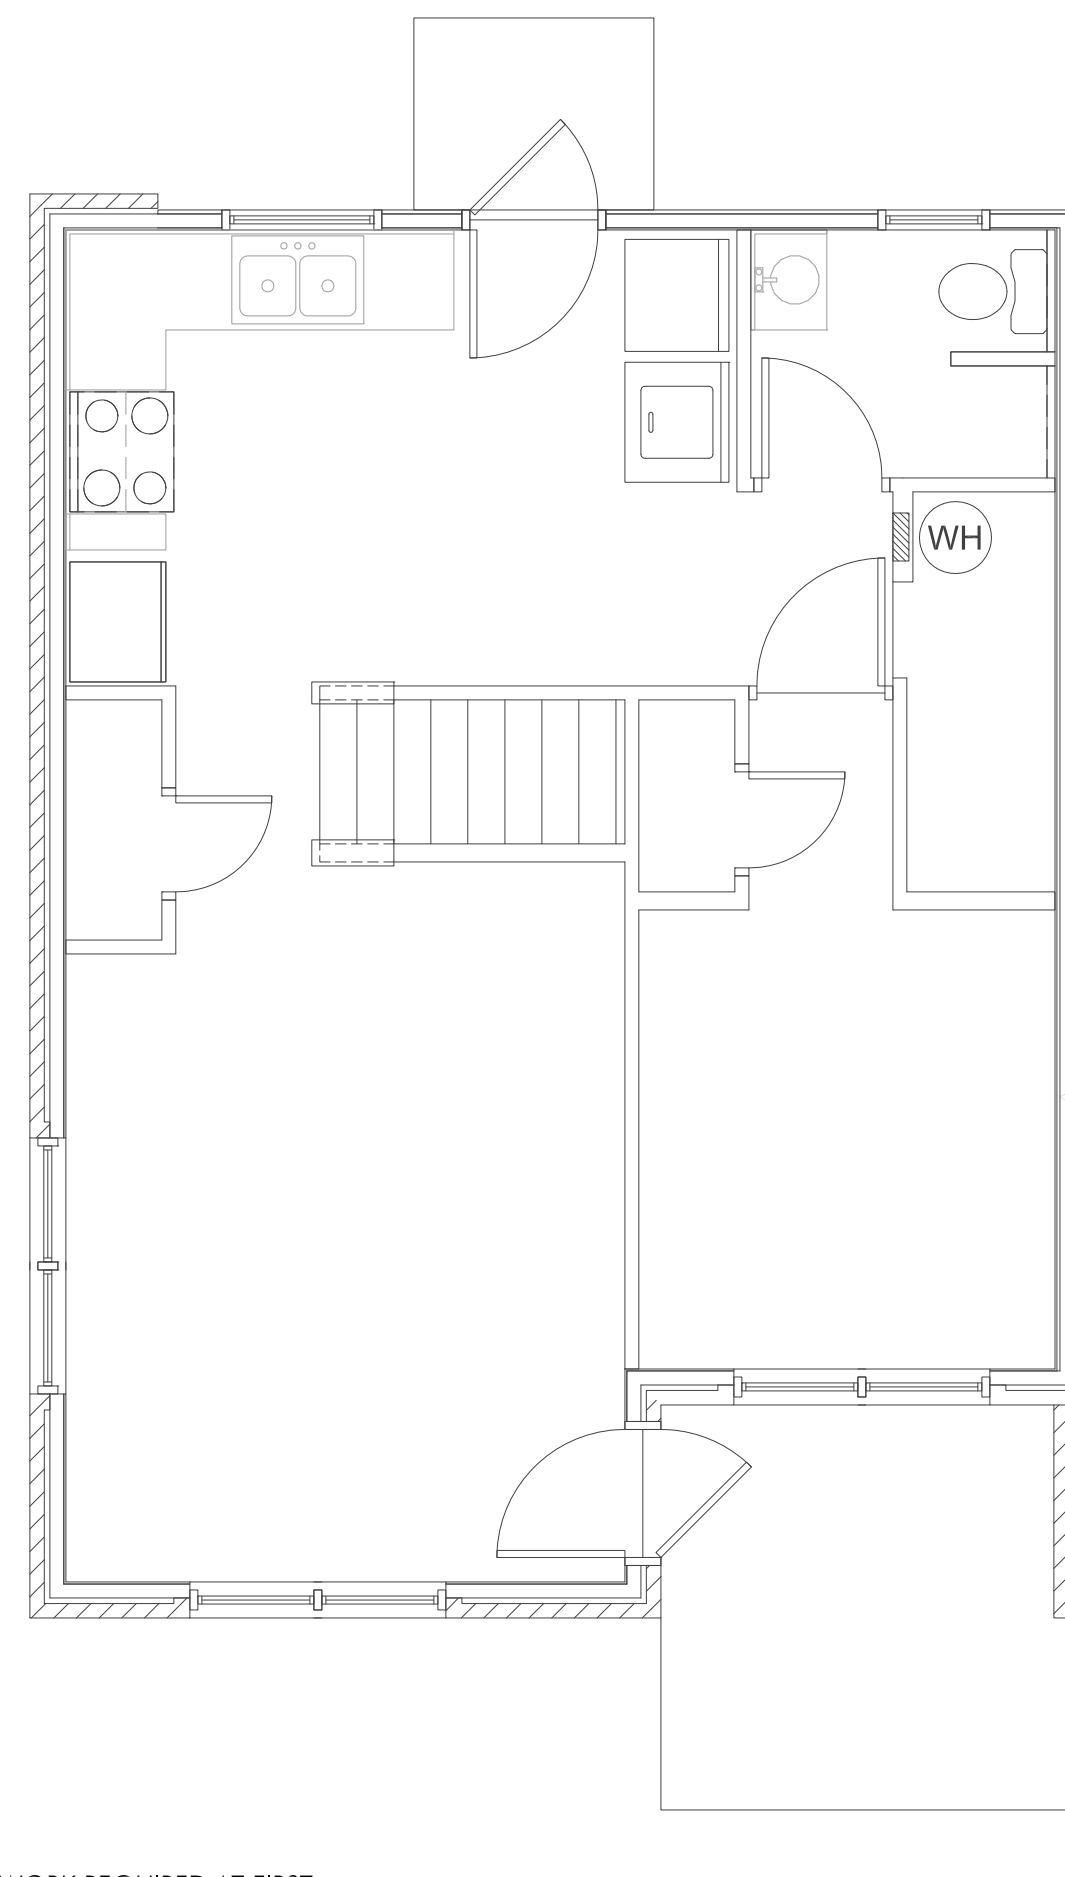


NOTE:  
NO ELECTRICAL WORK REQUIRED AT FIRST  
FLOOR, SHOWN FOR REFERENCE ONLY.

**1** FIRST FLOOR PLAN - SANITARY NEW - BUILDING I  
SCALE: 1/4" = 1'-0"

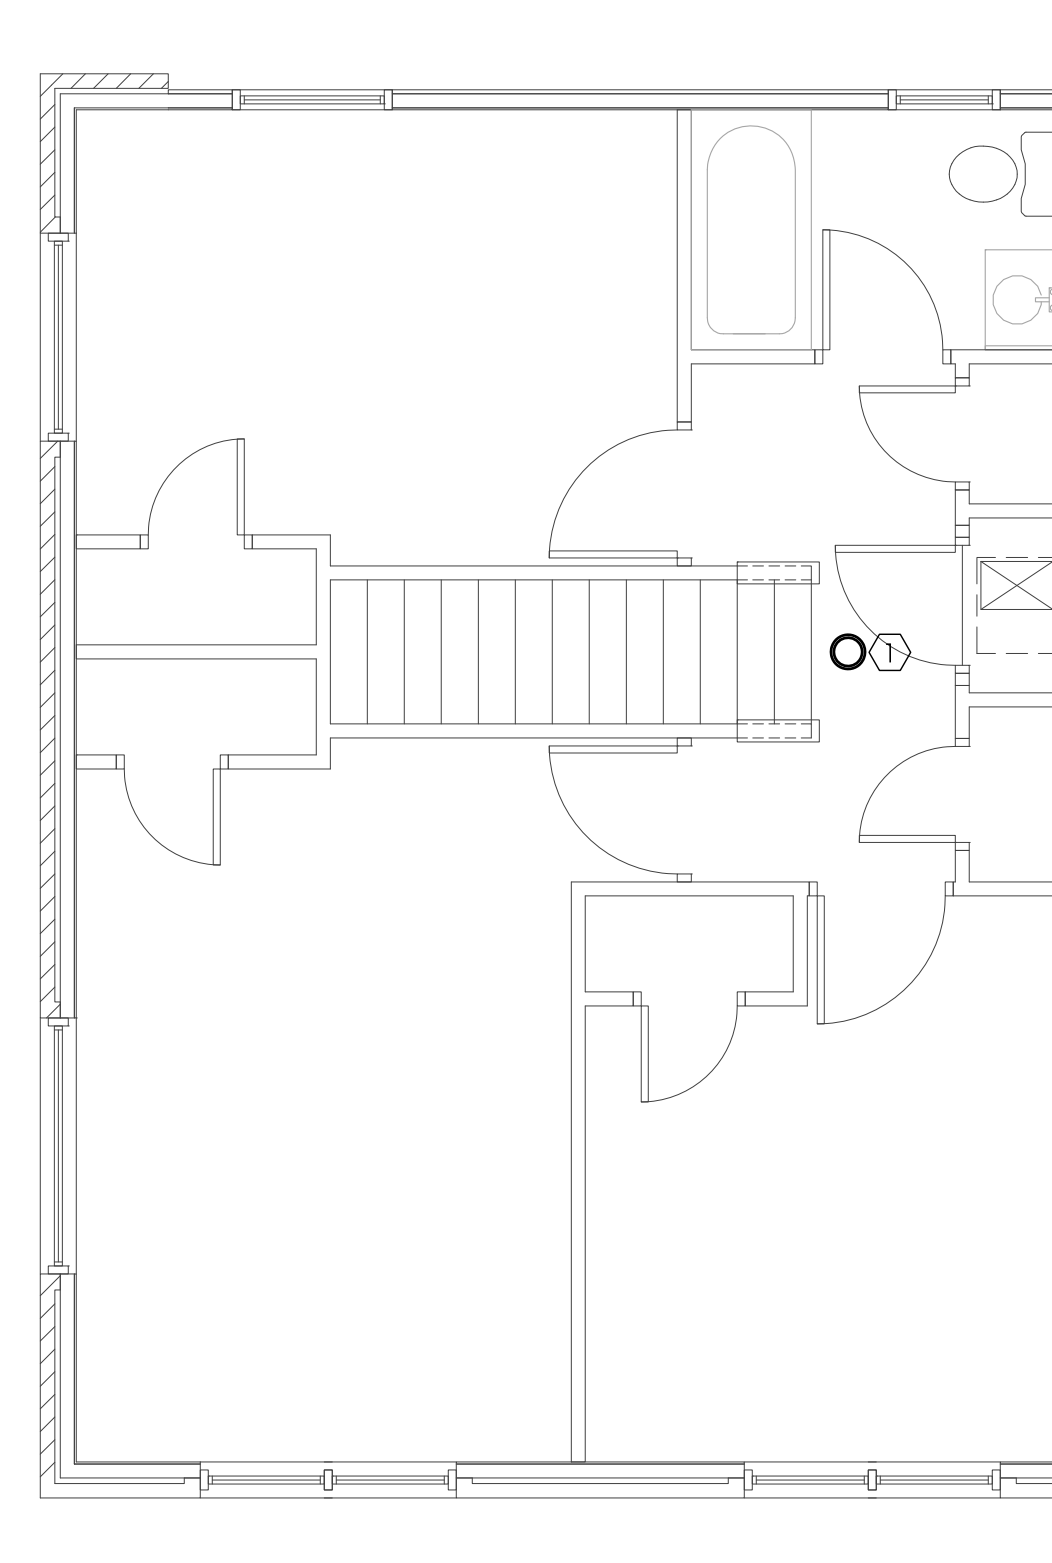

**2** SECOND FLOOR PLAN - SANITARY NEW - BUILDING I  
SCALE: 1/4" = 1'-0"

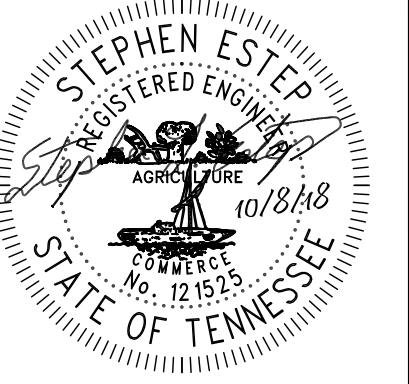

DATE	ISSUE FOR

This drawing is the property of DESIGN INNOVATIONS ARCHITECTS, INC. and is not to be reproduced or copied in whole or in part without authorization from DESIGN INNOVATIONS ARCHITECTS, INC. It is to be used for the project and site specifically identified herein and is not to be used for any other project. It is to be returned upon request. Do not scale drawings, within dimensions take precedence. All drawings and designs shown on these drawings are copyright © of DESIGN INNOVATIONS ARCHITECTS, INC.

Sheet Title  
**BUILDING I AND J  
UNIT PLANS -  
LIGHTING**

