
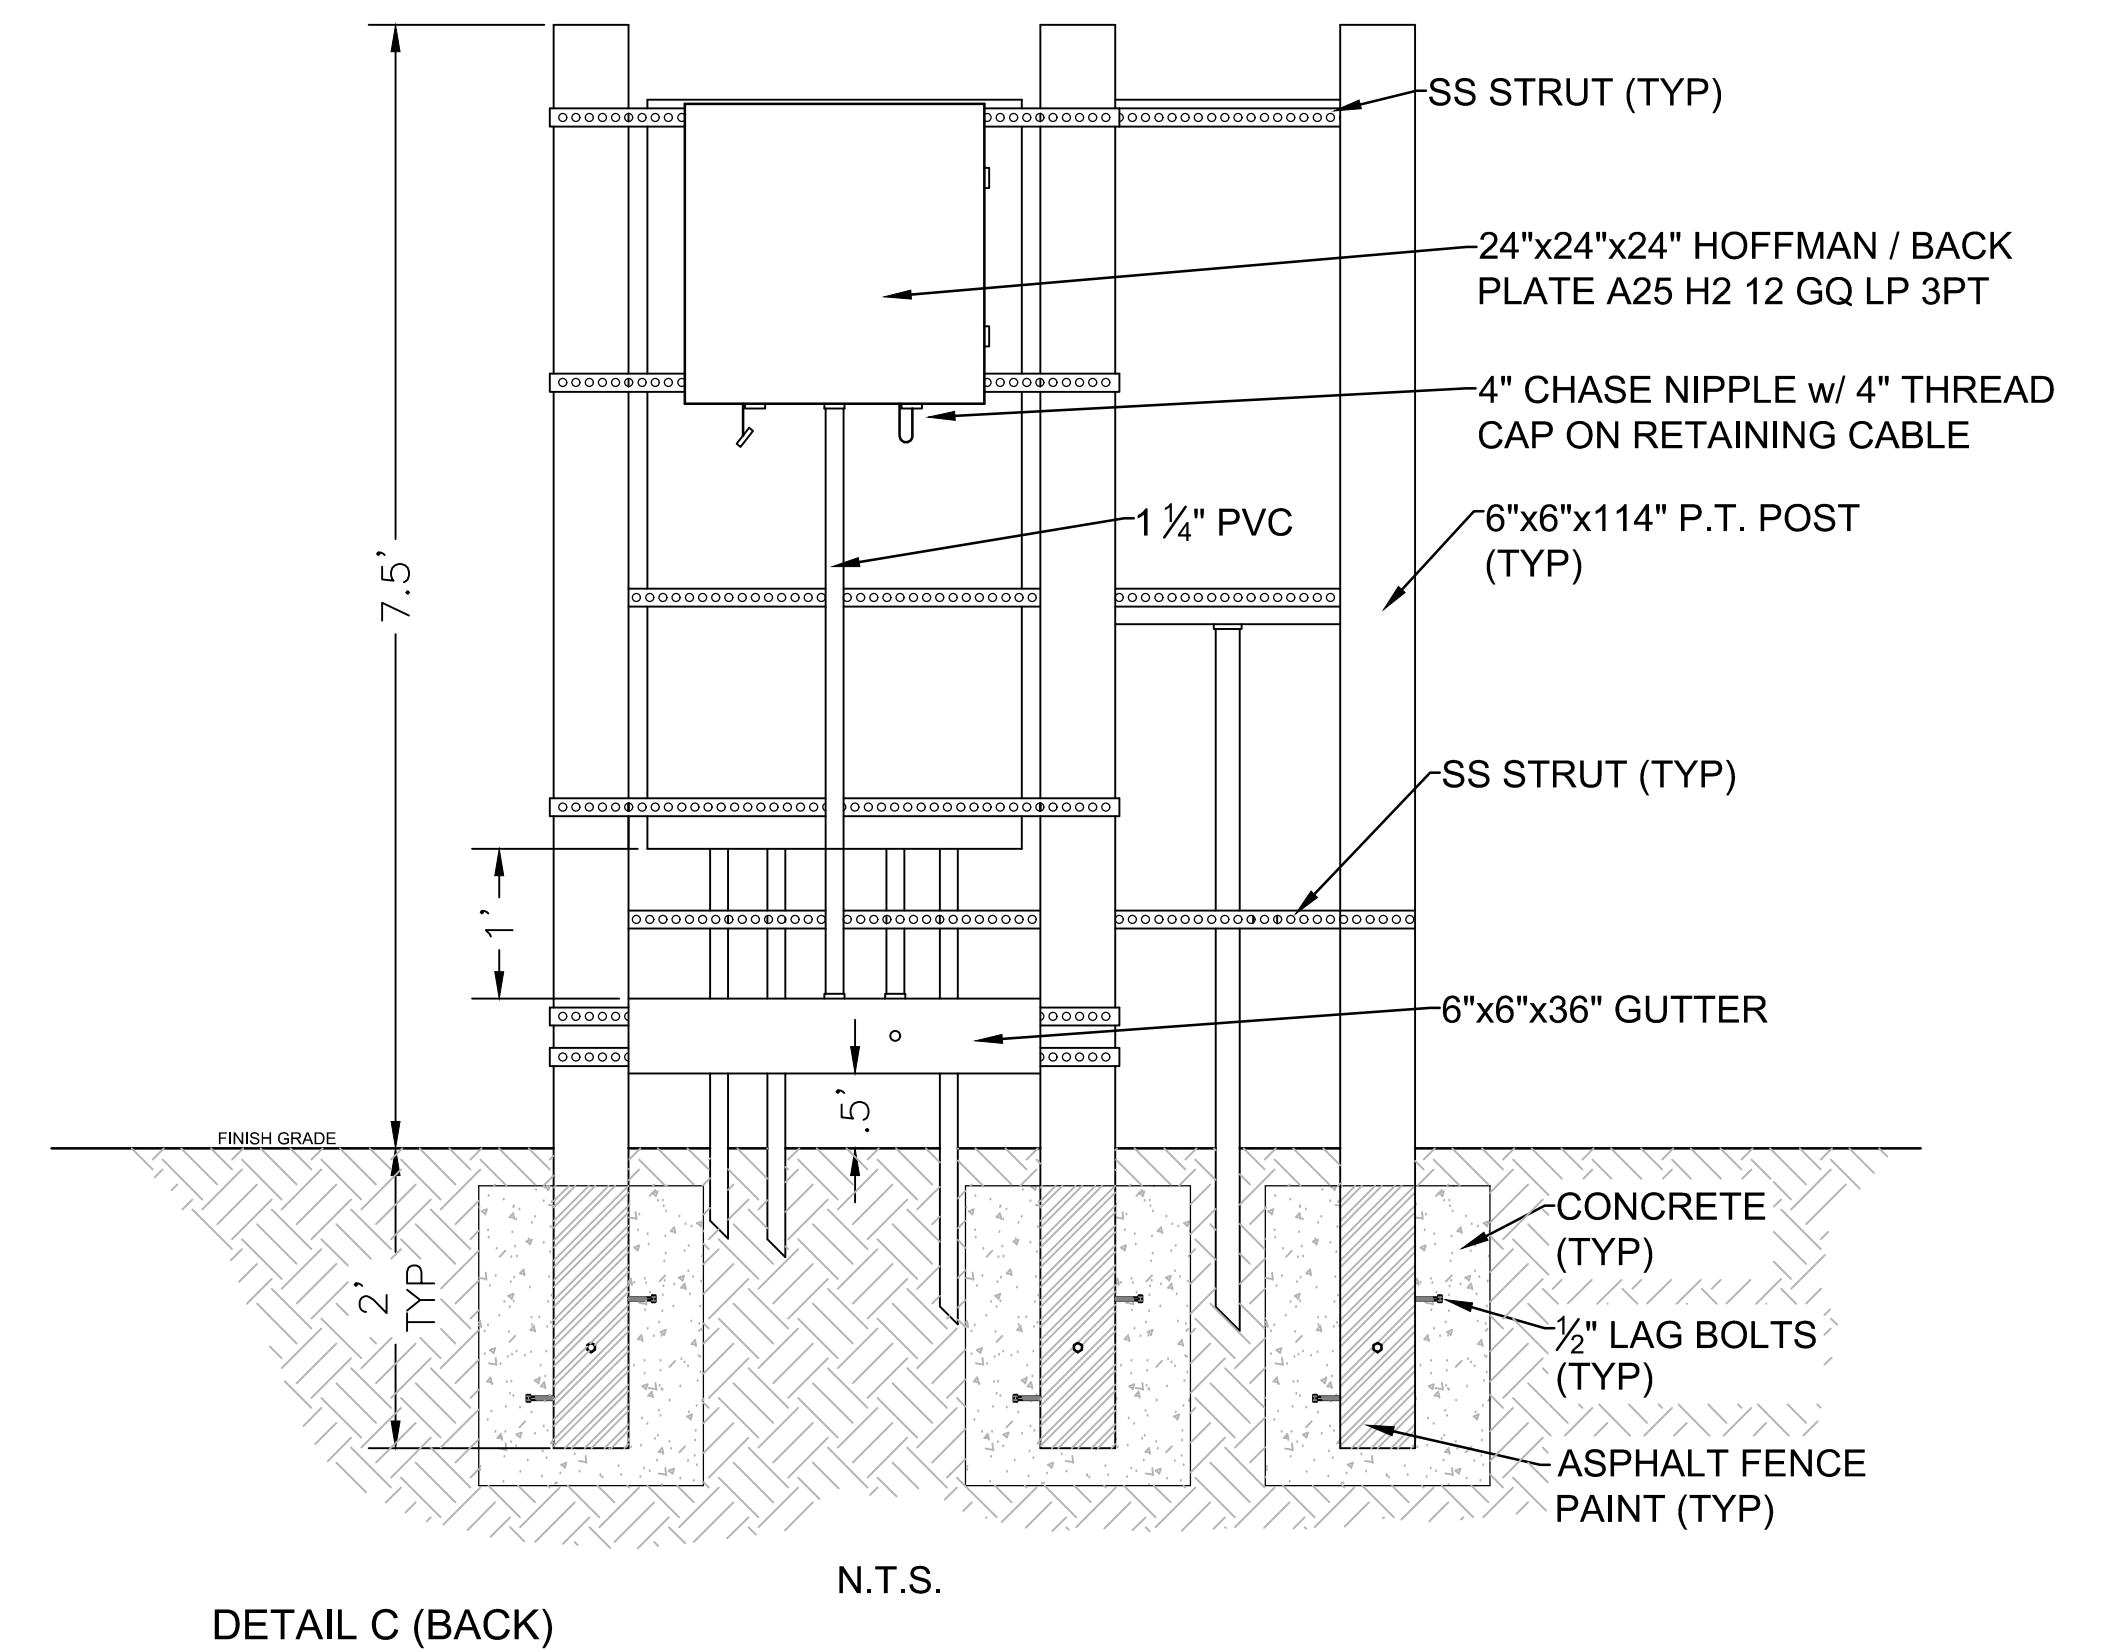
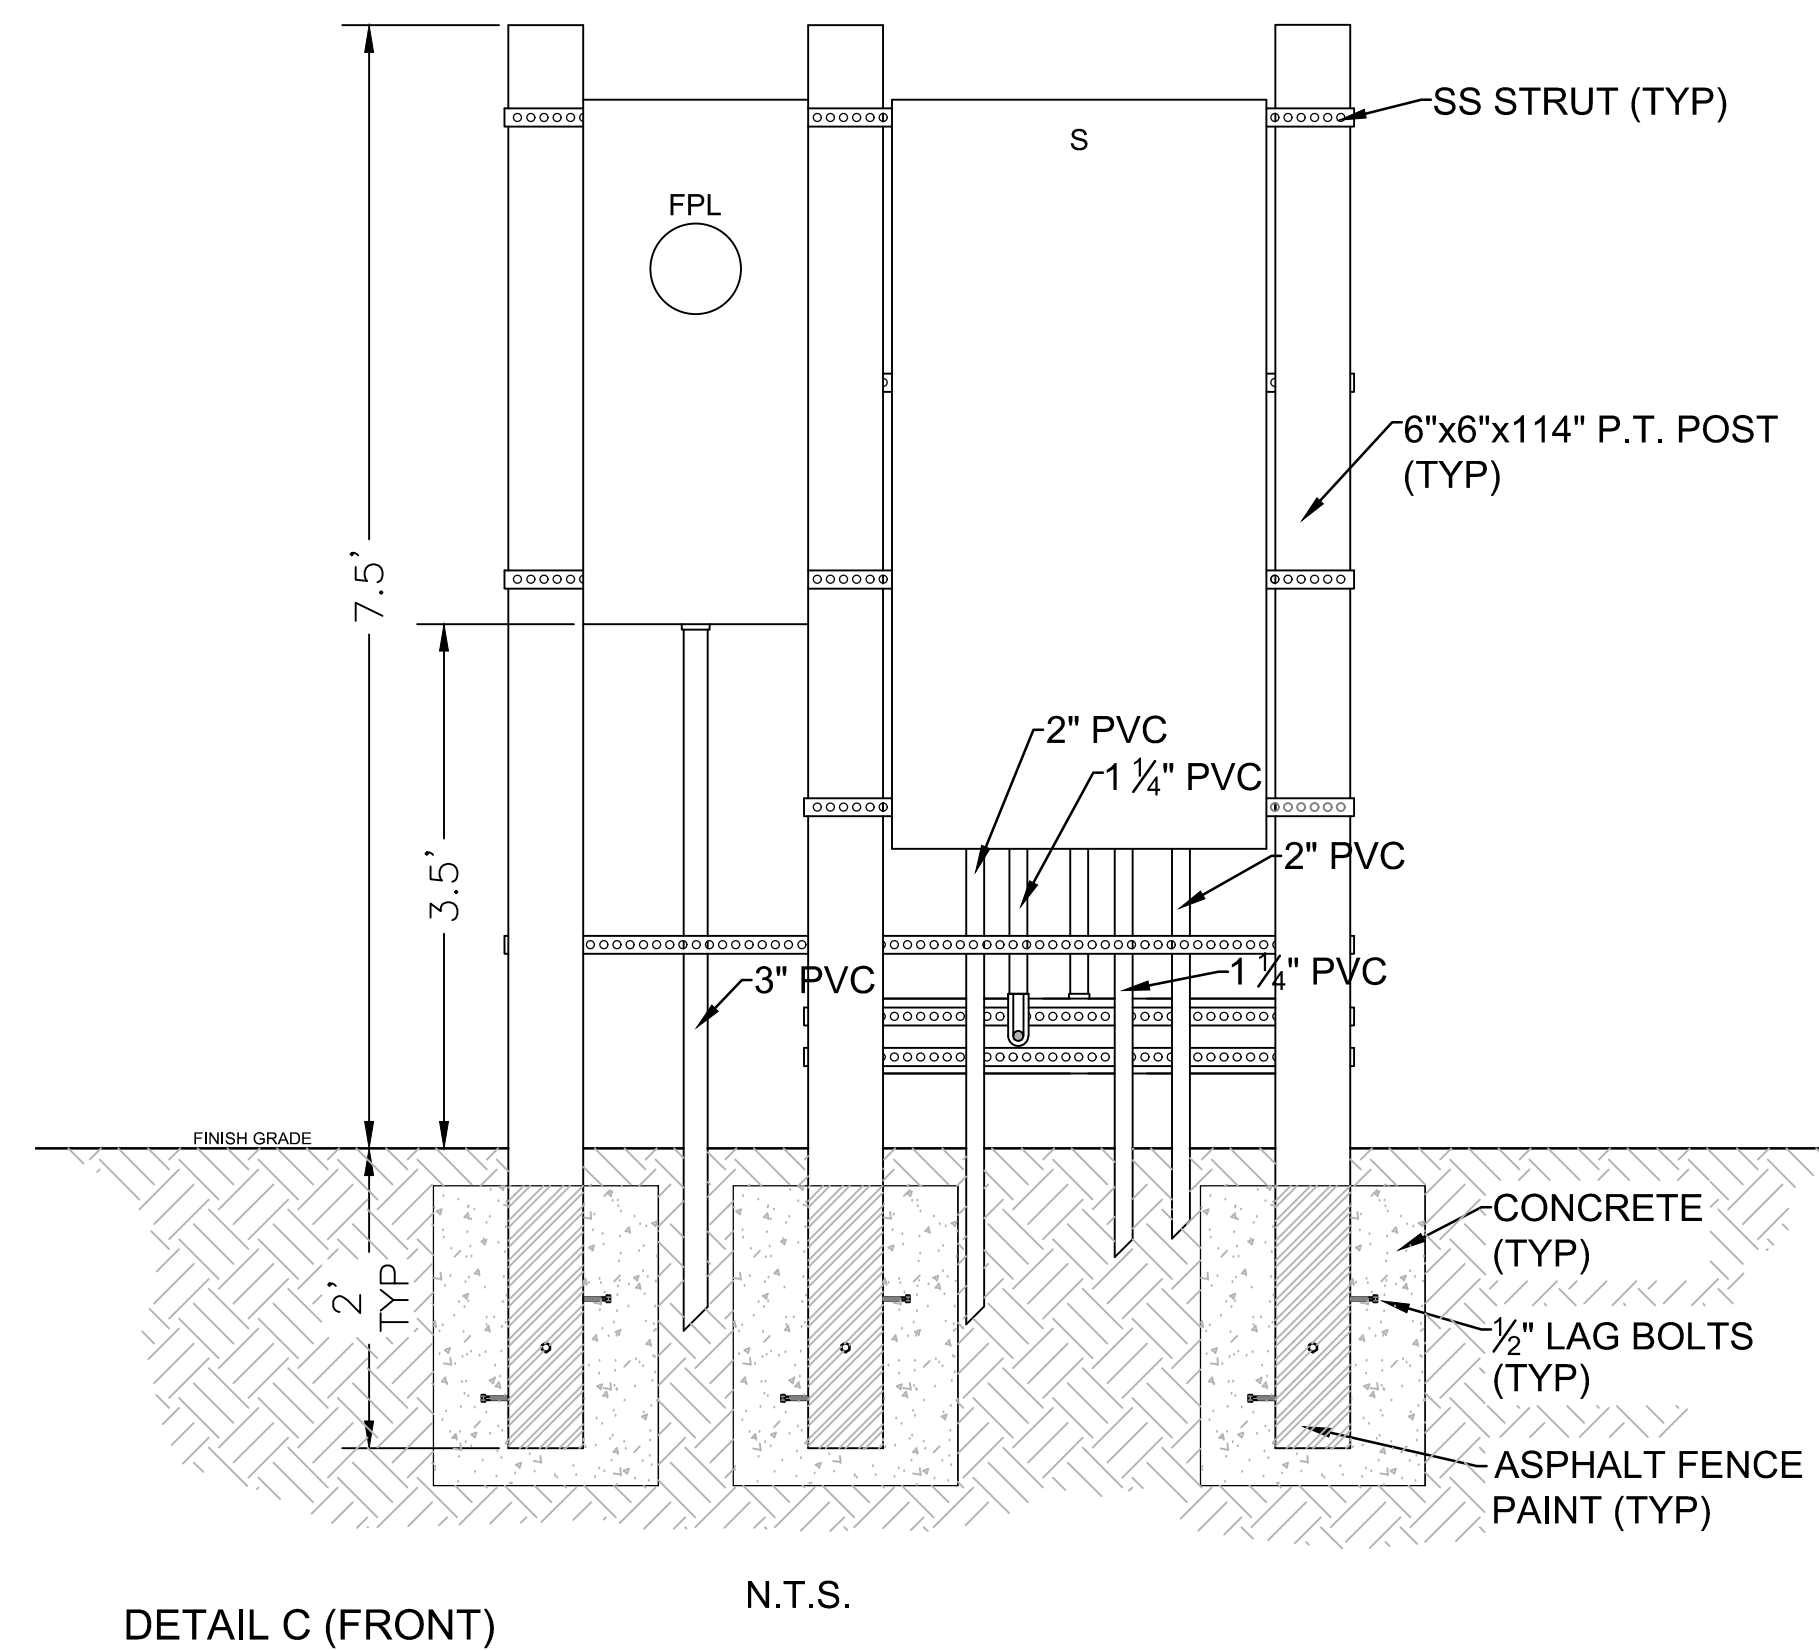


LEGEND

C 300 amp 1Ø 30 cir SQU D / 24"x24"x12" HOFFMAN 1-50TL 1-30TL 2-20a G.F.I.'s. DETAIL C (TYP)

SQUARE D EQUIPMENT PROVIDED BY CONTRACTOR

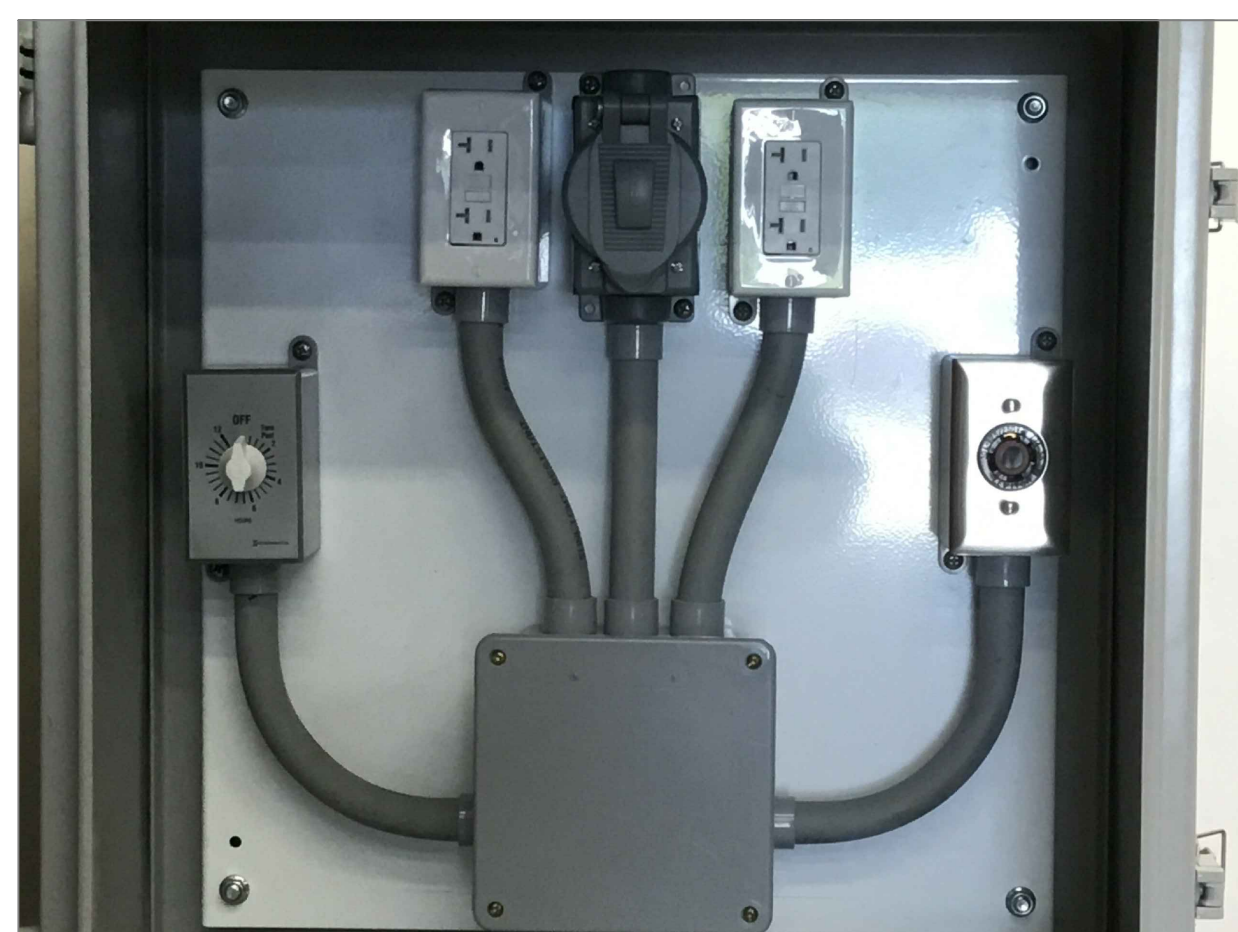

		Drawing Date: 12/13/2019	Scale:
		Survey Date: N/A	Rotation: 335°
		Survey By: N/A	File Name: MAGNOLIA FARMER
		Drawn By: P TRIMARCHI	Project No:
		Checked By: B JOHNSON	Contract No:
No:	Revision:	Date:	Image Name:
			Xref Name: N/A

THE CITY OF DAYTONA BEACH
PUBLIC WORKS DEPARTMENT
TECHNICAL SERVICES DIVISION
 950 BELLEVUE AVENUE • DAYTONA BEACH • FLORIDA • 32114
 PHONE: (386) 671-8610 FAX: (386) 671-8620



NORTH & SOUTH SIDE MAGNOLIA AVE.
PALMETTO AVE. TO BEACH ST.
FARMER'S MARKET
ELECTRICAL PLAN

PROJECT MANAGER	1
	of
	1