



**City of Avondale
Government
Center**


Owner:
City of Avondale
525 N. Central Ave.
Avondale, AZ 85323

SmithGroup
SmithGroup Incorporated
2800 North Central Avenue
Suite 1200
Phoenix, Arizona 85004
T: 602.265.2200
F: 602.265.2244
www.smithgroup.com

Issued for _____
Rev. Date _____

Police/Courts Permit, SH
Police/Courts, SSE Review
Design Development
Standard/LIC Permit, SH
SH
14MAR03
24FEB03
29NOV02
16OCT02

Scales and Signatures

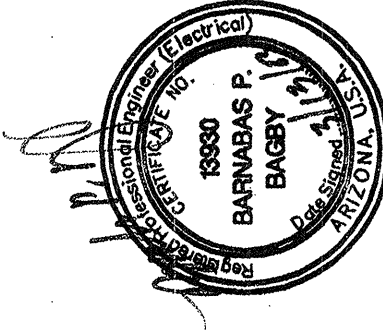

Key Plan

Drawing Title
**POLICE STATIONS
& COURTS
SITE PLAN**

Scale 1"=20'-0"
19,457,000

Project Number
E1.2
Drawing Number

LEGEND


- TELEPHONE/911 DUCT BANK
- 12/70V PRIMARY DUCT BANK
- LOCAL NETWORK/TELEPHONE DUCT BANK
- 400V MH, 25'-0" POLE, NM ENTABATURE SERIES (14E12-60HPS277-WH-P)
- 400V MH, 25'-0" DOUBLE HEADED POLE, NM ENTABATURE SERIES (24E12-60HPS277-WH-P)
- 70V MH ROLLAR, NM W81 SERIES (W81-70HPS277-WH-P)
- 70V HPS, 12'-0" POLE, AAL
- LUMBS-SR-145-F10-70
- HPS-SLJ7-FR4-4R10-125
- HAND HOLE
- MAN HOLE
- 8'-0" 8W TR80
- COLUMBIA 4758-285-EBB277-DMR

SHEET NOTES

A. STUB CONDUITS UP 6" A.F.F. AND CAP. PROVIDE PULL CHORDS IN EMPTY CONDUITS.

KEYED NOTES

1. 600A, 480V, 3#, 4W SERVICE ENTRANCE SWITCHBOARD.
2. 600A, 480V, 3#, 4W SERVICE ENTRANCE SWITCHBOARD.
3. PROVIDE (6) 1" CONDUITS THROUGH FOUNDATION WALL. STUB UP IN WALL ABOVE CEILING.
4. (1) 4" CONDUIT.
5. (3) 4" CONDUITS.
6. (4) 2-1/2" CONDUITS.
7. (3) 1" & (1) 2" CONDUITS.
8. TELEPHONE SERVICE ENTRANCE ROOM.
9. ELECTRICAL SERVICE CONDUITS, PROVIDE PER SSP SPECIFICATIONS.
10. REFER TO DRAWING A1-E10 FOR CONTINUATION OF CONDUITS.
11. (1) 2" CONDUIT.
12. COORDINATE CONDUIT SUB-UP LOCATION WITH GENERATOR MANUFACTURER.
13. CIRCUIT TO POLICE STATION LIGHTING PANEL.
14. CIRCUIT TO COURTS BUILDING LIGHTING PANEL.
15. STUB UP CONDUIT AT CANOPY SUPPORT. COORDINATE LOCATION WITH CANOPY MANUFACTURER.

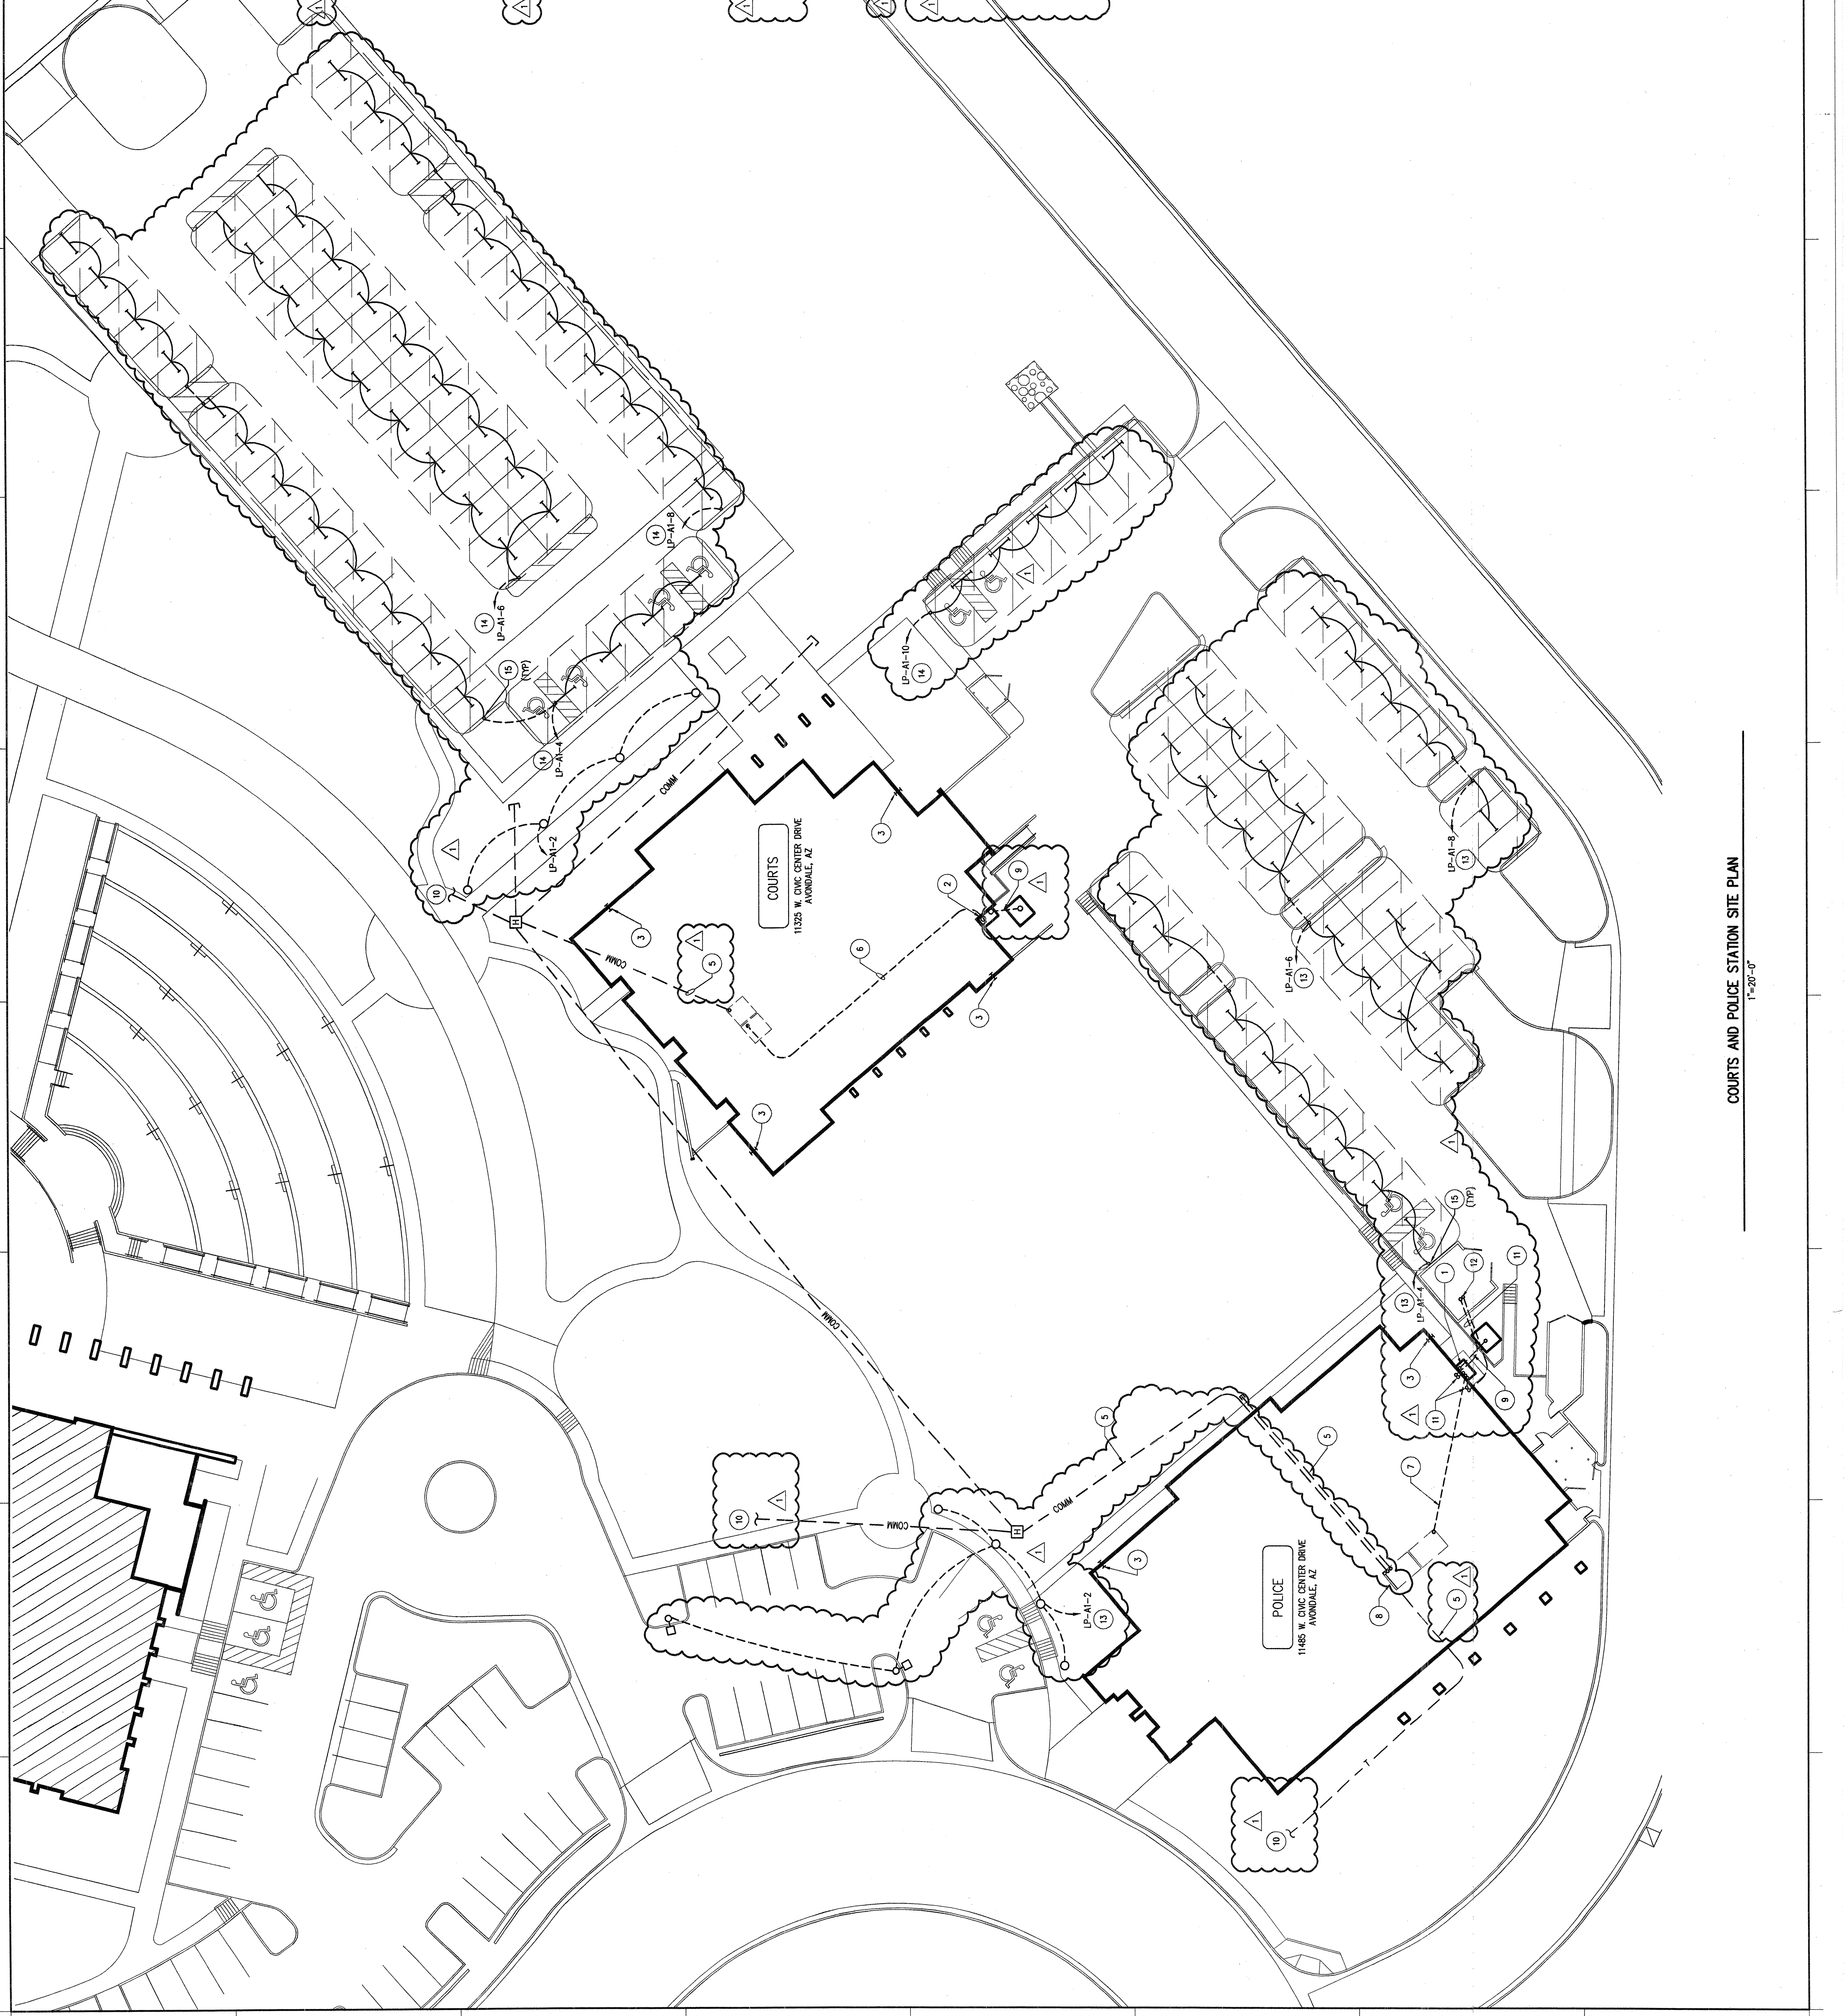

COURTS AND POLICE STATION SITE PLAN
1"=20'-0"