
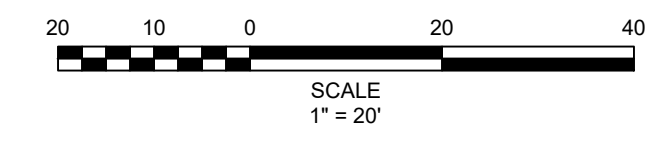


- LEGEND:**
- - - - - EXISTING SINGLE PHASE SECONDARY/SERVICE
 - - - - - EXISTING THREE PHASE SECONDARY/SERVICE
 - - - - - EXISTING THREE PHASE PRIMARY
 - ⊕ ELECTRIC METER
 - ⊙ DECORATIVE LIGHT
 - P — OH POWER
 - T — OH TELEPHONE
 - P&T — OH POWER & TELEPHONE
 - W — WATER
 - SS — SANITARY SEWER
 - SD — STORM DRAIN
 - G — GAS
 - UGT — UG TELEPHONE
 - CB CATCH BASIN
 - MH MANHOLE
 - FH FIRE HYDRANT
 - PP POWER POLE
 - ##### DOCKS

NOTES:

1. THIS DRAWING BASED ON DOWNTOWN GEORGETOWN REVITALIZATION PROJECT, PLAN - FRONT STREET ELECTRICAL, DRAWINGS 1-14.

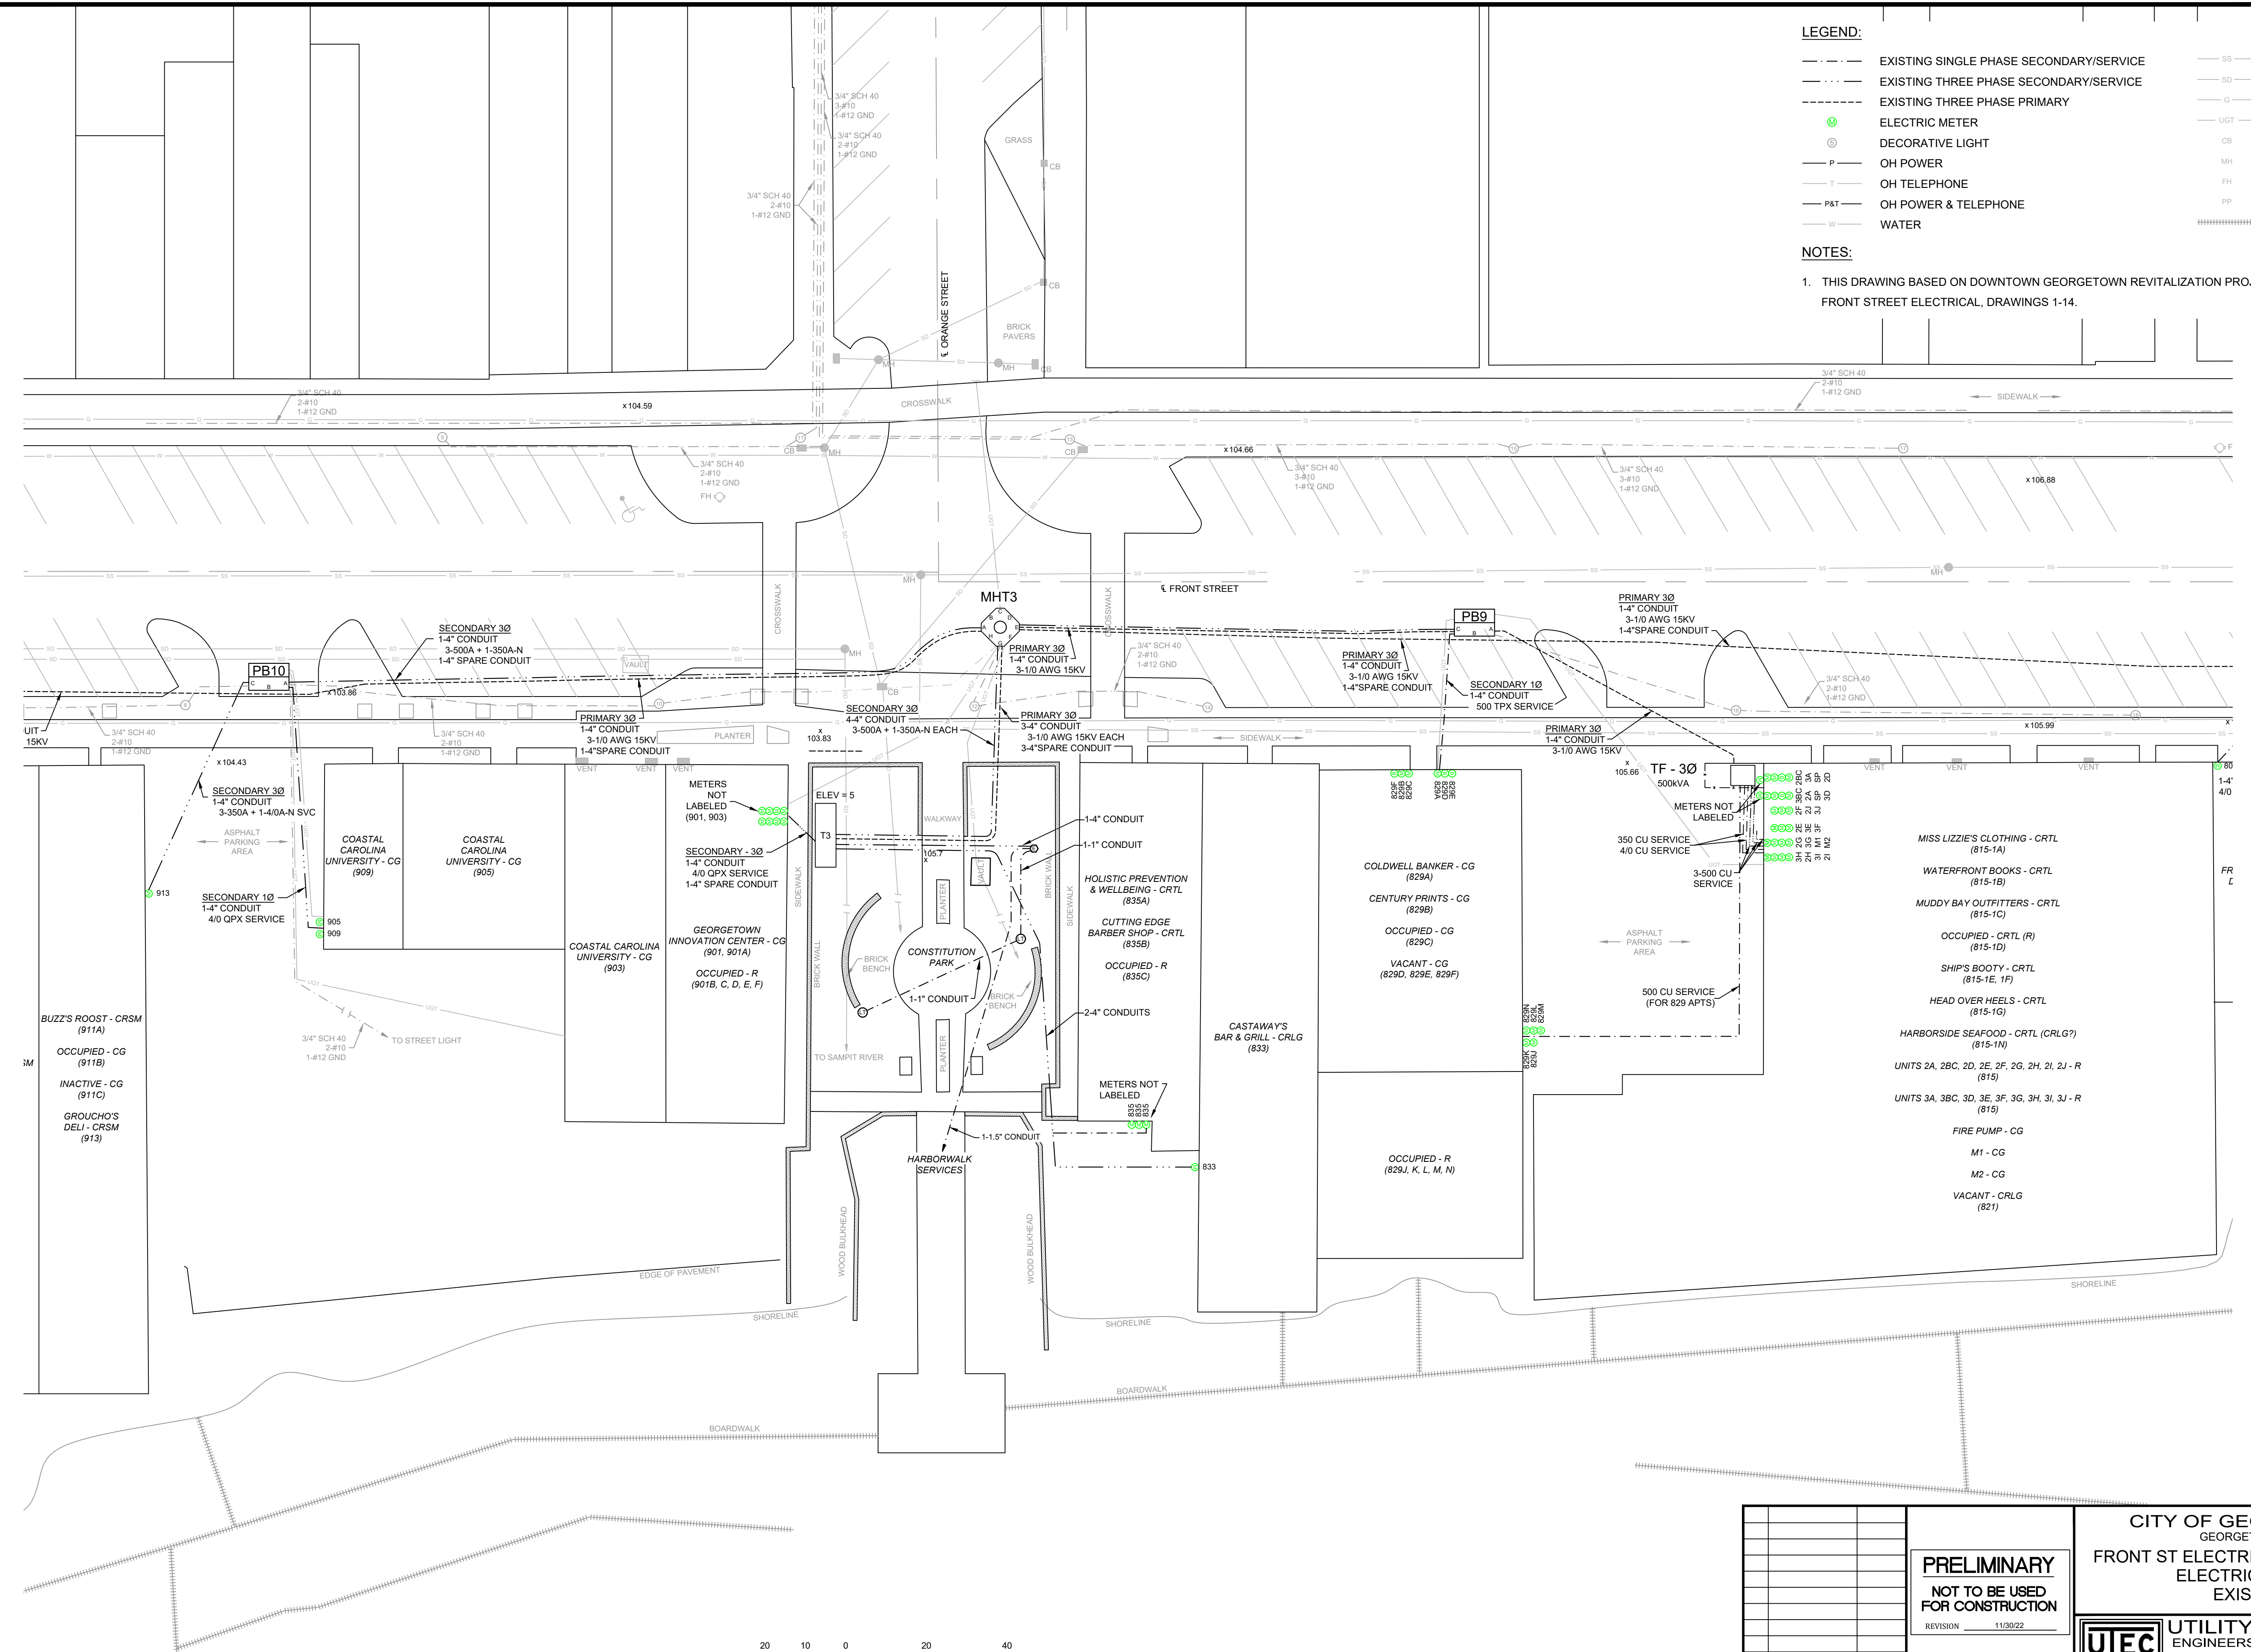

PRELIMINARY			CITY OF GEORGETOWN		
NOT TO BE USED FOR CONSTRUCTION			GEORGETOWN, SC		
REVISION 11/30/22			FRONT ST ELECTRIC UPGRADE - PH. 2		
REVISION			ELECTRICAL PLAN		
NO.			EXISTING		
REVISIONS			UTILITY TECHNOLOGY		
DATE			ENGINEERS - CONSULTANTS, PLLC		
0 BID ISSUE 12/01/22			P.O. Box 2629 • Asheboro, North Carolina • 27204		
NO.			E2002		
DATE			SCALE: 1" = 20'		
NO.			JOB NO. 220901		
DATE			SHEET NO. 1 OF 1		

Dec 01, 2022 - 8:49am X:\Georgetown\Drawings\Phase 2\E2002\FSD Electrical Plan Existing Rev 04.dwg Layout E2002