
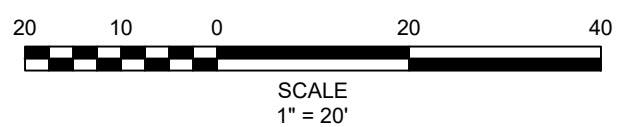


NOTES:

- THIS DRAWING BASED ON DOWNTOWN GEORGETOWN REVITALIZATION PROJECT, PLAN - FRONT STREET ELECTRICAL, DRAWINGS 1-14.

LEGEND:

- | | | | |
|-------|------------------------------------|-----|----------------------|
| --- | EXISTING SINGLE PHASE SERVICE | --- | OH POWER & TELEPHONE |
| --- | EXISTING THREE PHASE SERVICE | --- | WATER |
| --- | EXISTING THREE PHASE PRIMARY | --- | SS - SANITARY SEWER |
| --- | NEW SINGLE PHASE SECONDARY/SERVICE | --- | SD - STORM DRAIN |
| --- | NEW THREE PHASE SECONDARY/SERVICE | --- | G - GAS |
| --- | NEW THREE PHASE PRIMARY | --- | UGT - UG TELEPHONE |
| ⊙ | ELECTRIC METER | CB | CATCH BASIN |
| ⊙ | DECORATIVE LIGHT | MH | MANHOLE |
| — P — | OH POWER | FH | FIRE HYDRANT |
| ○ | NEW 6" CONCRETE BOLLARD | PP | POWER POLE |
| — T — | OH TELEPHONE | | DOCKS |

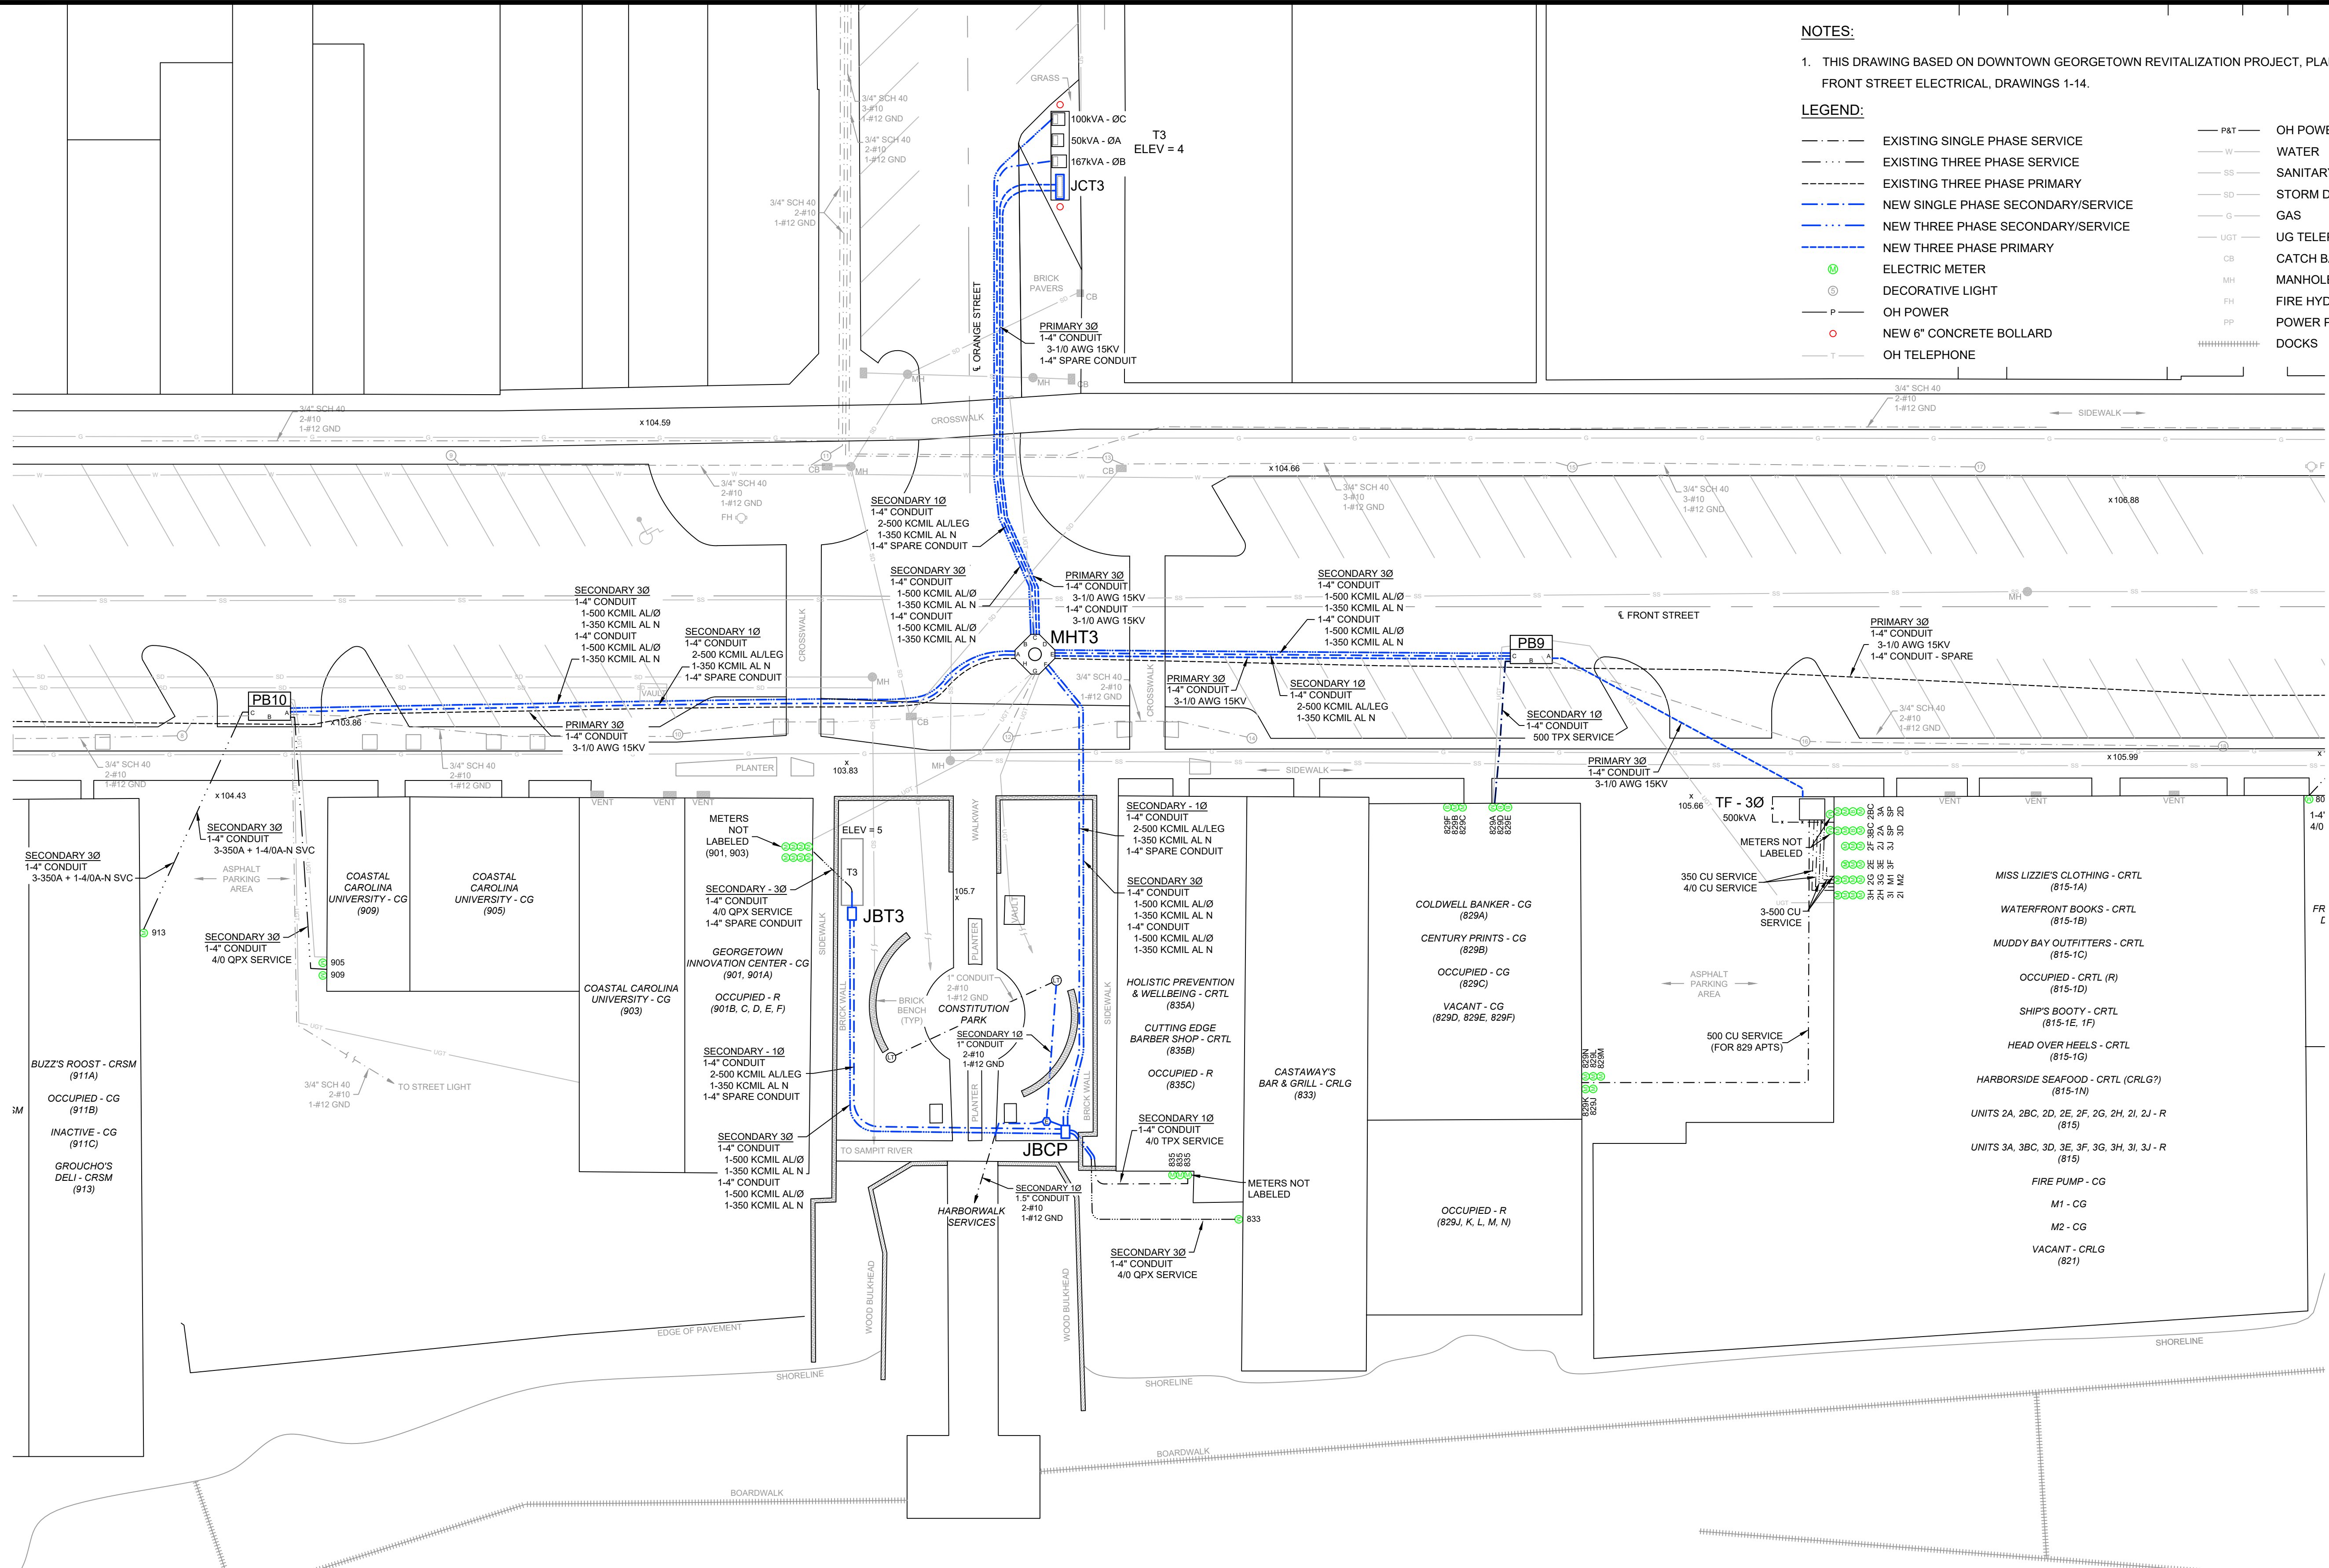

NO.	REVISIONS	DATE

PRELIMINARY
NOT TO BE USED FOR CONSTRUCTION
 REVISION 11/30/22

CITY OF GEORGETOWN
 GEORGETOWN, SC
FRONT ST ELECTRIC UPGRADE - PH. 2
ELECTRICAL PLAN
NEW

UTILITY TECHNOLOGY ENGINEERS - CONSULTANTS, PLLC
 P.O. Box 2629 • Asheboro, North Carolina • 27204

E2003

SCALE: 1" = 20'
 JOB NO. 220901
 SHEET NO. 1 OF 1

Y:\Georgetown\Phase 2\Phase 2\2024\ESD\Electrical Plan New Rev 0.dwg Layer: E2003
 Dec 11, 2022, 8:55am