


**NOTES:**

1. TRANSFORMER TO BE INSTALLED LATER BY OWNER. PRIMARY CONDUCTORS ARE IN TEMPORARY ELBOW JUNCTION CABINET.
2. 3Ø CIRCUIT TO 601 FRONT STREET NOT IN USE. CONDUCTORS ARE DEAD-ENDED IN SECONDARY PEDESTAL AT BASE OF OVERHEAD 1Ø SERVICE DIP POLE.

**LEGEND:**

- EXISTING EQUIPMENT
- - - EXISTING CABLE
- FUTURE EQUIPMENT
- - - FUTURE CABLE
- TRANSFORMER
- OVERHEAD FUSE
- 15 KV LOADBREAK ELBOW
- SURGE ARRESTER

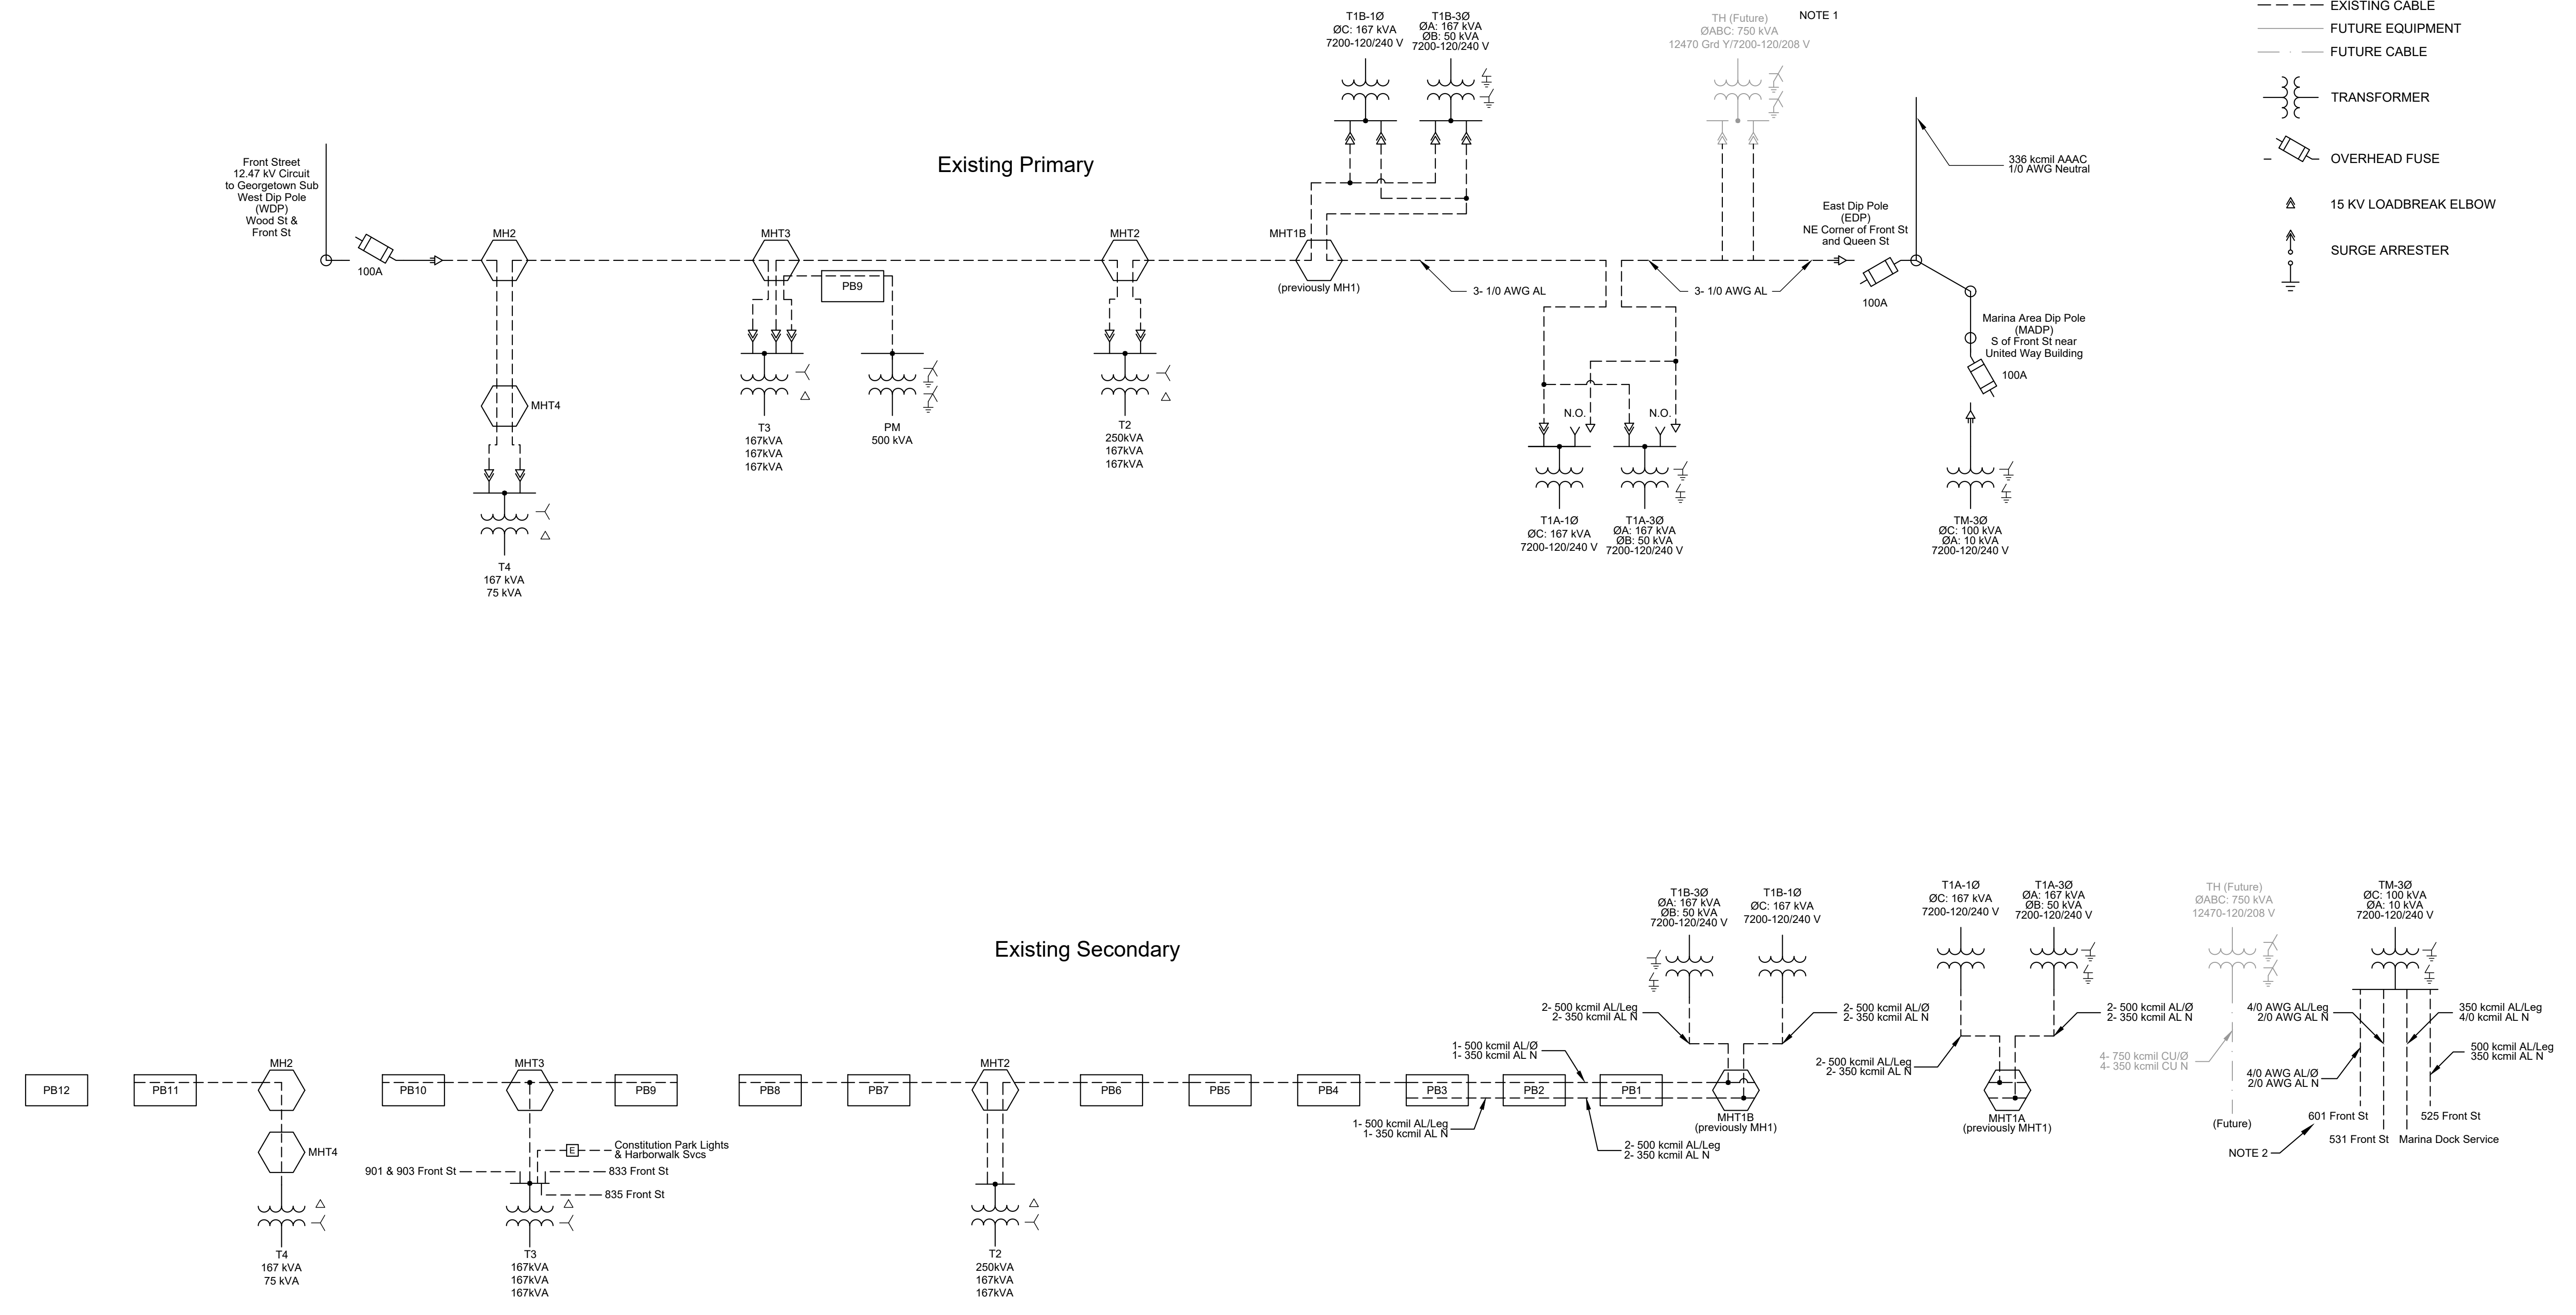

	<b>PRELIMINARY</b>	<b>CITY OF GEORGETOWN</b> GEORGETOWN, SC	
	NOT TO BE USED FOR CONSTRUCTION	<b>FRONT ST ELECTRIC UPGRADE - PH. 2</b>	
	REVISION 11/29/22	<b>ONE-LINE DIAGRAM</b>	
		<b>EXISTING</b>	
NO.	REVISIONS	DATE	
0	BID ISSUE	12/01/22	
<b>UTEC</b>		<b>UTILITY TECHNOLOGY</b> ENGINEERS - CONSULTANTS, PLLC	
SCALE: NONE	JOB NO. 220901	DATE: 10/31/22	DWG. NO. <b>E2100-1</b>
	SHEET NO.	1 OF 2	

Dec 01, 2022 - 9:40am  
 Y:\Georgetown\Front St\Phase 2\E2100-1\ESD\One-Line\Diagram\Rev 0.dwg Layer: E2100-1