


Notes:

1. Acoustical Ceiling Tile in the Office, and Bathrooms shall be at 8'0" from finish floor
2. Lighting in Office, Bathrooms shall be 4' troffers with 3 bulb LED bulbs.
3. Lighting in Storage and Canopy shall be 4' wraps with 2 bulb LED bulbs.
4. Lighting on the front corner shall be 60 watt LED Wall Packs.
5. Receptacles, switches and thermostat controls shall be white with white cover plates
6. Fixture colors will be standard color selection from manufacturer. Owner will dicide color.

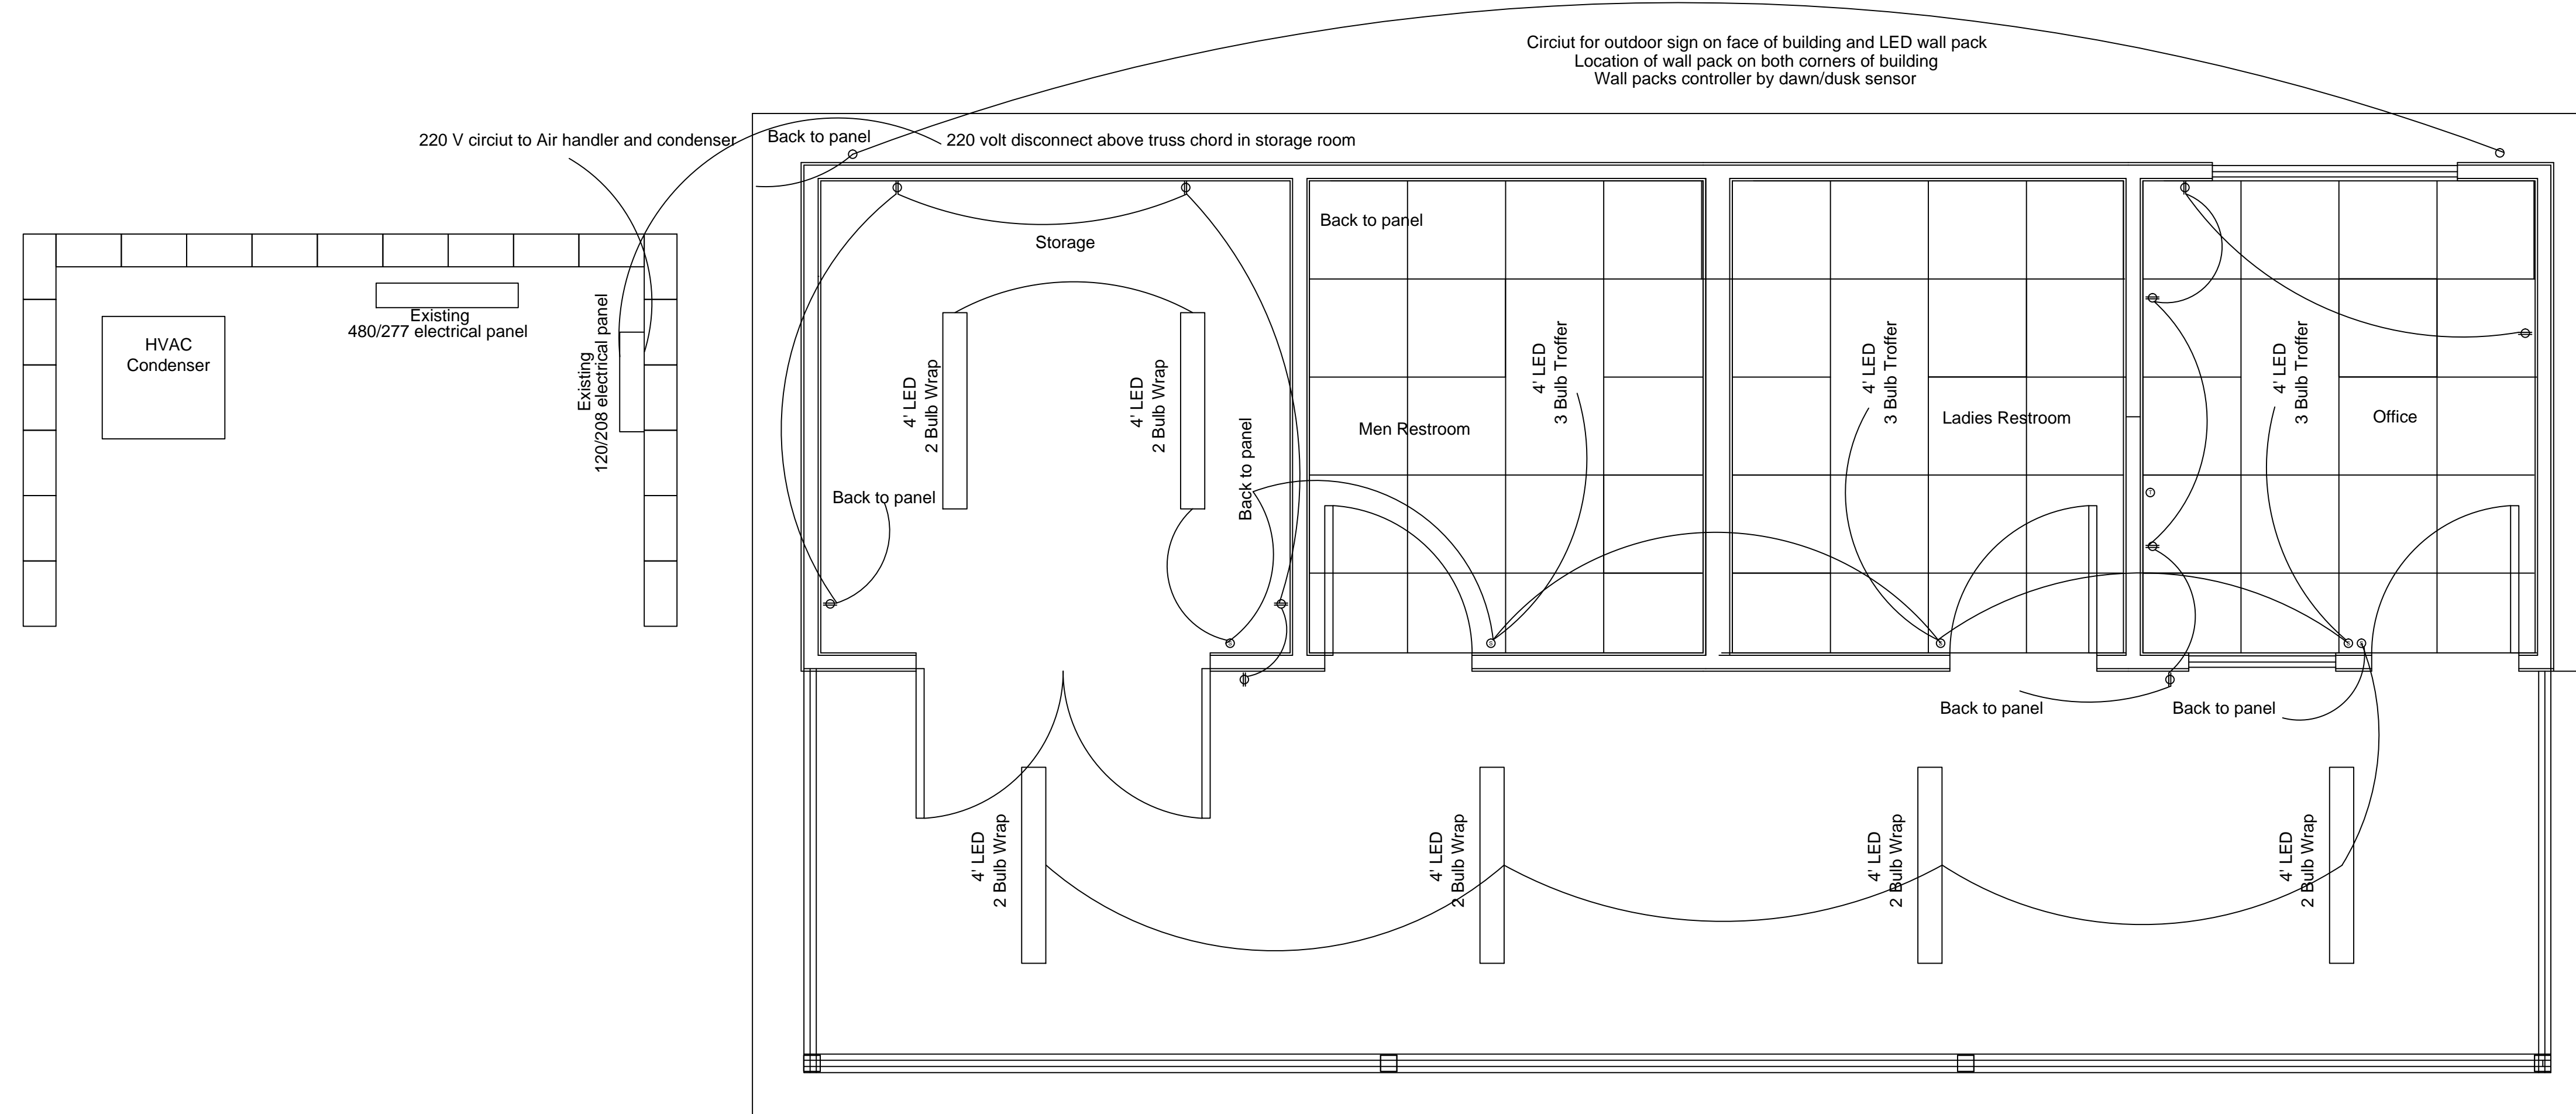

NOT TO SCALE

Drawn By	DC	REV.	DESCRIPTION	DATE	BY
Checked By	SP				
App'd By	DC				
Date	AUG/16/2017				

CITY OF SPARTANBURG CONSTRUCTION MANAGEMENT

HOT SPOT SKATE PARK
BUILDING REPLACEMENT

DESCRIPTION; Electrical Plan	Dwg. No.
Scale : NTS	E-1 1 of