


REVISIONS		
DATE	DESCRIPTION	INITIALS

SCADA RELOCATION PROJECT SP1901

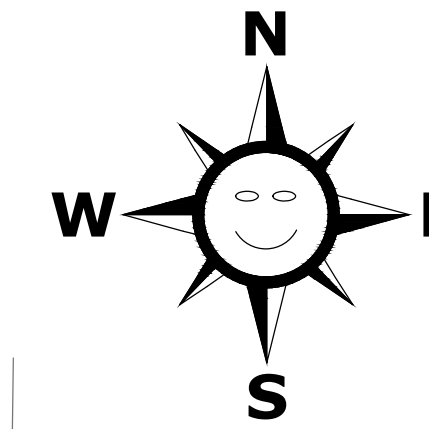

SCALE: 1" = 30'

LEGEND:


- | | |
|---|---|
| # = NUMBER | A/C = AIR CONDITIONER |
| - = DISTANCE NOT TO SCALE | ⊕ = POWER POLE AND GUY ANCHOR |
| L.B. = LICENSED BUSINESS | — = ROAD SIGN |
| L.S. = LICENSED SURVEYOR | RCP = REINFORCED CONCRETE PIPE |
| P.S.M. = PROFESSIONAL SURVEYOR AND MAPPER | CMP = CORRUGATED METAL PIPE |
| AC. = ACRES | CPP = CORRUGATED PLASTIC PIPE |
| O.R. = OFFICIAL RECORDS BOOK / PAGE | —E-SWR— = EXISTING SANITARY SEWER PIPE |
| P.B. = PLAT BOOK / PAGE | —E-TEL— = EXISTING TELEPHONE CABLE |
| D.B. = DEED BOOK / PAGE | —E-UFO— = EXISTING FIBER-OPTIC CABLE |
| ± = MORE OR LESS | —E-ELE— = EXISTING ELECTRIC CABLE |
| R/W = RIGHT OF WAY | —E-GAS— = EXISTING GAS MAIN |
| ℄ = CENTERLINE | —E-OHU— = EXISTING OVERHEAD UTILITIES |
| ⊠ = TELEPHONE SERVICE BOX | —E-WL— = EXISTING WATER LINE |
| ⊙ = SANITARY SEWER MANHOLE | —E-F.M.— = EXISTING FORCE MAIN |
| ⊕ = STORM DRAINAGE MANHOLE | —FO— = FIBER OPTIC LINE IN 1" SCH. 40 PVC CONDUIT |
| ⊕ = WATER VALVE | — = WETLANDS |
| ⊠ = TELEVISION SERVICE BOX | ☆ = LAMP POST |
| ⊠ = WATER METER | F.M. = FORCE MAIN |
| ⊕ = LIGHT POLE | TCB = TRAFFIC CONTROL BOX |
| | — = FIBER-OPTIC MARKER |
| | CONC. = CONCRETE |
| | NO ID = NO IDENTIFICATION |
| | BFP = BACKFLOW PREVENTER |

SCALE IN FEET




NOTES:


1. PROVIDE 48 HOUR NOTICE TO CITY FIRE STATION #7 BATTALION CHIEF AND CITY SEWER COLLECTIONS SUPERVISOR AT (850) 585-9015 AND (850) 833-9613 RESPECTFULLY.
2. FIRE TRUCK ACCESS SHALL NOT BE BLOCKED AT ANY POINT IN TIME.
3. CHECK-IN IS REQUIRED WITH FIRE DEPARTMENT STAFF PRIOR TO DAILY WORK SCHEDULE.

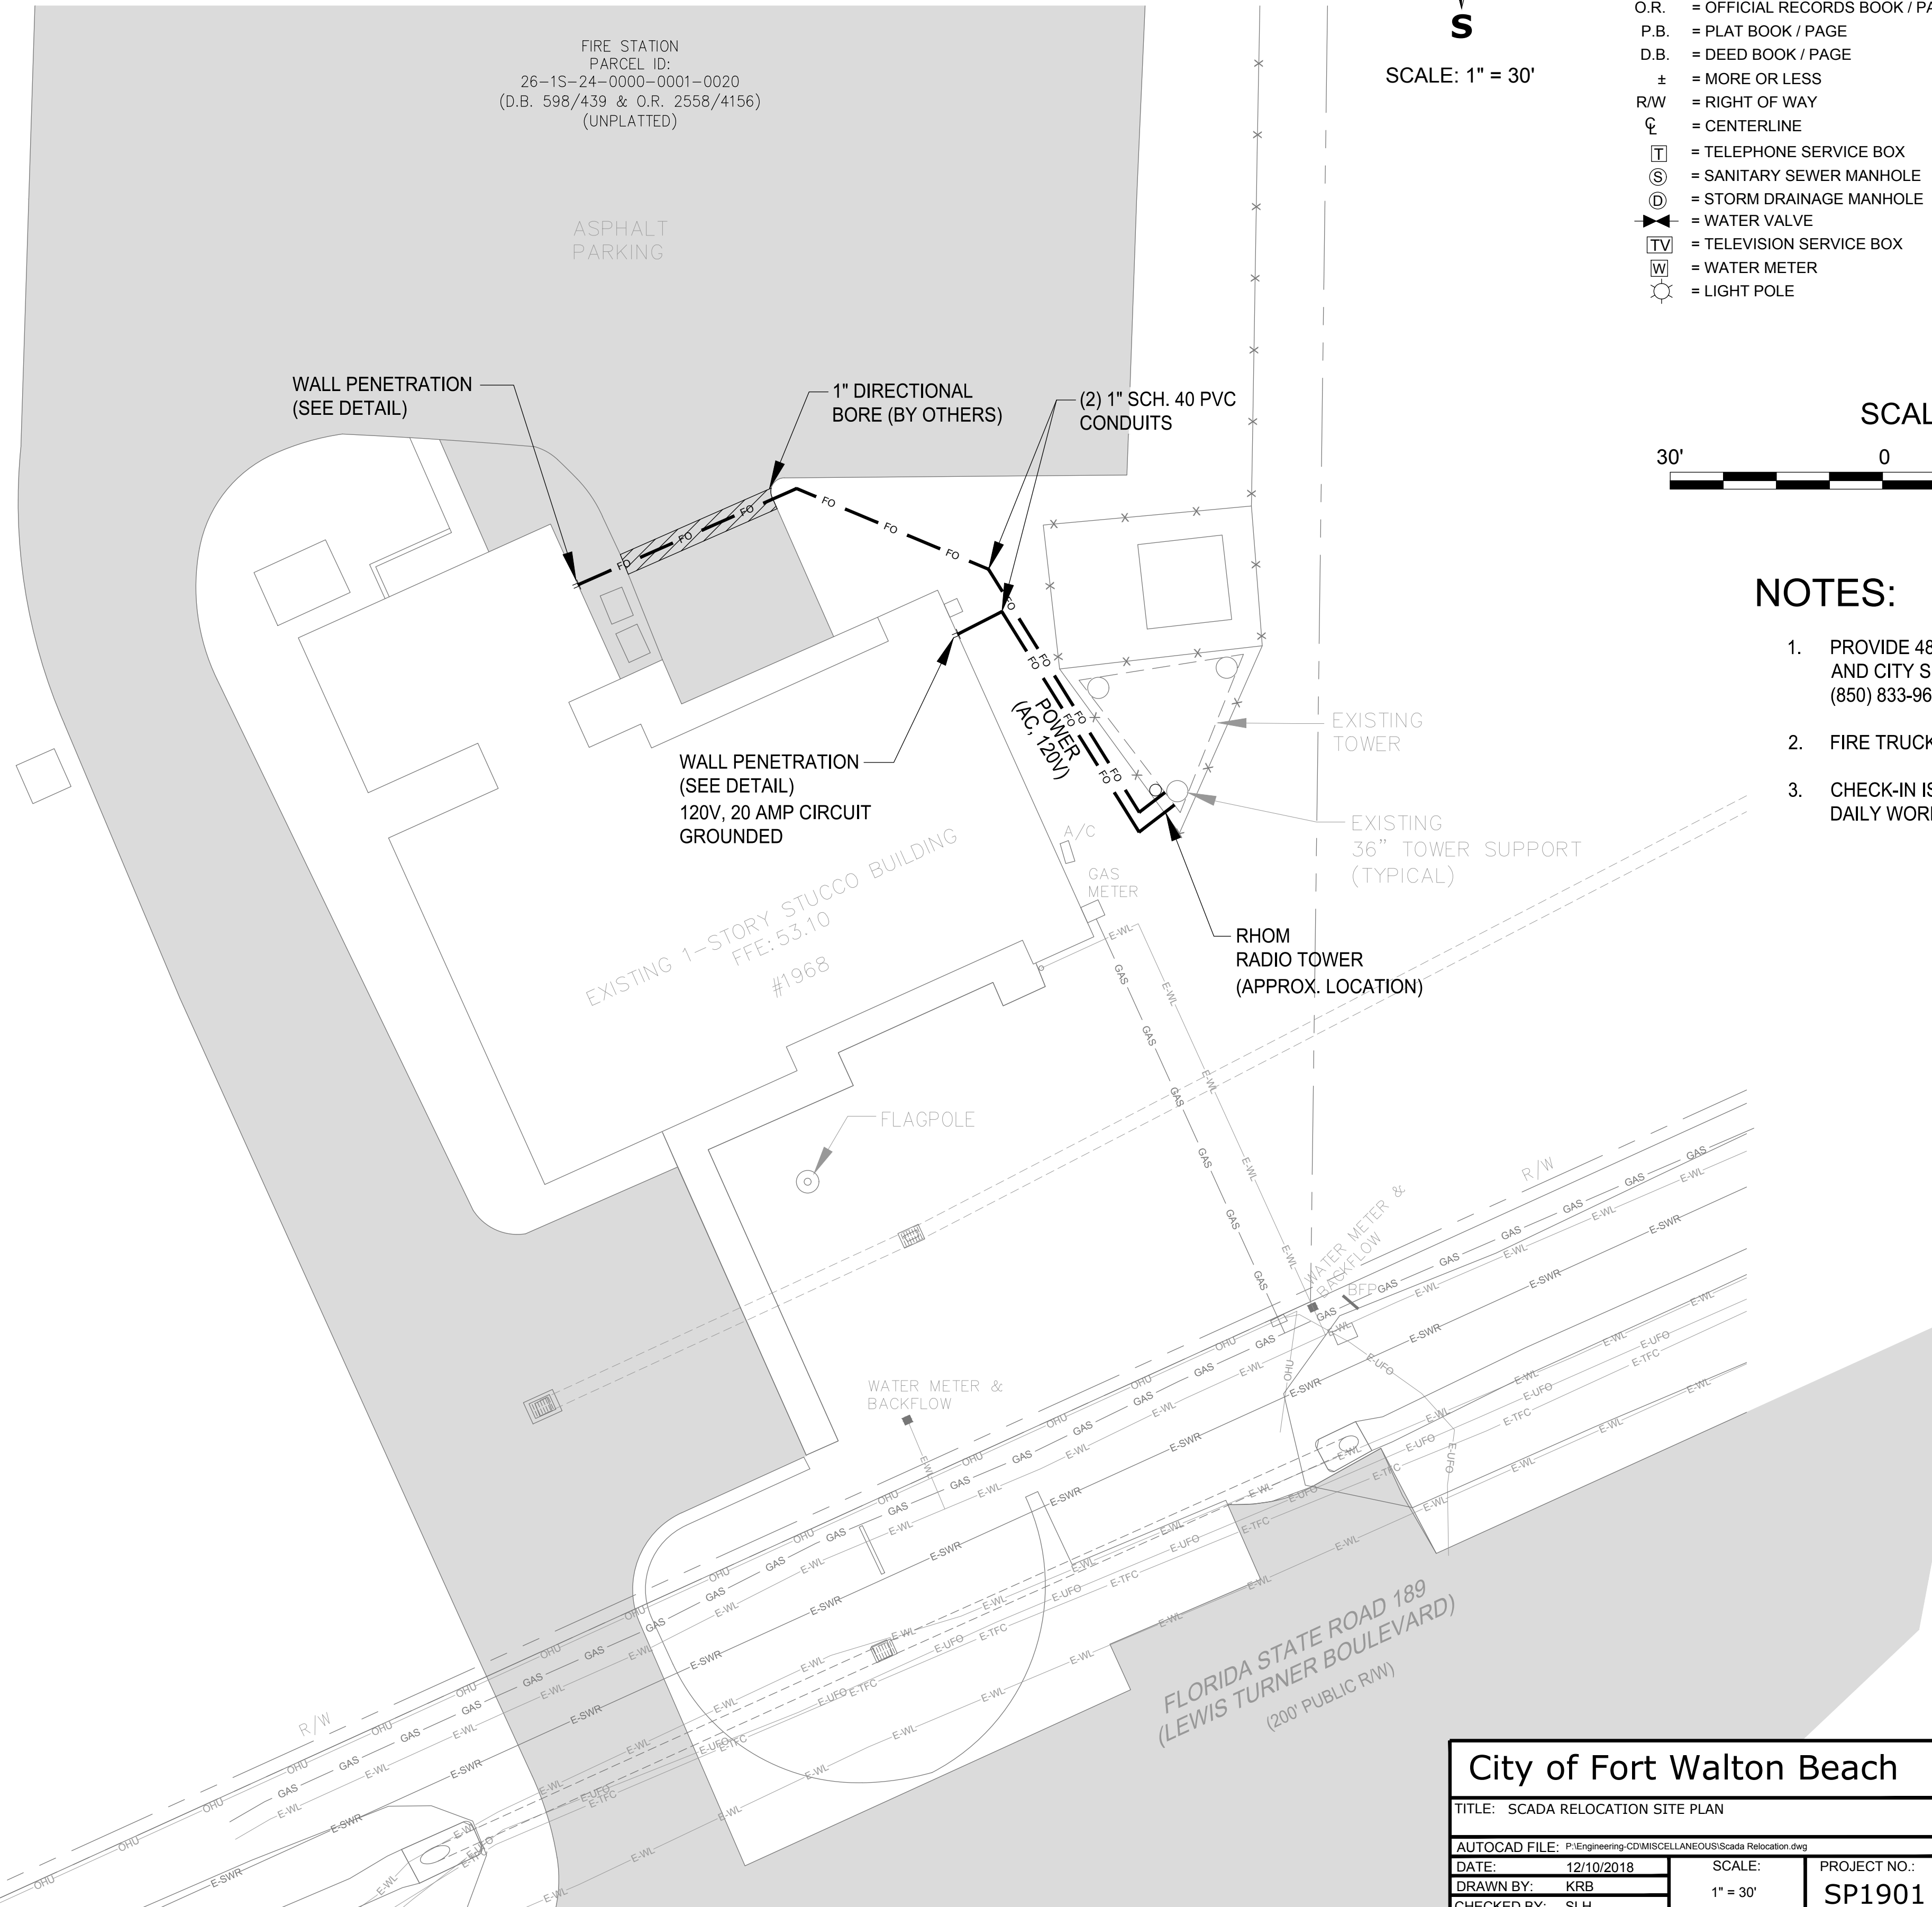

WALL PENETRATION DETAIL

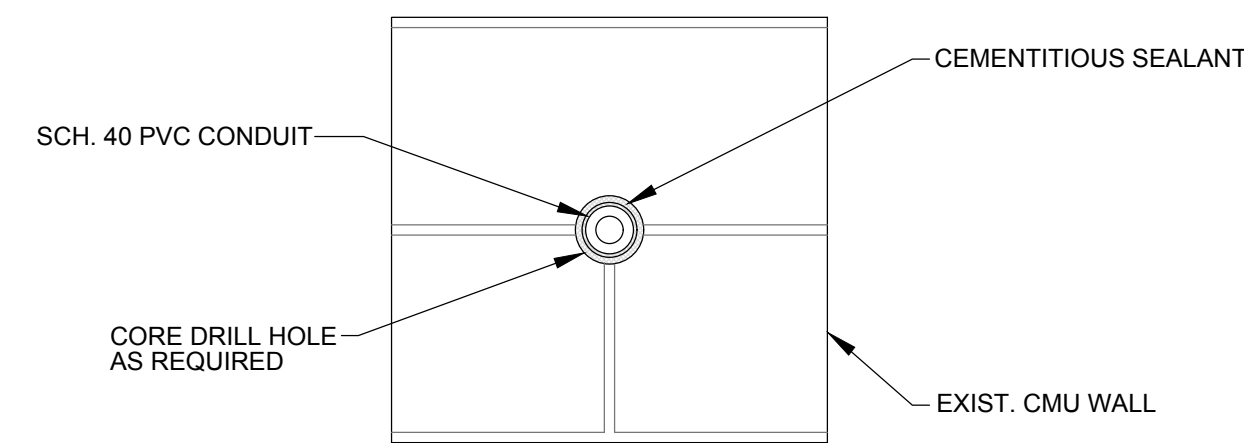

PLAN

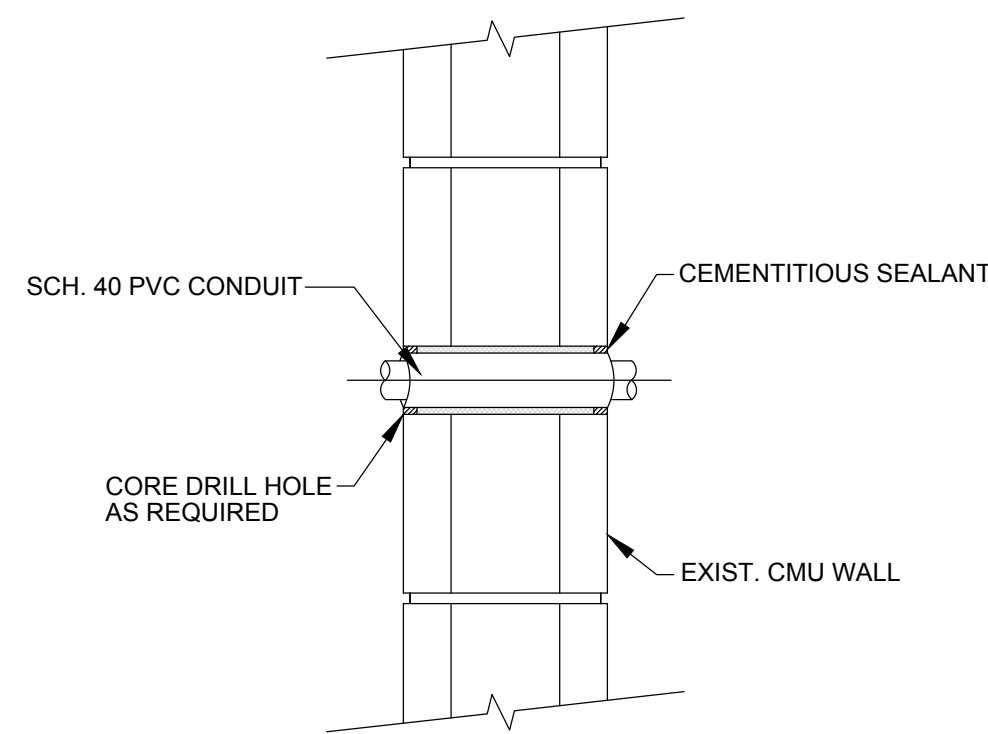

SECTION

SCALE: N.T.S.

City of Fort Walton Beach		SUBDIVISION NAME: METE & BOUNDS	
TITLE: SCADA RELOCATION SITE PLAN		CONSTRUCTION DATE:	
AUTOCAD FILE: P:\Engineering\CD\MISC\ELLANE\SCADA Relocation.dwg		EASEMENTS:	
DATE: 12/10/2018	SCALE: 1" = 30'	PROJECT NO.: SP1901	SHEET 1 OF 1
DRAWN BY: KRB			DRAWING NO. 7-242
CHECKED BY: SLH			