

SHEET NOTES

1. REFER TO ARCHITECTURAL PLANS FOR EXACT LOCATIONS OF OUTLETS, DEVICES, AND EQUIPMENT. ALSO REFER TO ELECTRICAL PLANS TO COORDINATE FINAL LOCATIONS OF OUTLETS, DEVICES, AND EQUIPMENT.
2. REFER TO OVERALL PLANS FOR TELECOM DEVICES SERVING LOCATIONS.
3. REFER TO SHEET T5.02 FOR PATHWAY REQUIREMENTS.
4. REFER TO ARCHITECTURAL DRAWINGS FOR THE FURNITURE LOCATION.
5. REFER TO OVERALL PLANS FOR PROJECTION SCREEN LOCATIONS. CENTER PROJECTOR TO PROJECTOR SCREEN LATERALLY.
6. SEE INSTALLATION DETAIL IN THIS SET.

NUMBERED NOTES

- 01 REFER TO OVERALL PLAN FOR MULTI SERVICE FLOOR BOX AND POKE-THROUGH
- 02 THIS FLOOR BOX ONLY APPLIES TO ROOM NUMBER 100
- 03 THIS FLOOR BOX ONLY APPLIES TO ROOM NUMBER 120

AV EQUIPMENT LIST

| ID | DESCRIPTION |
|-----|--------------------------------|
| 104 | ASSISTIVE LISTENING PLATE |
| 105 | CONTROL PANEL |
| 106 | ROOM SCHEDULER |
| 113 | INTERFACE PLATE |
| 114 | WALL MOUNTED PROJECTION SCREEN |
| 115 | PROJECTOR |




NOLL & TAM
ARCHITECTS

729 Heinz Avenue
Berkeley, CA 94710
tel 510.542.2200
fax 510.542.2201

CAVAGNERO
MARK CAVAGNERO ASSOCIATES ARCHITECTS
1845 KATEWIND DRIVE, SUITE 200
SAN FRANCISCO, CALIFORNIA 94111
www.cavagnero.com

SEAL



TEECOM
1222 Broadway
Oakland, CA
94612
916.872.2880
www.teecom.com

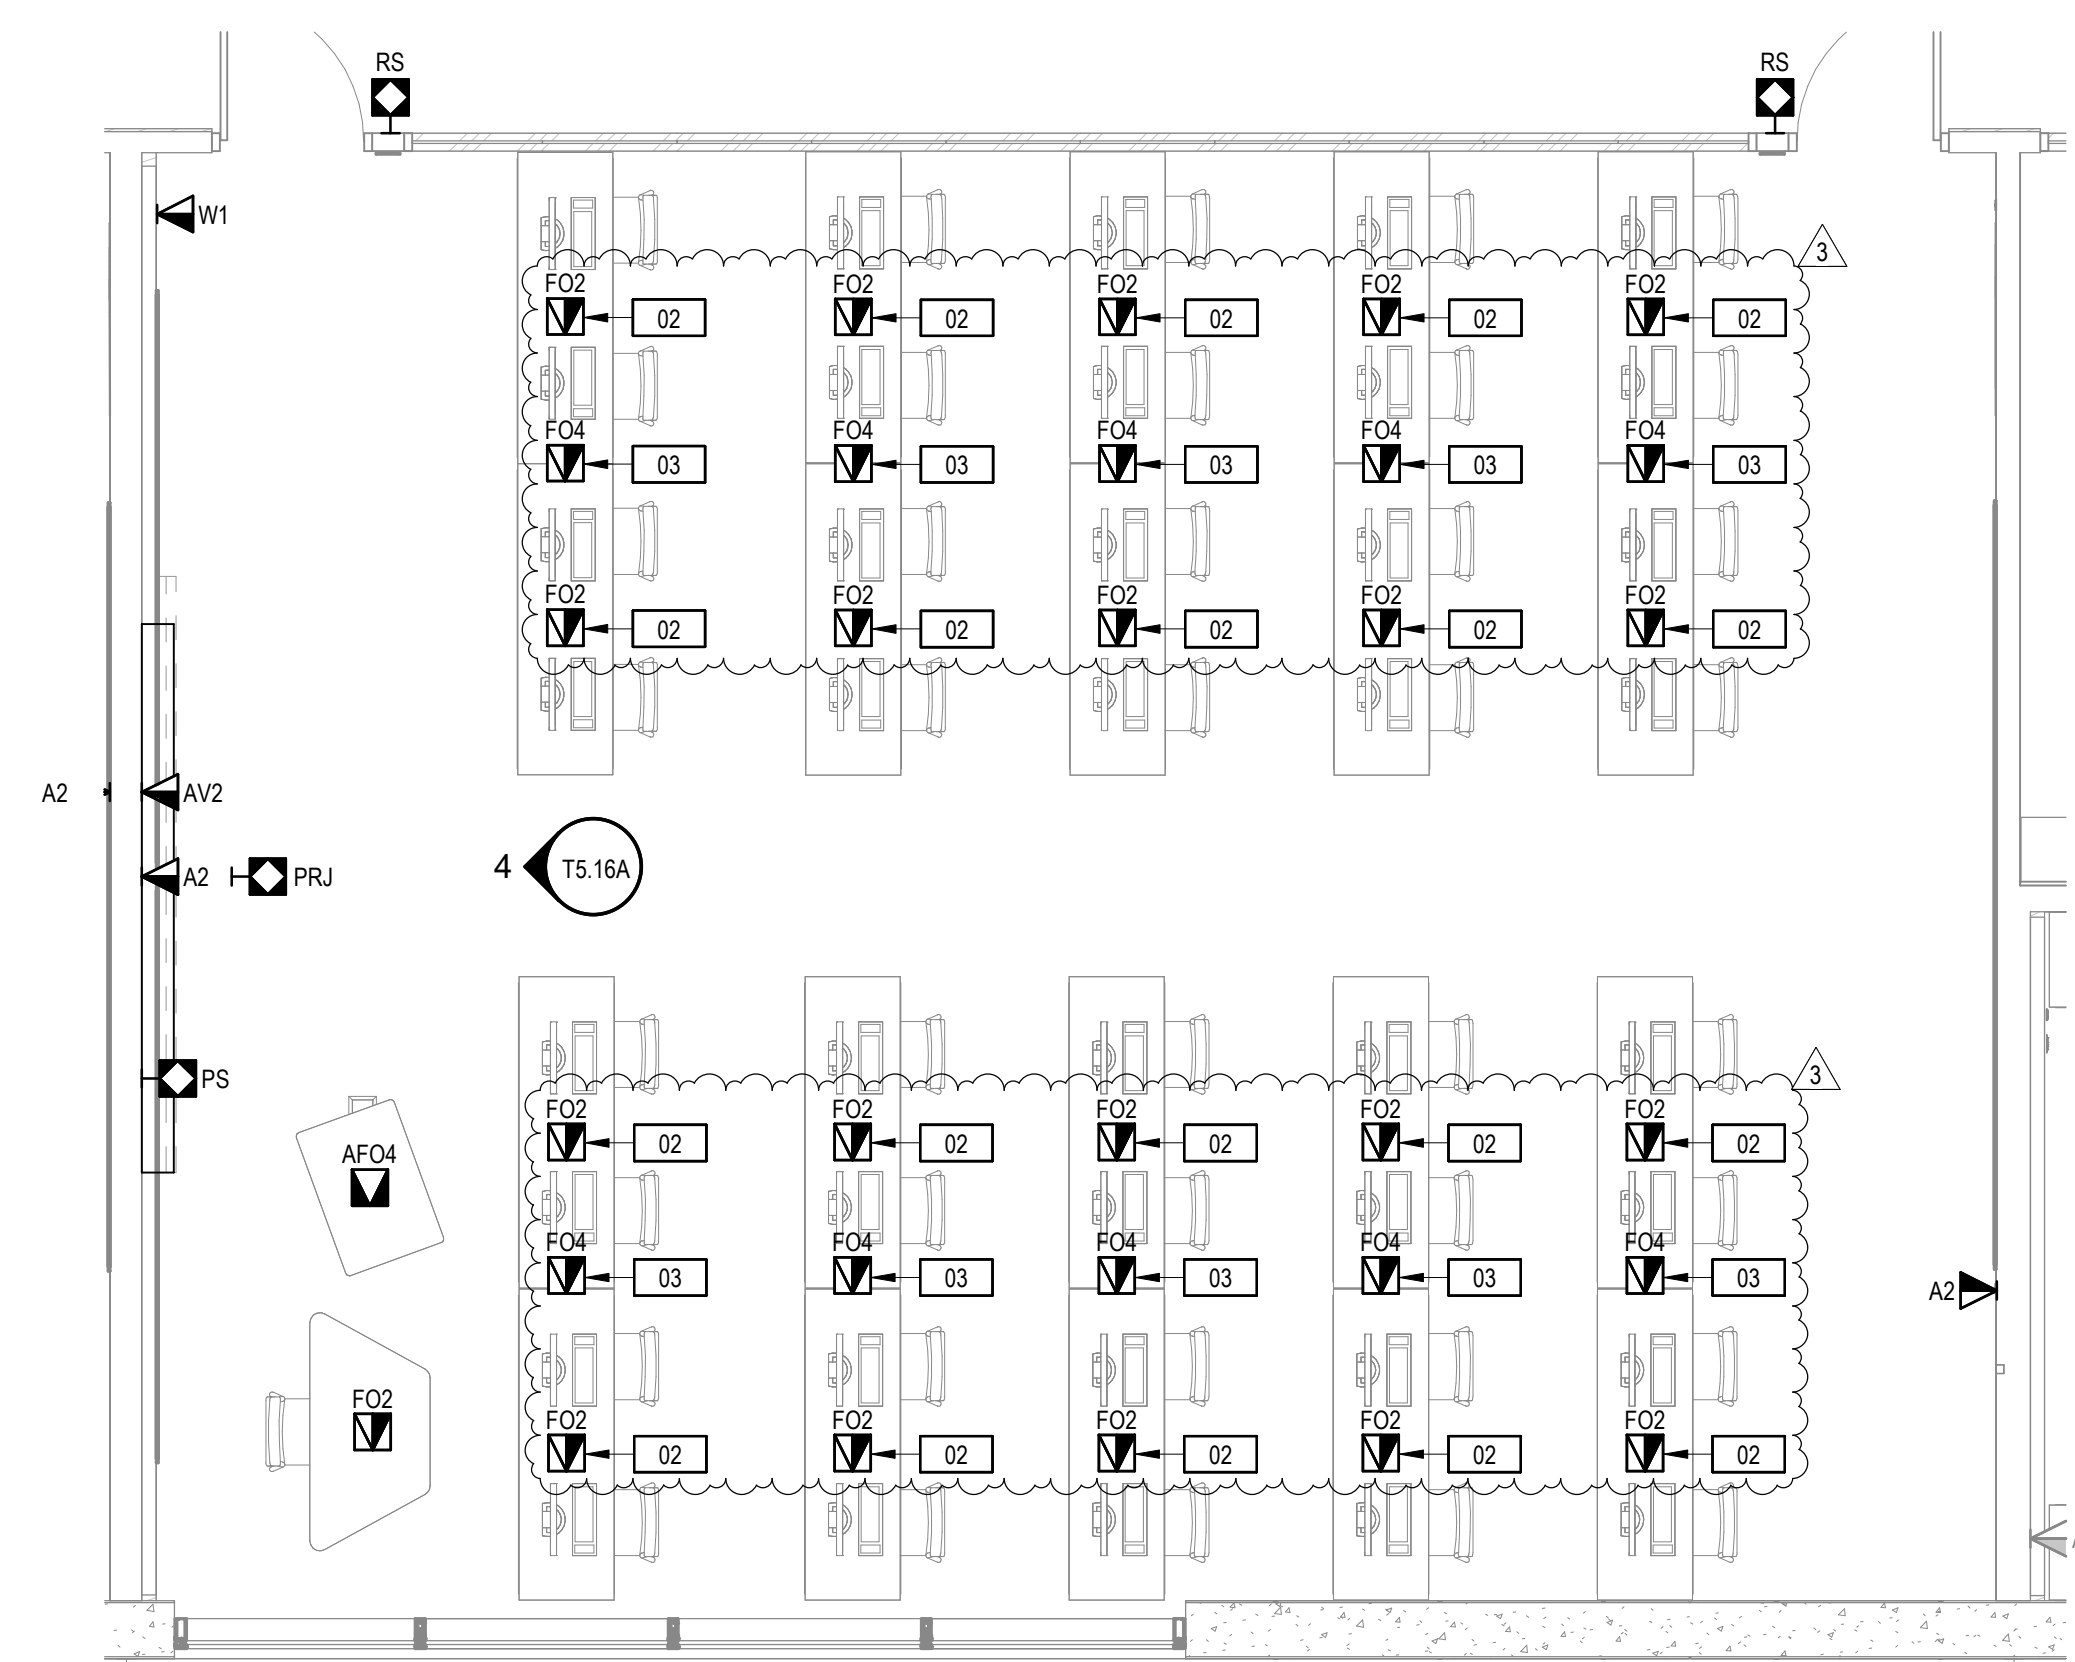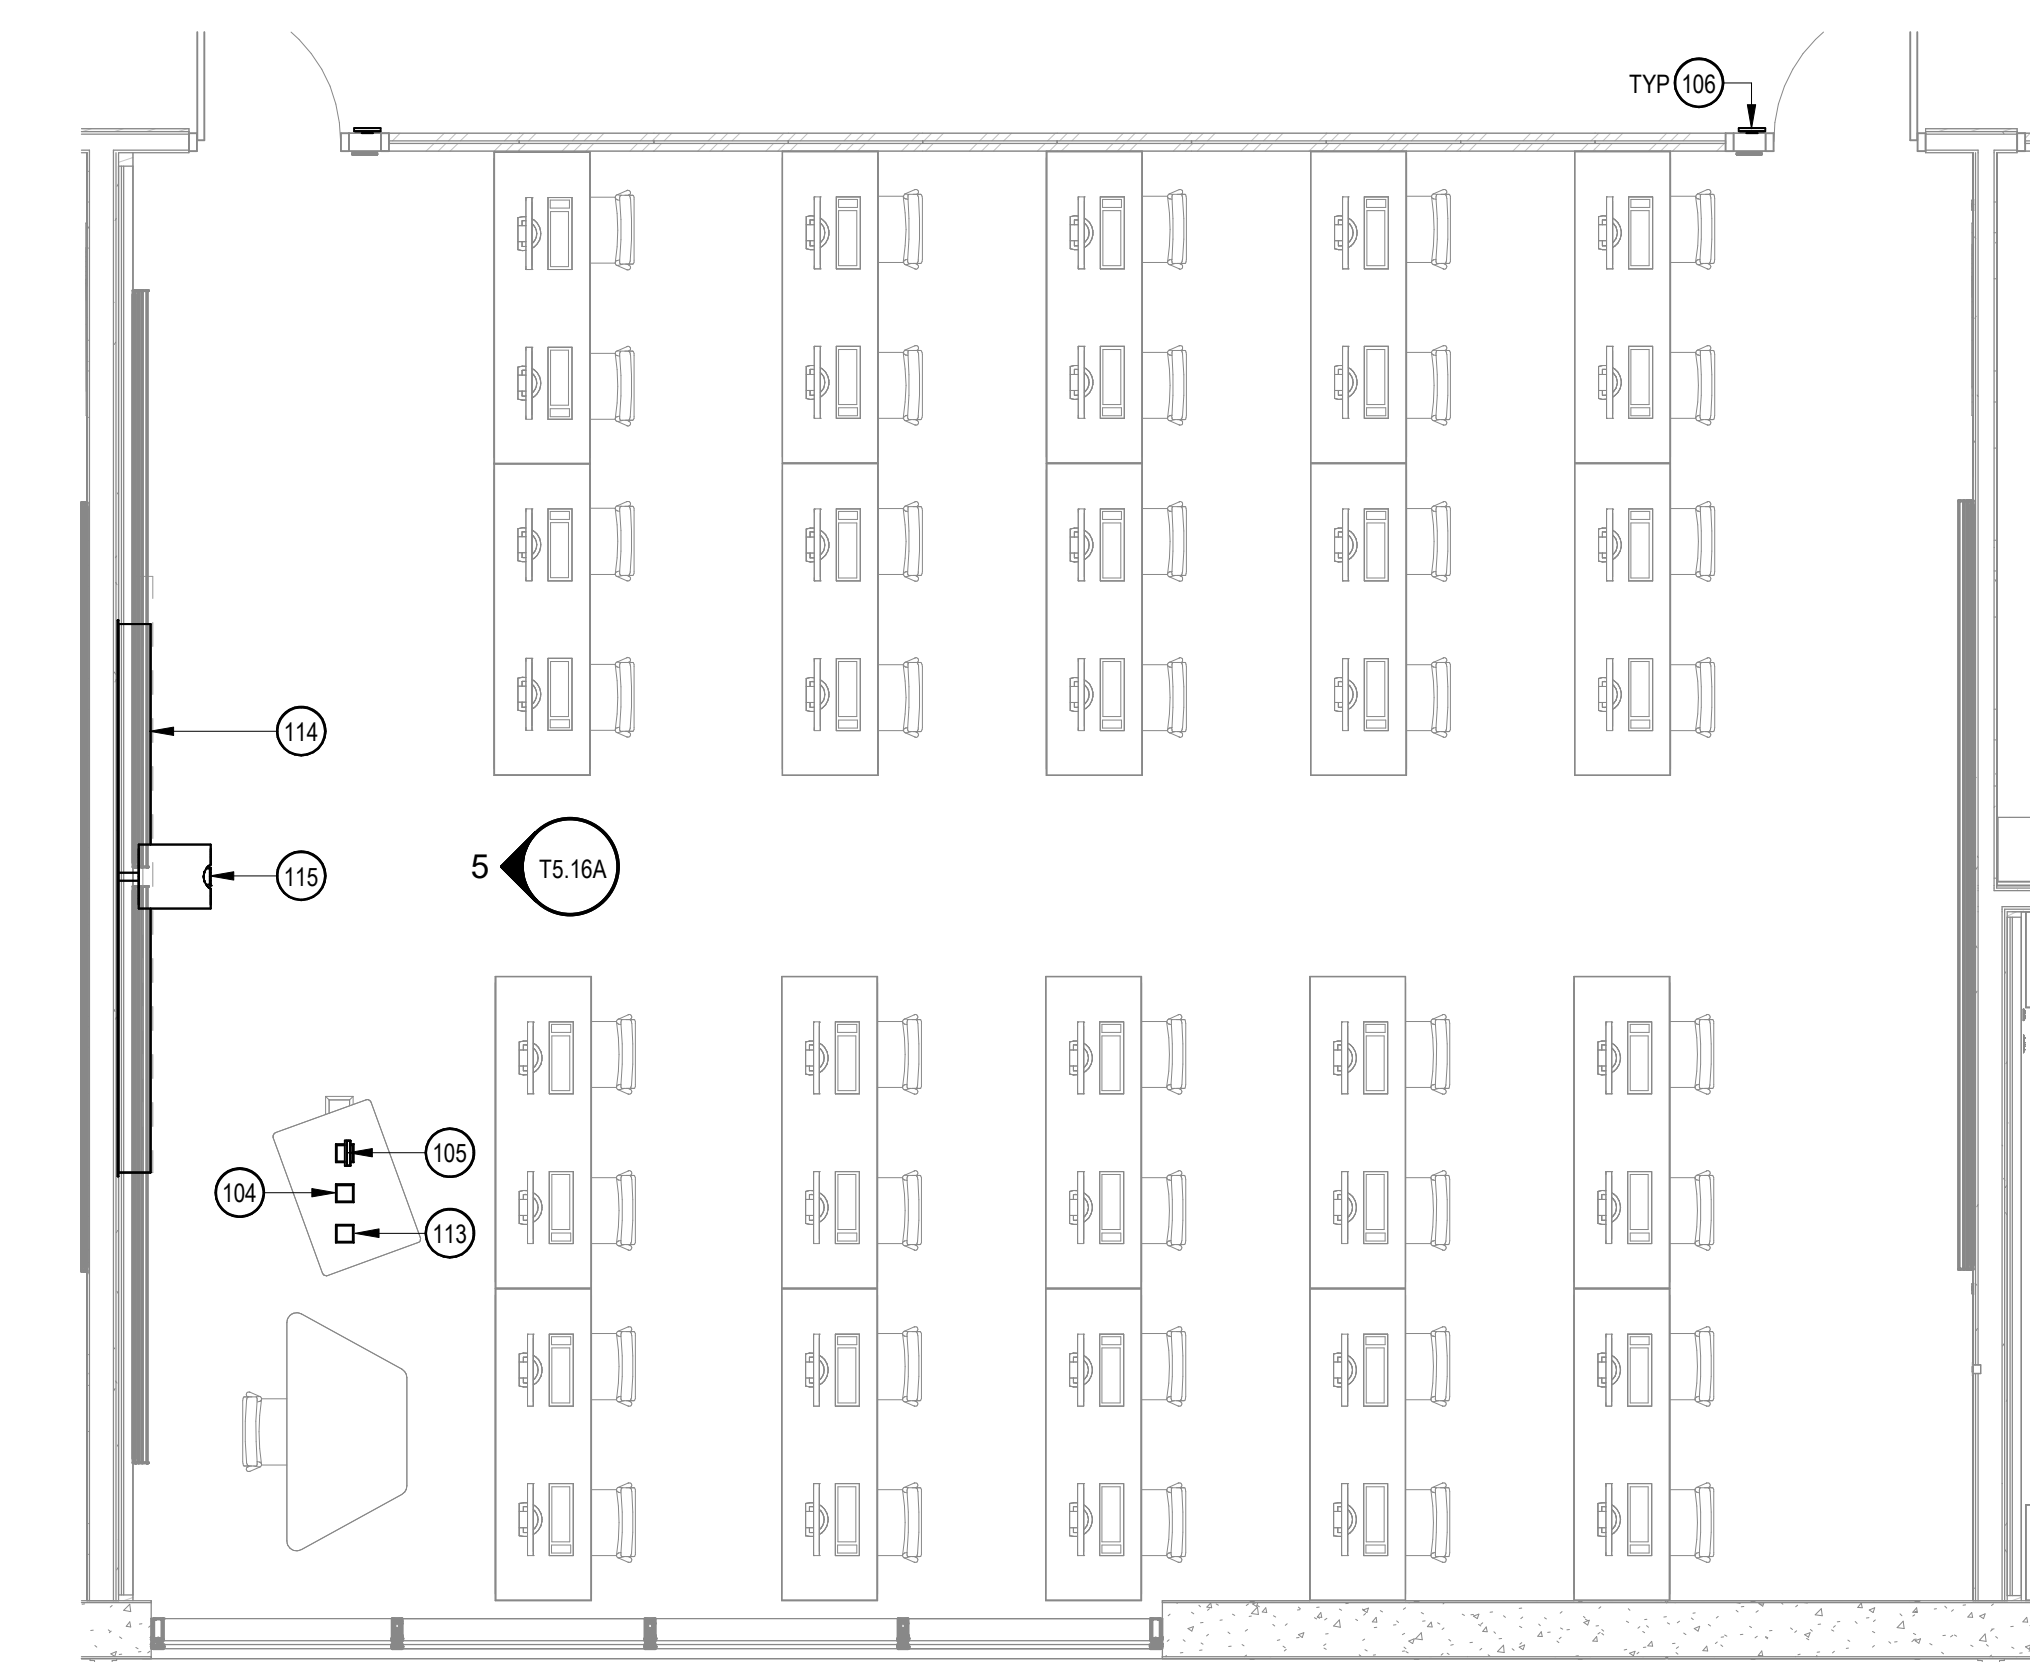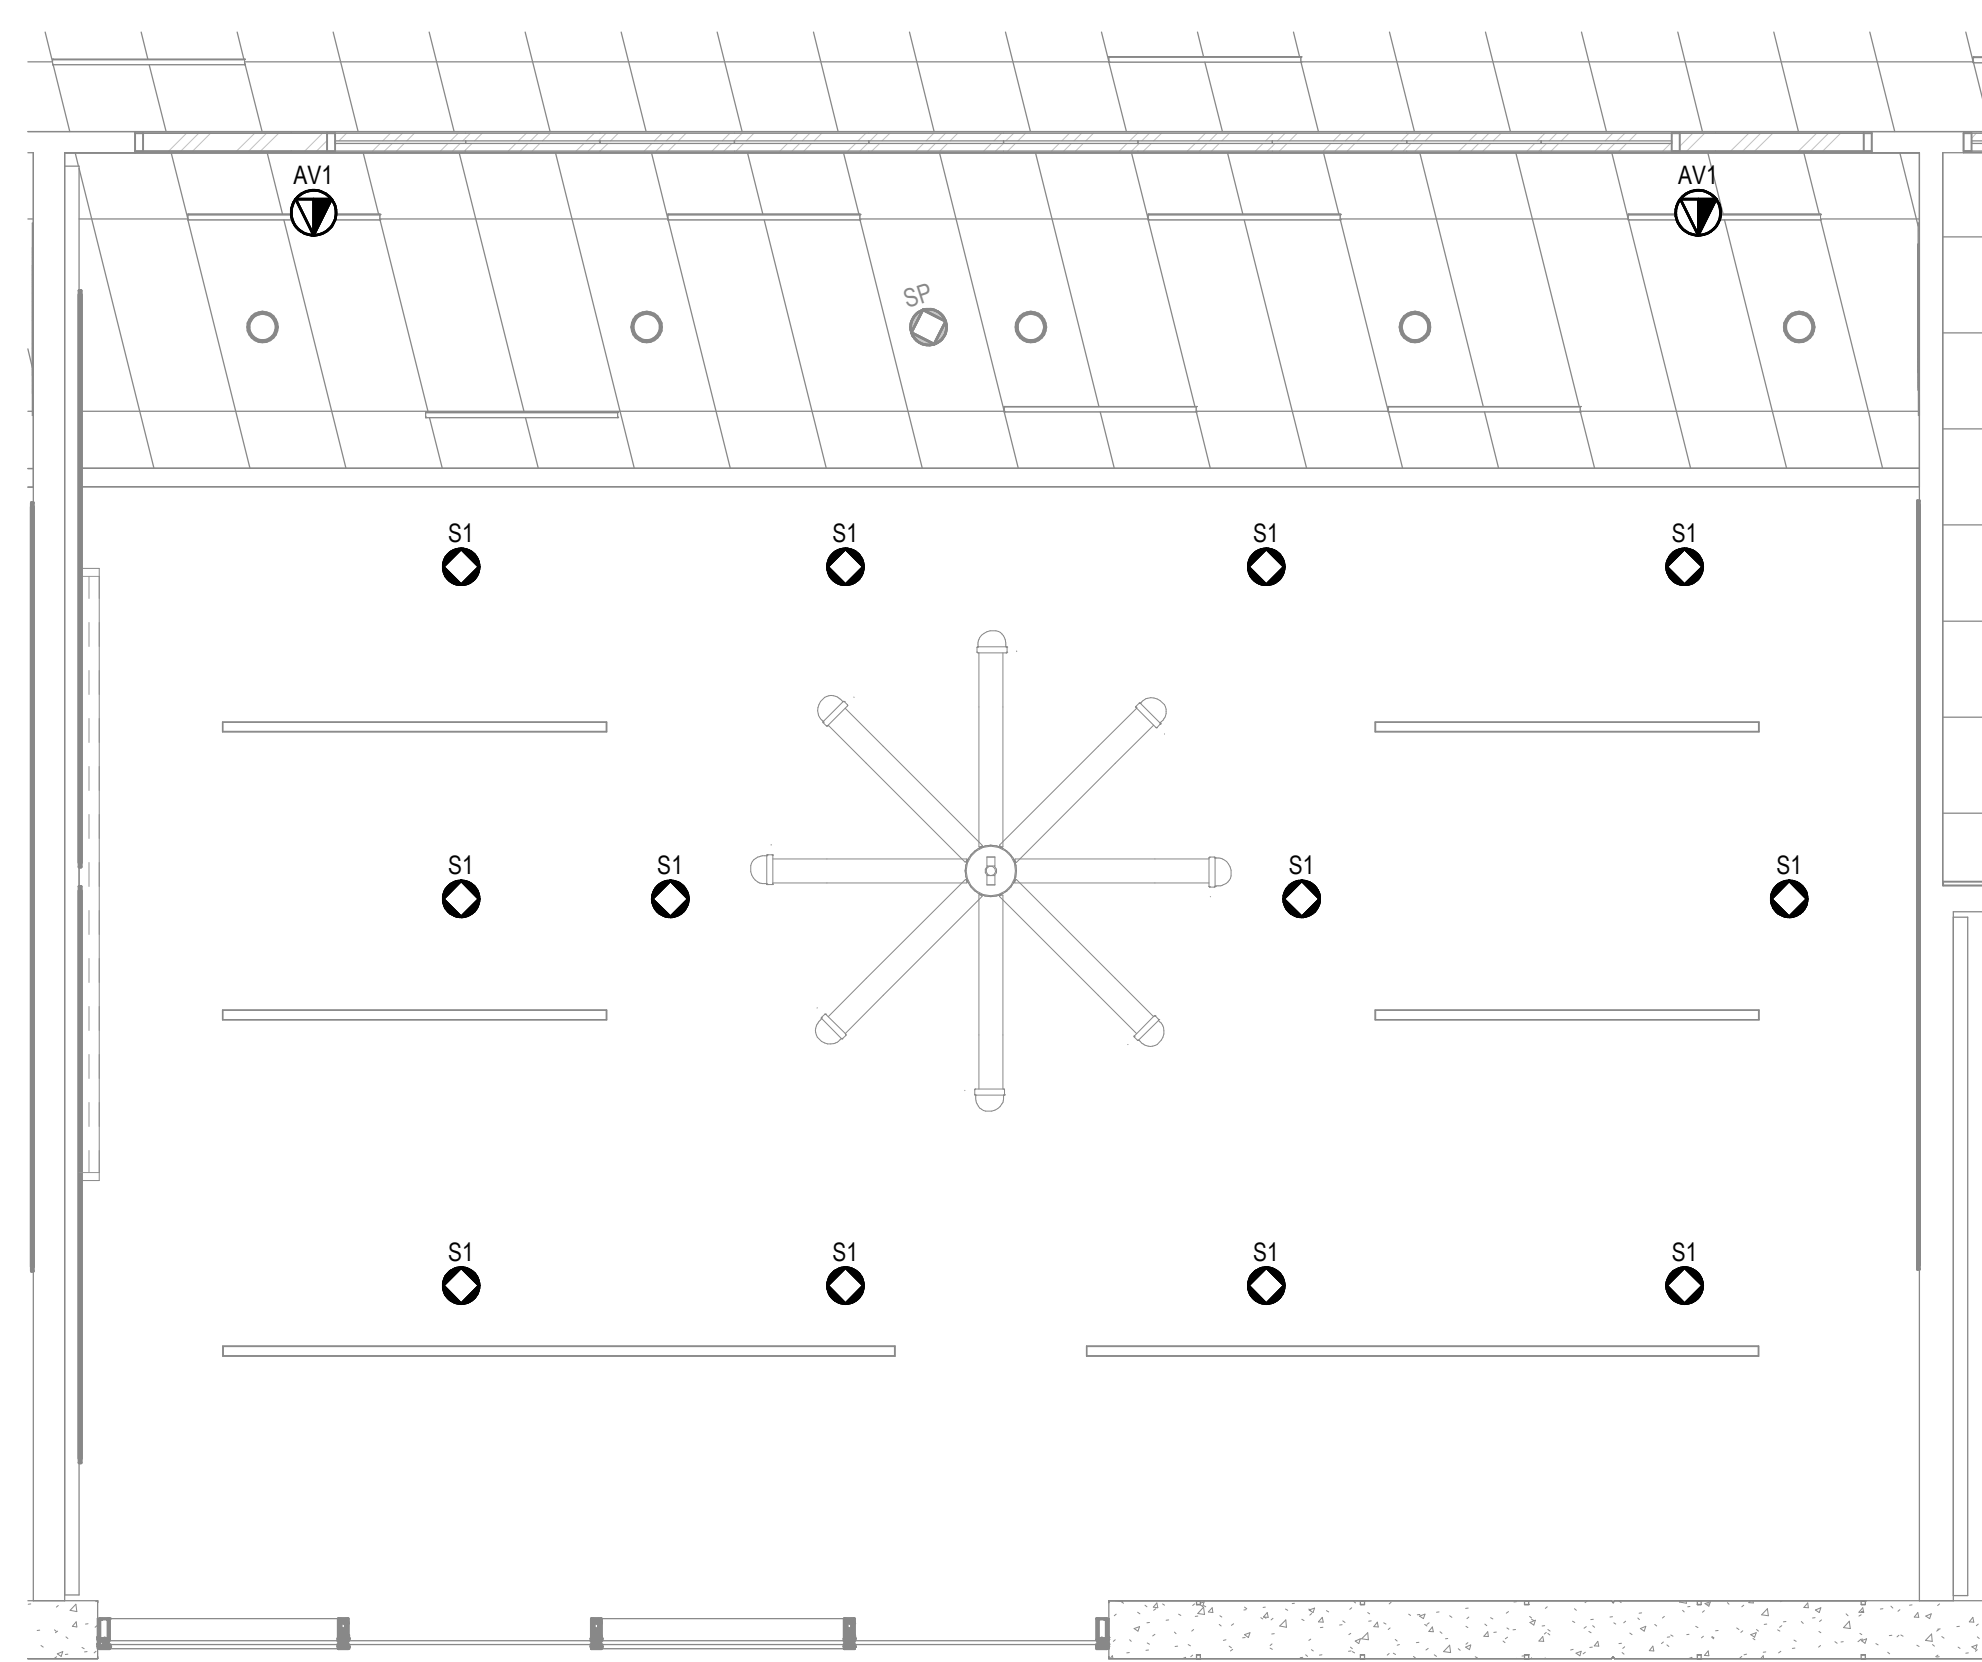

3 REFLECTED CEILING PLAN

2 EQUIPMENT PLAN

1 INFRASTRUCTURE PLAN

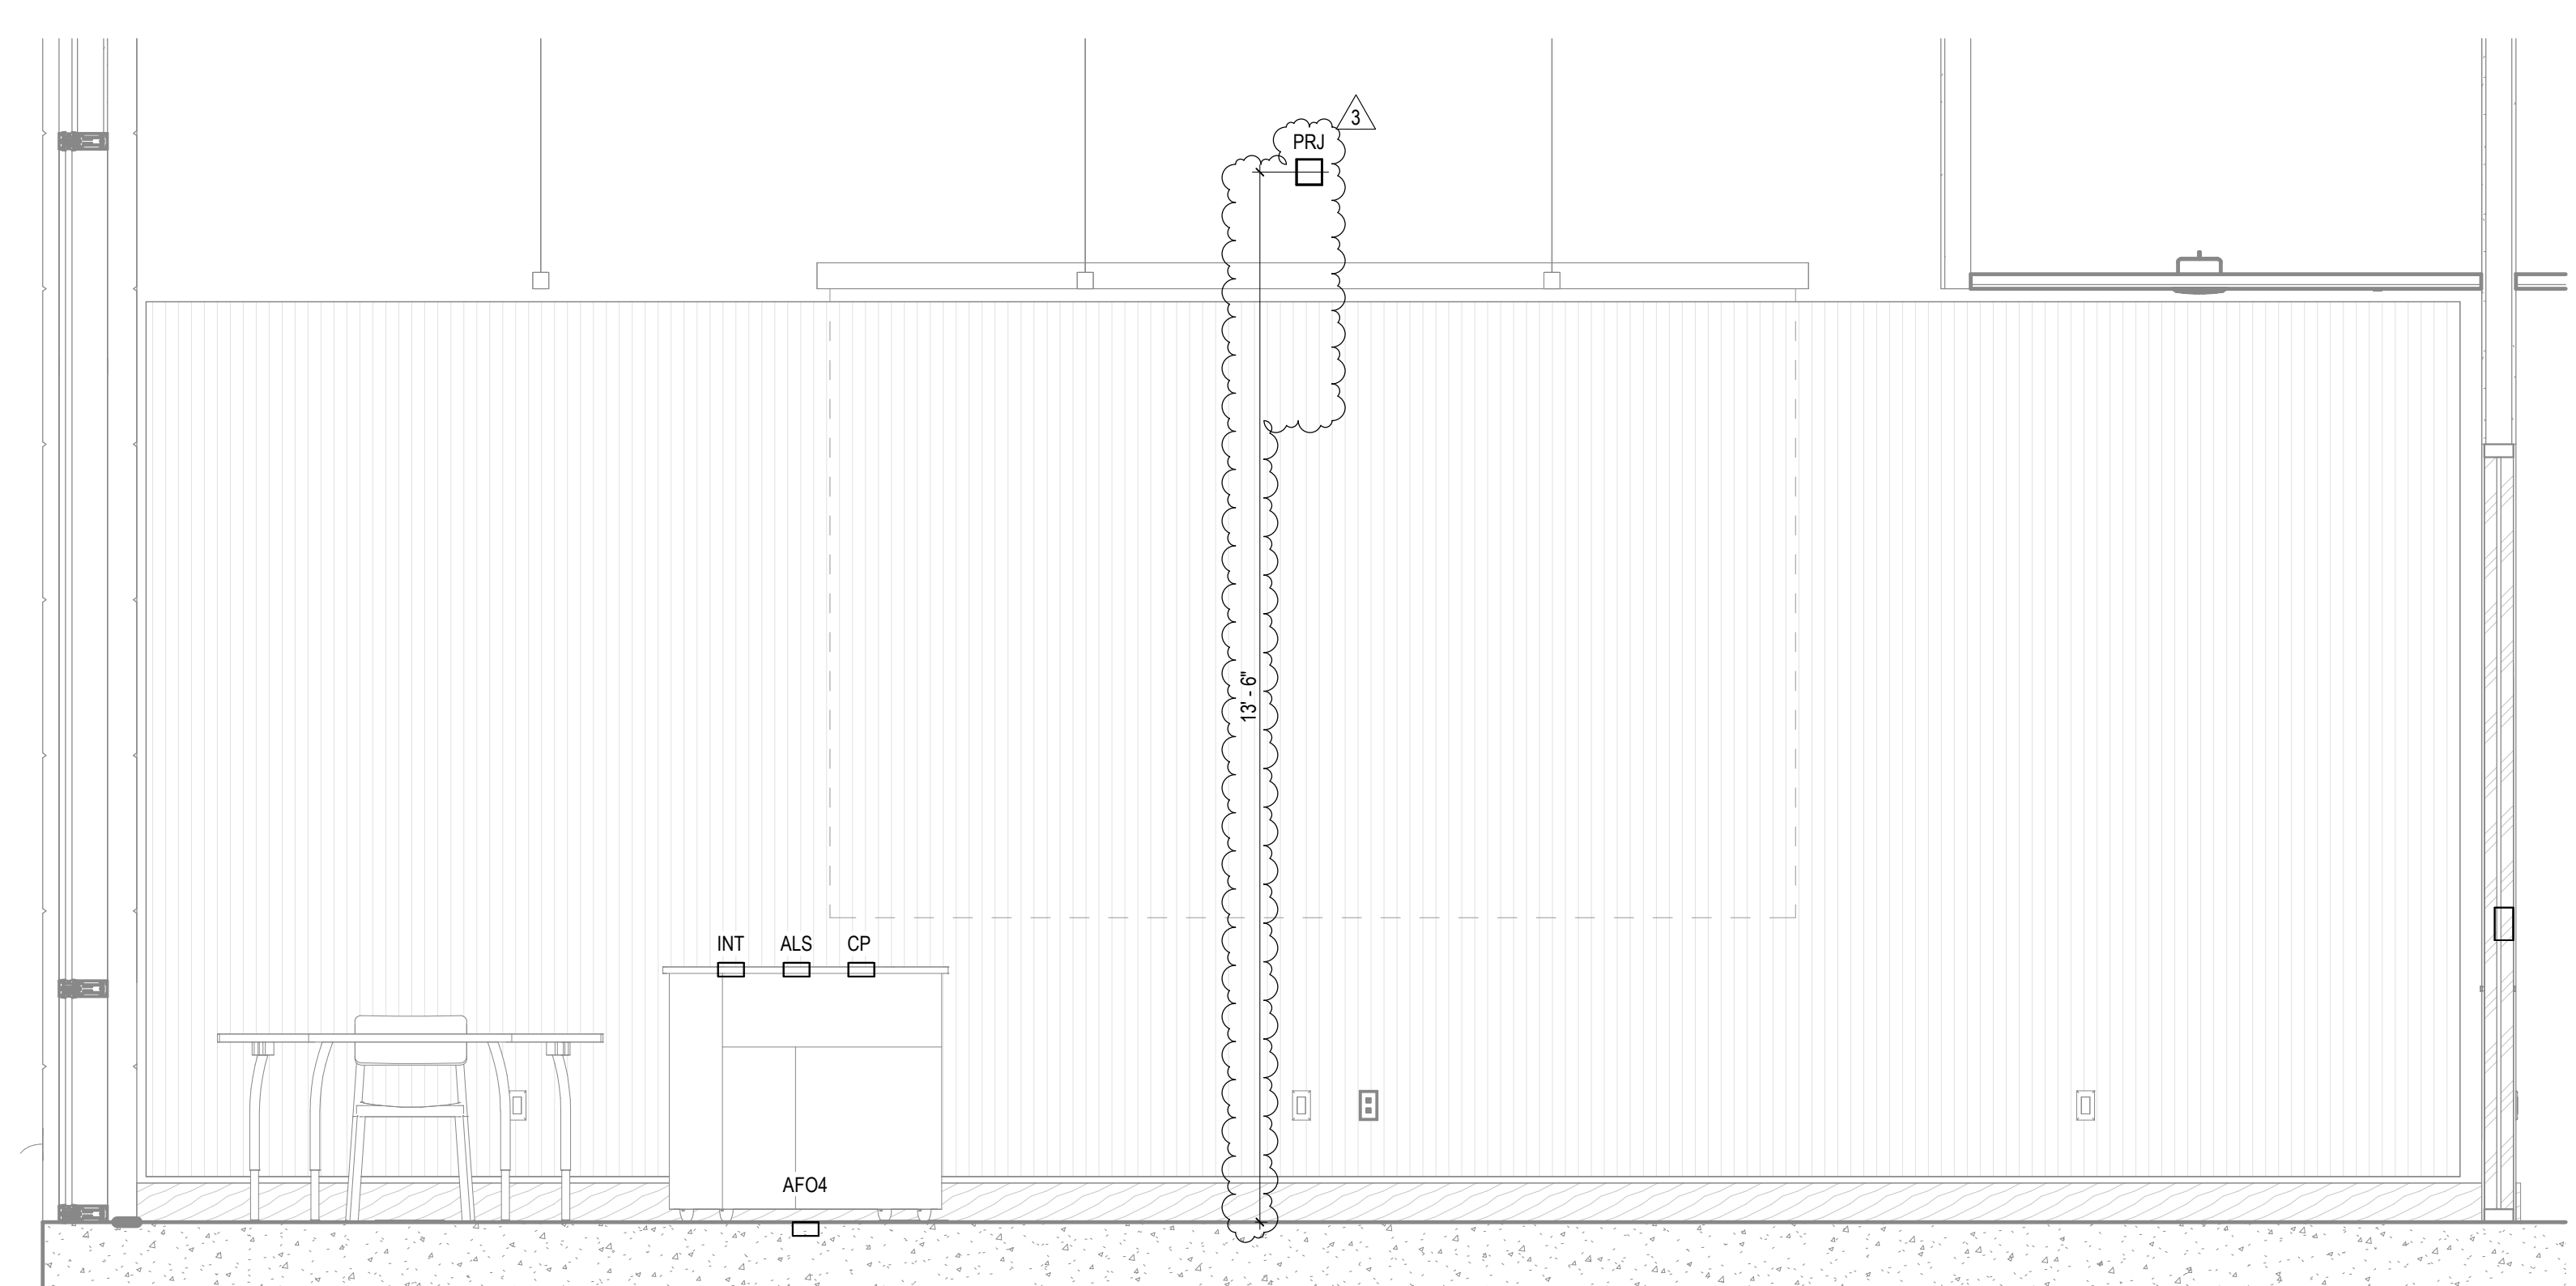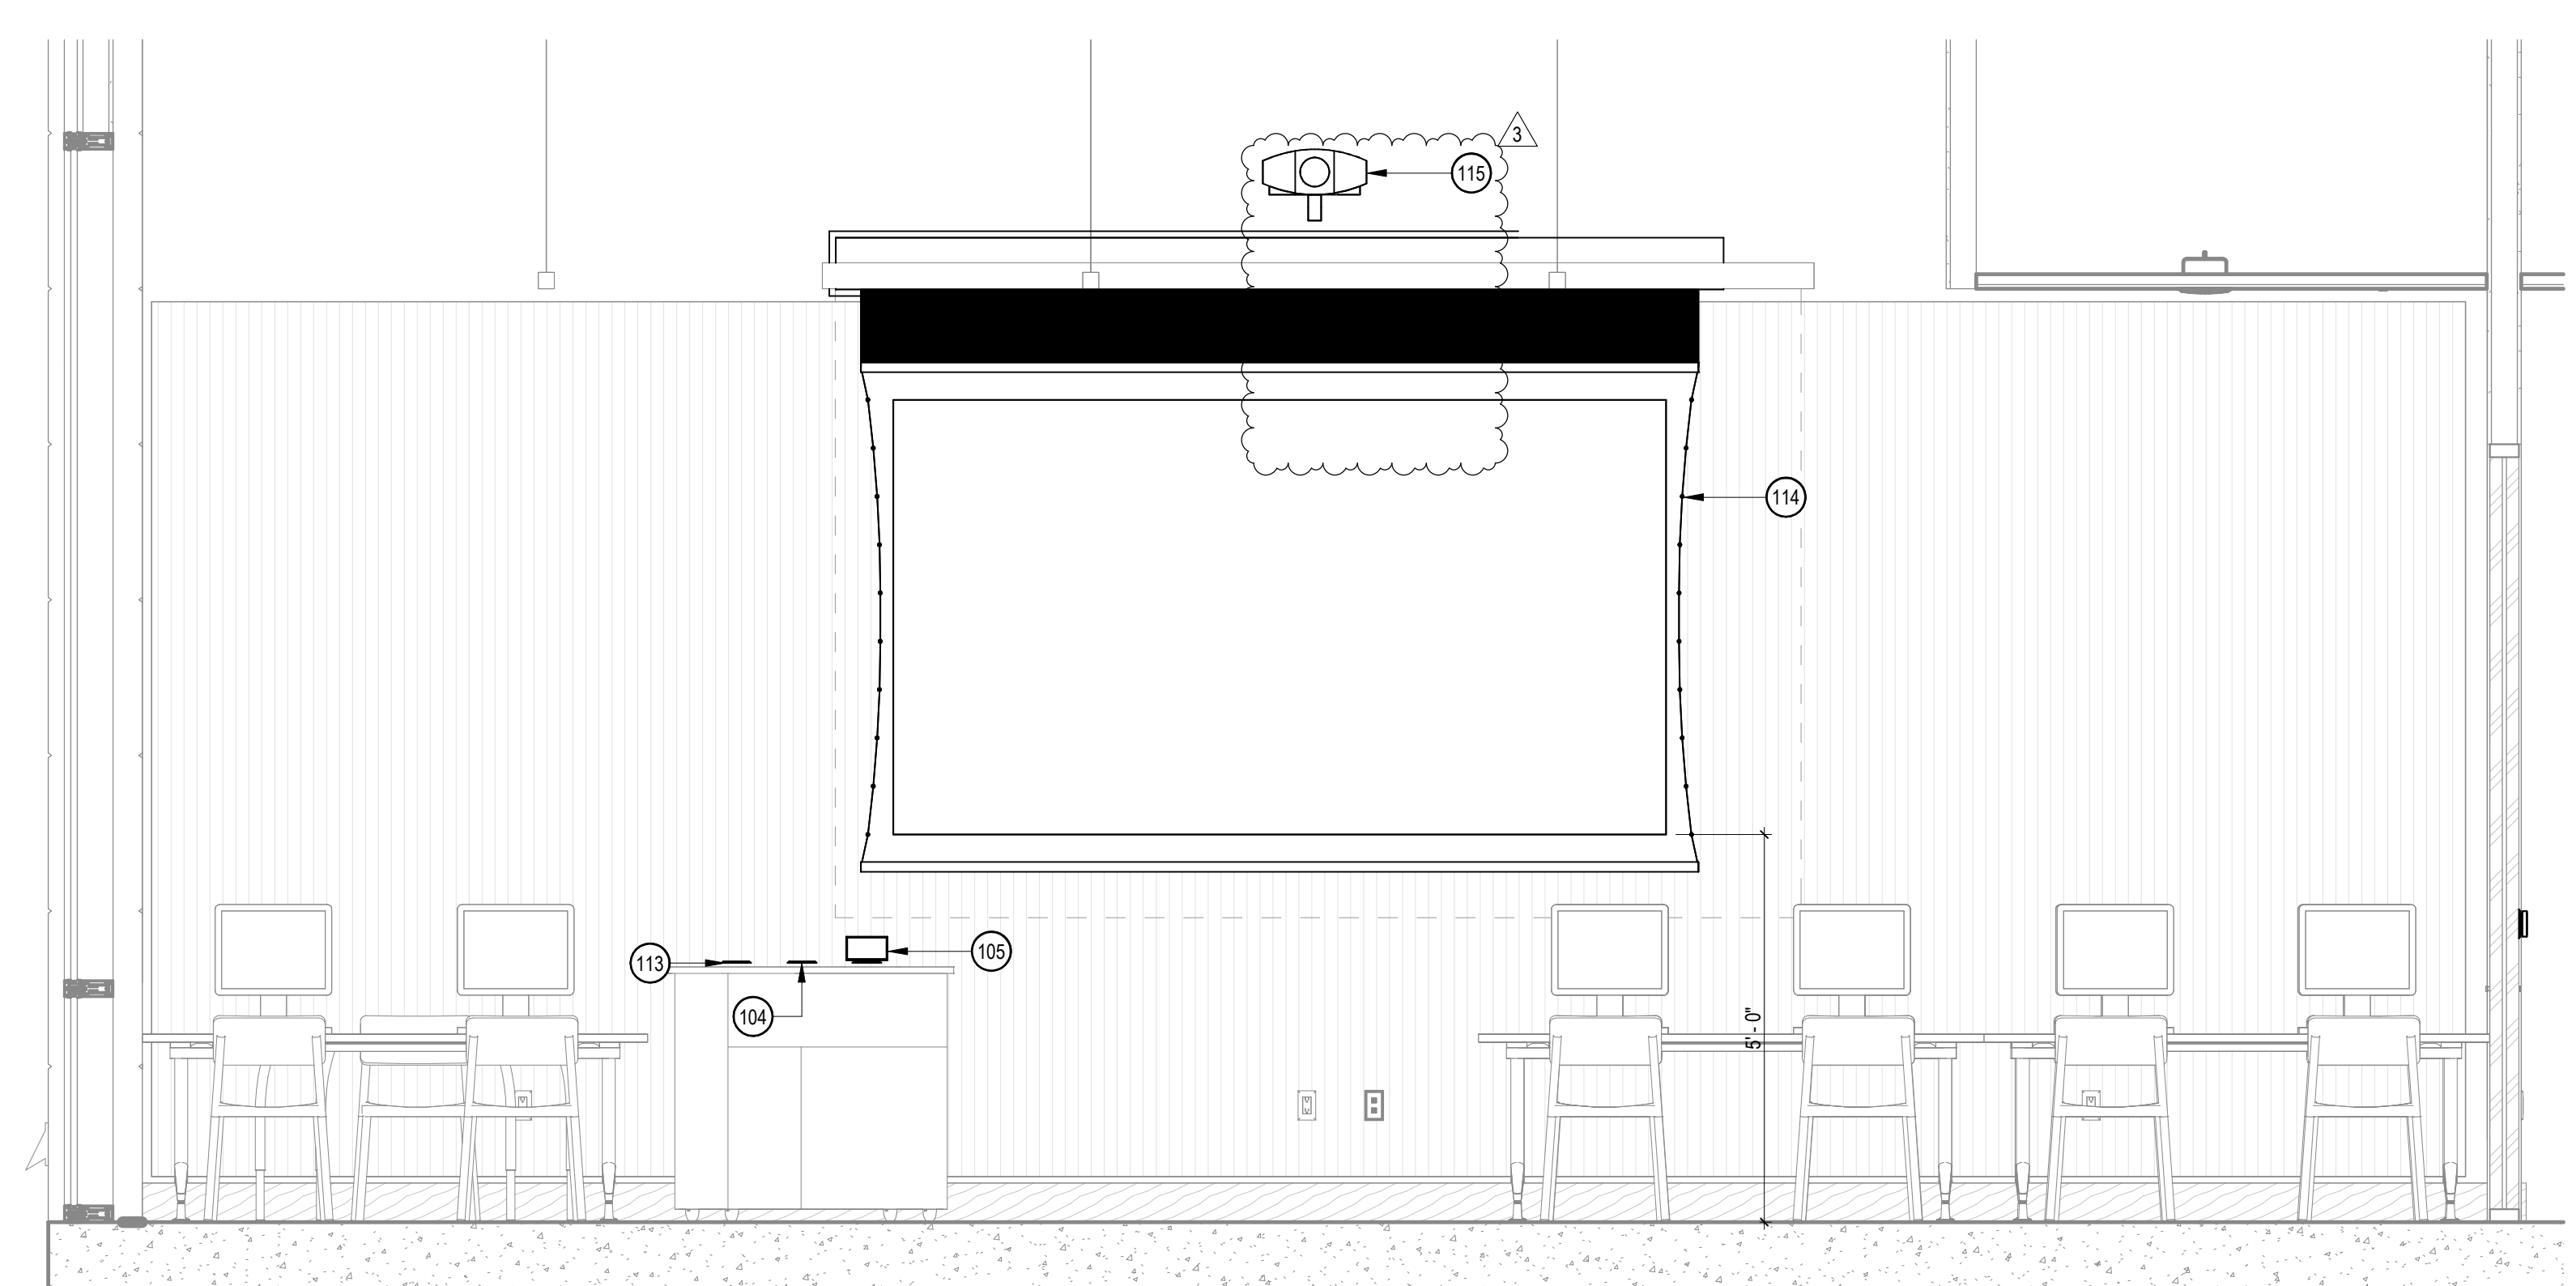

5 EQUIPMENT ELEVATION

4 INFRASTRUCTURE ELEVATION

PROJECT TITLE

**Peralta Community College District
Laney Library & Learning Resource Center
(Building 100 Replacement)**

900 Fallon Street, Oakland, CA 94607

ISSUE FOR BID

| | |
|-----------------|-----------------|
| ISSUE DATE | 03/31/2023 |
| NAT. JOB NUMBER | 21942 |
| REVISIONS | |
| DATE | DESCRIPTION |
| 3 05/16/2024 | Addendum No. 03 |

DRAWN BY: JA CHECKED BY: DM
SHEET TITLE
ENLARGED ROOM PLAN - CLASSROOM - TYPE 1

SHEET NUMBER

T5.16A