



NUMBERED SHEET NOTES

- FIRE PUMP FEEDERS TO BE INSTALLED UNDERGROUND TO MAINTAIN FIRE PROTECTION OF FEEDERS.
- PROVIDE AND INSTALL DISCONNECT SWITCH WITH AUXILIARY SWITCHES, ONE N.O. CONTACT AND ONE N.C. CONTACT. THE AUXILIARY SWITCHES ARE TO BE AVAILABLE FOR FIRE ALARM SYSTEM USE TO MONITOR SWITCH POSITION.

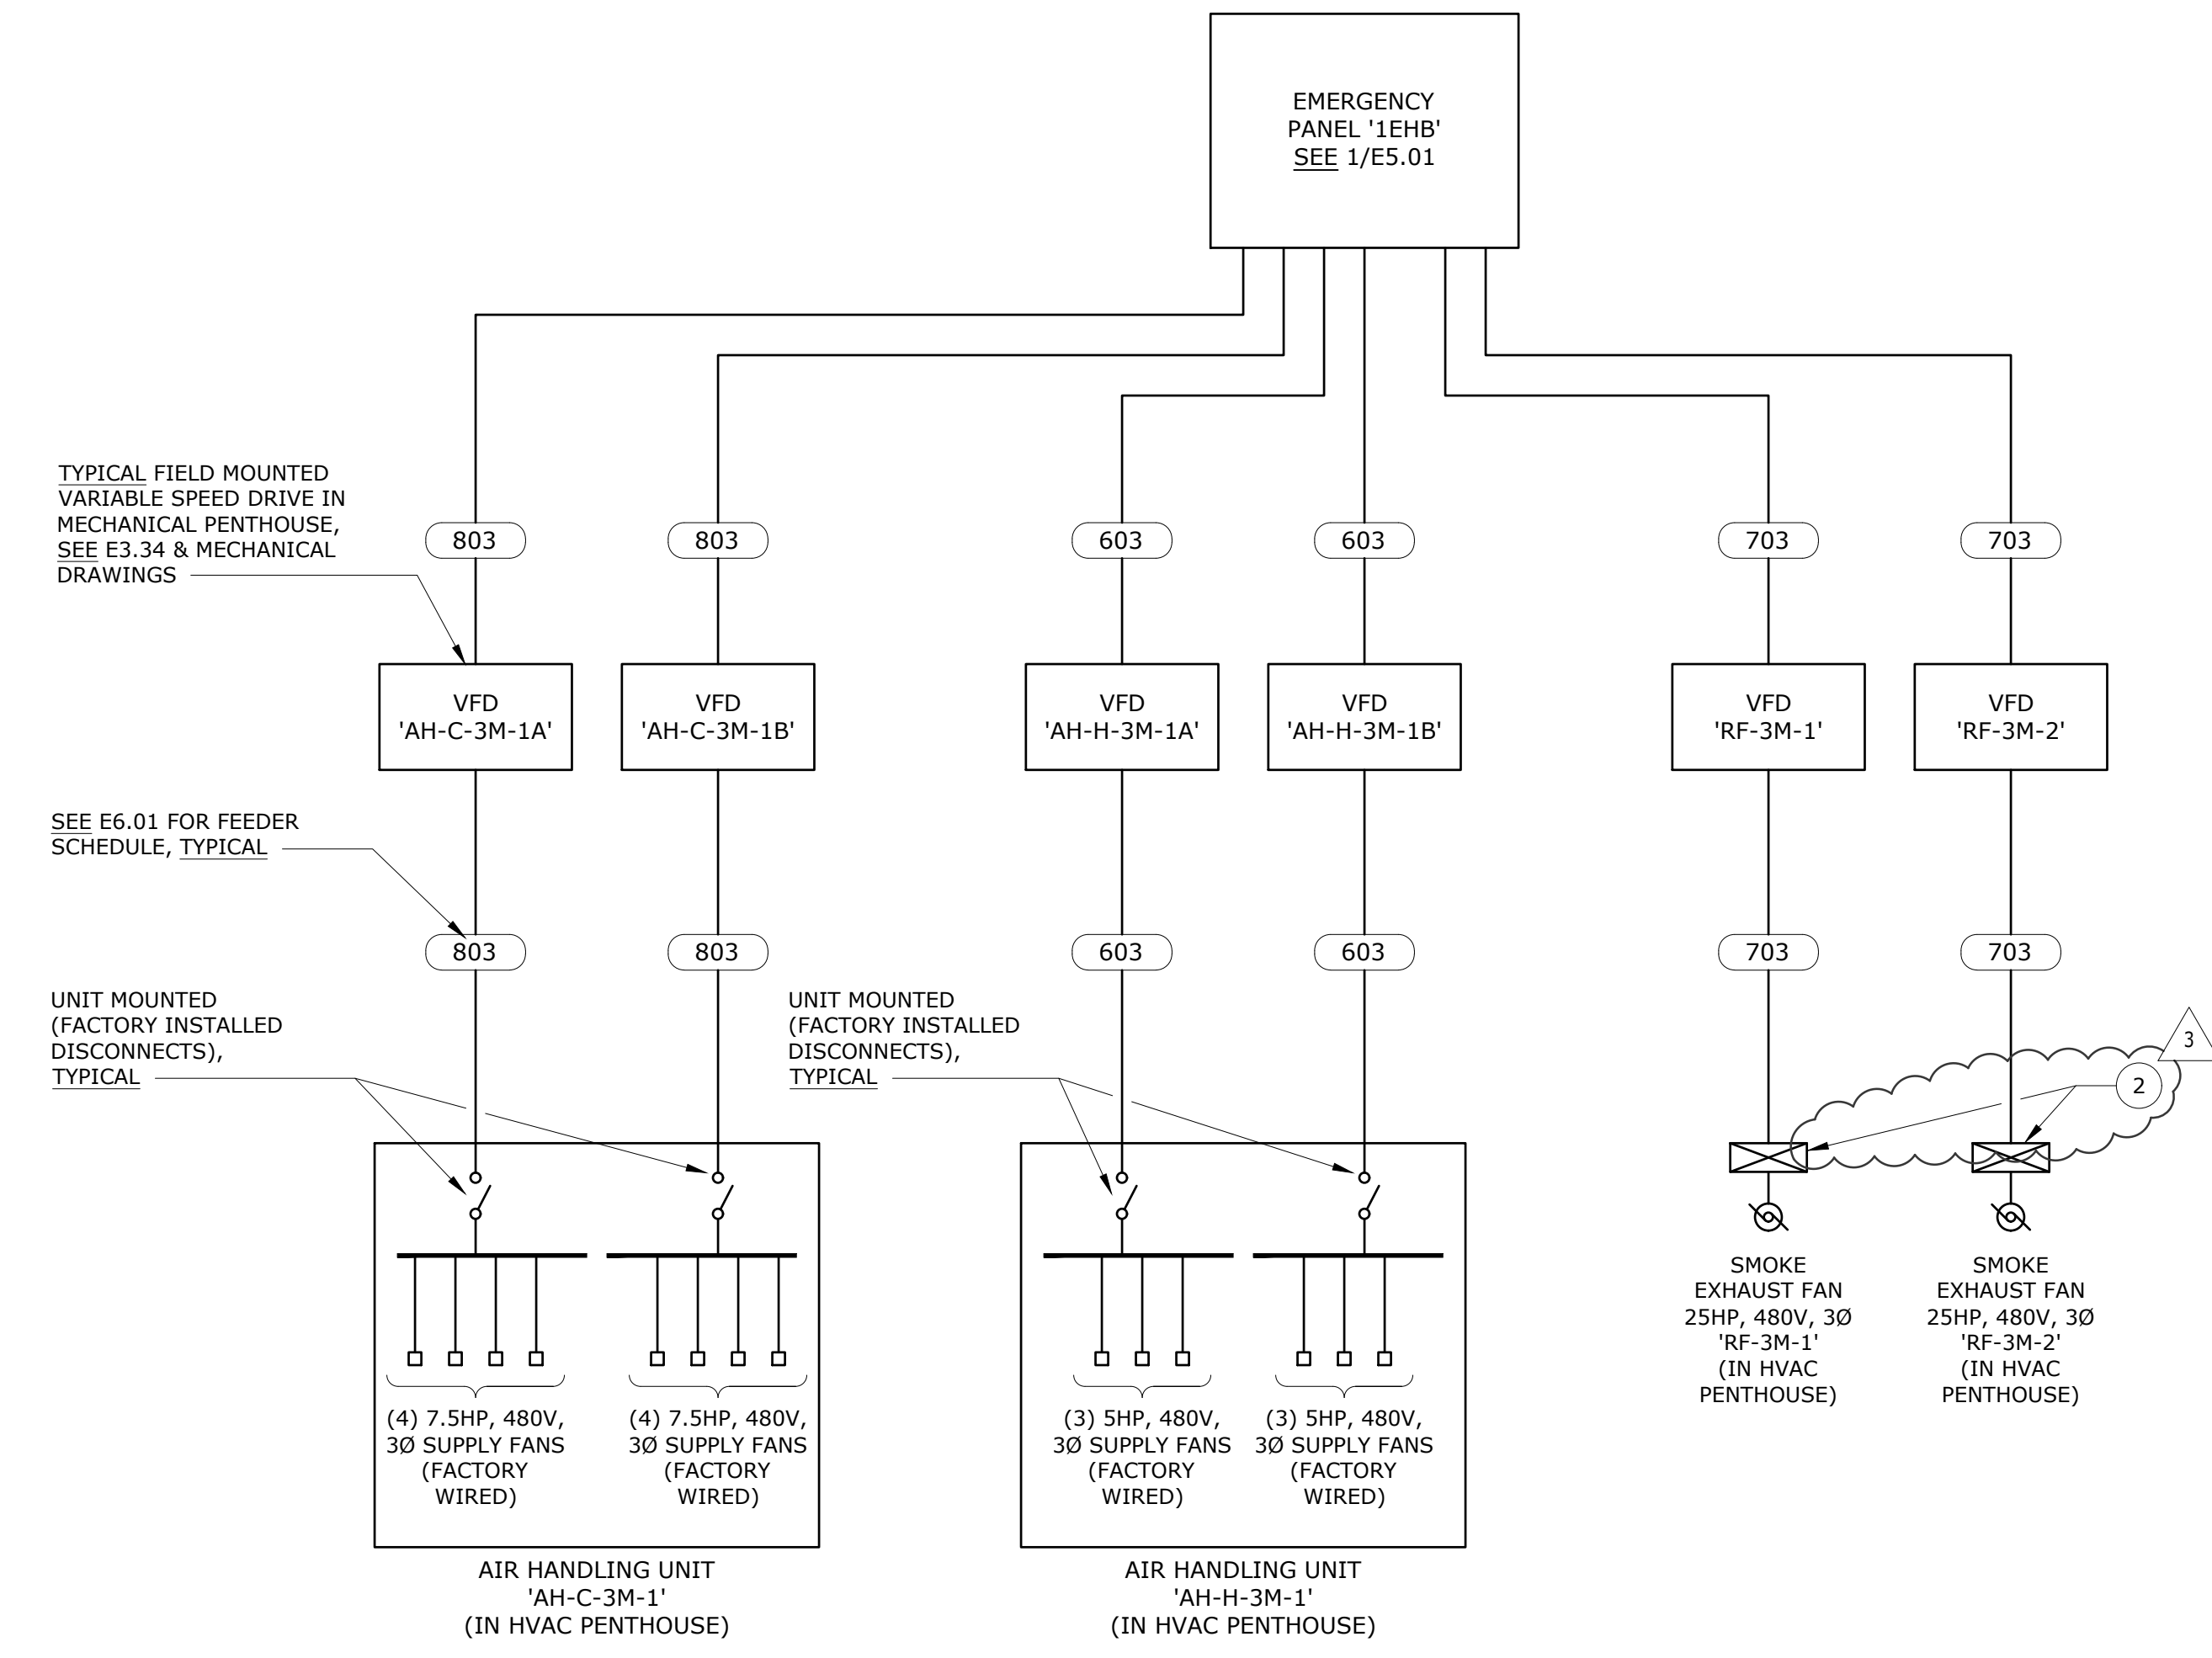

ATRIUM SMOKE FAN POWER DIAGRAM
SCALE: NONE

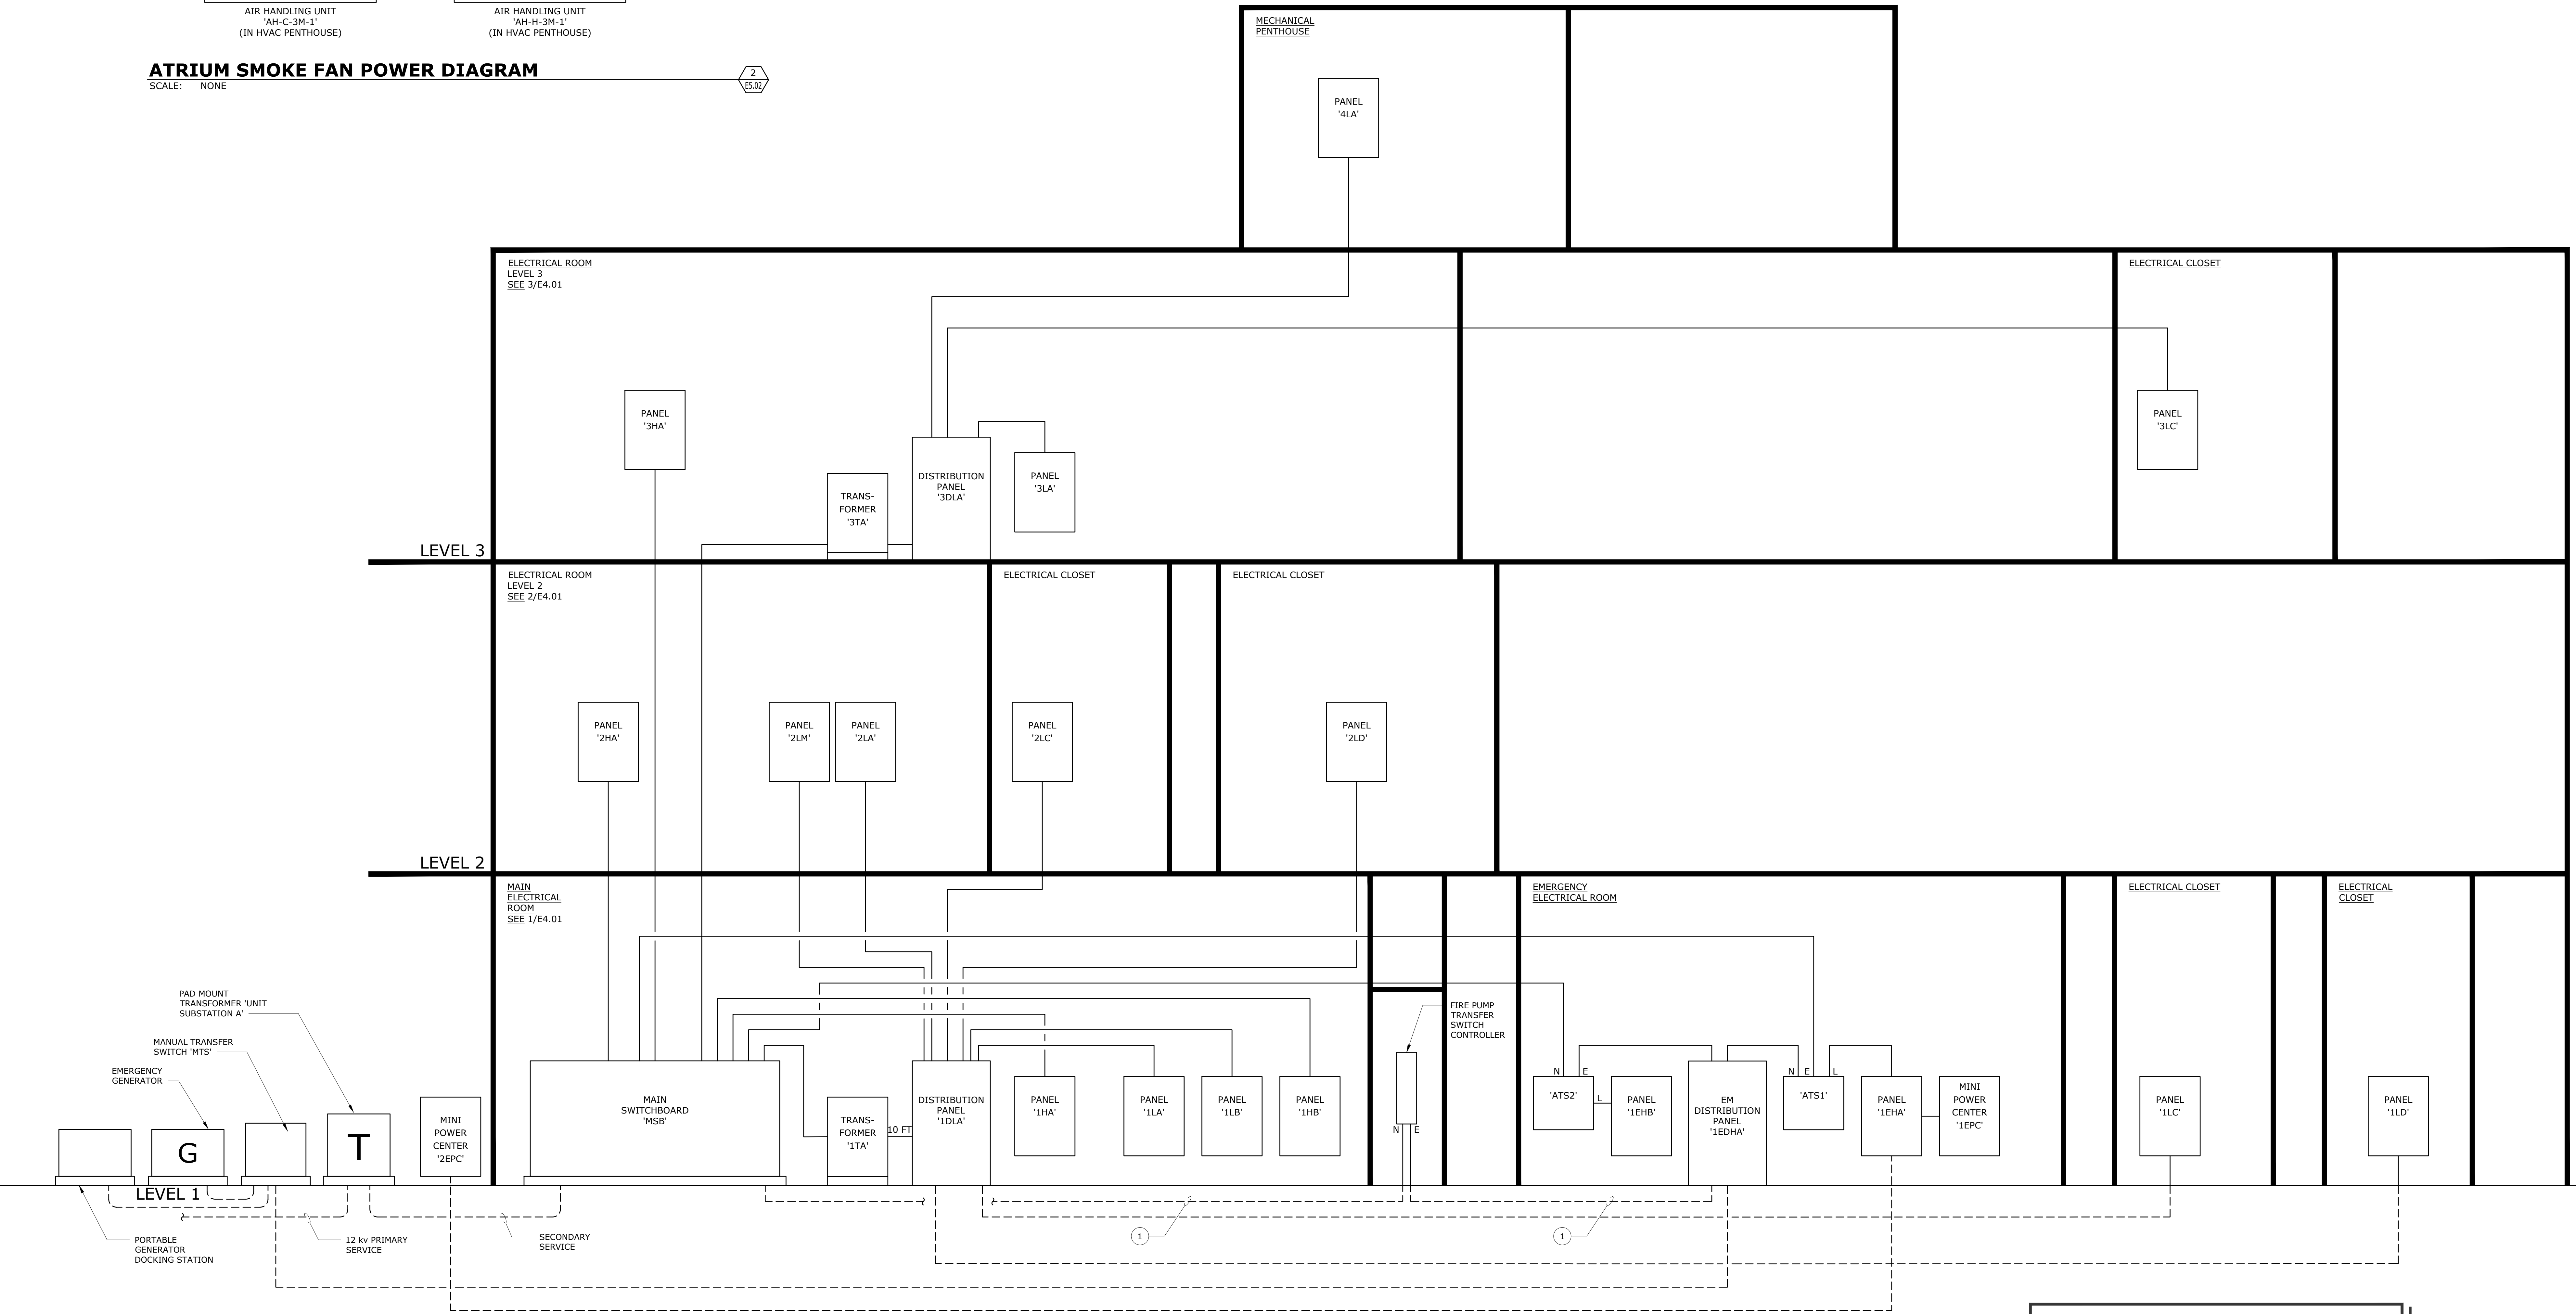

NOTES:

- SEE 1/E5.01 FOR SINGLE LINE DIAGRAM.
- ELECTRICAL ROOMS ARE NOT STACKED, SEE FLOOR PLANS FOR LOCATIONS

RISER DIAGRAM - POWER
SCALE: NONE

NOLL & TAM
ARCHITECTS
729 Heinz Avenue
Berkeley, CA 94710
tel 510.542.2200
fax 510.542.2201

CAVAGNERO
MARK CAVAGNERO ASSOCIATES ARCHITECTS
1000 Redwood Street, Suite 200
San Francisco, California 94111
tel 415.399.8943
www.cavagnero.com



OMAHONY & MYER
REGISTERED PROFESSIONAL ENGINEERS
4540 REDWOOD HWY, SUITE 245
SAN RAFAEL, CALIFORNIA 94903
(415) 492-0820/FAX (415) 479-9662
www.comaconline.com

PROJECT TITLE
**Peralta Community College District
Laney Library & Learning Resource Center (Building 100 Replacement)**
900 Fallon Street, Oakland, CA 94607

ISSUE FOR BID
ISSUE DATE 3/31/23
MAT JOB NUMBER 21942
REVISIONS
DATE DESCRIPTION
05/16/2024 ADDENDUM NO. 03

DRAWN BY SHEET TITLE
CHECKED BY
DIAGRAMS