

**SHEET NOTES**




1. REFER TO ARCHITECTURAL PLANS FOR EXACT LOCATIONS OF OUTLETS, DEVICES, AND EQUIPMENT. ALSO REFER TO ELECTRICAL PLANS TO COORDINATE FINAL LOCATIONS OF OUTLETS, DEVICES, AND EQUIPMENT.
2. REFER TO OVERALL PLANS FOR TELECOM DEVICES SERVING LOCATIONS.
3. REFER TO SHEET T5.02 FOR PATHWAY REQUIREMENTS.
4. REFER TO ARCHITECTURAL DRAWINGS FOR THE FURNITURE LOCATION.
5. REFER TO OVERALL PLANS FOR PROJECTION SCREEN LOCATIONS. CENTER PROJECTOR TO PROJECTOR SCREEN LATERALLY.
6. SEE INSTALLATION DETAIL IN THIS SET.

**NUMBERED NOTES**

- 01 REFER TO OVERALL PLAN FOR MULTI SERVICE FLOOR BOX AND POKE-THROUGH
- 02 THIS FLOOR BOX ONLY APPLIES TO ROOM NUMBER 100
- 03 THIS FLOOR BOX ONLY APPLIES TO ROOM NUMBER 120

**AV EQUIPMENT LIST**



ID	DESCRIPTION
104	ASSISTIVE LISTENING PLATE
105	CONTROL PANEL
106	ROOM SCHEDULER
113	INTERFACE PLATE
114	WALL MOUNTED PROJECTION SCREEN
115	PROJECTOR

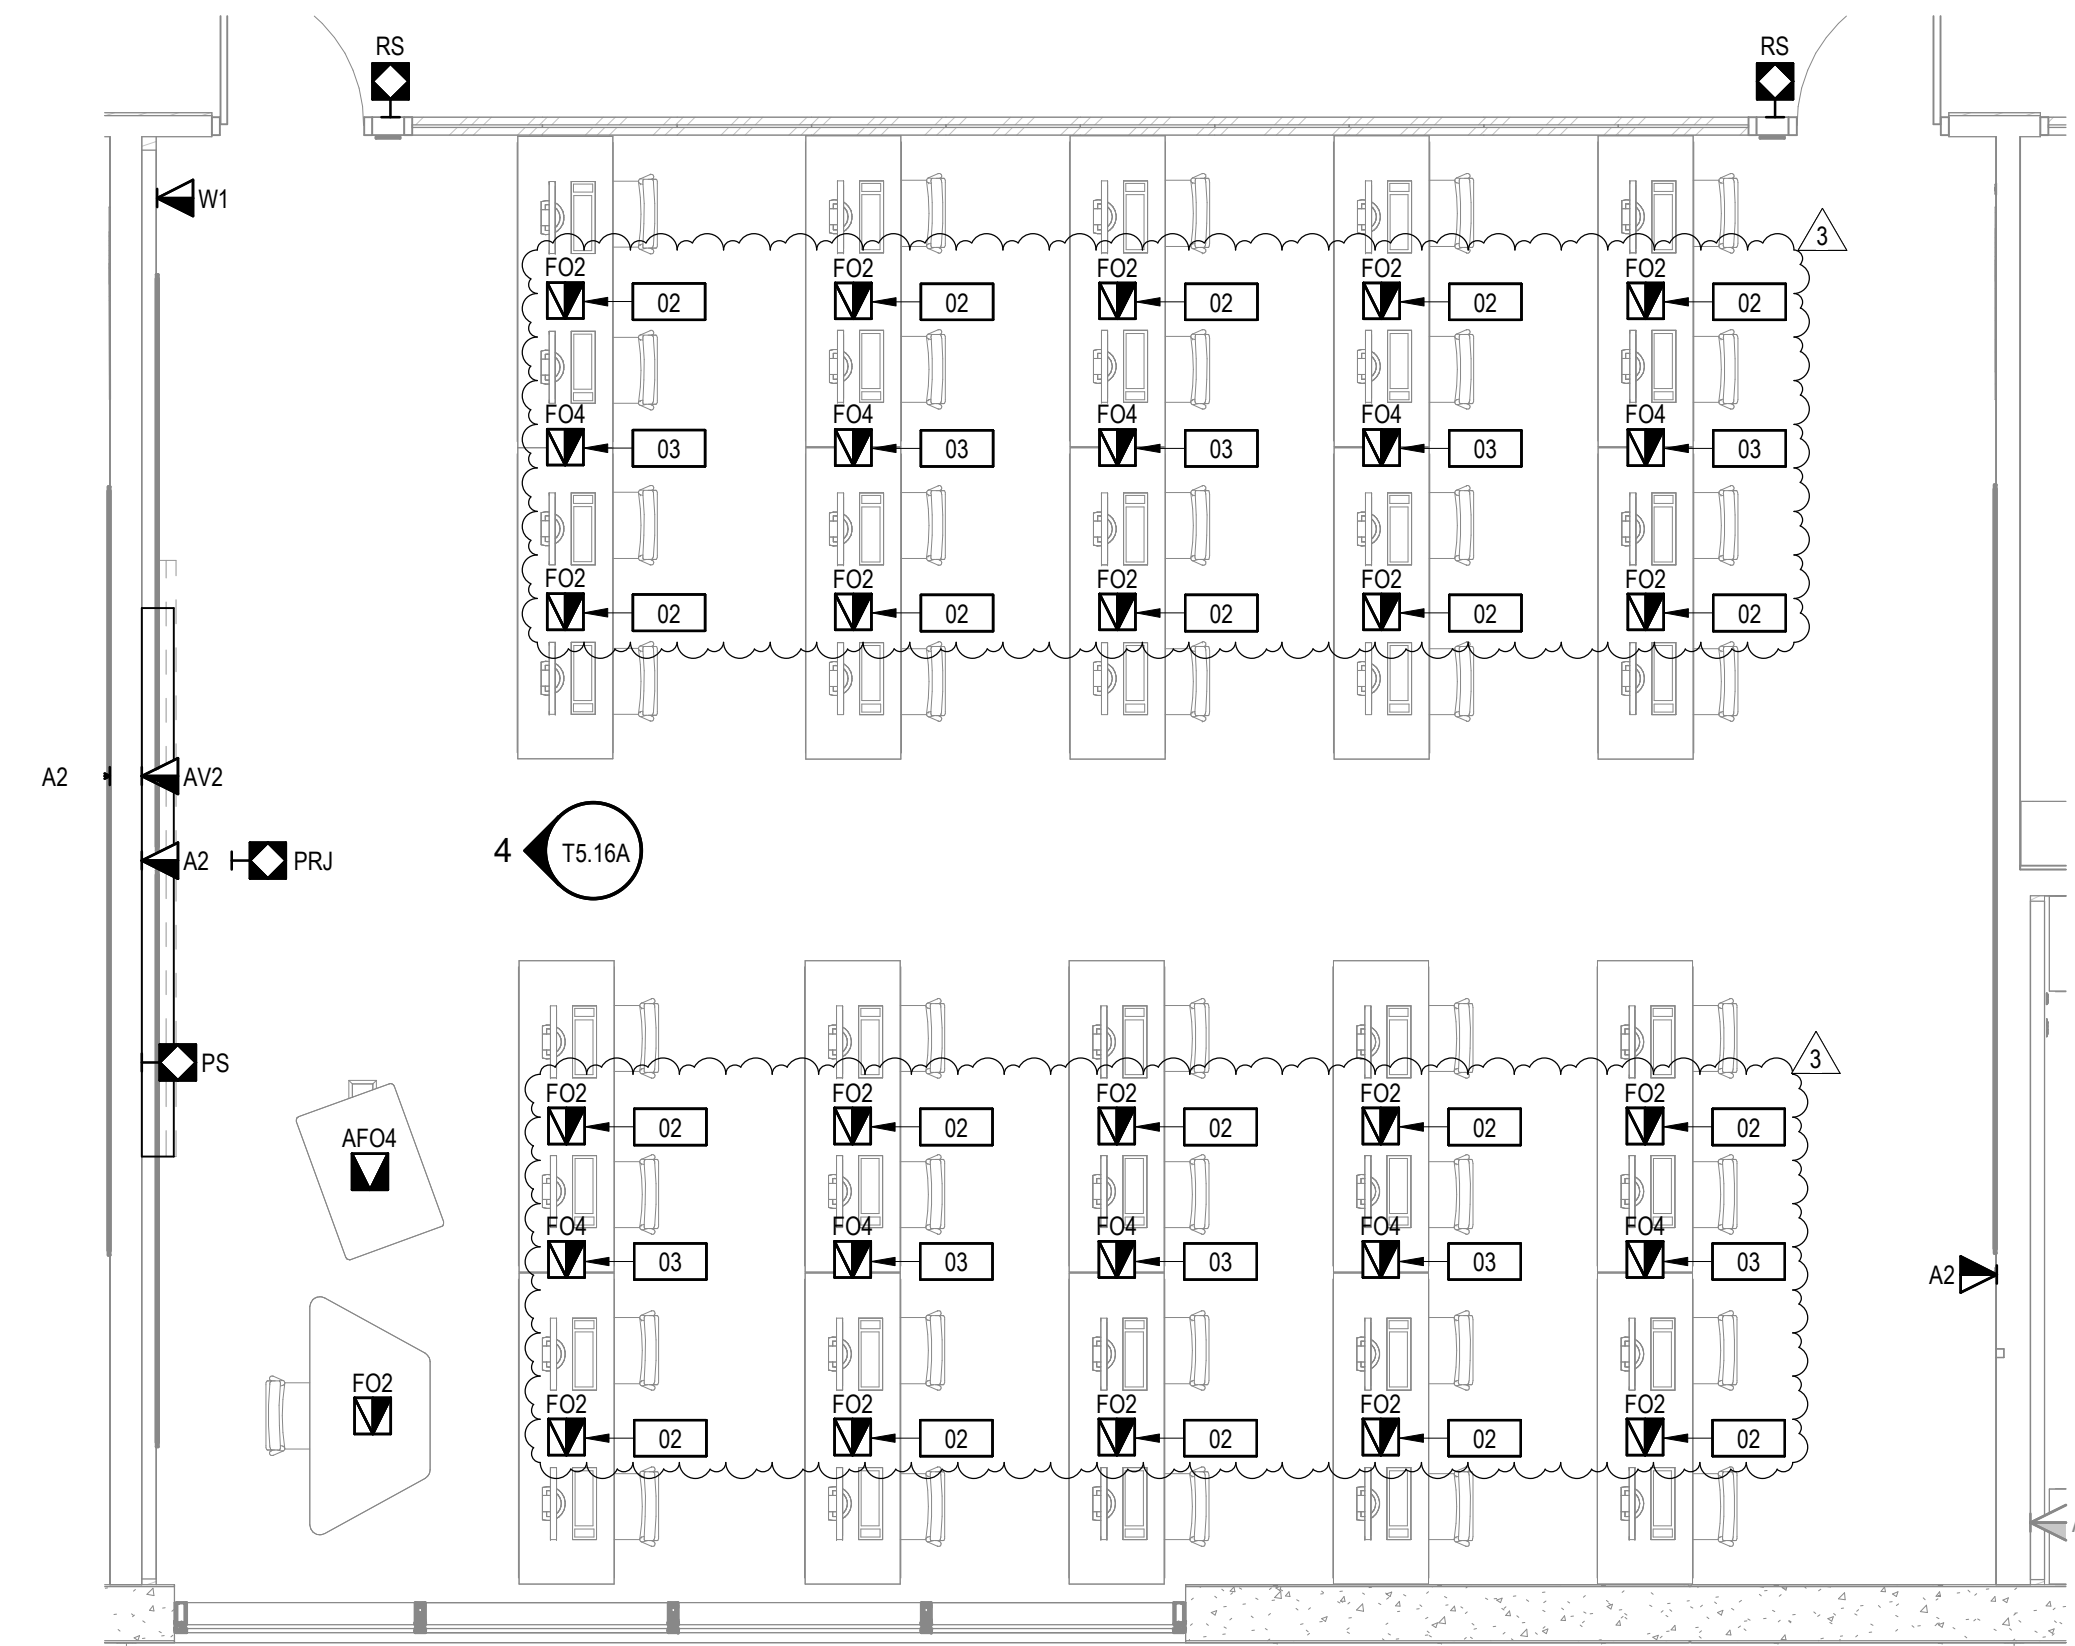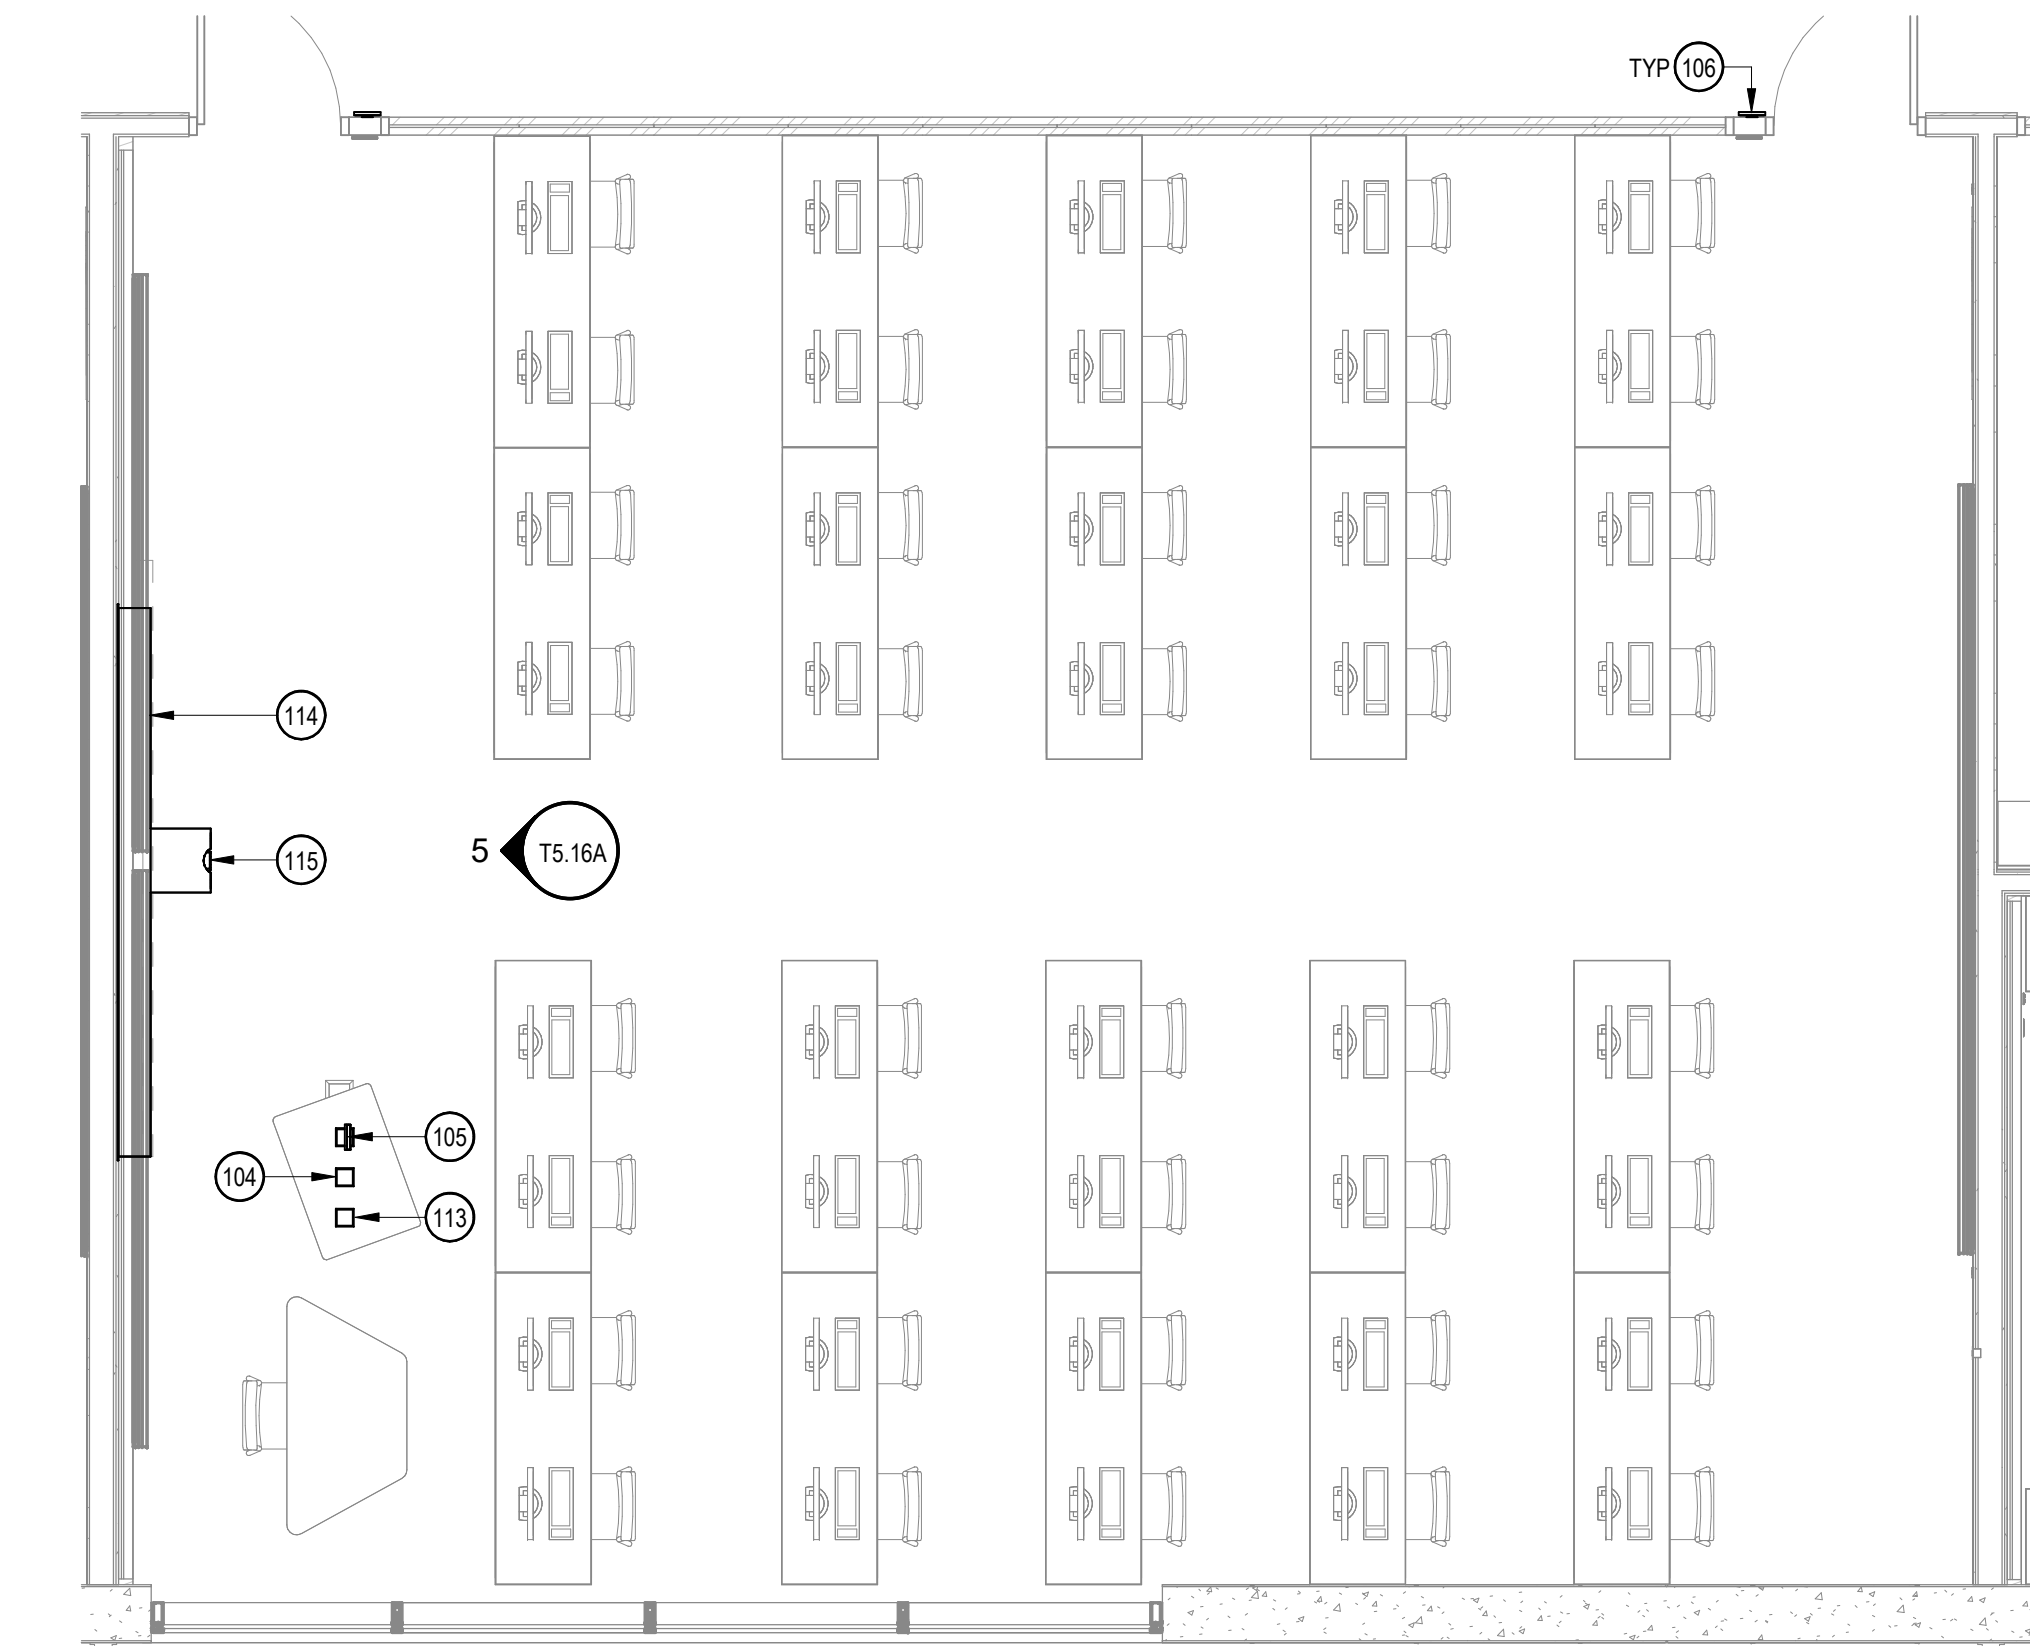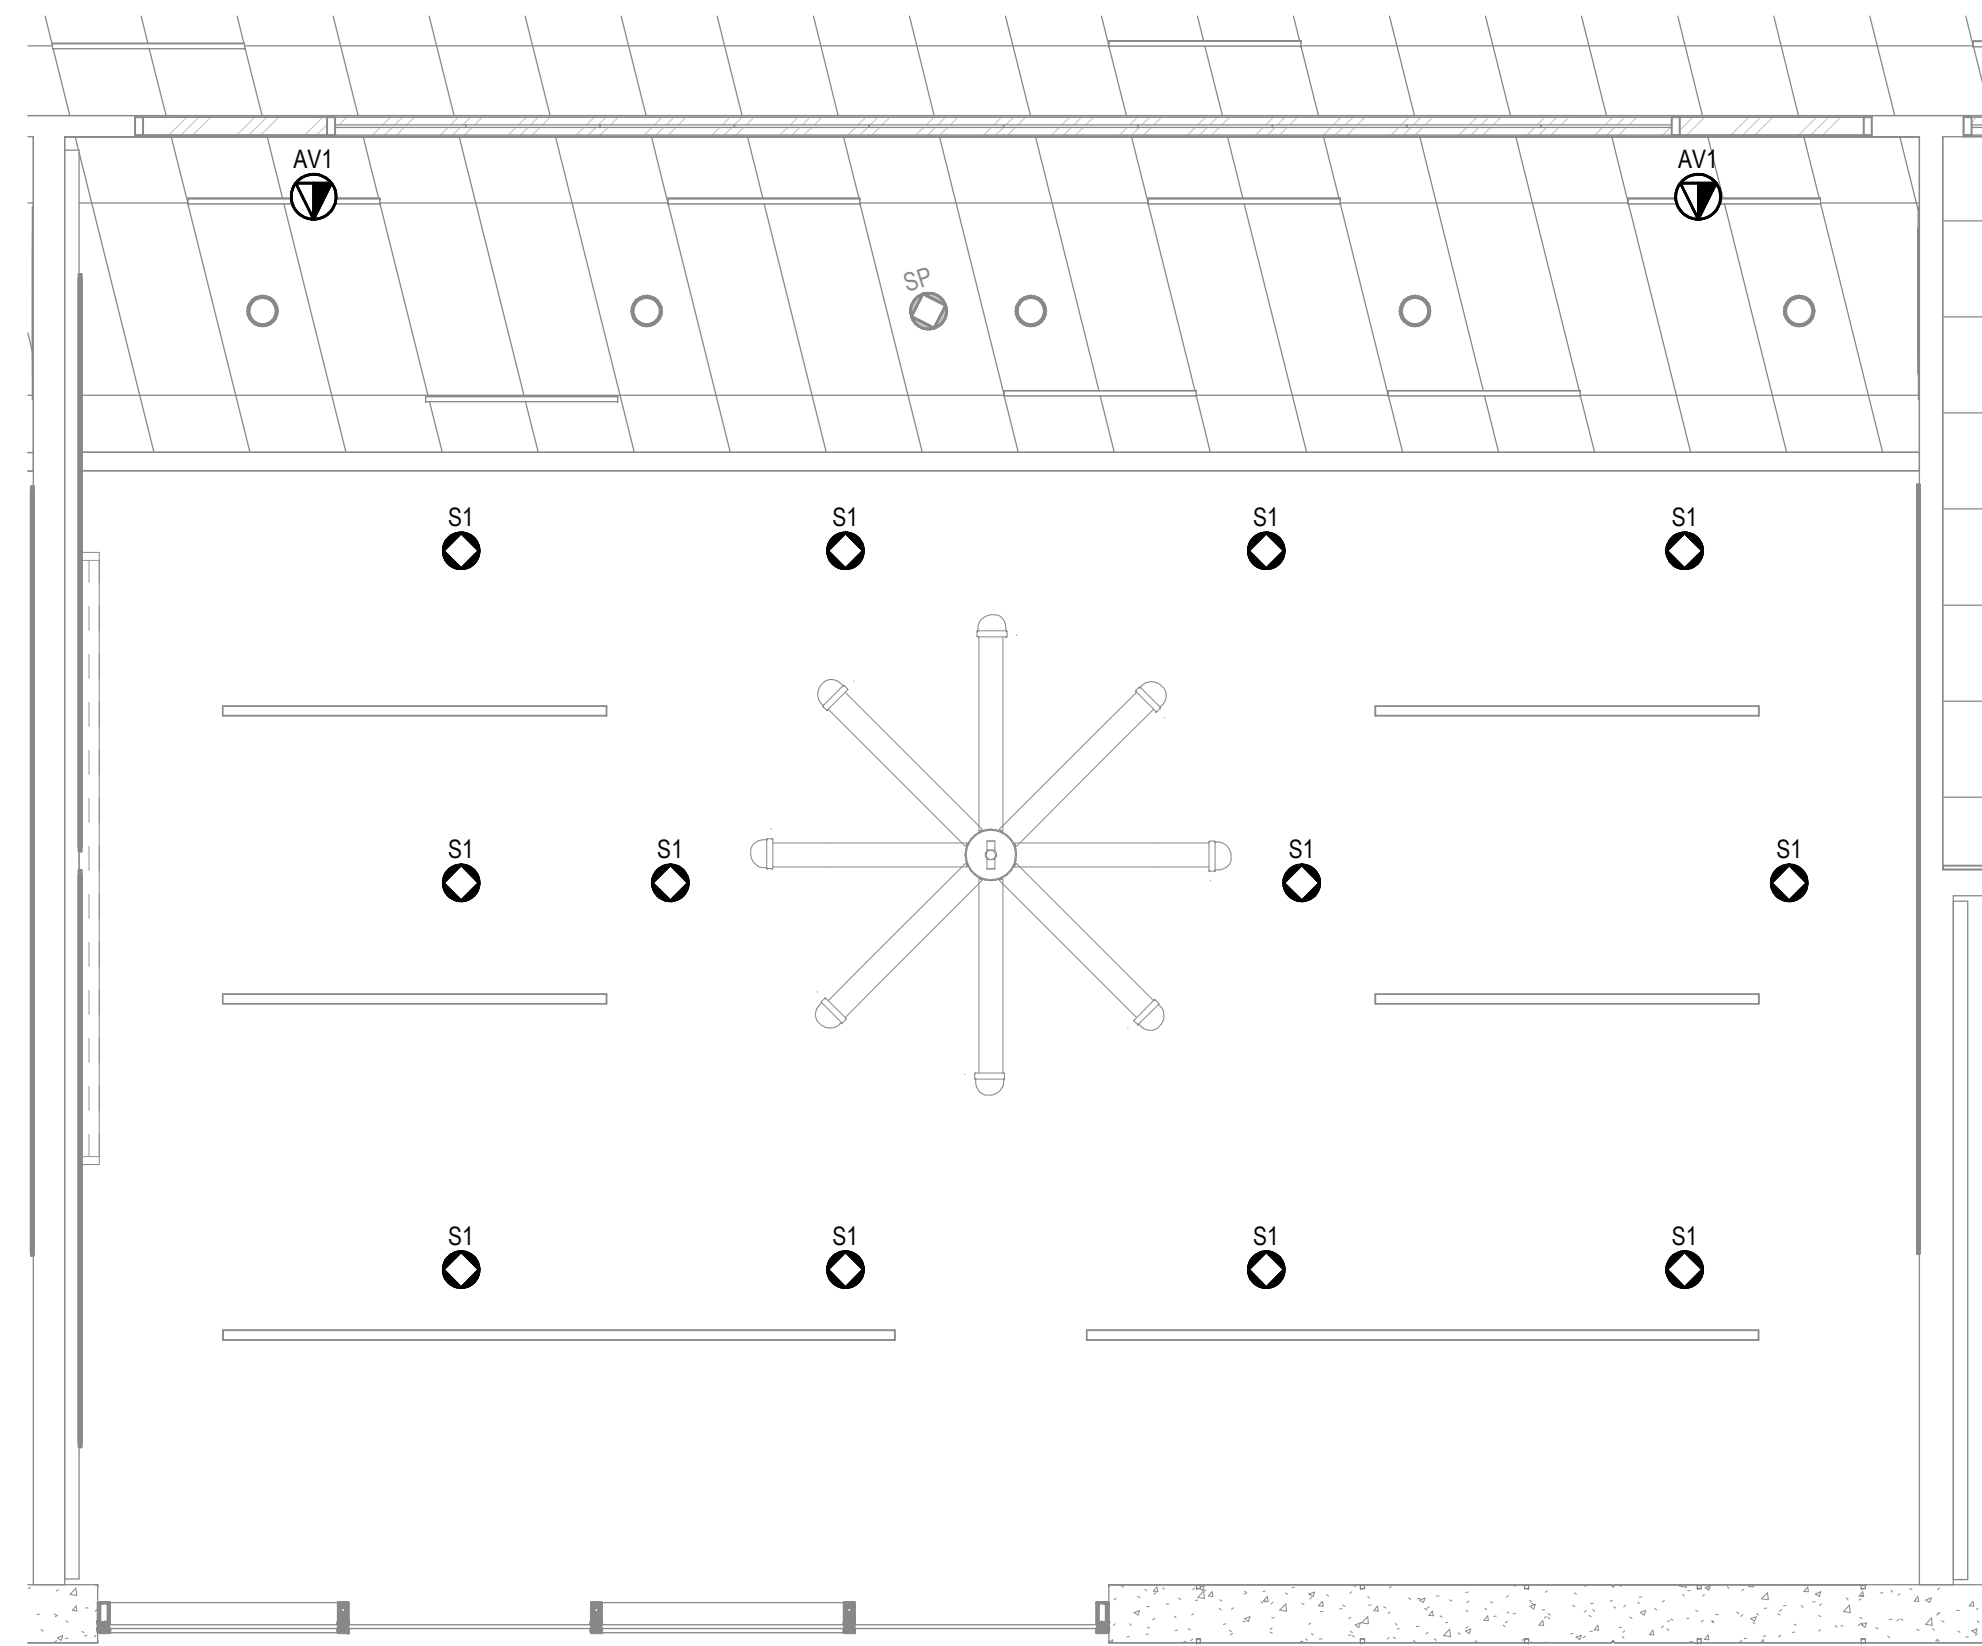

3 REFLECTED CEILING PLAN  
SCALE: 1/4" = 1'-0"

2 EQUIPMENT PLAN  
SCALE: 1/4" = 1'-0"

1 INFRASTRUCTURE PLAN  
SCALE: 1/4" = 1'-0"

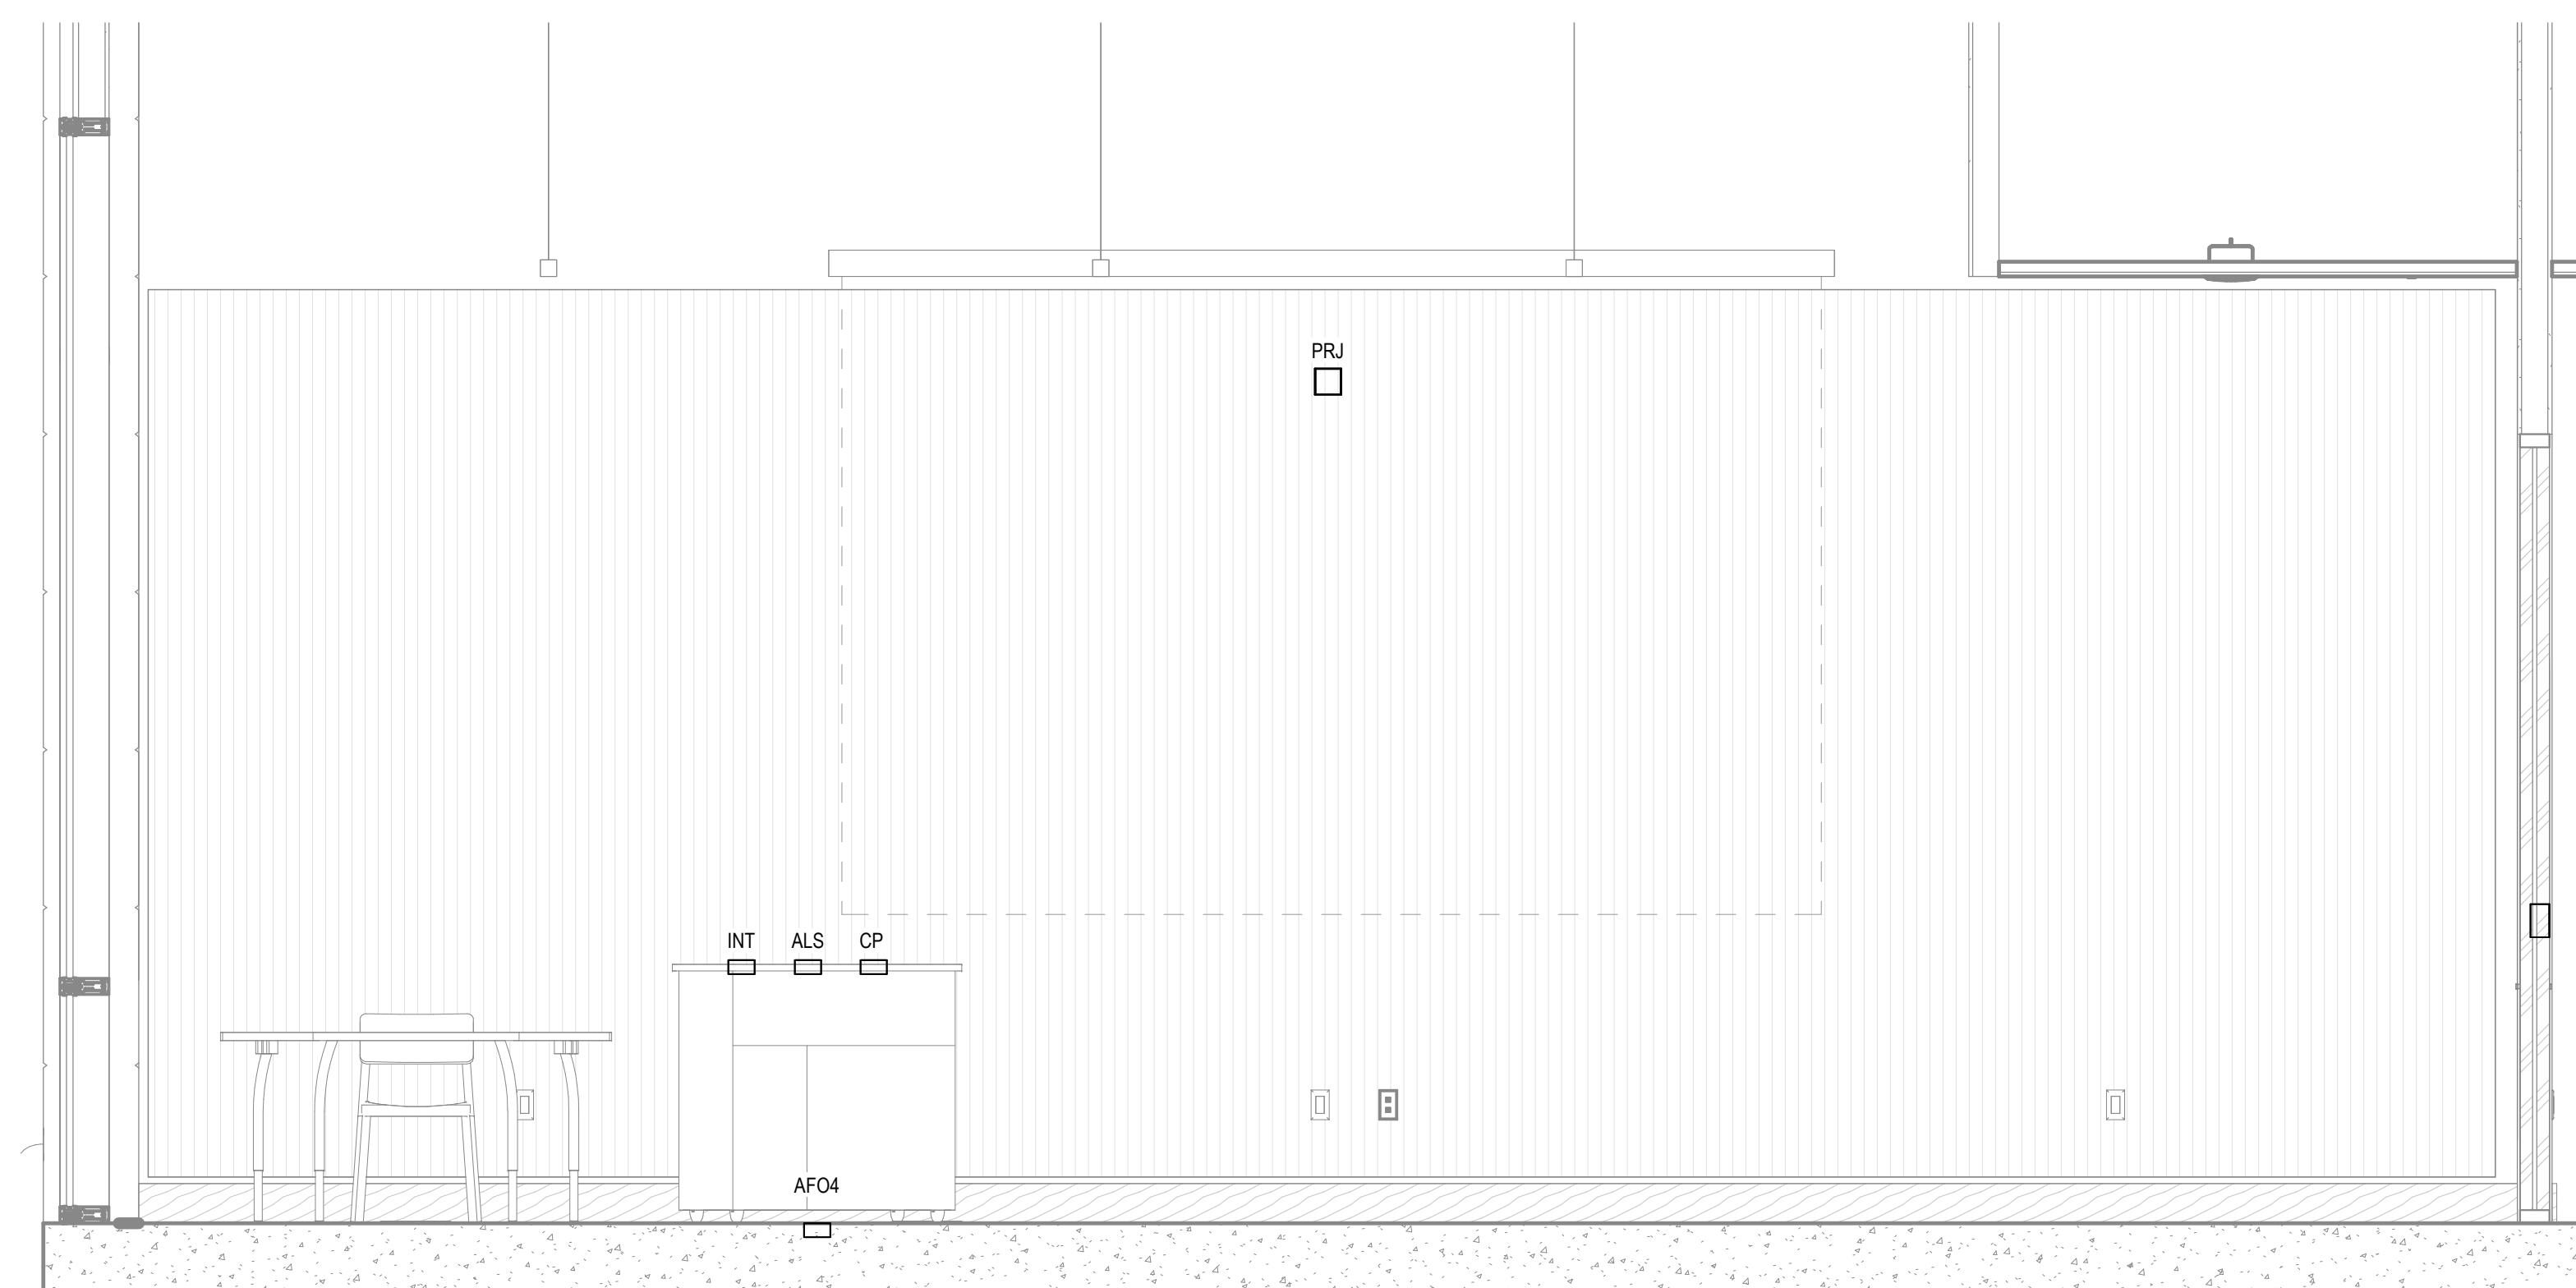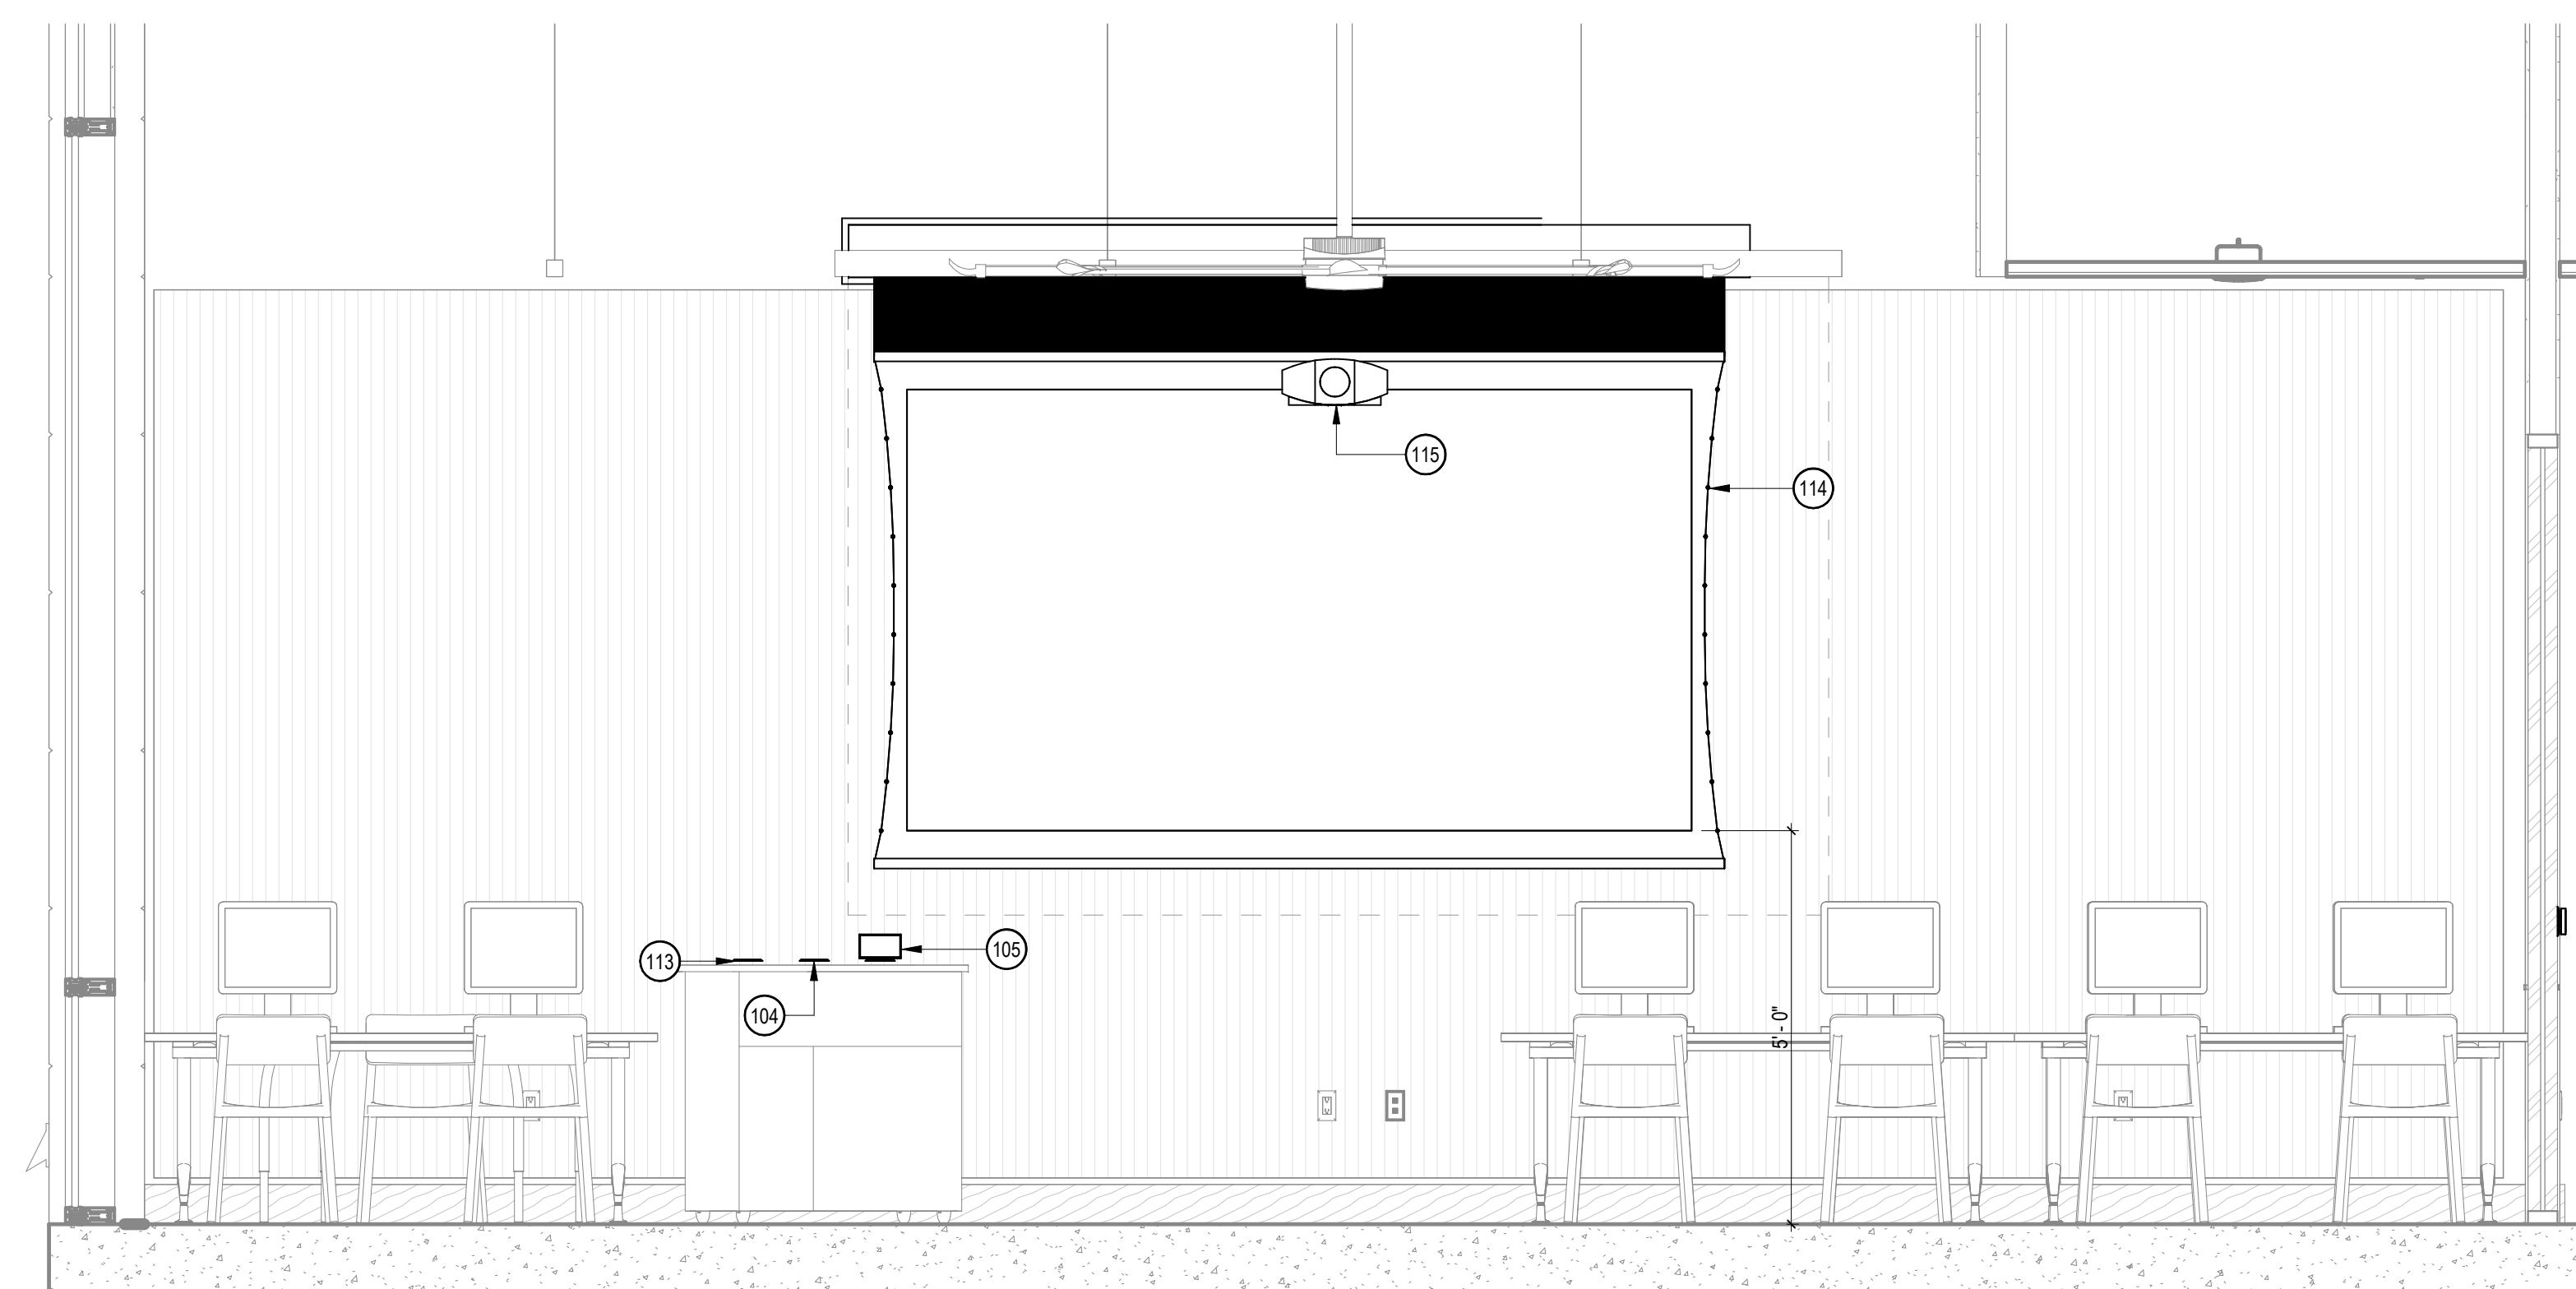

5 EQUIPMENT ELEVATION  
SCALE: 1/2" = 1'-0"

4 INFRASTRUCTURE ELEVATION  
SCALE: 1/2" = 1'-0"

PROJECT TITLE

**Peralta Community College District  
Laney Library & Learning Resource Center  
(Building 100 Replacement)**

900 Fallon Street, Oakland, CA 94607

ISSUE FOR BID

ISSUE DATE	03/31/2023
NAT. JOB NUMBER	21942
REVISIONS	
DATE	DESCRIPTION
3 05/16/2024	Addendum No. 03

DRAWN BY: JA CHECKED BY: DM  
SHEET TITLE:  
**ENLARGED ROOM PLAN - CLASSROOM - TYPE 1**

SHEET NUMBER  
**T5.16A**