





SHEET NOTES

1. REFER TO ARCHITECTURAL PLANS FOR EXACT LOCATIONS OF OUTLETS, DEVICES, AND EQUIPMENT. ALSO REFER TO ELECTRICAL PLANS TO COORDINATE FINAL LOCATIONS OF OUTLETS, DEVICES, AND EQUIPMENT.
2. REFER TO OVERALL PLANS FOR TELECOM DEVICES SERVING LOCATIONS.
3. REFER TO SHEET T02 FOR PATHWAY REQUIREMENTS.
4. ALIGN CENTER OF DISPLAY TO CENTERLINE OF FURNITURE. REFER TO ARCHITECTURAL DRAWINGS FOR THE FURNITURE LOCATION.
5. REFER TO OVERALL PLANS FOR PROJECTION SCREEN LOCATIONS. CENTER PROJECTOR TO PROJECTOR SCREEN LATERALLY.
6. SEE INSTALLATION DETAIL IN THIS SET.

AV EQUIPMENT LIST

ID	DESCRIPTION
101	WALL MOUNTED DISPLAY
104	ASSISTIVE LISTENING PLATE
105	CONTROL PANEL
108	ROOM SCHEDULER
113	INTERFACE PLATE



FUNCTIONAL LEGEND

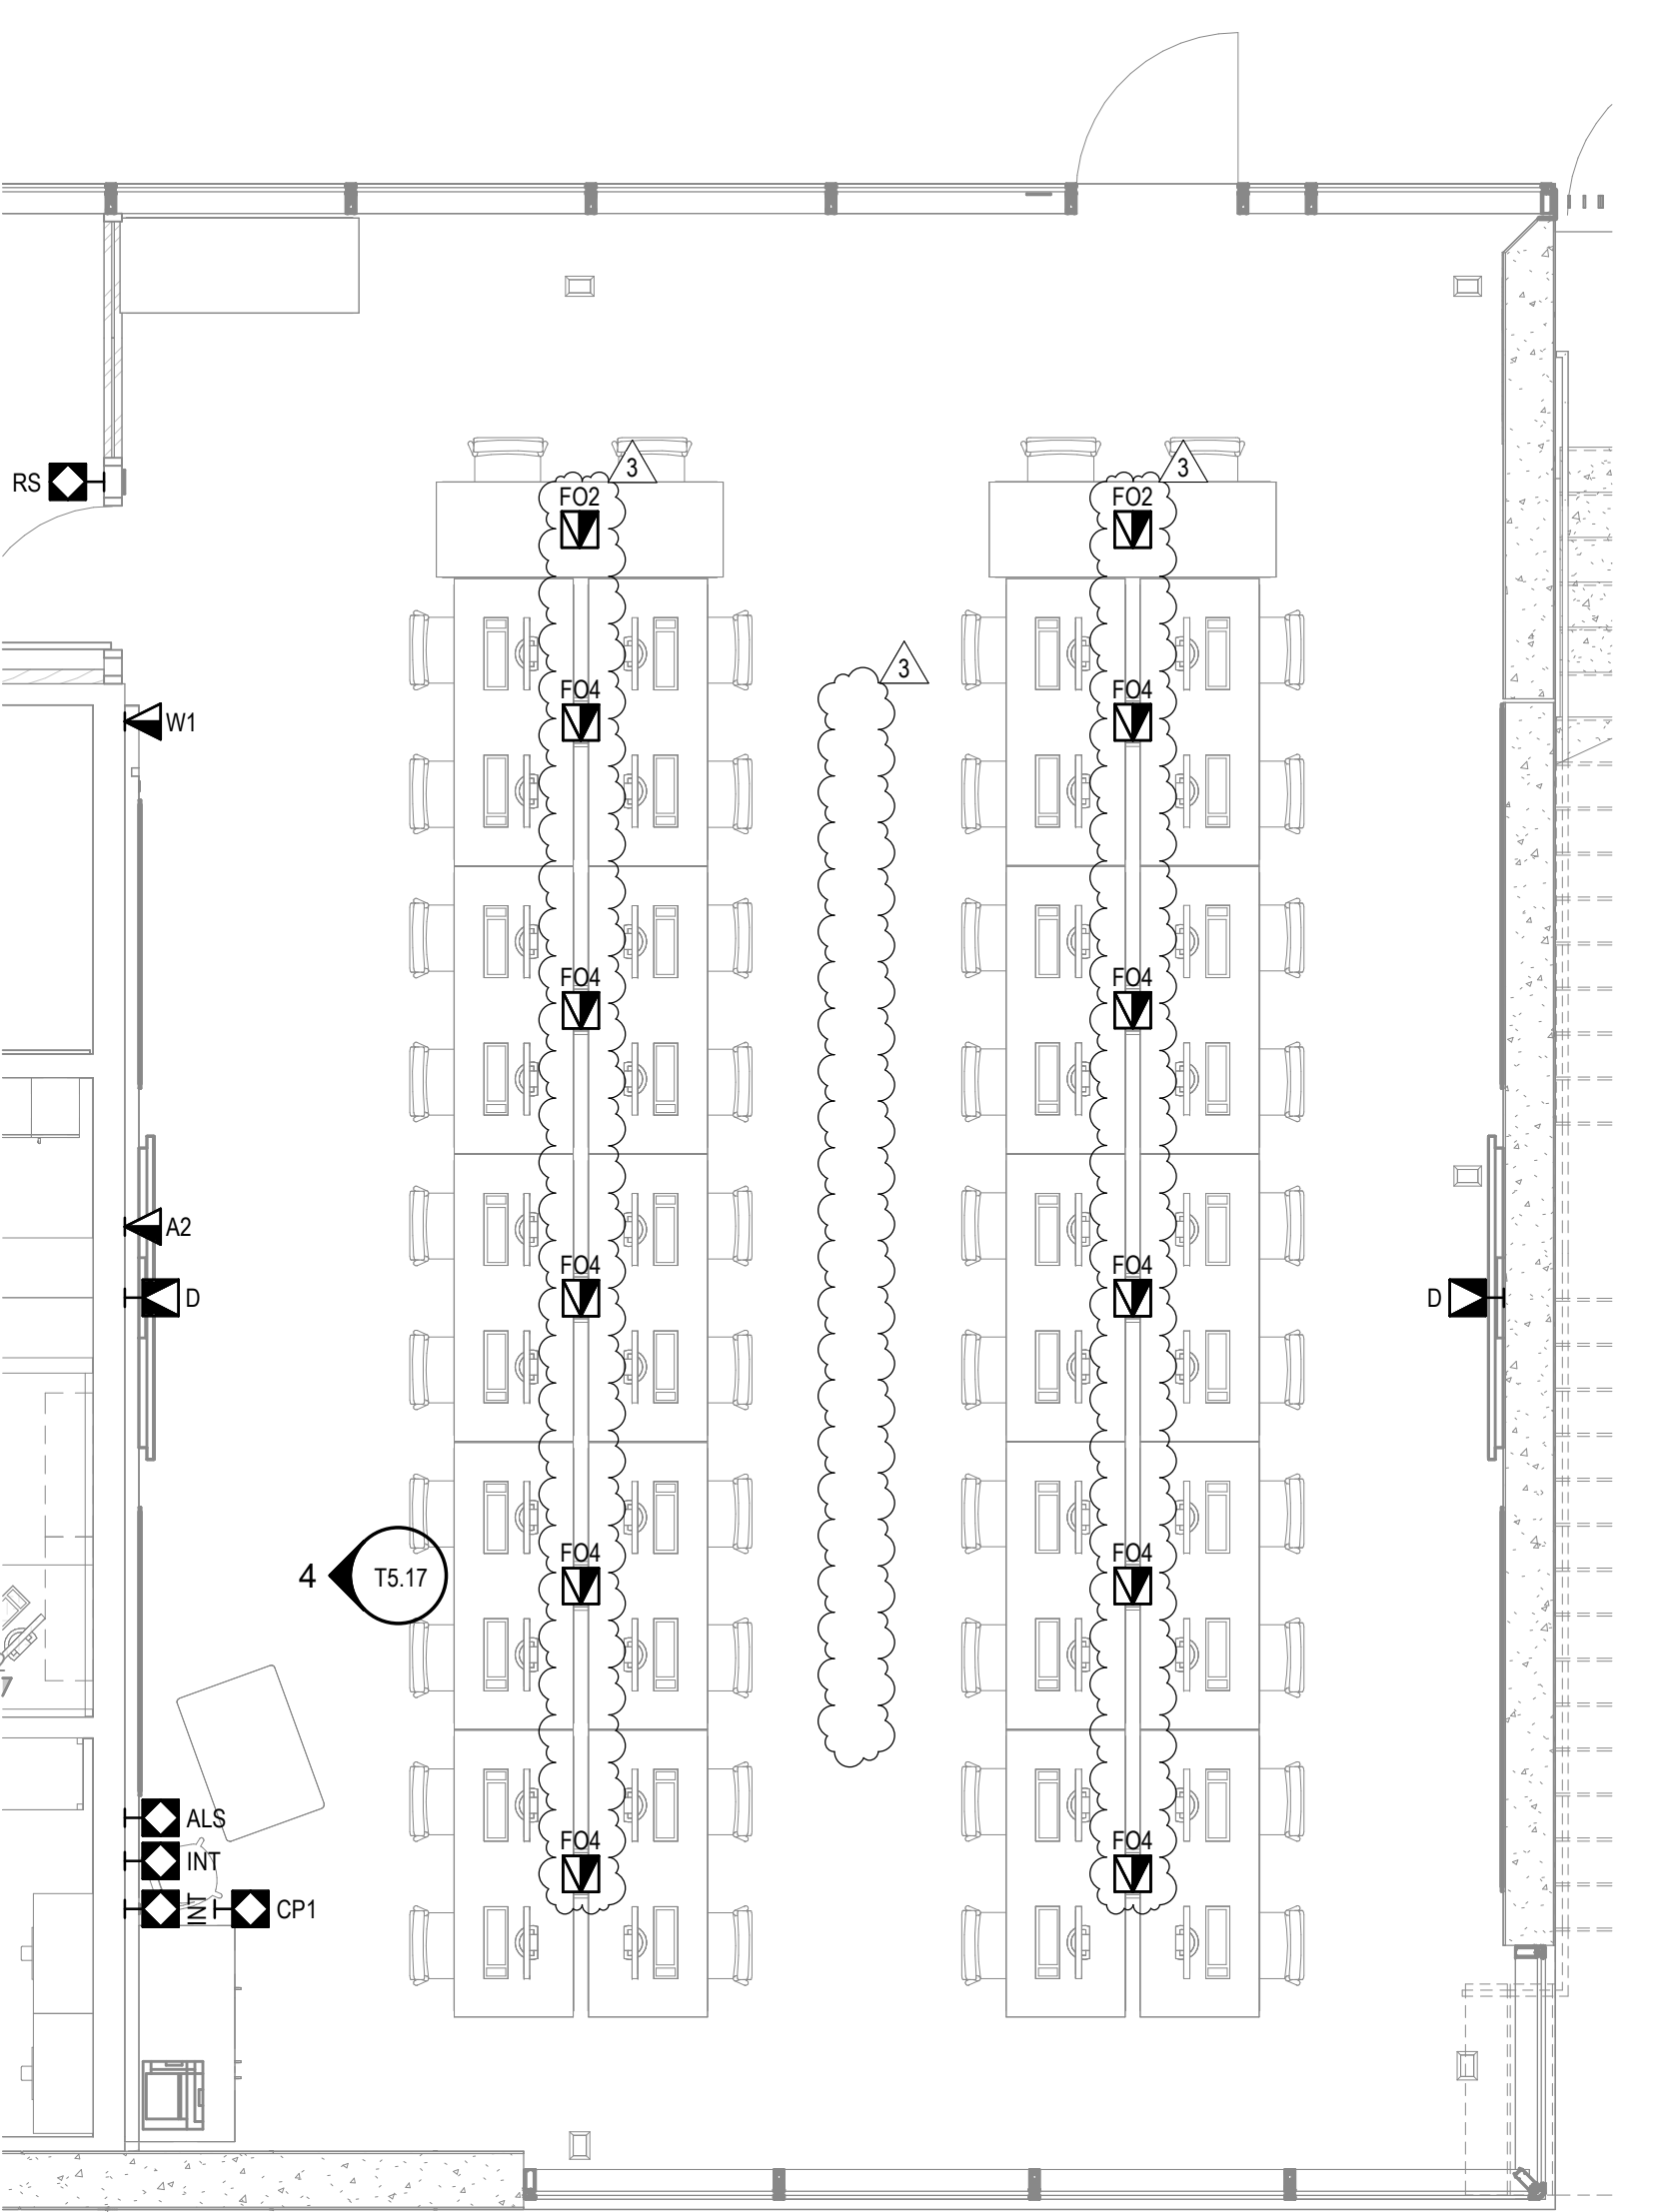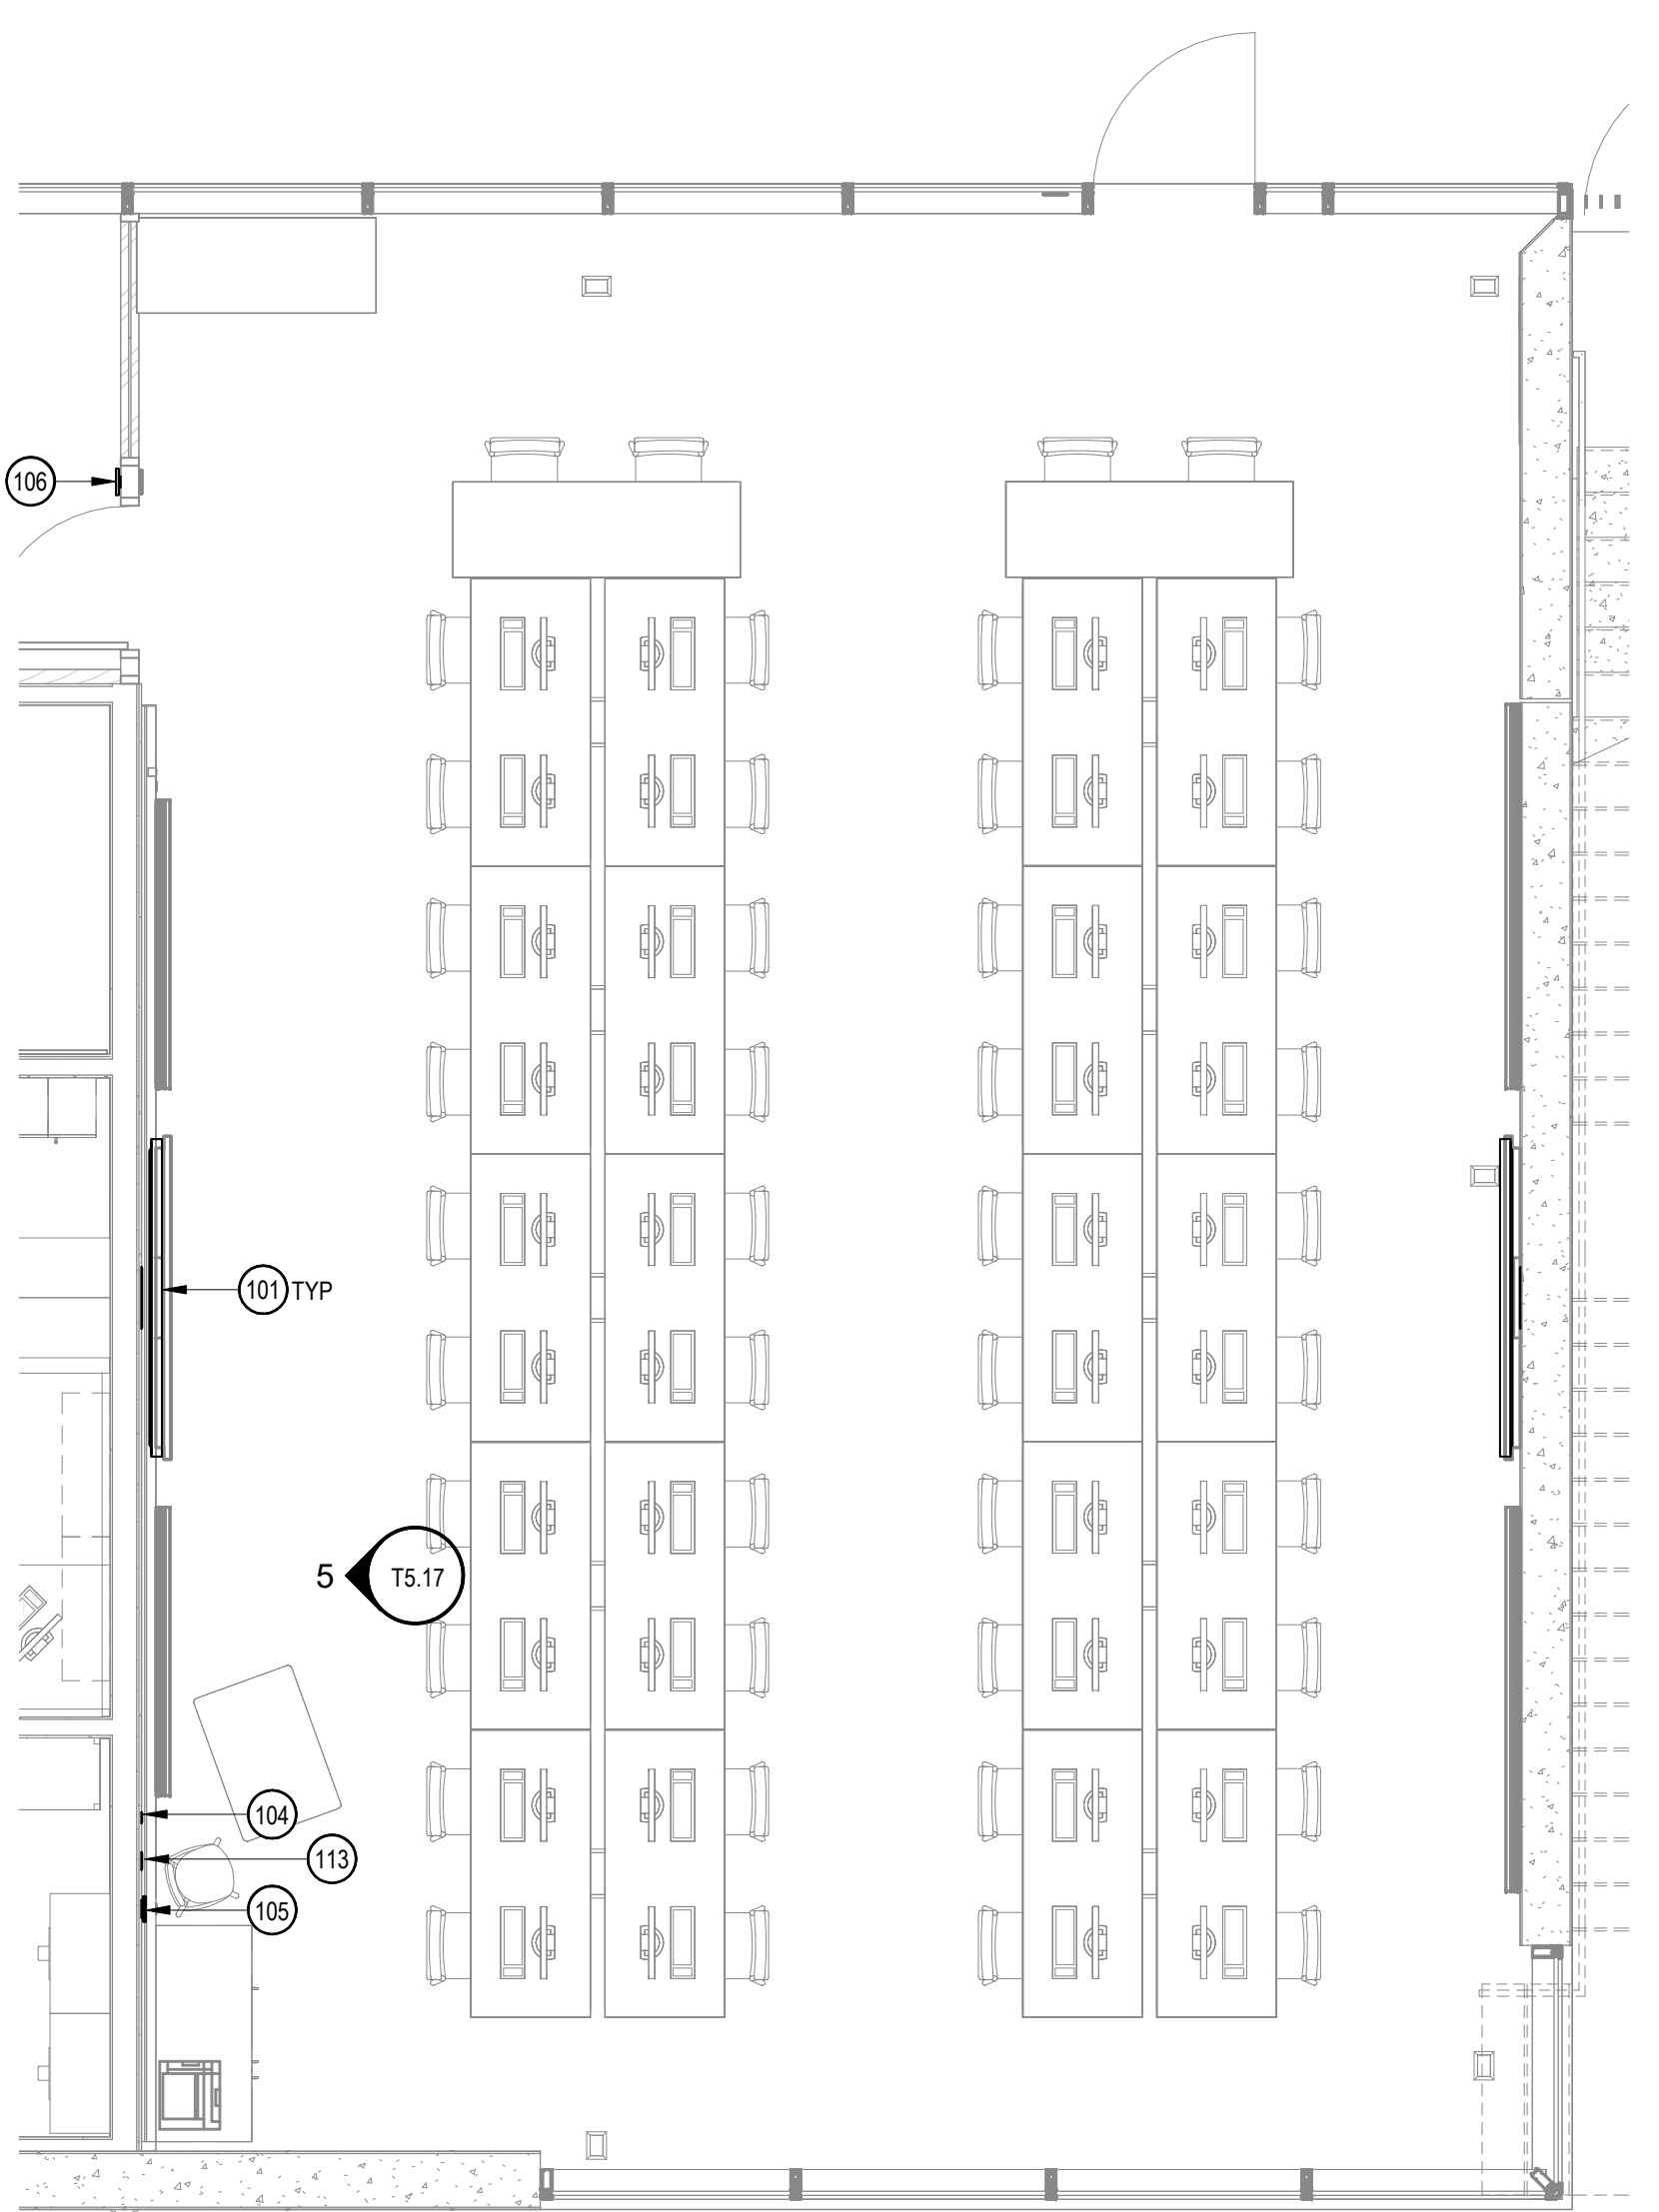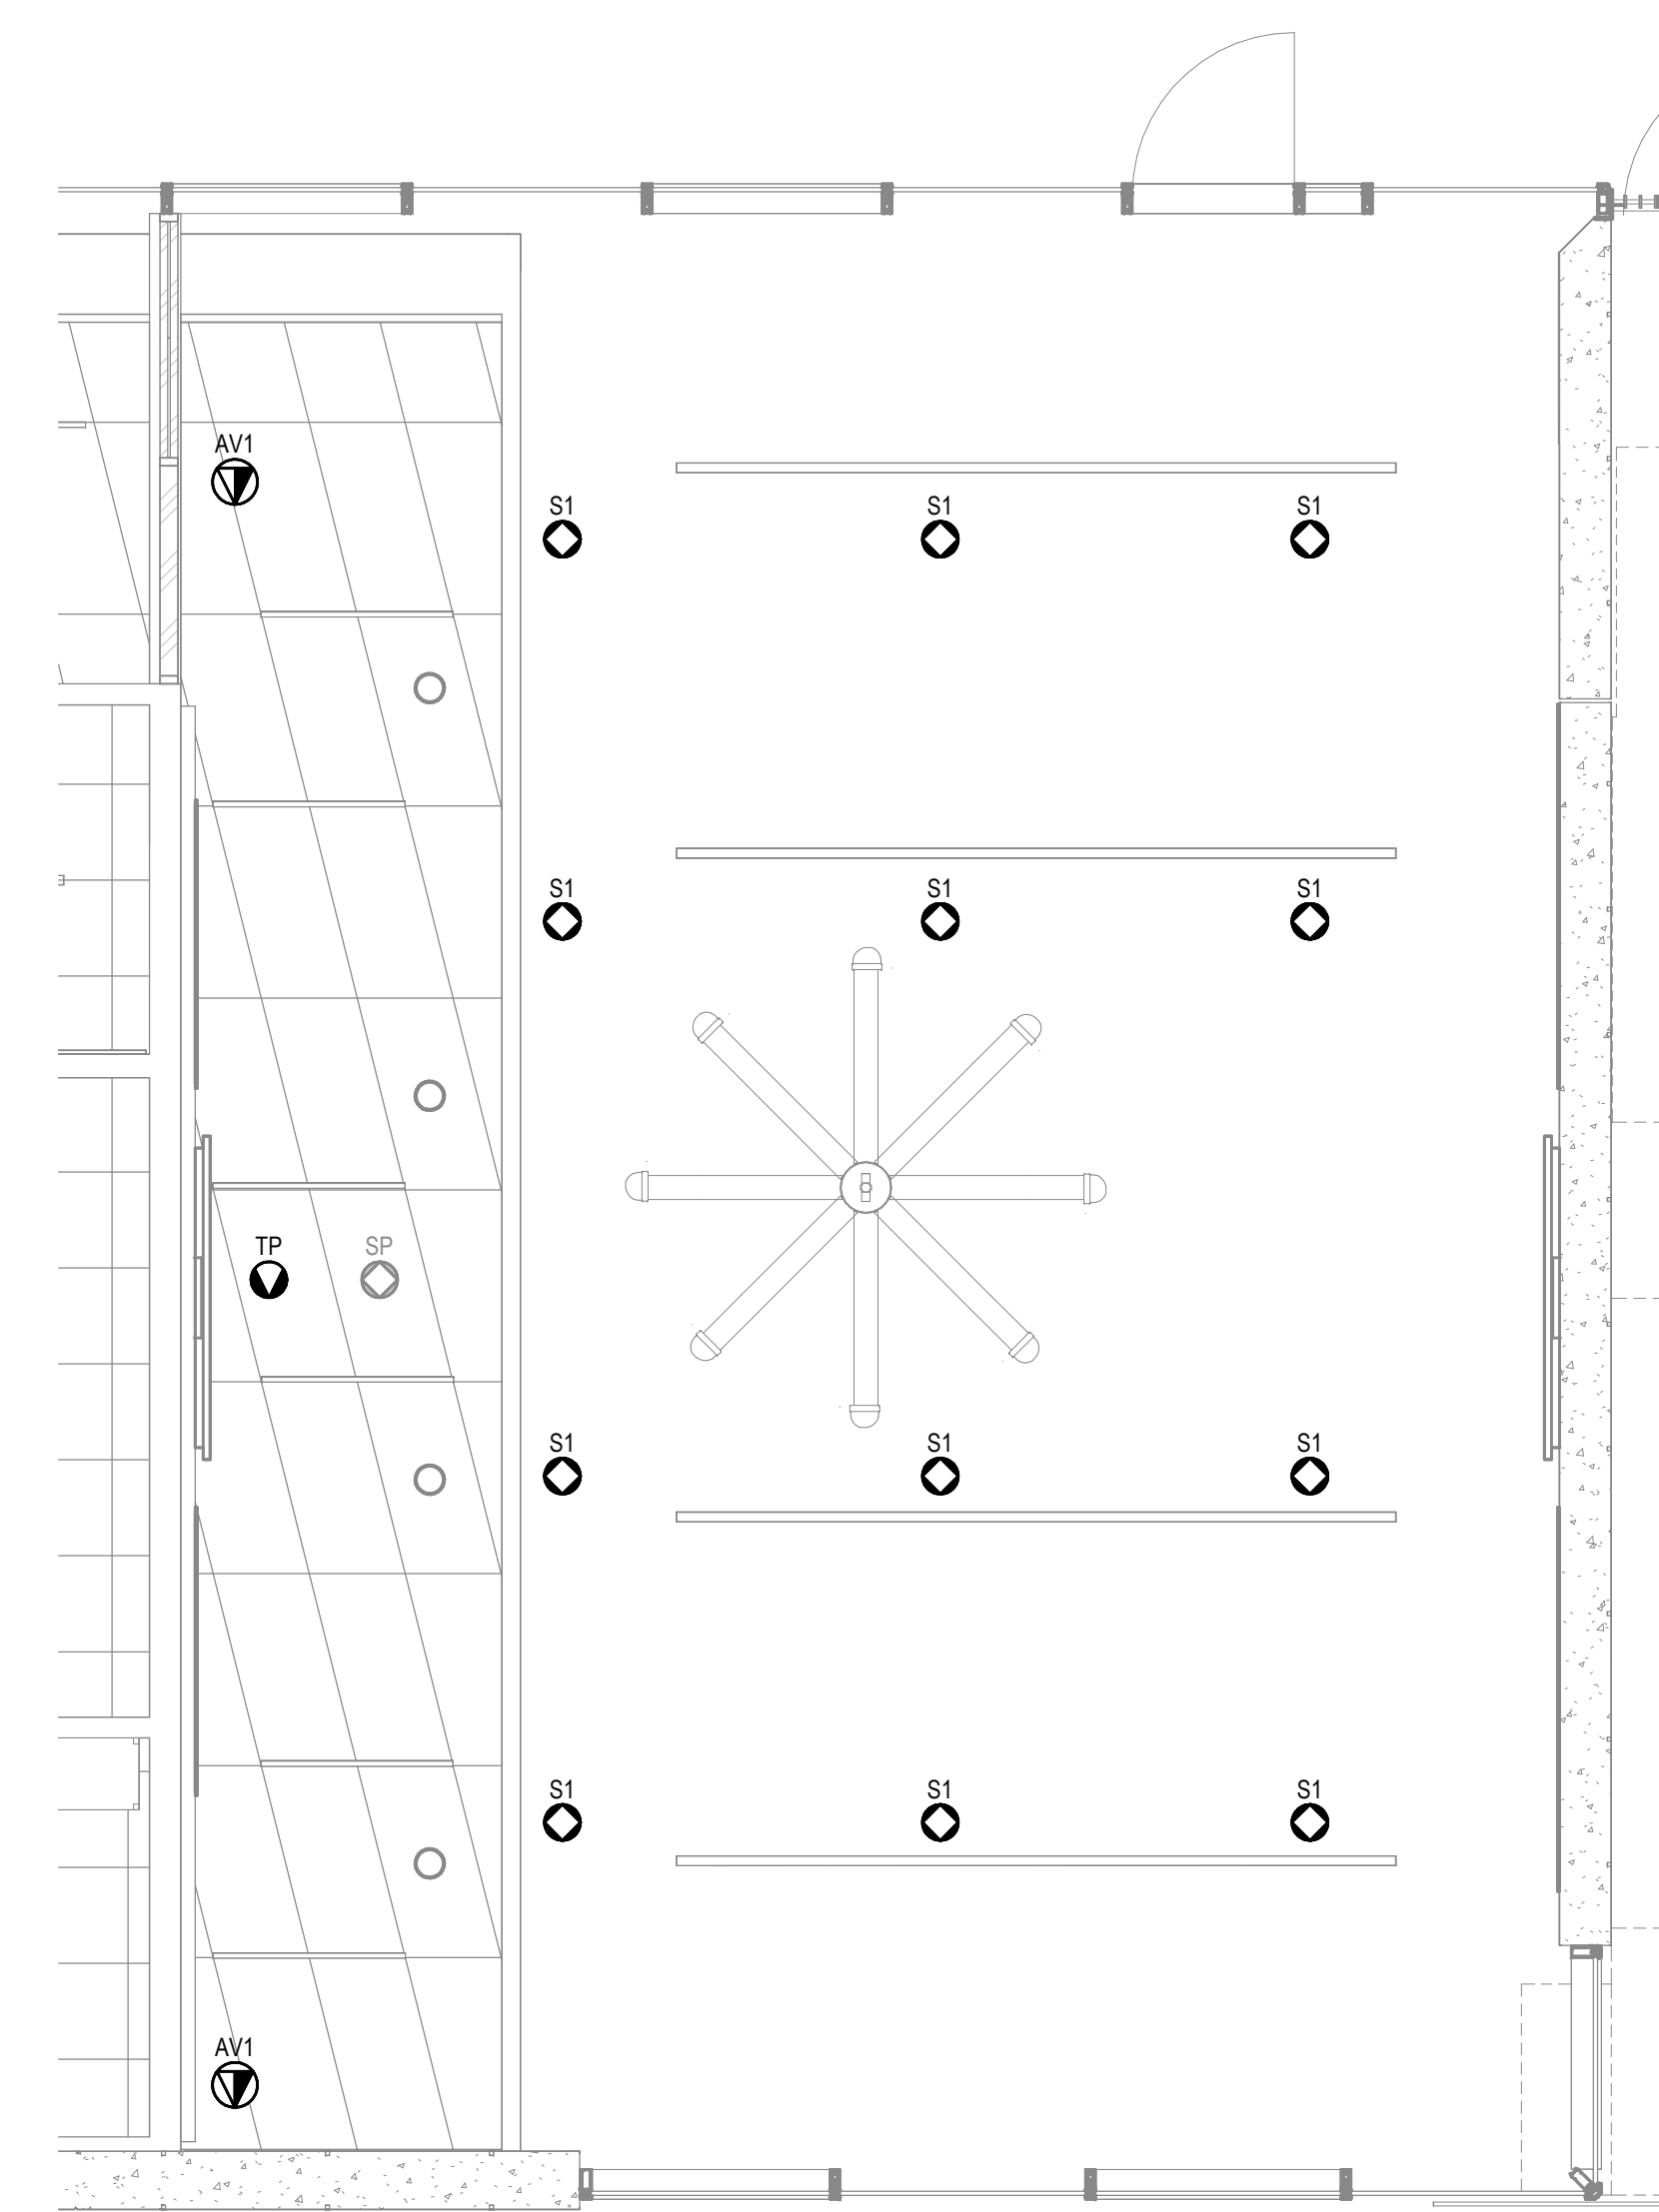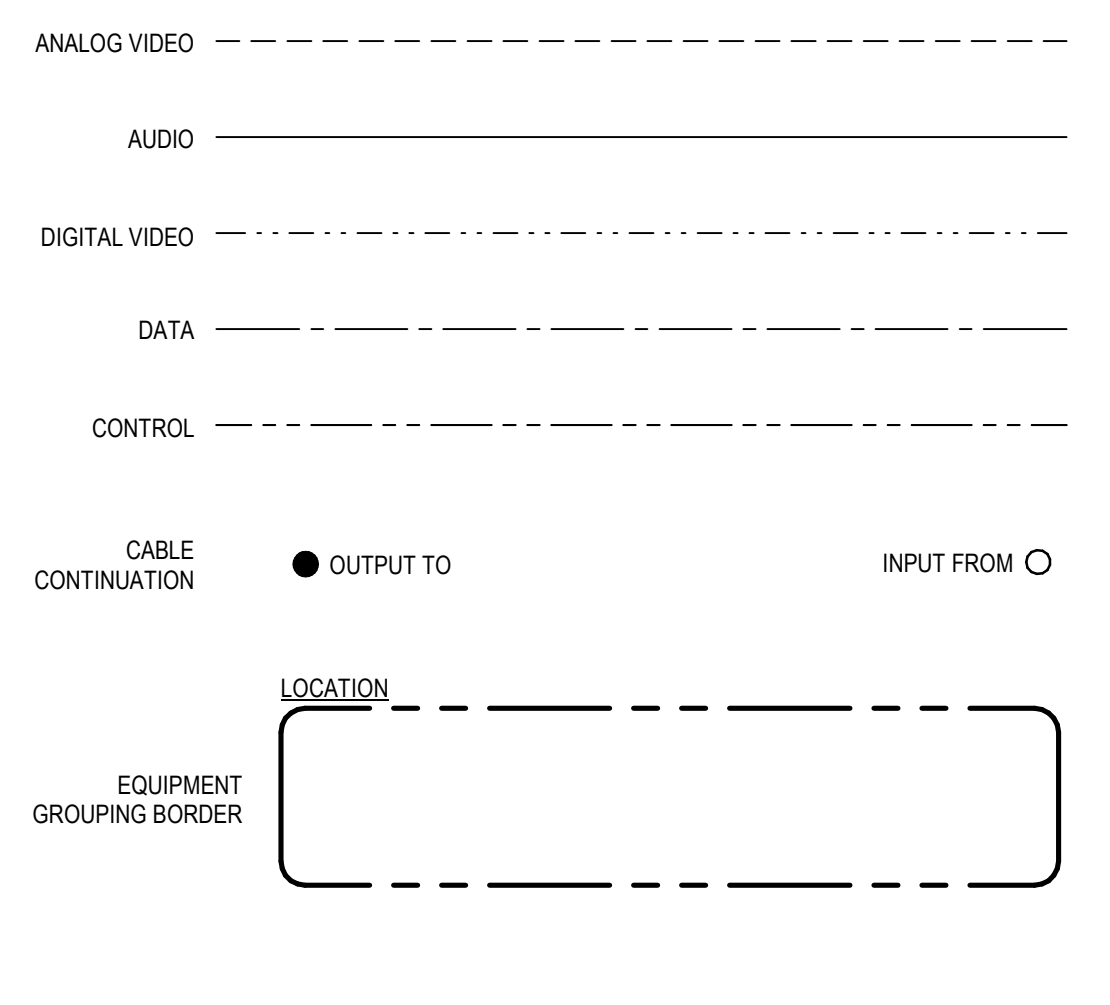

3 REFLECTED CEILING PLAN
SCALE: 1/4" = 1'-0"


2 EQUIPMENT PLAN
SCALE: 1/4" = 1'-0"

1 INFRASTRUCTURE PLAN
SCALE: 1/4" = 1'-0"

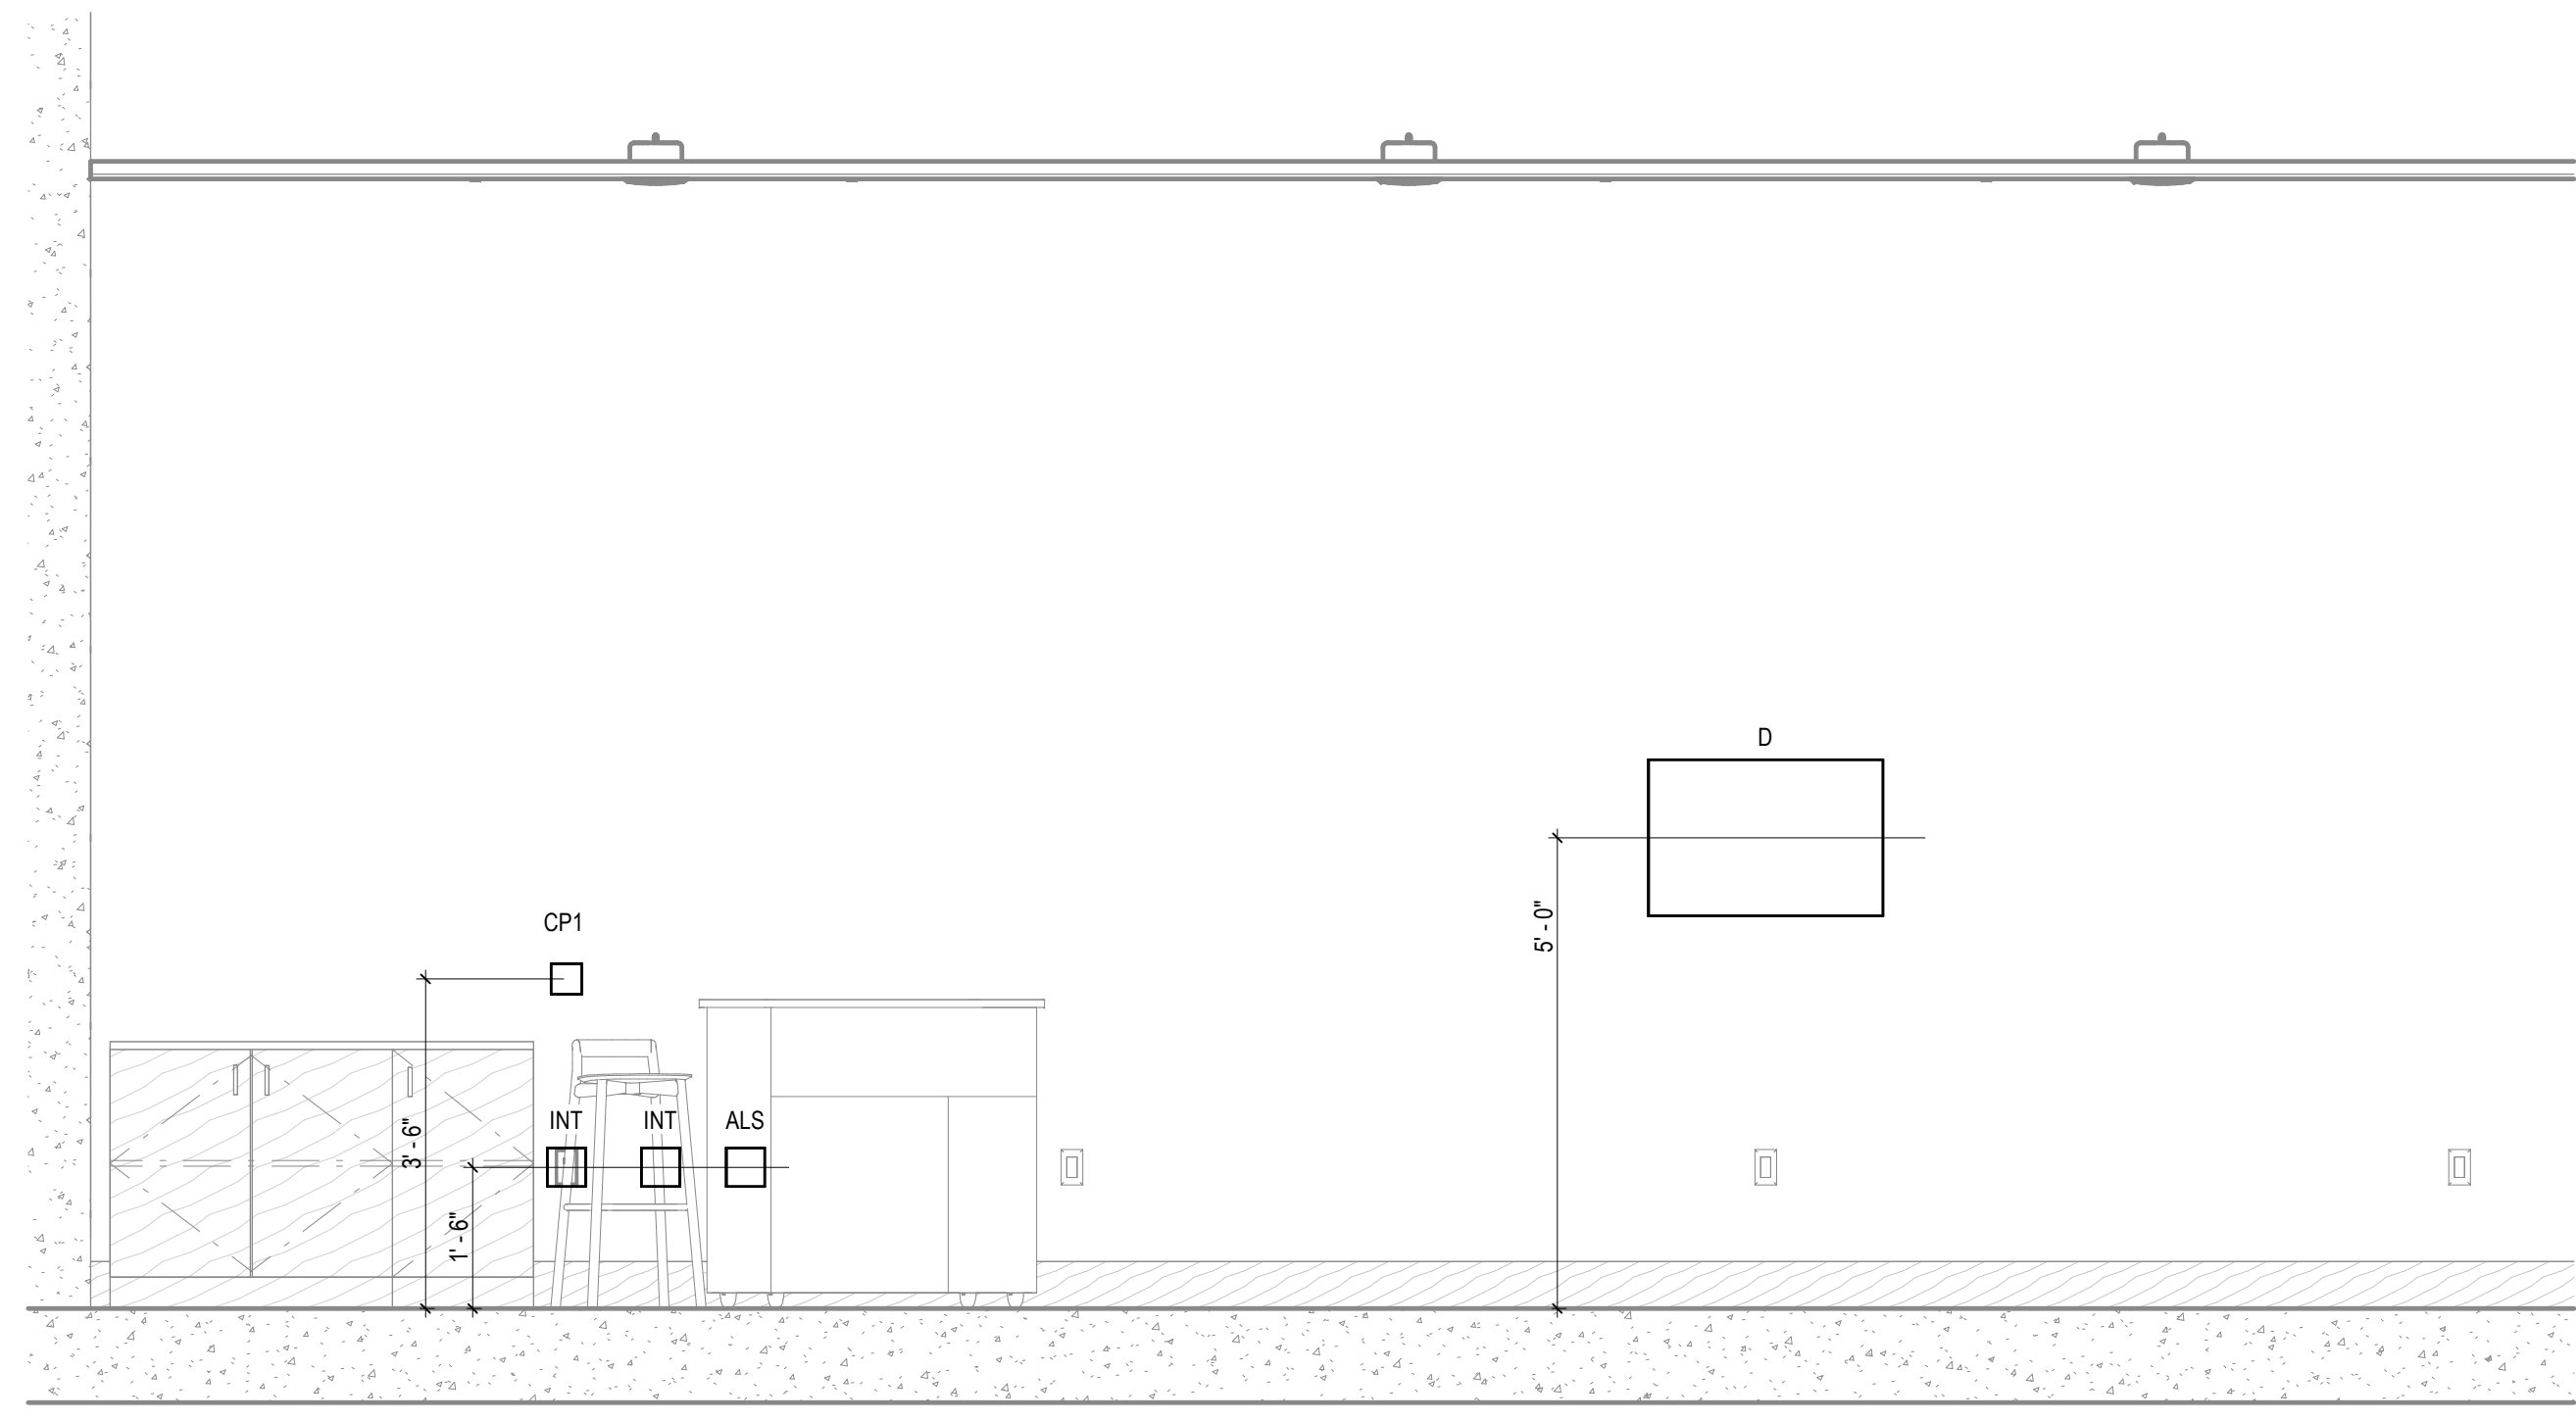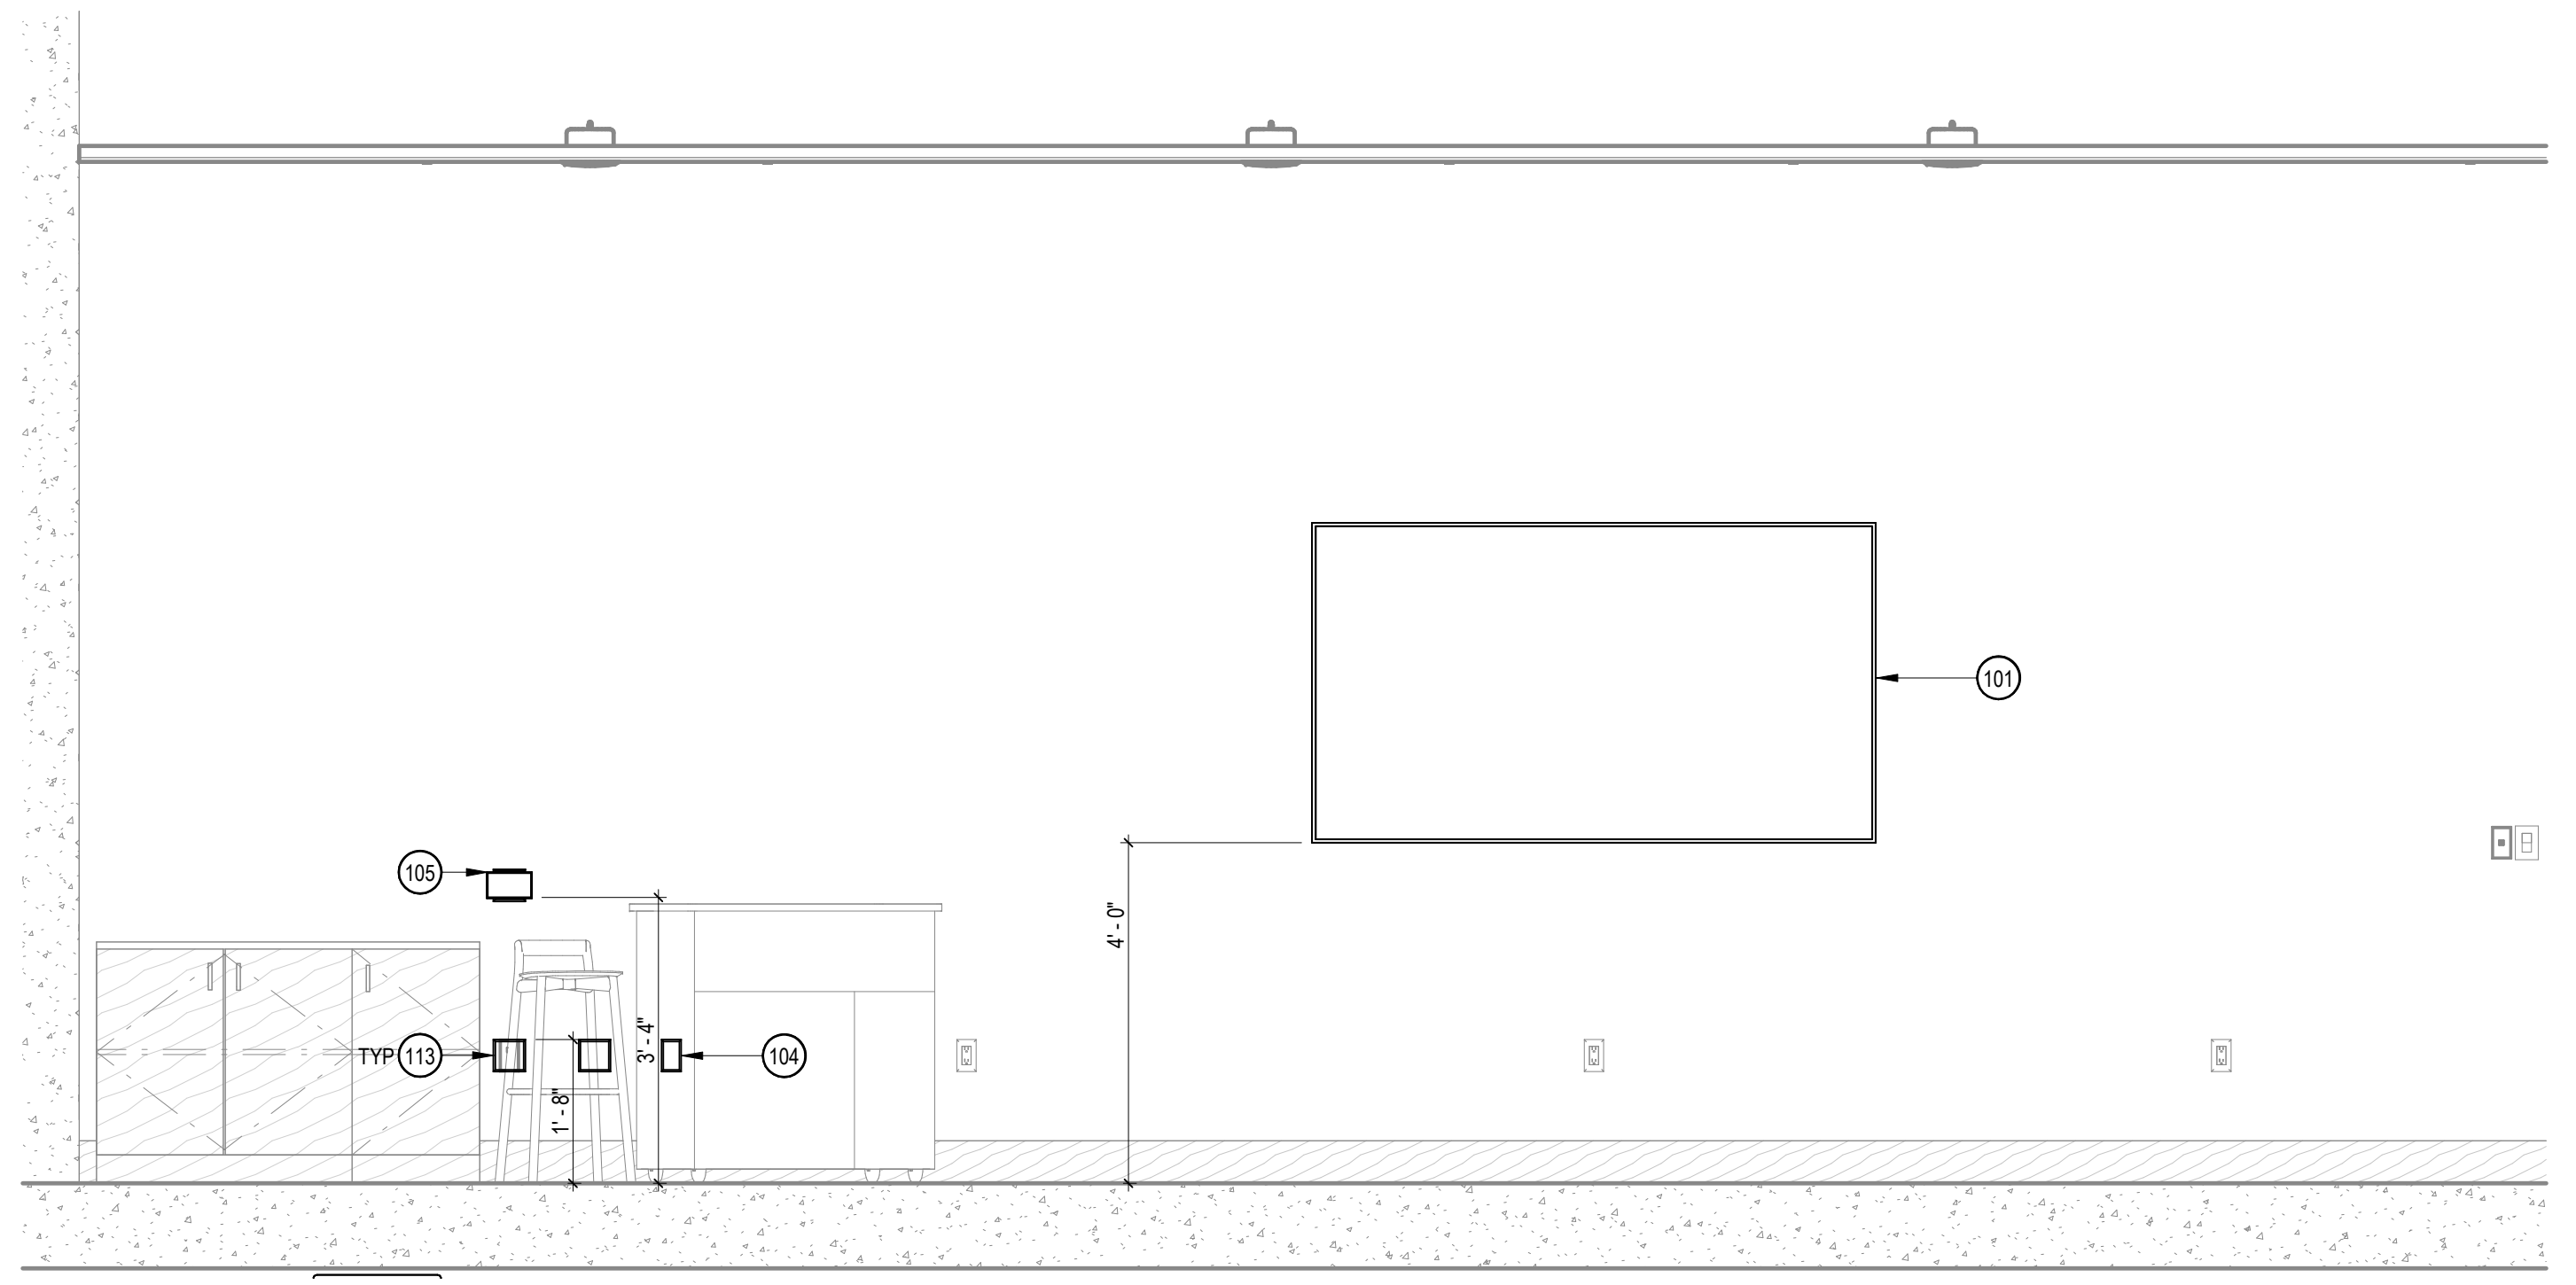


5 EQUIPMENT ELEVATION
SCALE: 1/2" = 1'-0"

4 INFRASTRUCTURE ELEVATION
SCALE: 1/2" = 1'-0"

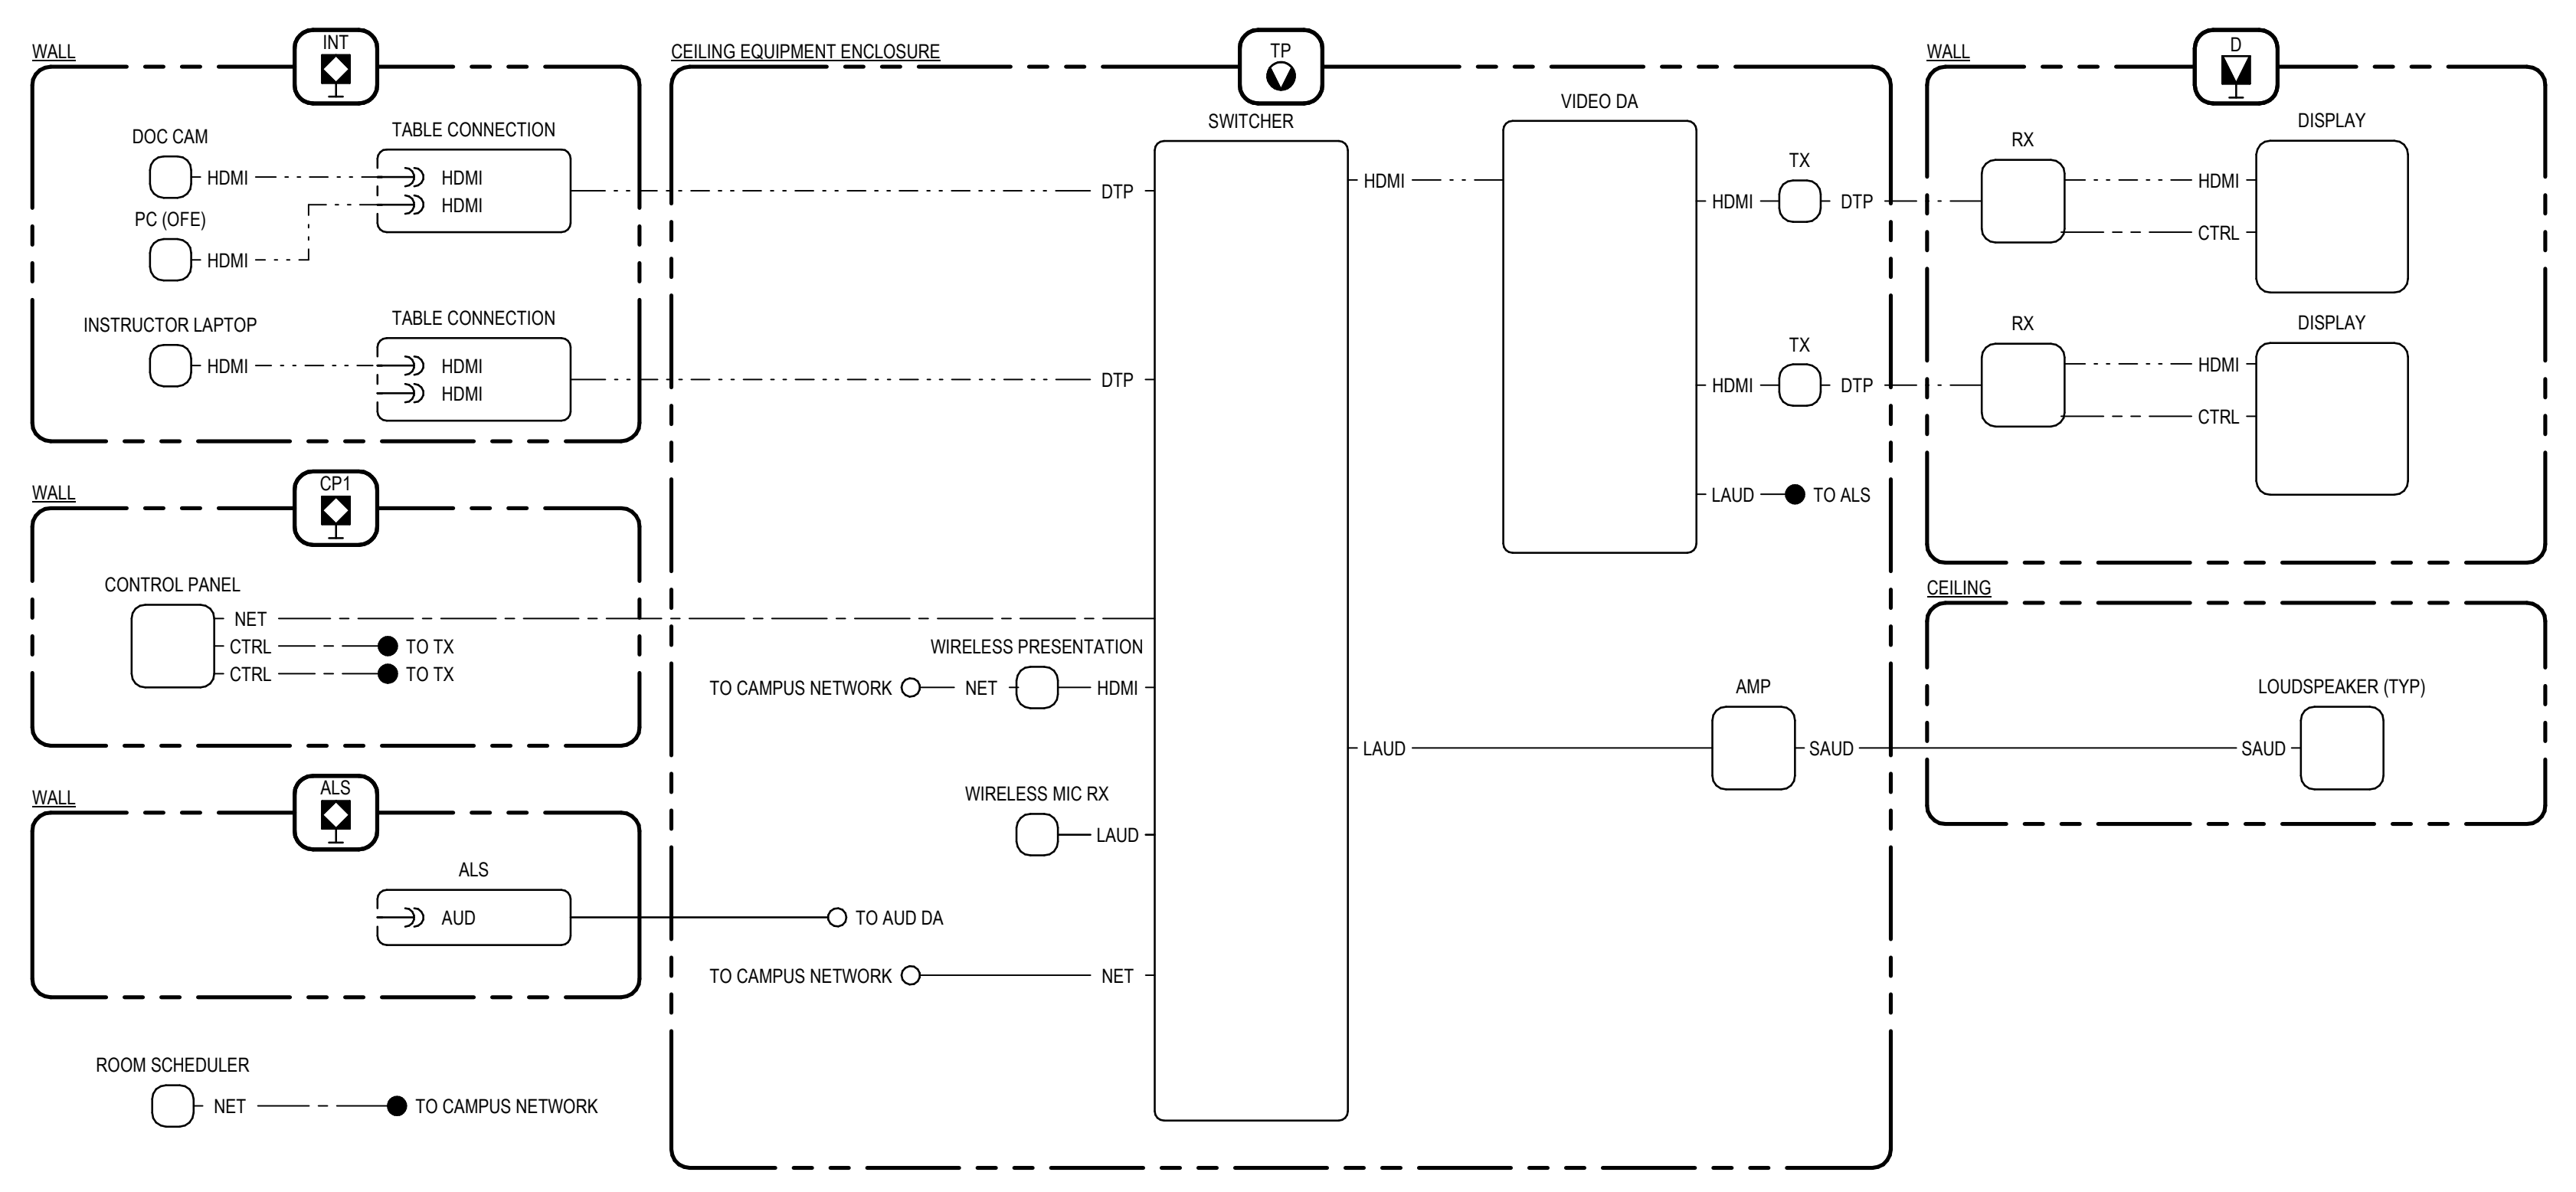

7 AUDIOVISUAL FUNCTIONAL DIAGRAM
SCALE: NONE

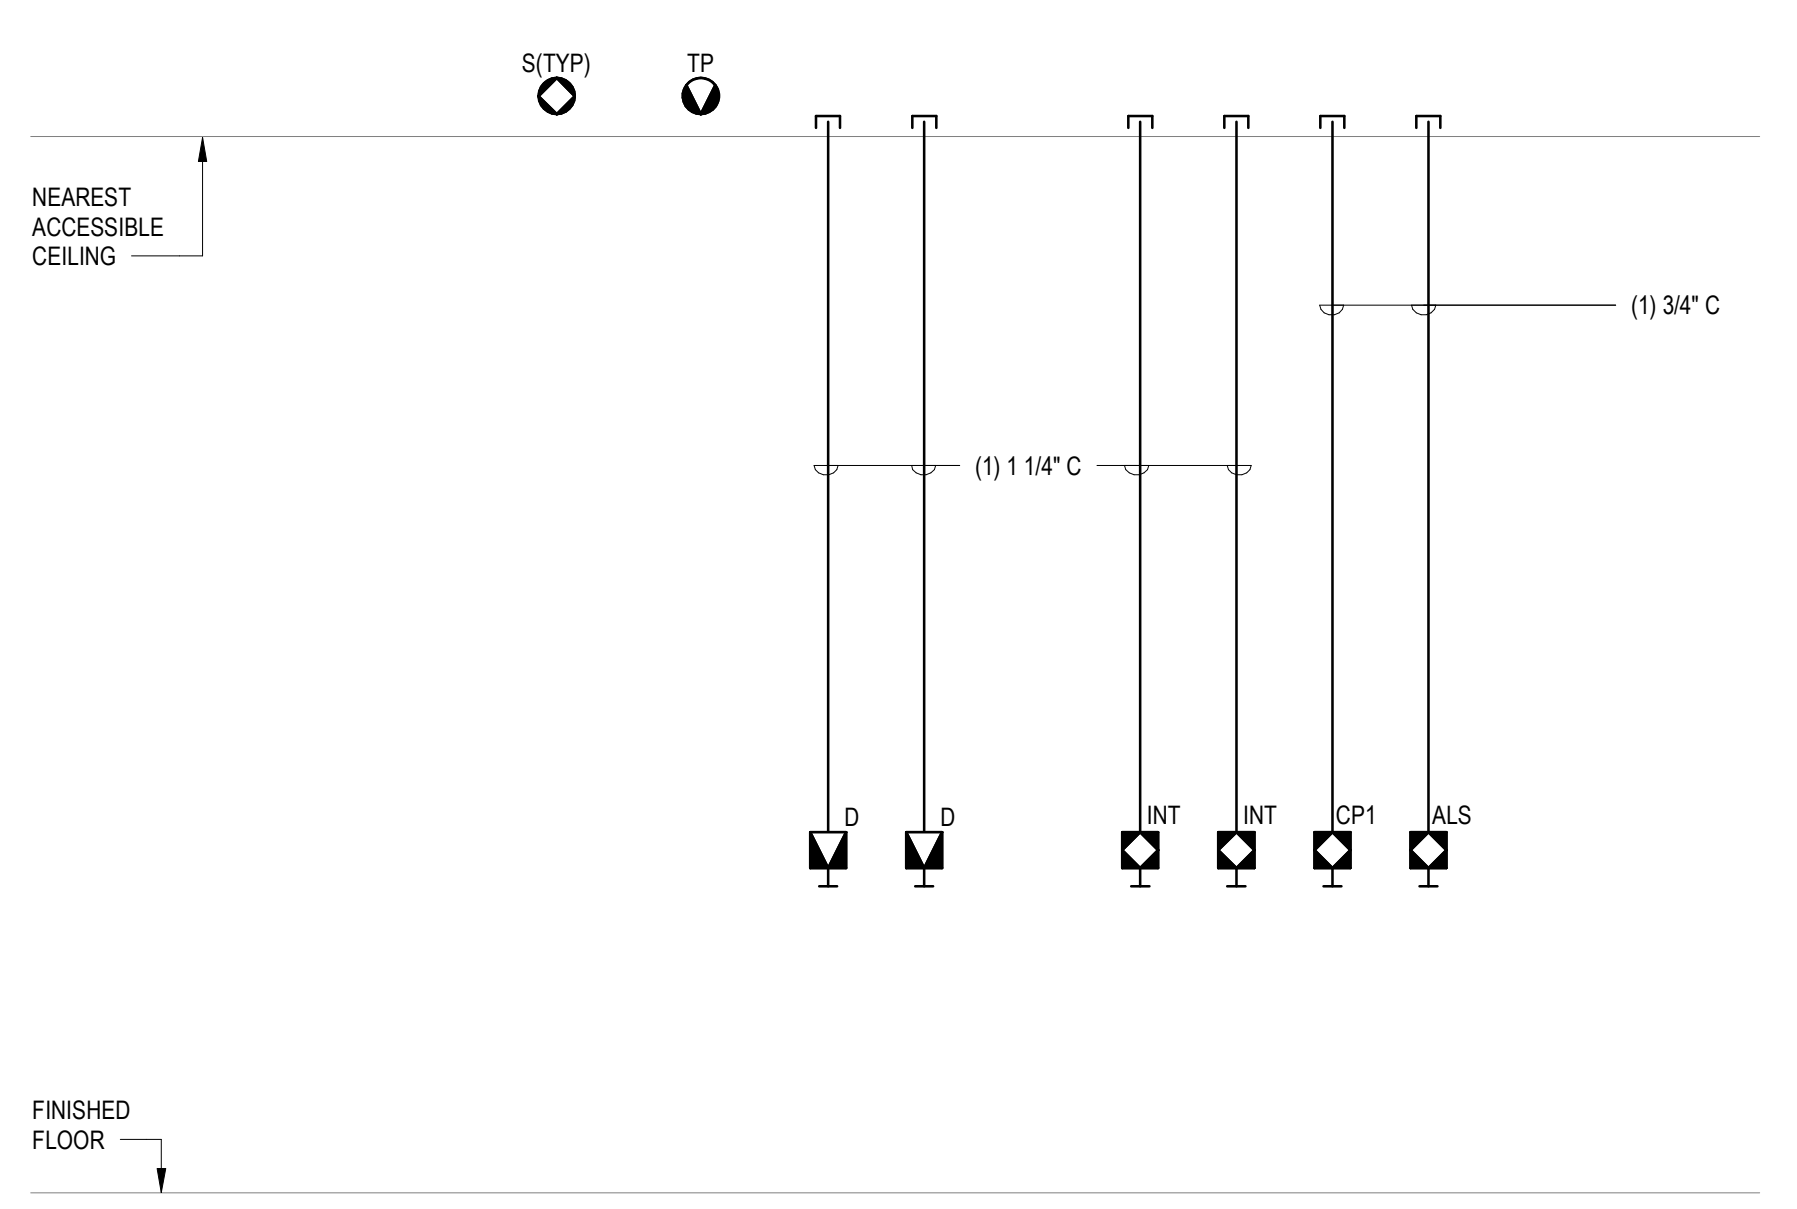

6 AV PATHWAY DIAGRAM
SCALE: 1/2" = 1'-0"