
 
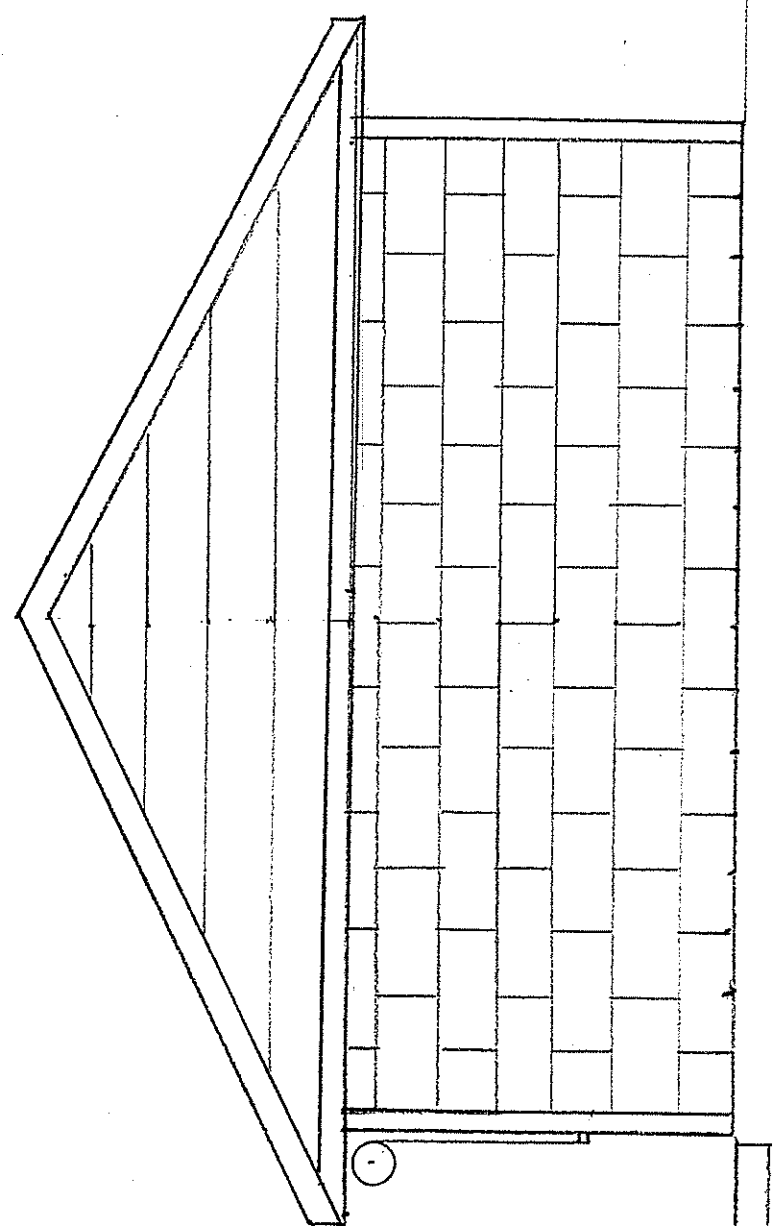



EAST VIEW



NORTH VIEW

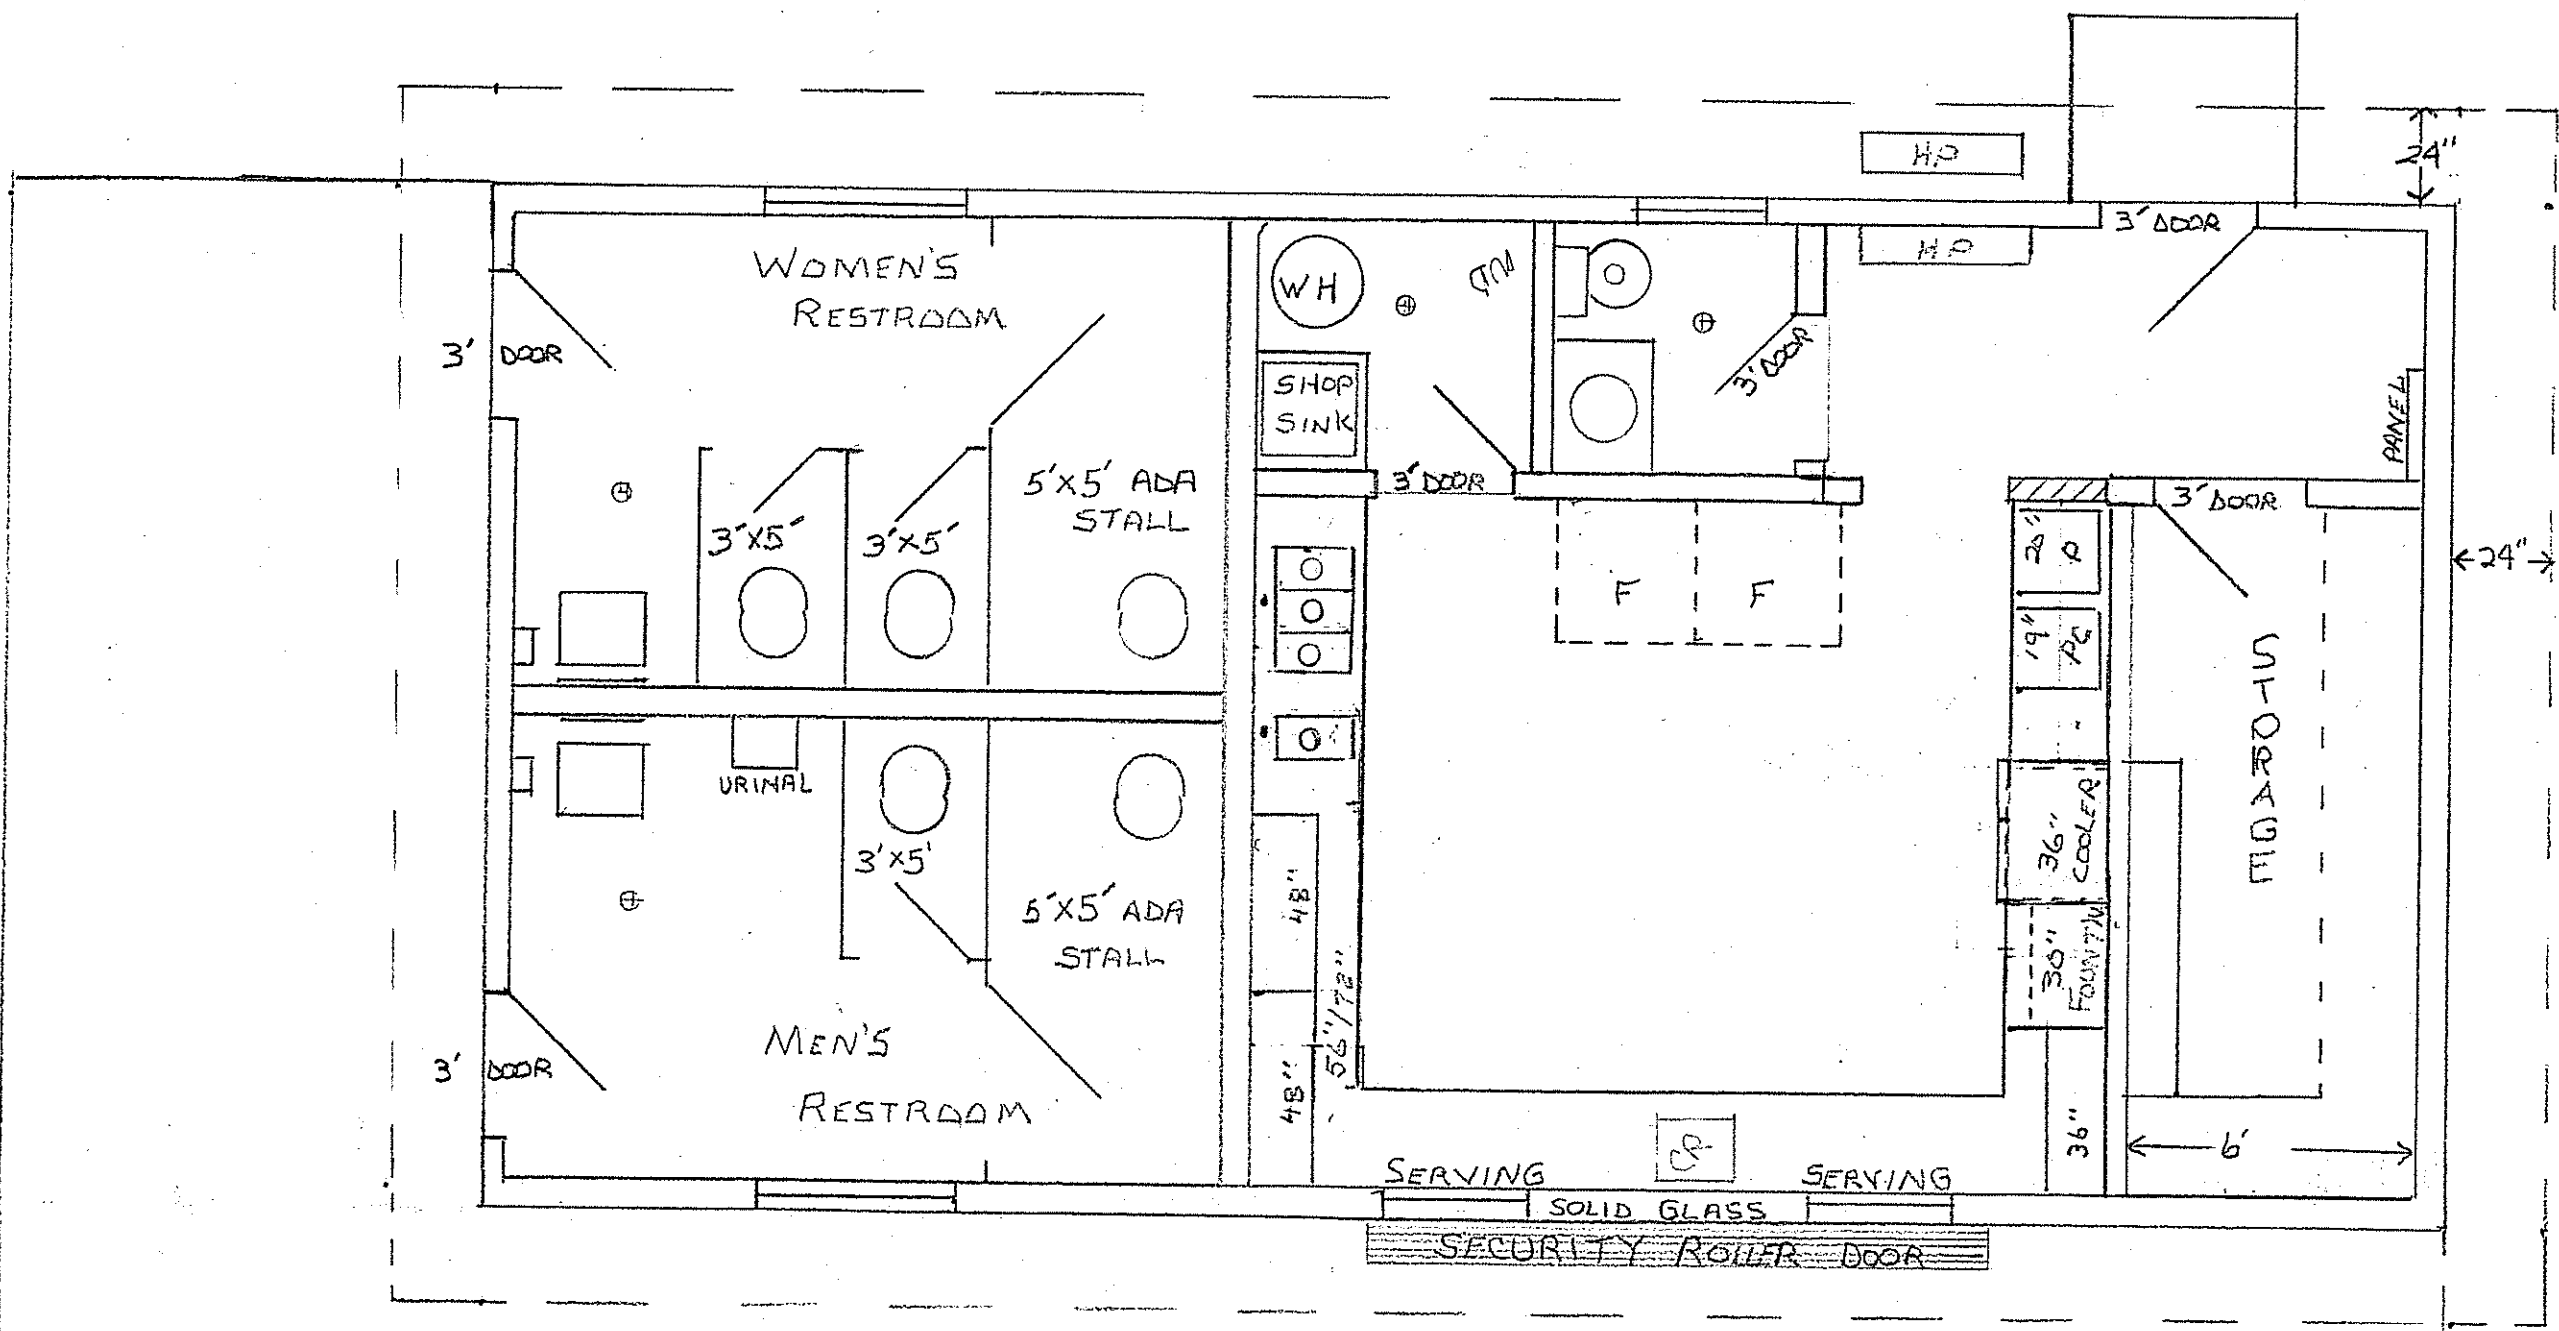


FLOOR PLAN

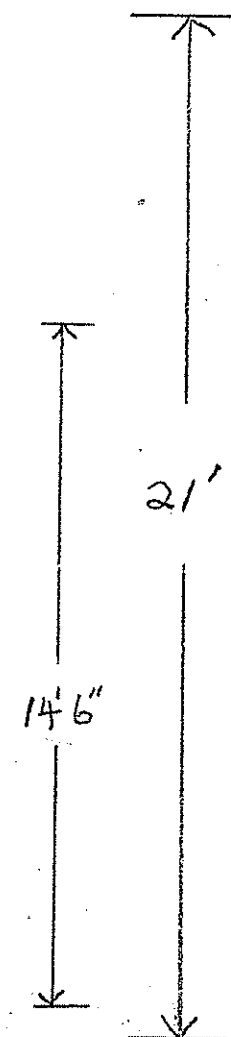


CONCESSION & RESTROOMS		
SCALE: 1/4" = 1'	APPROVED BY:	DRAWN BY JEB
DATE: 12-24-16		REVISED
BASEBALL COMPLEX @ REC CNTR		
FLOOR PLAN	DRAWING NUMBER	1

LIGHTING FIXTURE SCHEDULE		
MARK	REMARKS	MOUNTING
A	4' LONG 2 LAMP FLOURESCENT STRIP	CEILING SURFACE
B	4' LONG 2 LAMP FLOURESCENT STRIP	CEILING SURFACE
C	LUMAPRO 3R20 WALL MOUNT AT 7'-0" AFF TO TOP	WALL SURFACE
D	4' LONG 2 LAMP FLOURESCENT STRIP	CEILING SURFACE
E	4' LONG 2 LAMP FLOURESCENT STRIP	CEILING SURFACE


PANELBOARD SCHEDULE					
C#	BRKR	DESCRIPTION	C#	BRKR	DESCRIPTION
1	20/1	LIGHTING	2	20/1	REFRIGERATOR
3	20/1	COFFEE MAKER	4	20/1	REFRIGERATOR
5	20/1	HC MACHINE	6	20/1	HD MACHINE
7	20/1	WALL HEATER #1	8	20/1	PC MACHINE
9	20/1	WALL HEATER #2	10	20/1	MICROWAVE
11	30/2	WATER HEATER	12	20/1	COOLER
13			14	20/1	APPLIANCE
15	30/2	HEAT PUMP	16	20/1	APPLIANCE
17			18	20/1	STORE Rm RECEPT
19	20/1	APPLIANCE	20	20/1	SPACE
21	20/1	SPARE	22		SPARE
23		SPACE	24		SPACE
25		SPACE	26		SPACE
27		SPACE	28		SPACE

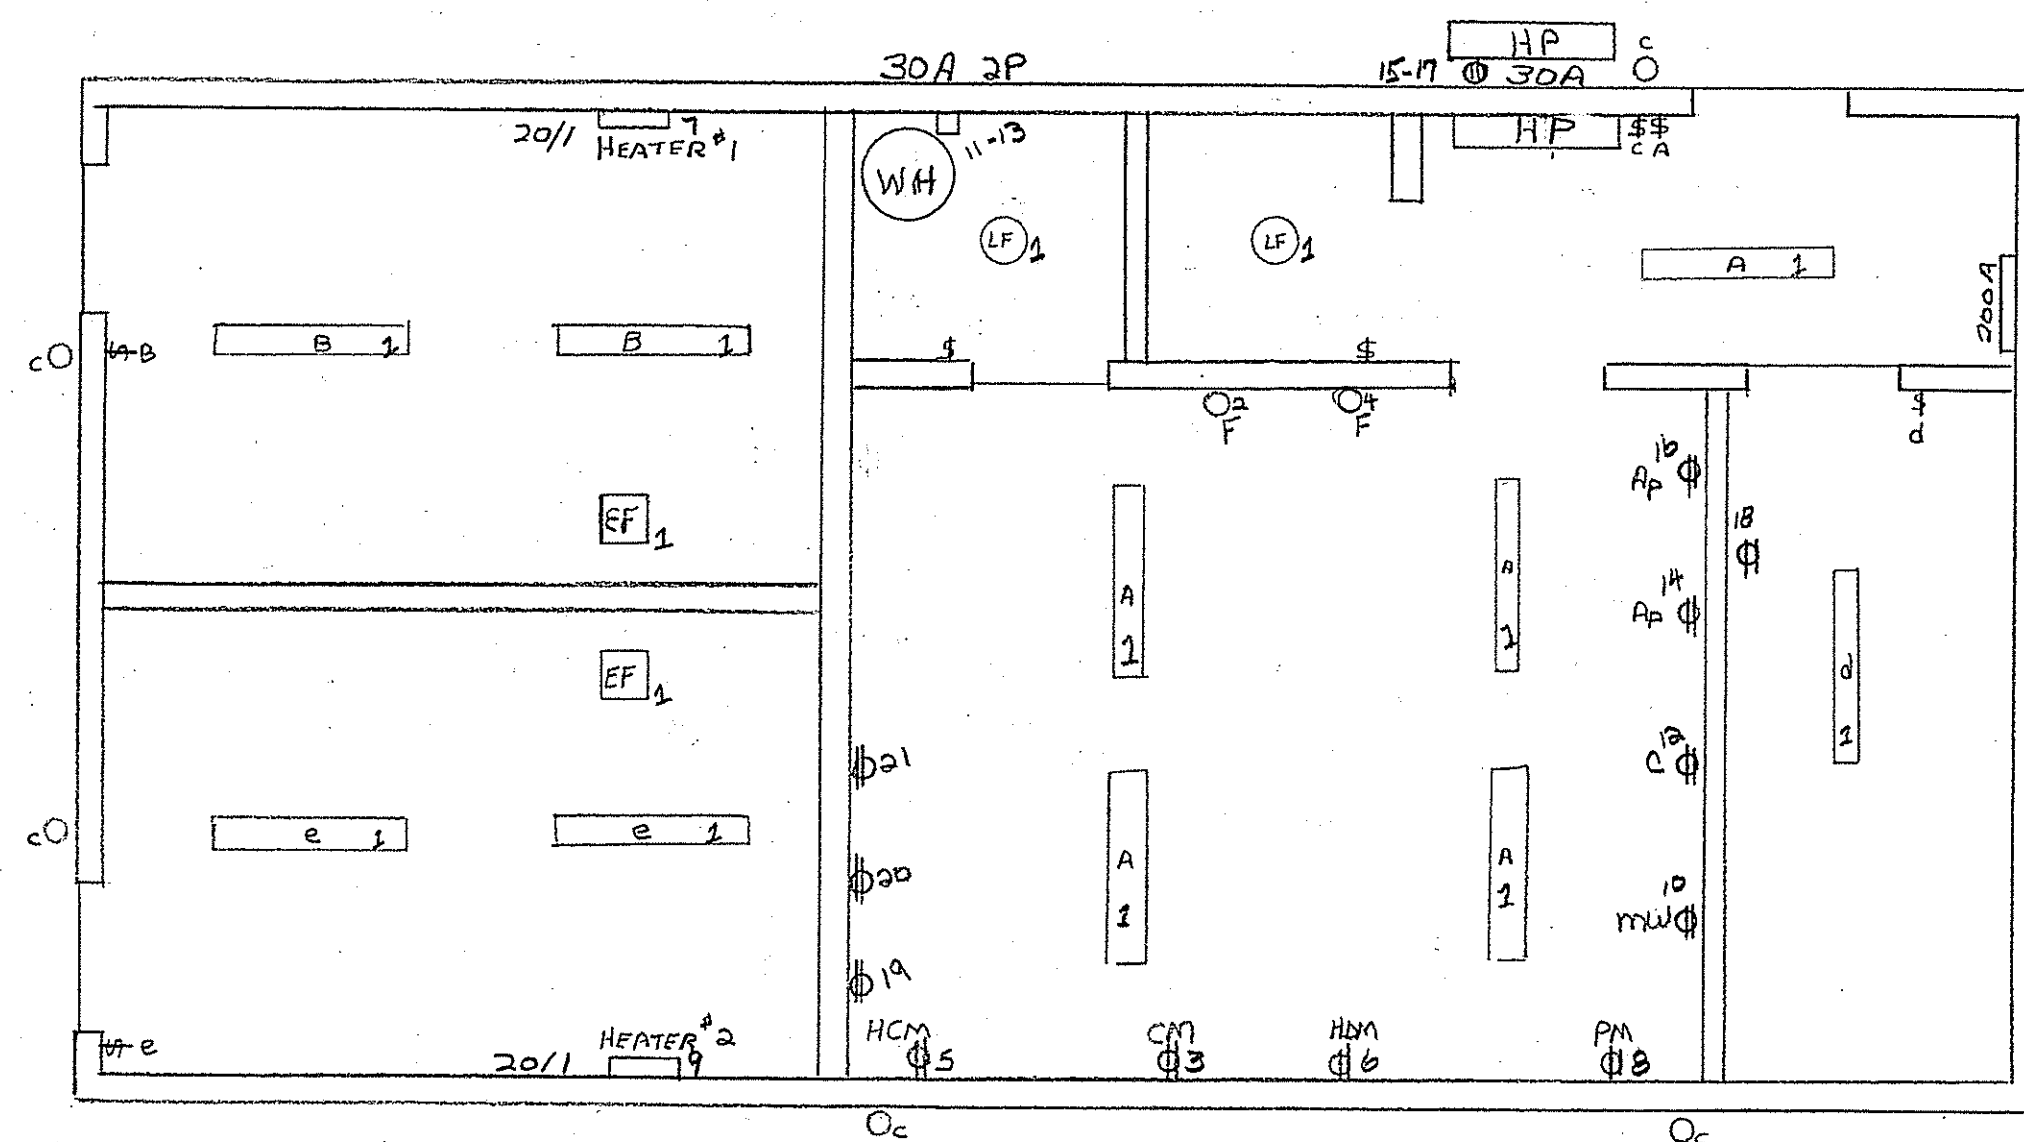

CONCESSION & RESTROOMS		
SCALE: 1/4" = 1'	APPROVED BY:	DRAWN BY JEB
DATE: 12-24-16		REVISED
ELECTRICAL		DRAWING NUMBER
		2

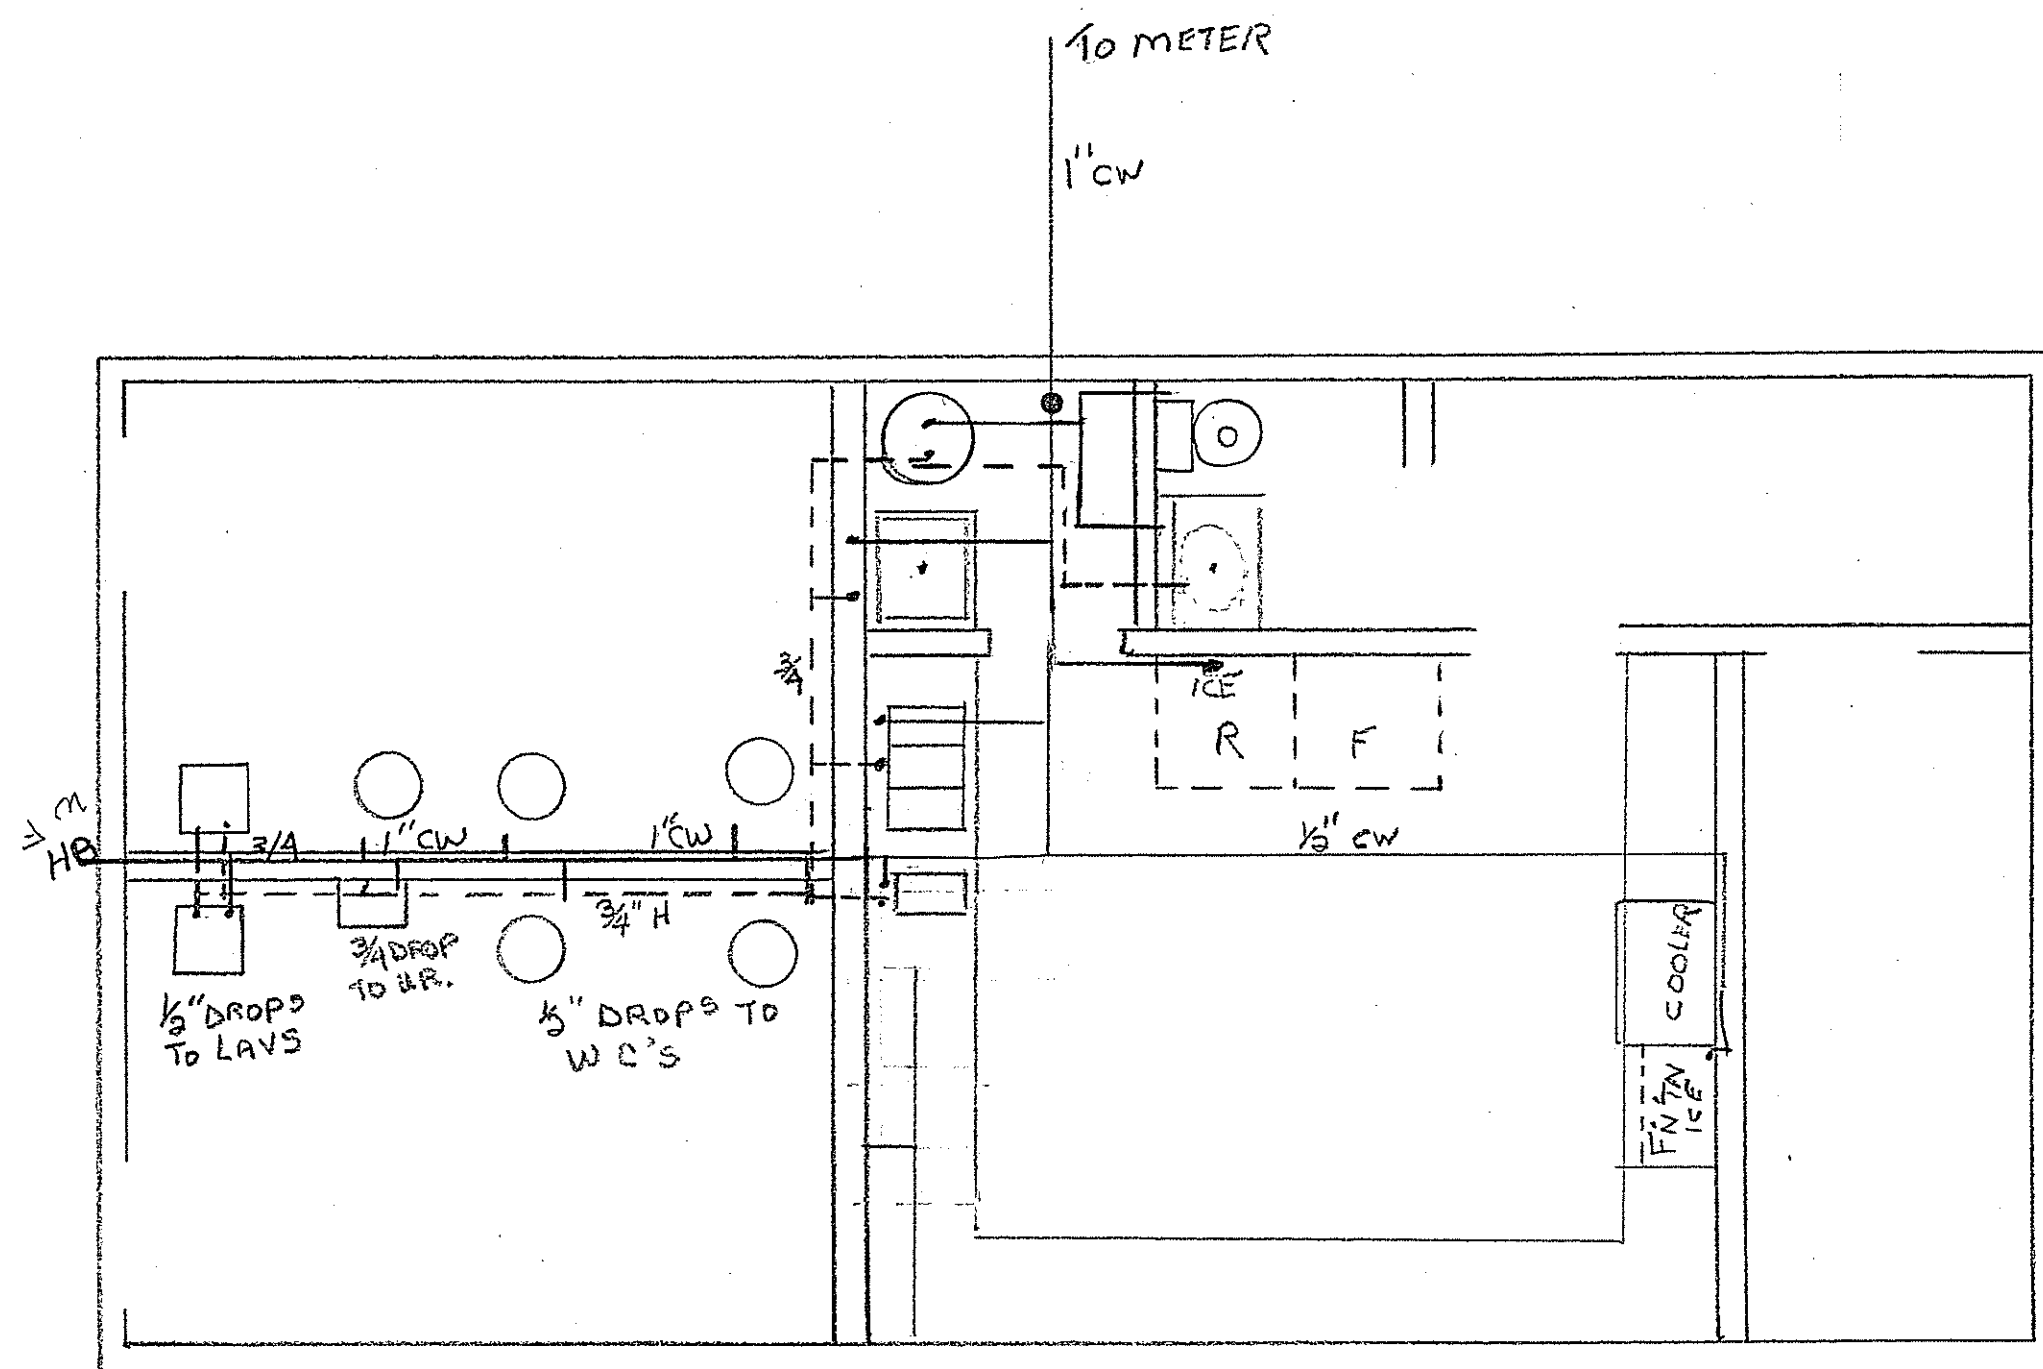

SCALE: 1/4" = 1'	APPROVED BY:	DRAWN BY JEB
DATE:		REVISED
DOMESTIC WATER SUPPLY		DRAWING NUMBER
SCHEMATIC		3

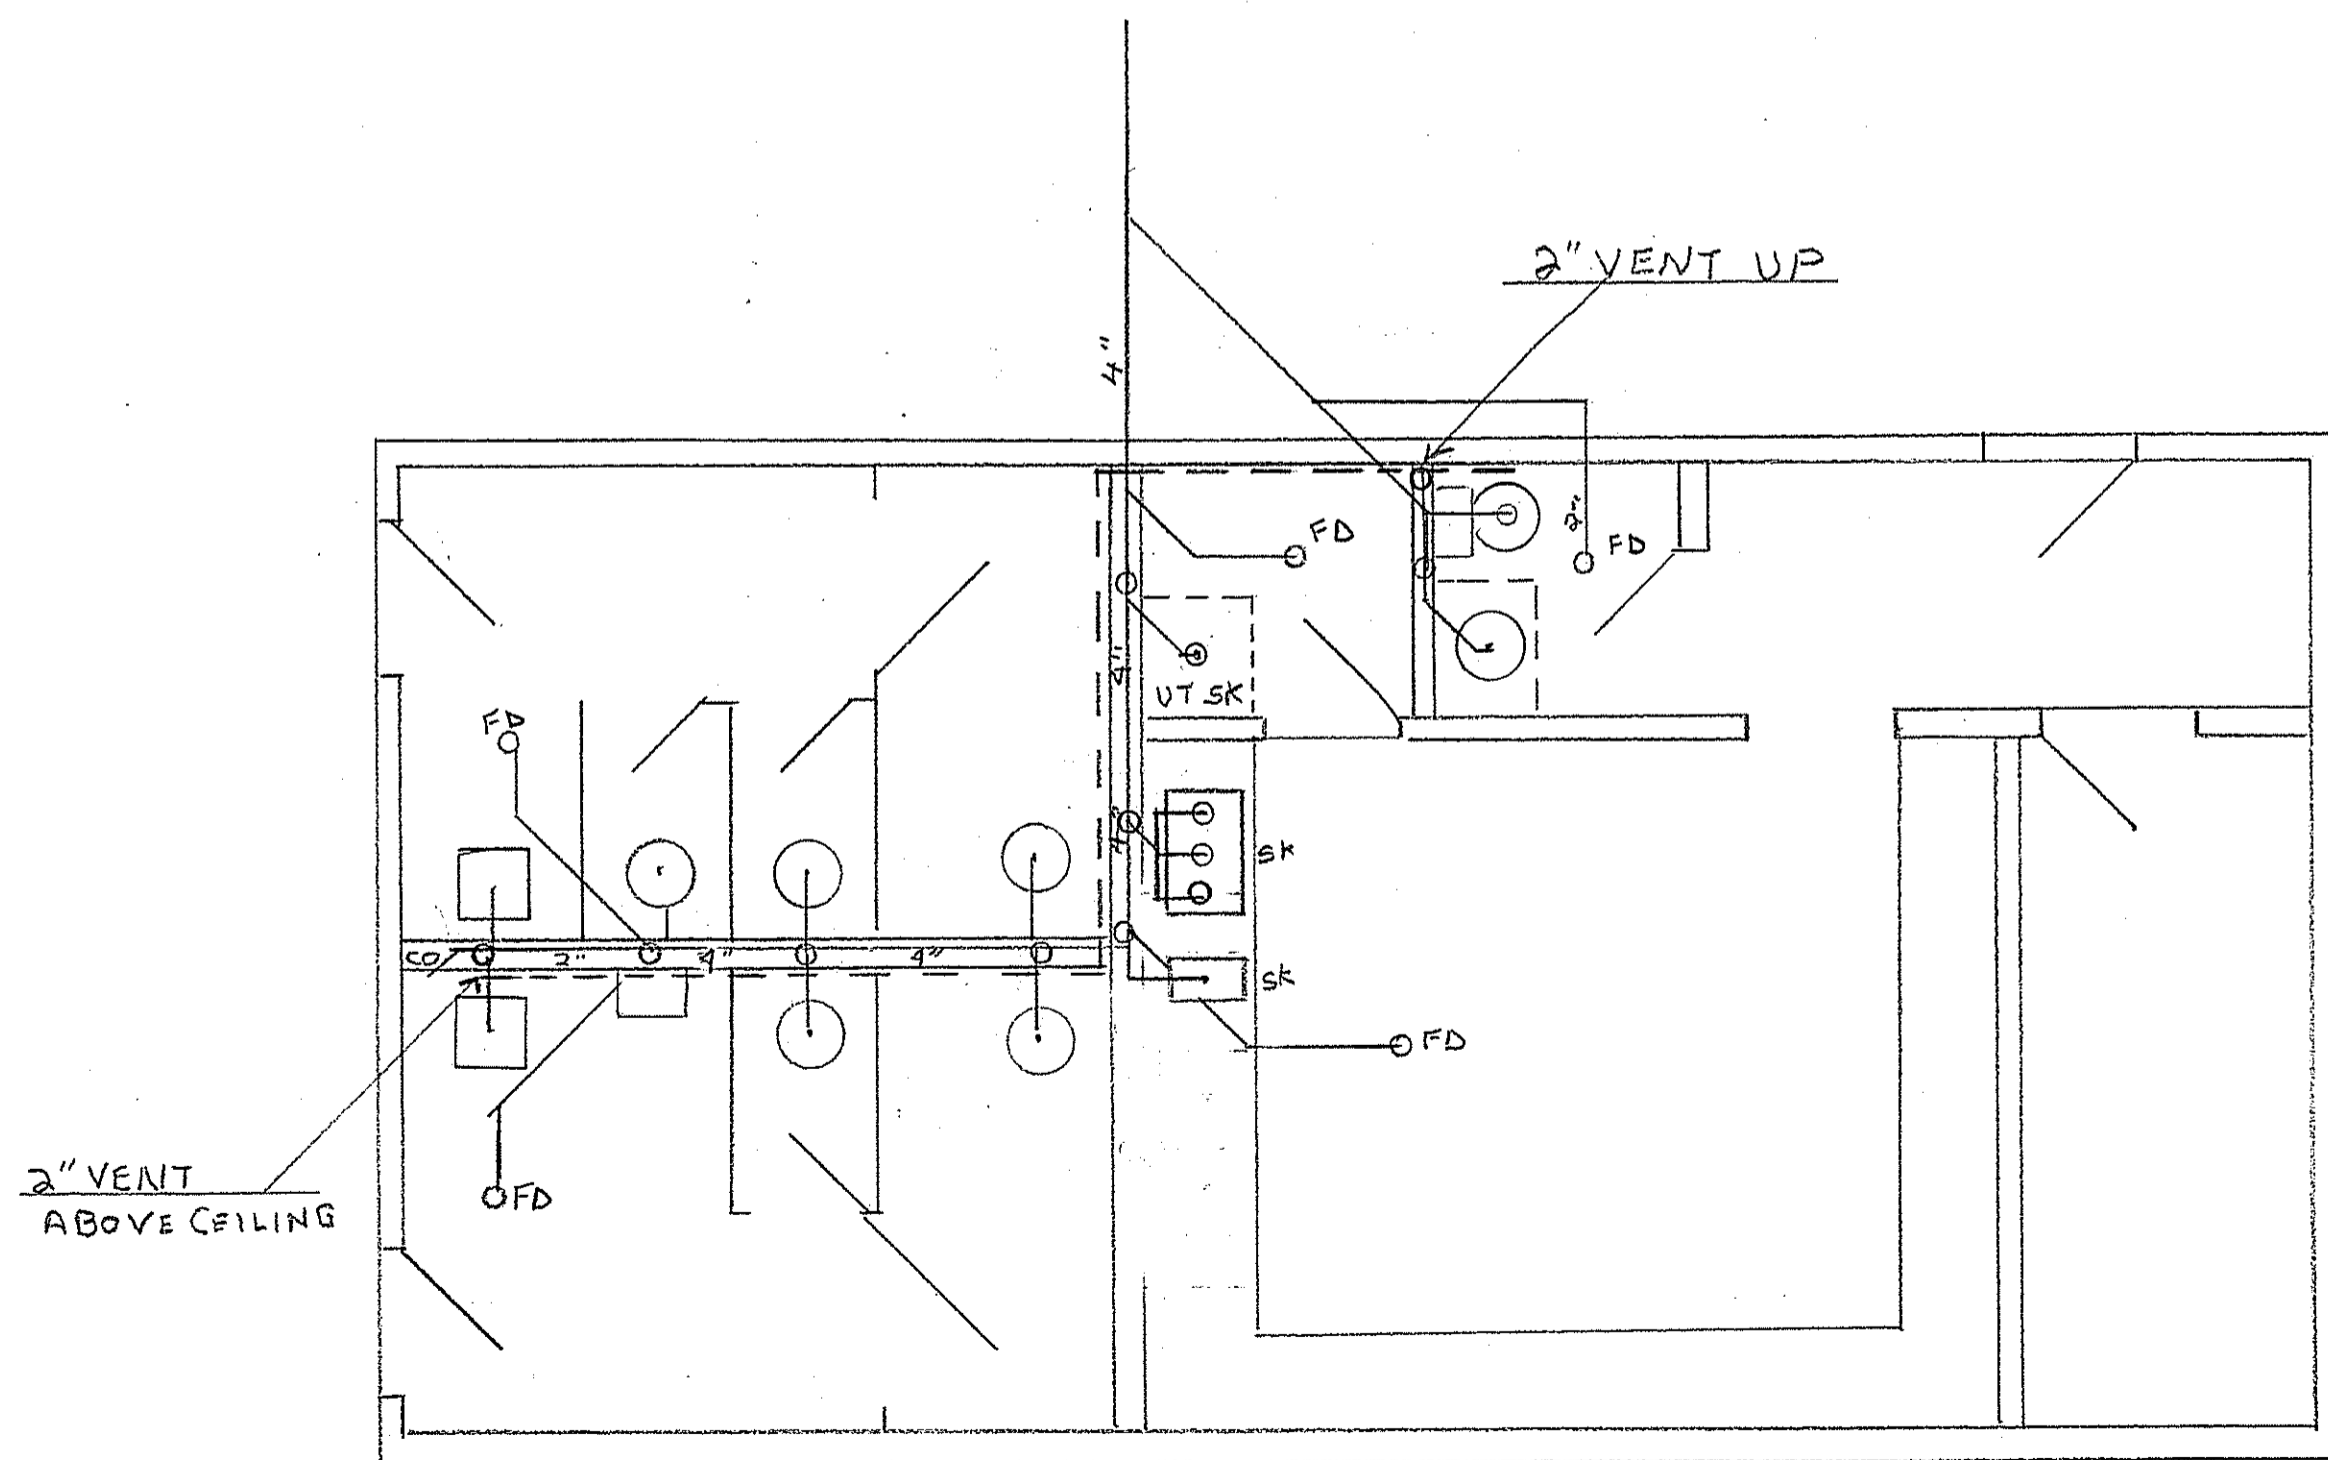

SCALE: 1/4" = 1'	APPROVED BY:	DRAWN BY: <i>[Signature]</i>
DATE: 12-27-10		REVISED:
WASTE & VENT PLAN		DRAWING NUMBER
SCHEMATIC		4