



DEPARTMENT OF PARKS AND RECREATION
 Park Development Division
 2100 Clarendon Boulevard, Suite 414
 Arlington, VA 22201
 Phone: 703.228.3332
 Fax: 703.228.3328

ITB #23-DPR-ITBPW-450

#SWM 22-0224

Project Name and Location
ARLINGTON JUNCTION PARK

FINAL PLAN

1051 SOUTH EADS STREET
 ARLINGTON, VIRGINIA


Sheet Title
MATERIALS PLAN

Approval _____ Date _____
 Design Supervisor _____


Revisions	Date
CEP#1	7/15/2021
CEP#2	12/21/2023
BUILDING PERMIT	02/15/2023
REVISED BUILDING PERMIT	04/20/2023
CEP #4	7/20/2023

Designed: _____
 Drawn: JC, SM
 Checked: SM, CF

Filename: _____
 Plotted: _____
 Scale: AS SHOWN
 Date: 04/20/2023

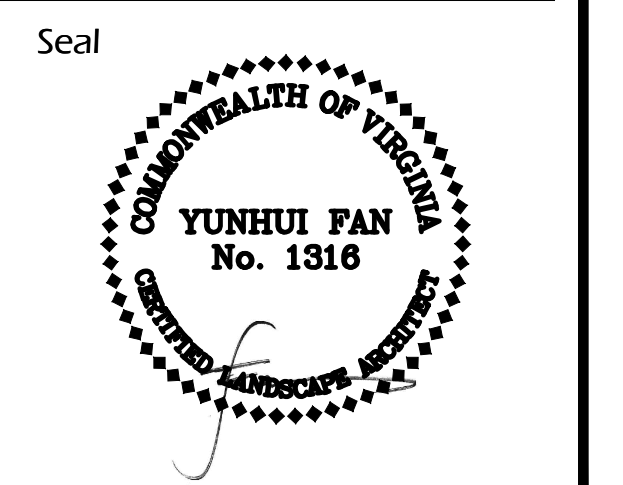

Sheet **L101**

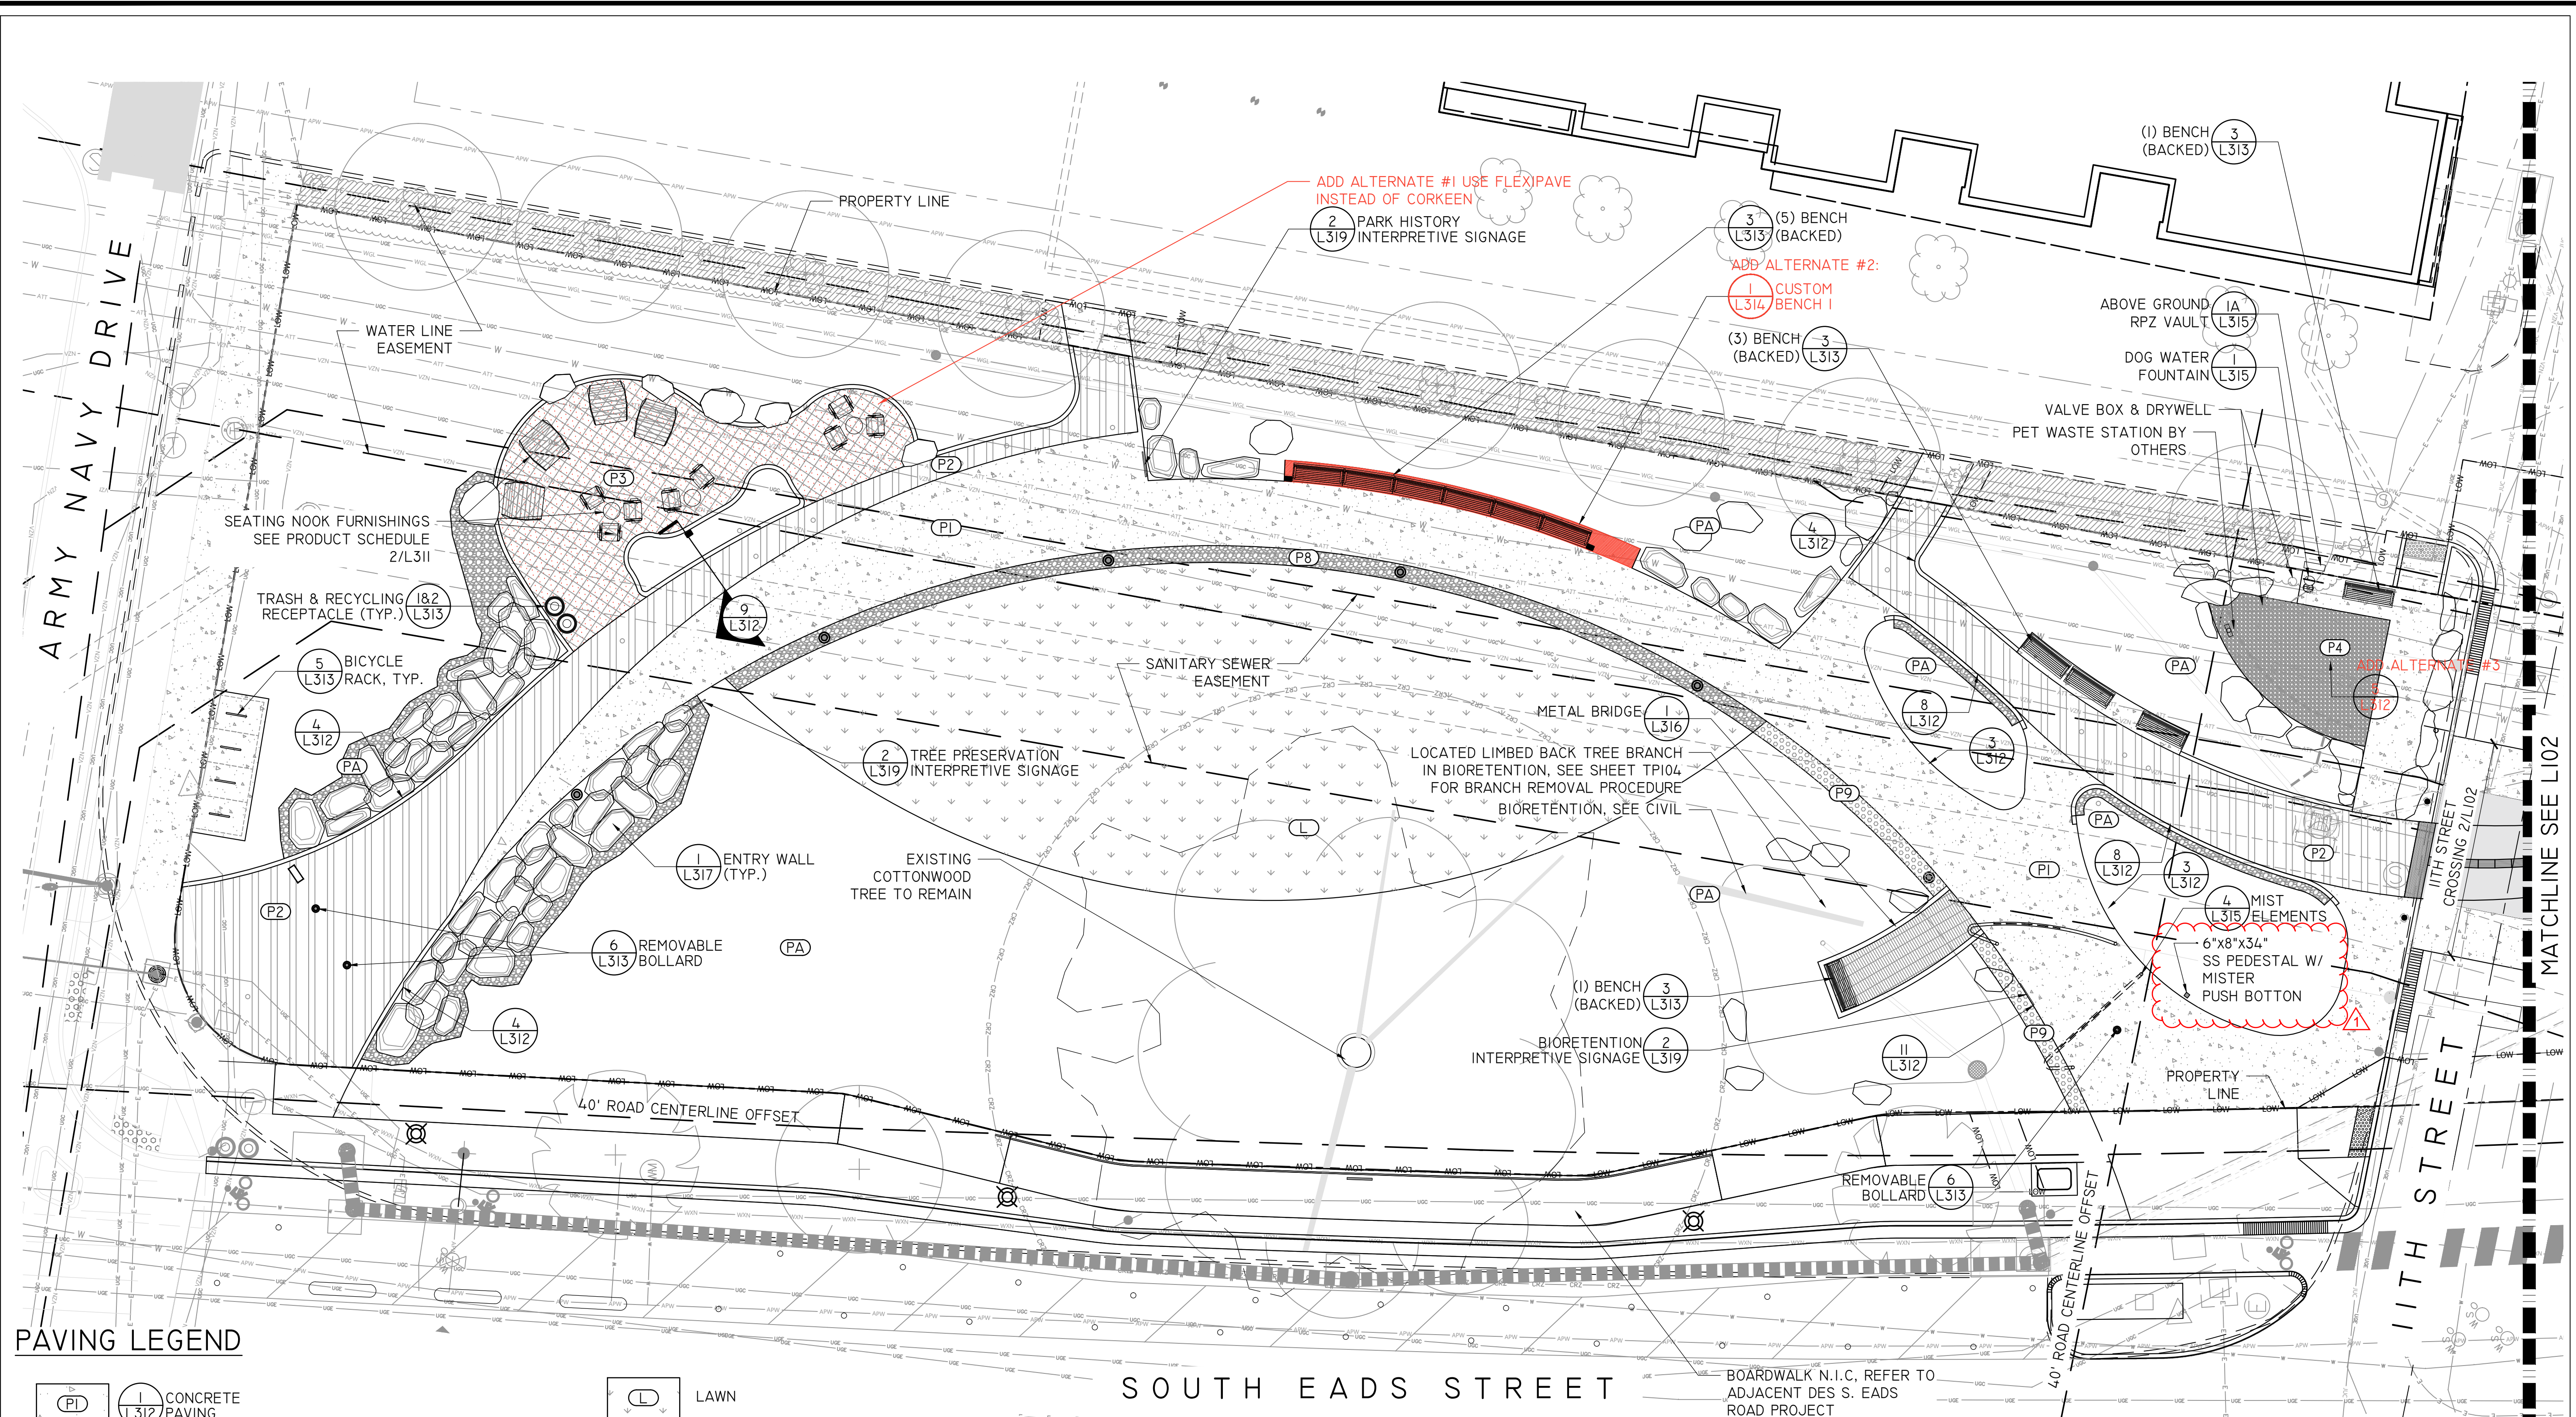

PAVING LEGEND


- 1** CONCRETE PAVING (L312)
- 4** POROUS UNIT PAVING (L312)
- 3** CORKEEN PAVING (L311)
- 3** UNSTABILIZED AGGREGATE PAVING (L311A)
- CONCRETE CROSSWALK. REFER TO CIVIL FOR PAVING CROSS SECTION AND STRIPING**
- 10** GRAVEL GARDEN (L312)
- 7** LONGITUDINAL DIRECTIONAL PAVERS (L312)
- 1** RIVER JACK COBBLE STRIP REFER TO DETAIL (L312)
- 11** GRAVEL FILTER STRIP (L312)
- LAWN**
- PLANTED AREA**
- 5** LANDSCAPE BOULDER TYPE 2 (L317)
- 3** BOULDER TYPE I SIM. (L317)
- 3** FLUSH CONCRETE TURN DOWN EDGE CONDITION (L312)
- 4** FLUSH CURB ADJACENT TO POROUS PAVING (L312)
- 8** RAISED CURB ADJACENT TO POROUS PAVING (L312)
- 9** PLANTER CURB (L312)

LIGHTING/ELECTRICAL LEGEND

- EXISTING POLE LIGHT**
- STREET LIGHTS, REFER TO STREETSCAPE PLANS**
- PLYON AREA LIGHT-REFER TO STRUCTURAL FOR MOUNTING CONDITION**
- BOLLARD LIGHT-REFER TO STRUCTURAL FOR MOUNTING CONDITION**
- INTEGRAL STRUCTURE LEDES**
- PARK POLE LIGHT-REFER TO STRUCTURAL FOR MOUNTING CONDITION**
- POWER PEDESTAL**

ALTERNATES LEGEND

- ADD ALTERNATE #1: FLEXI-PAVE POROUS PAVING (L312)**
- ADD ALTERNATE #2: CUSTOM BENCHES POROUS PAVING (L314)**
- ADD ALTERNATE #3: SYNTHETIC TURF (L312)**

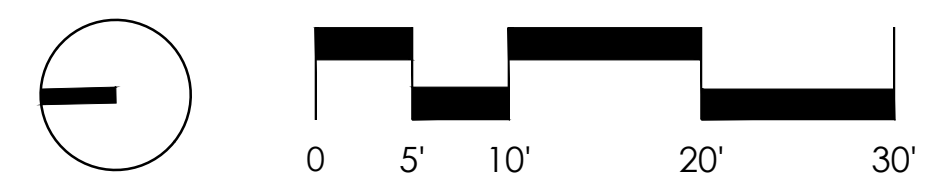

ARLINGTON COUNTY, VIRGINIA
 DEPARTMENT OF ENVIRONMENTAL SERVICES

MATERIALS PLAN
 ARLINGTON JUNCTION PARK-CIVIL ENGINEERING PLAN
 1051 SOUTH EADS STREET
 ARLINGTON COUNTY, VA

SCALE: AS SHOWN SHEET L101