



DEPARTMENT OF PARKS AND RECREATION
 Park Development Division
 2100 Clarendon Boulevard, Suite 414
 Arlington, VA 22201
 Phone: 703.228.3332
 Fax: 703.228.3328

ITB #23-DPR-ITBPW-450

#SWM 22-0224

Project Name and Location
ARLINGTON JUNCTION PARK

FINAL PLAN

1051 SOUTH EADS STREET
 ARLINGTON, VIRGINIA

Sheet Title
LIGHTING PLAN

Approval _____ Date _____
 Design Supervisor _____


Revisions _____ Date _____
 CEP#1 7/15/2021
 CEP#2 12/21/2023
 BUILDING PERMIT 02/15/2023
 REVISED BUILDING PERMIT 04/20/2023
 CEP #4 7/20/2023

Designed: _____
 Drawn: JC, SM
 Checked: SM, CF


Filename: _____
 Plotted: _____

Scale: AS SHOWN
 Date: 04/20/2023

Seal

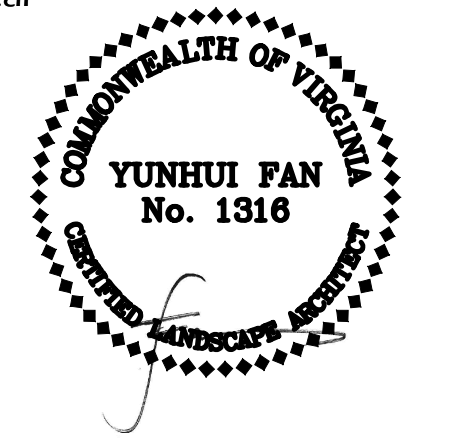


Sheet **L110**

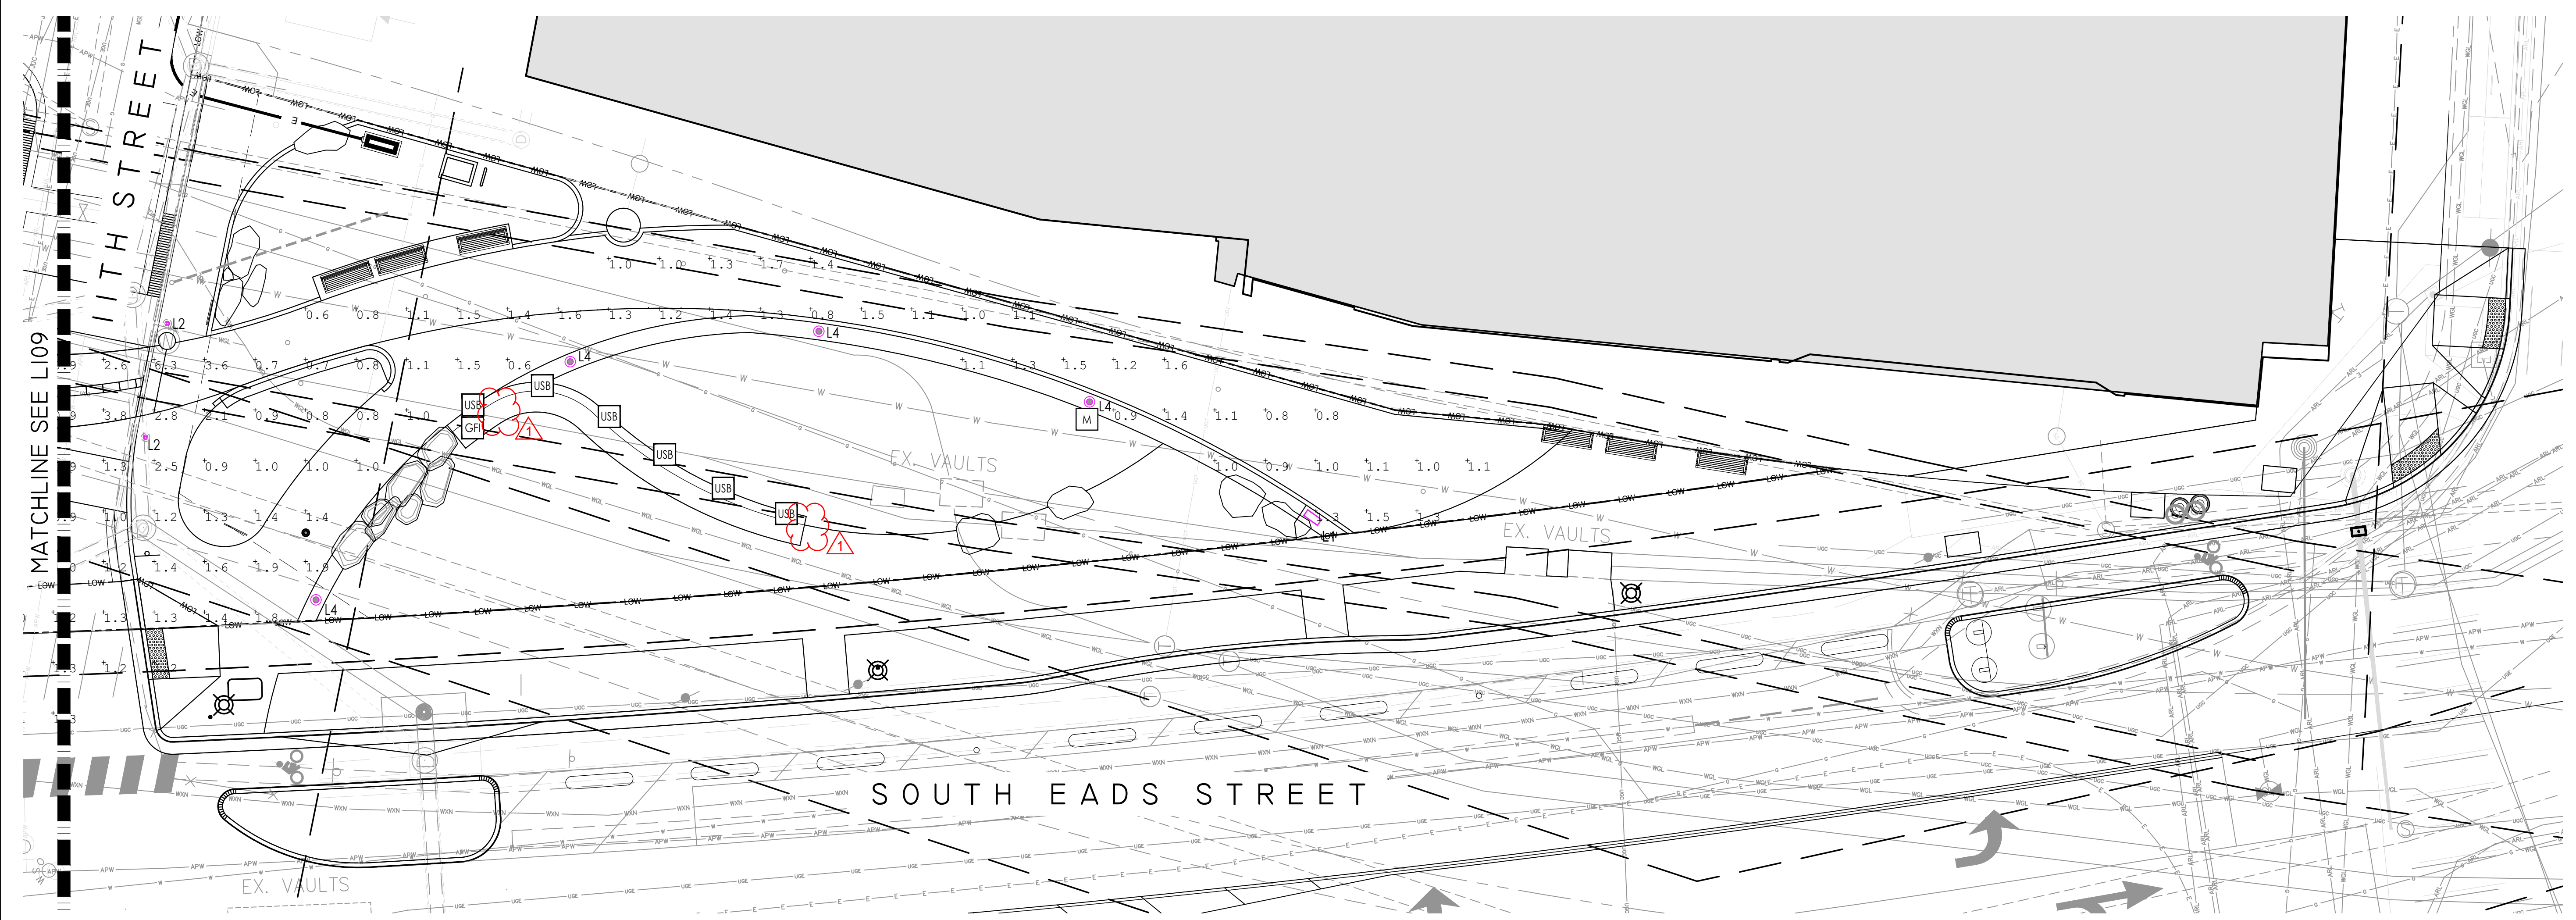

LIGHTING/ELECTRICAL LEGEND

- EXISTING POLE LIGHT
- STREET LIGHTS, REFER TO STREETScape PLANS
- L1 PYLON AREA LIGHT-REFER TO STRUCTURAL FOR MOUNTING CONDITION
- L2 BOLLARD LIGHT-REFER TO STRUCTURAL FOR MOUNTING CONDITION
- L3 INTEGRAL STRUCTURE LEDS
- L4 PARK POLE LIGHT-REFER TO STRUCTURAL FOR MOUNTING CONDITION
- L5 POWER PEDESTAL
- GFI LOCATION
- USB CHARGING OUTLET
- MAINTENANCE OUTLET

LIGHTING/ELECTRICAL SCHEDULE					
TAG	REFERENCE SHEETS	QTY.	DESCRIPTION	PRODUCT NUMBER	SUMMARY
L1	1/L318	2	WAYFINDING PYLON LIGHT	CUSTOM FIXTURE, 15' HEIGHT, 4000K	-
L2	5/L318	4	BOLLARD LIGHT	BEGA 88 060	-
L3	LED ACCENT LIGHTING NOT INCLUDED IN CALCULATIONS				
L4	7/L318	10	PARK POLE LIGHT	BEGA 84 875	-
L5	REFER TO PRODUCT SCHEDULE				
AVG. FC FOR PRIMARY CIRCULATION					1.48 FC
MIN. FC FOR PRIMARY CIRCULATION					0.6 FC

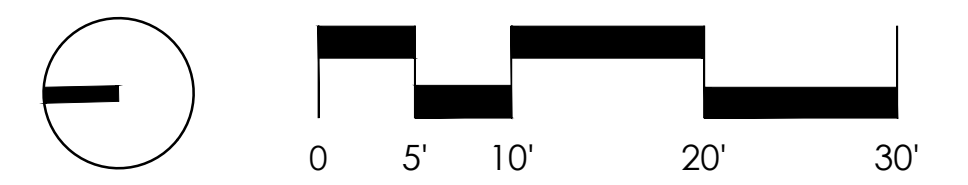

ARLINGTON COUNTY, VIRGINIA
 DEPARTMENT OF ENVIRONMENTAL SERVICES

LIGHTING PLAN
 ARLINGTON JUNCTION PARK-CIVIL ENGINEERING PLAN
 1051 SOUTH EADS STREET
 ARLINGTON COUNTY, VA

SCALE: AS SHOWN SHEET L110