


These drawings are property of Owens and Associates, Inc. Consulting Engineers and may not be used in whole or in part without written consent of the engineer and any infringement is subject to legal action

OVERALL MECHANICAL AND ELECTRICAL ROOF PLAN

SCALE: 1/32"= 1'-0"

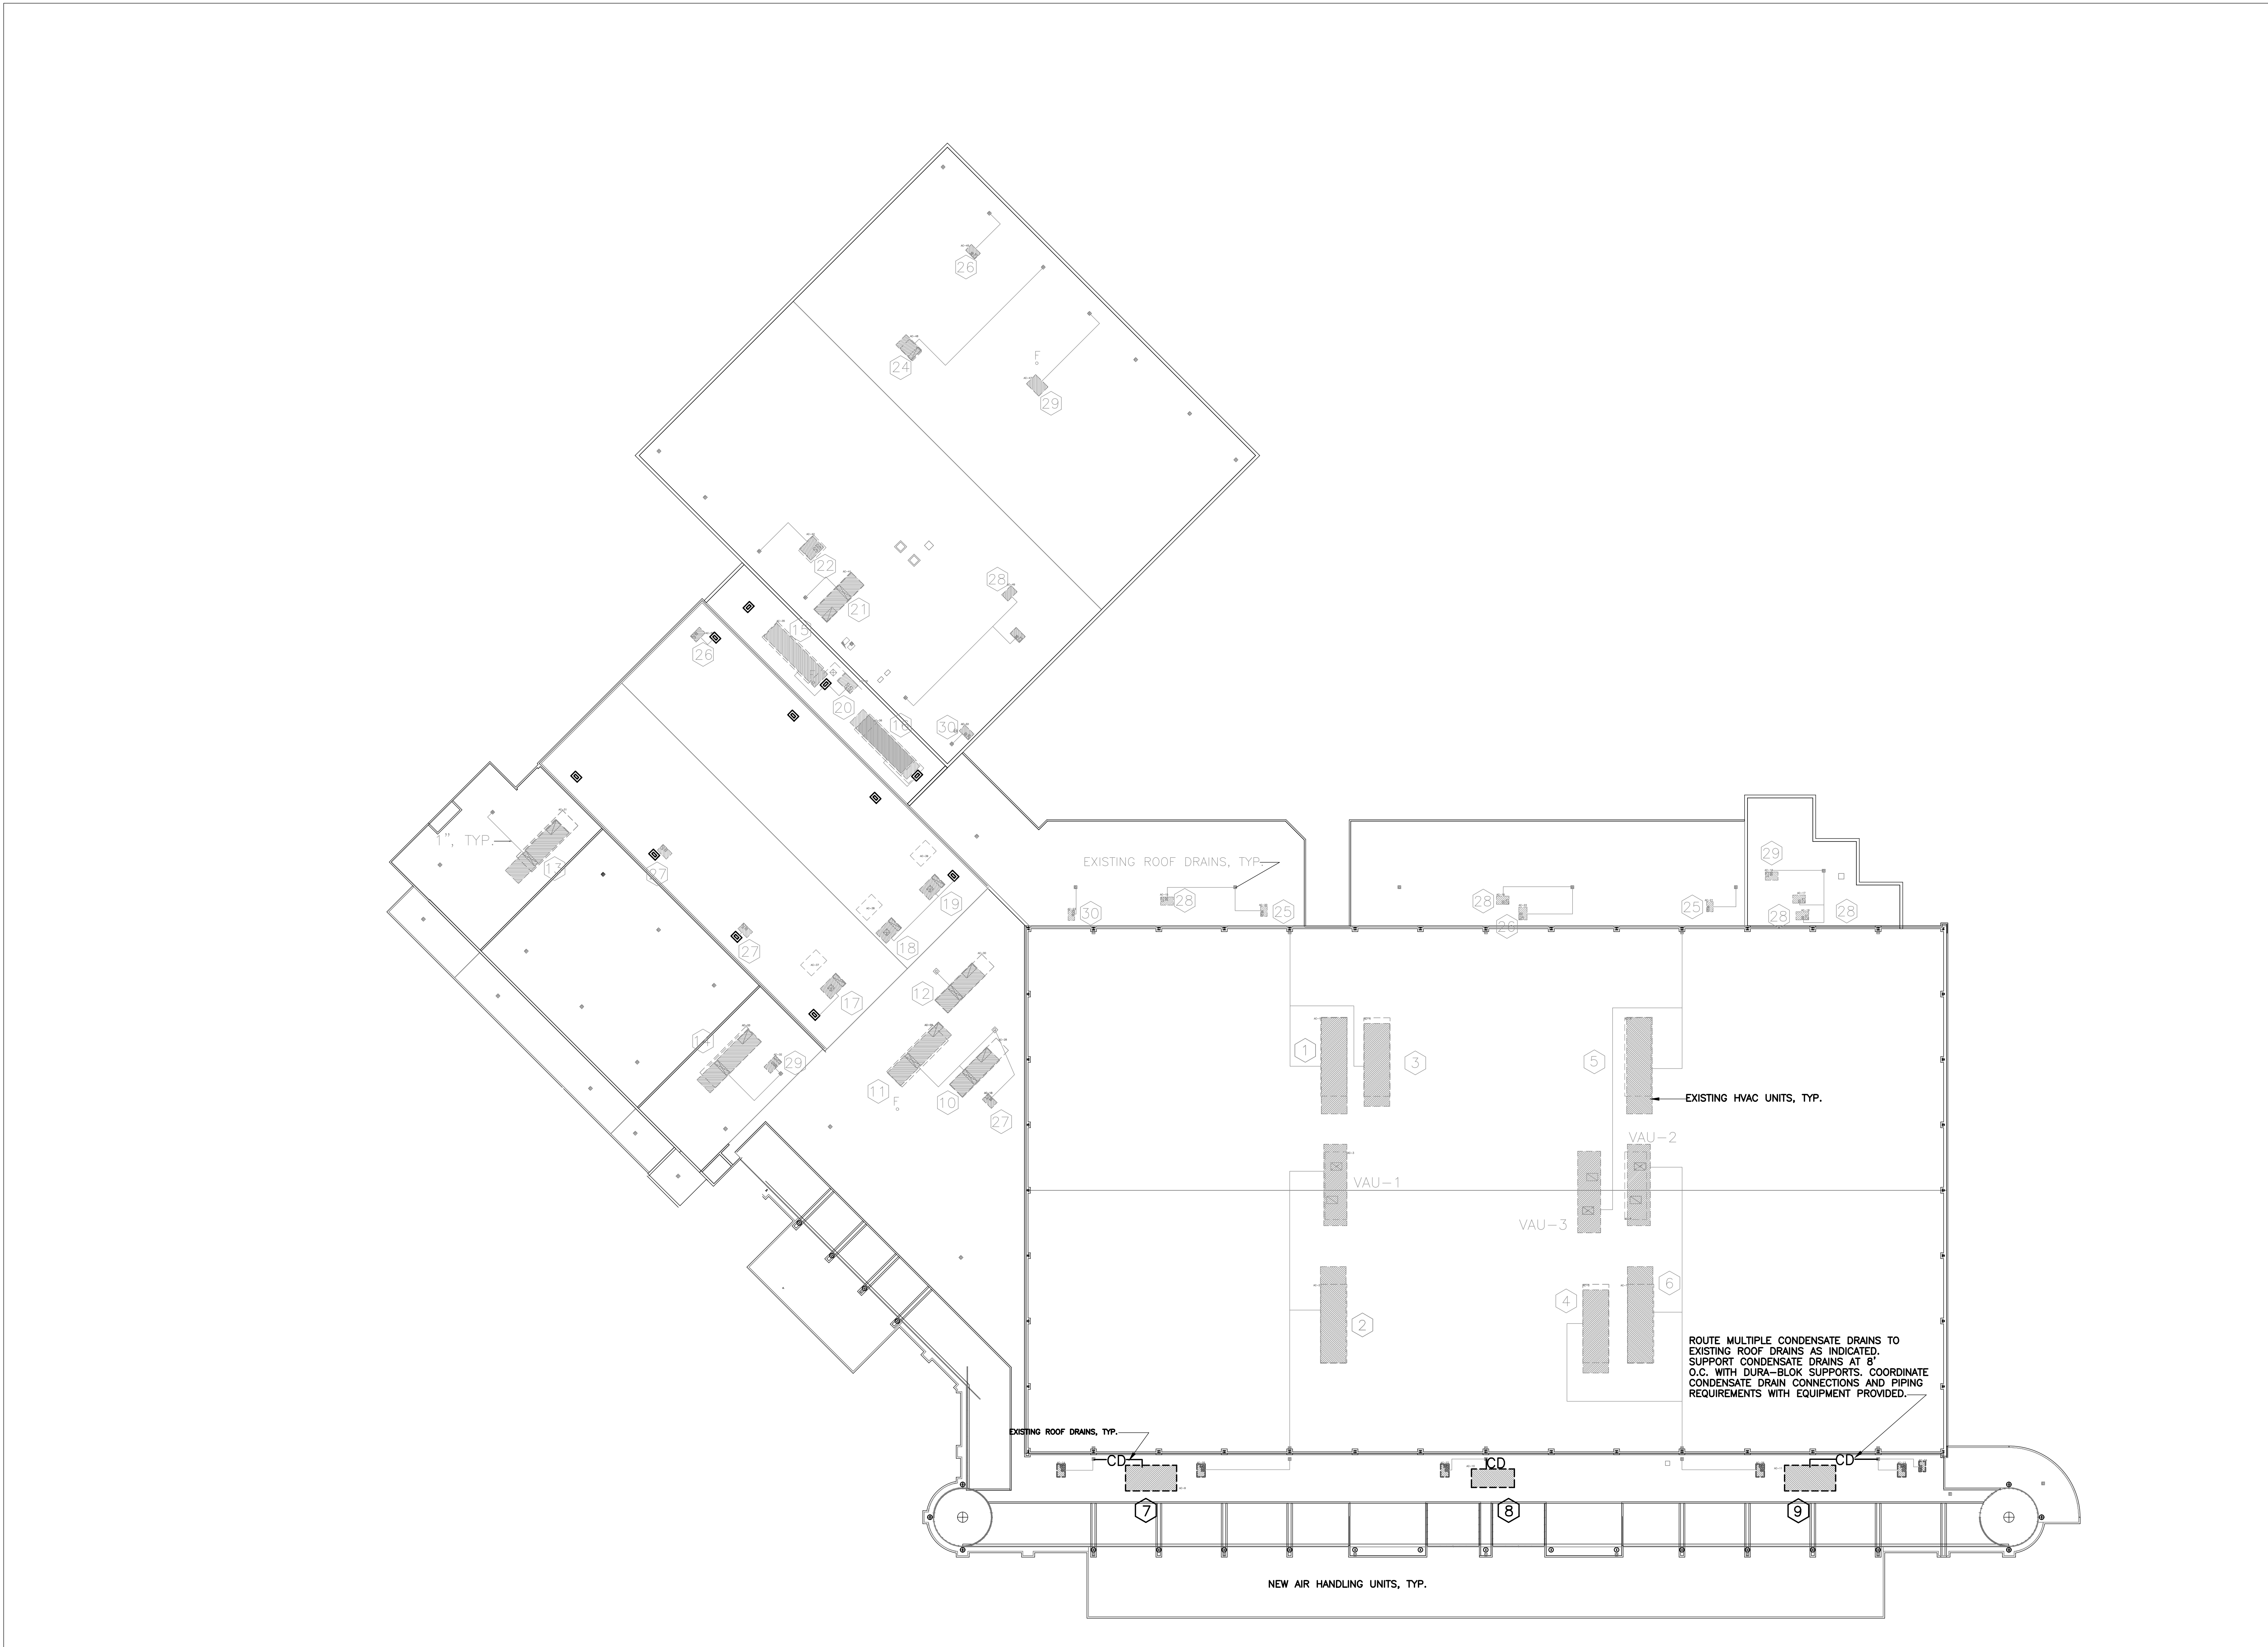

Owens and Associates, Incorporated * Consulting Engineers * 1007 Lake Hunter Circle * Mt. Pleasant, South Carolina 29464 * Telephone: (843) 849 - 6457 * Facsimile: (843) 849 - 6551.

ME-1

project: 1905
date: 06-14-2019

REVISIONS

project:
MECHANICAL RENOVATIONS
AT MYRTLE BEACH
CONVENTION CENTER PH-II
CITY OF MYRTLE BEACH
MYRTLE BEACH, SC 29577

Owens and Associates Inc.,
Inc., consulting engineers
Mt. Pleasant, South Carolina

OWENS AND ASSOCIATES, INC.
CONSULTING ENGINEERS

