



These drawings are property of Owens and Associates, Inc. Consulting Engineers and may not be used in whole or in part without written consent of the engineer and any infringement is subject to legal action

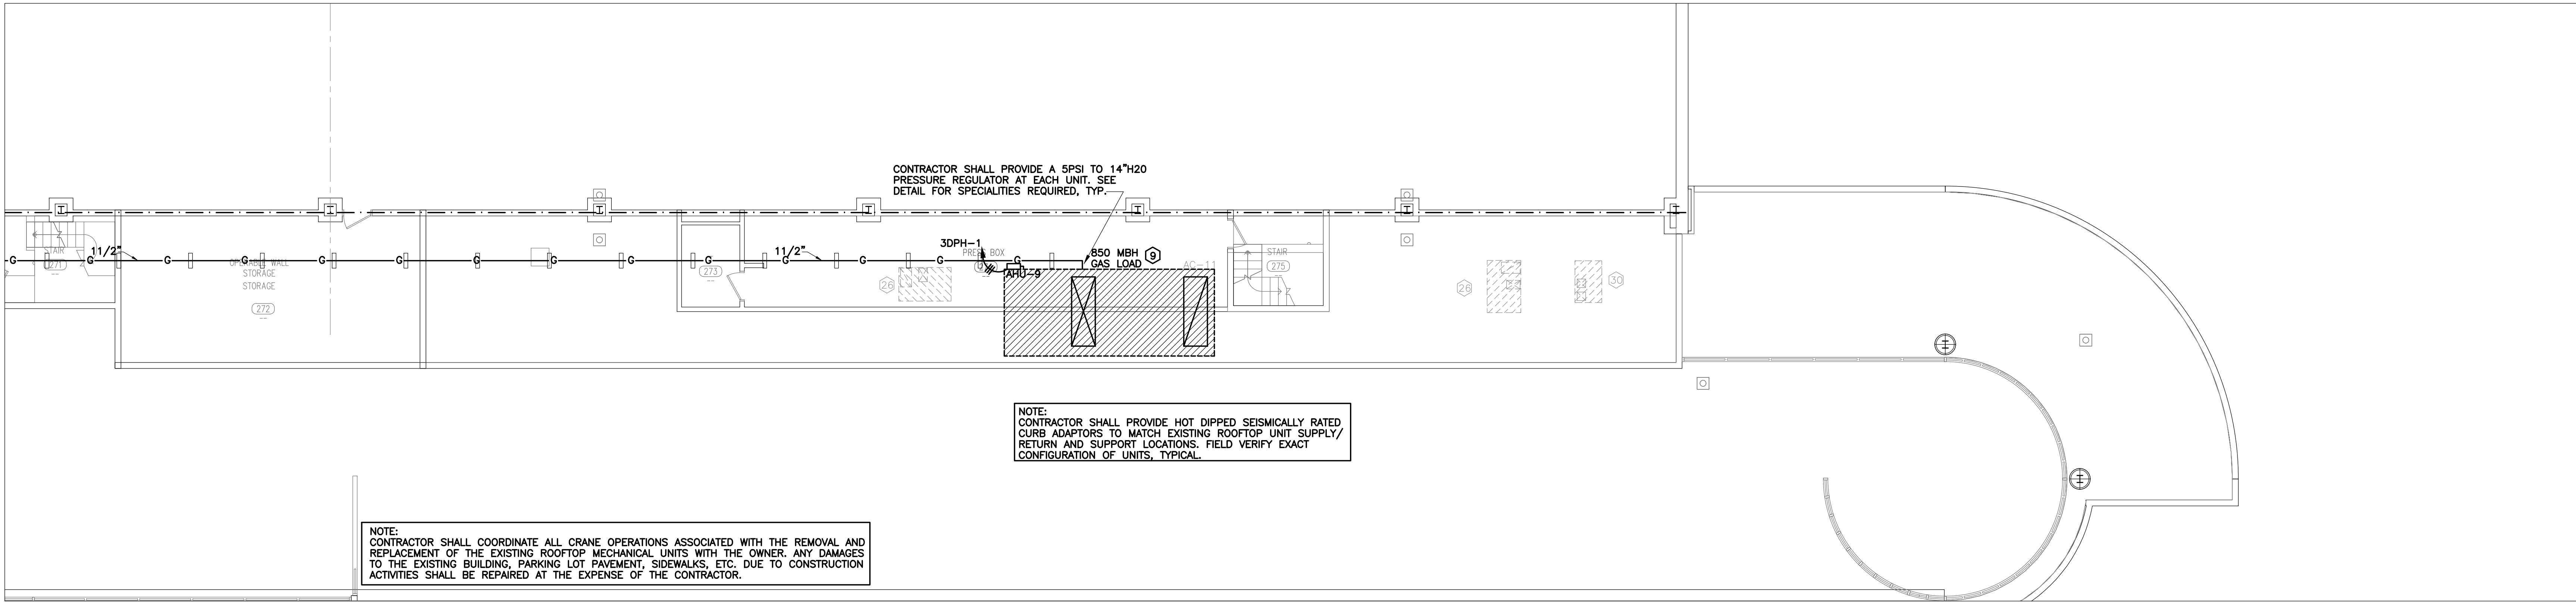


MECHANICAL AND ELECTRICAL FLOOR PLAN - MAIN CONCOURSE/PREFUNCTION NORTH

SCALE: 1/8"= 1'-0"

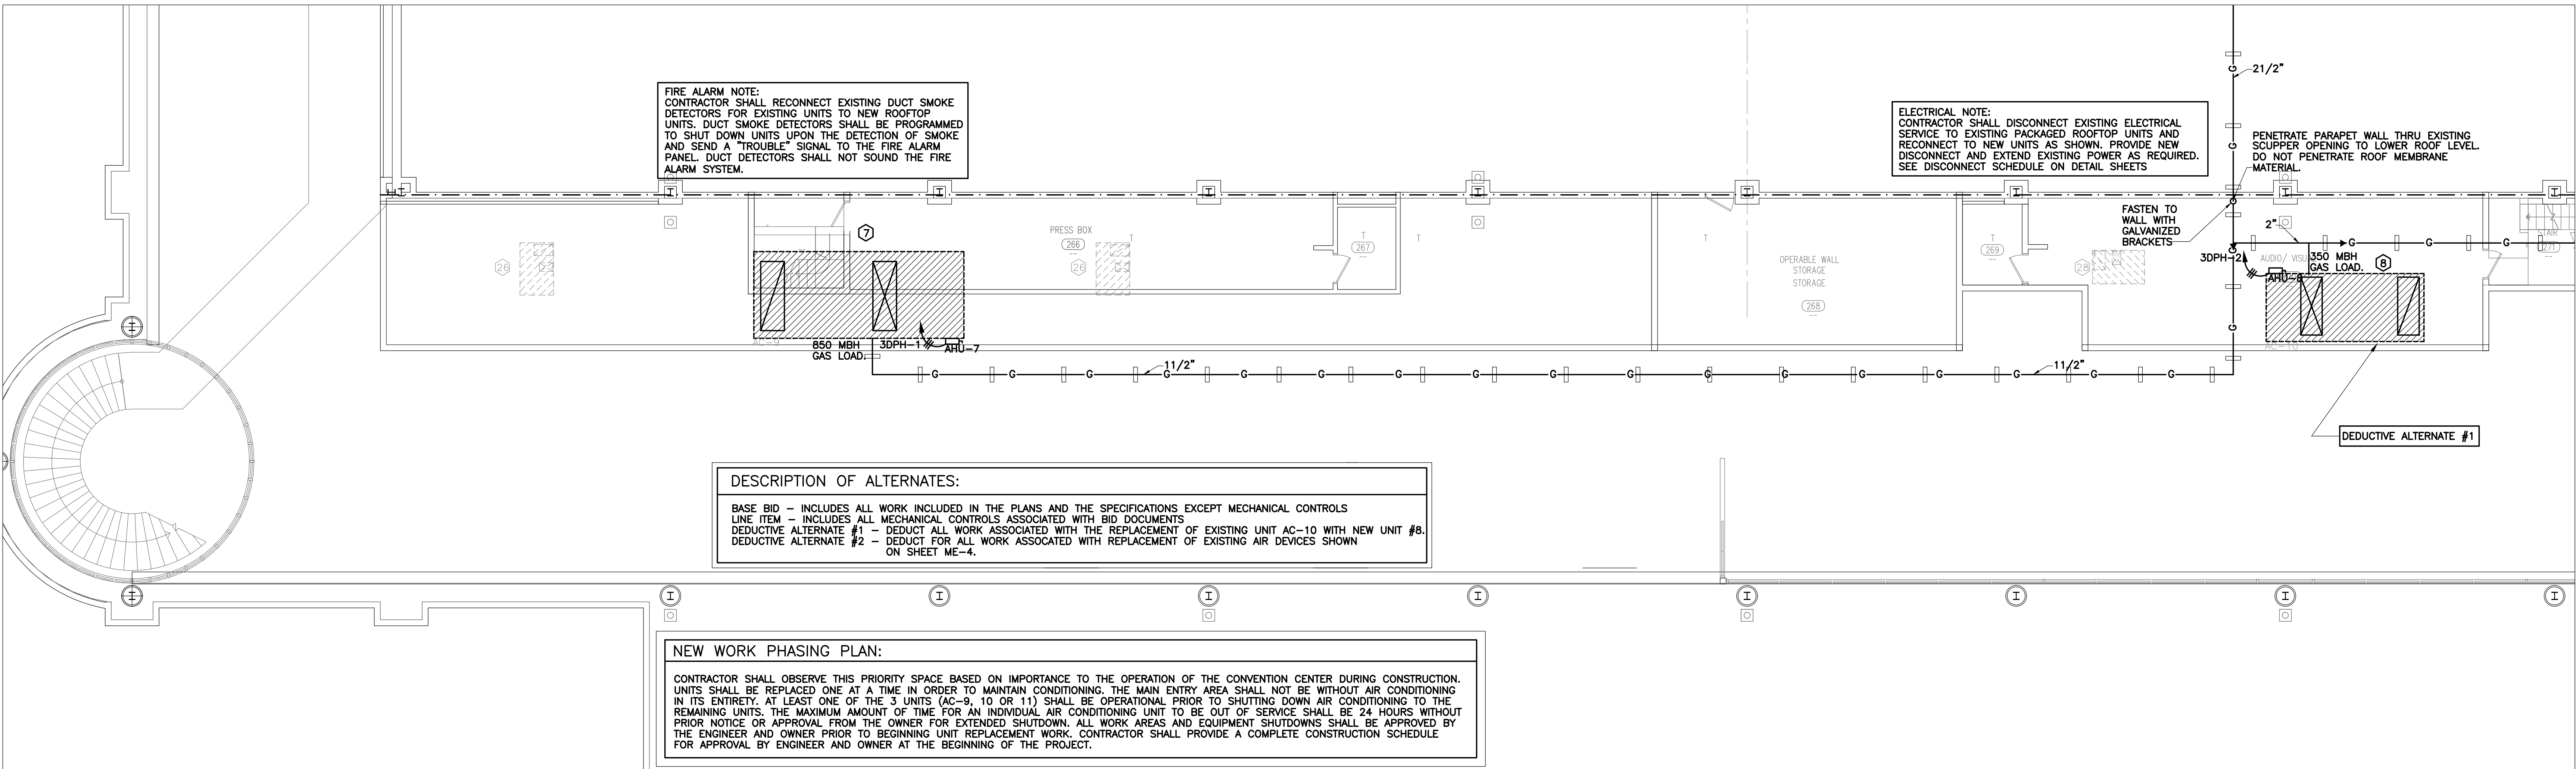


MECHANICAL AND ELECTRICAL FLOOR PLAN - MAIN CONCOURSE/PREFUNCTION SOUTH

SCALE: 1/8"= 1'-0"

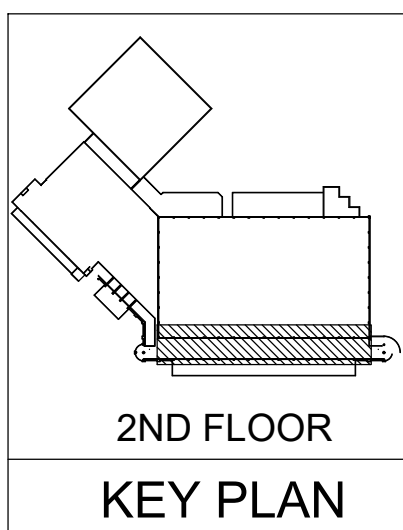

Owens and Associates, Incorporated * Consulting Engineers * 1007 Lake Hunter Circle * Mt. Pleasant, South Carolina 29464 * Telephone: (843) 849 - 6457 * Facsimile: (843) 849 - 6551.

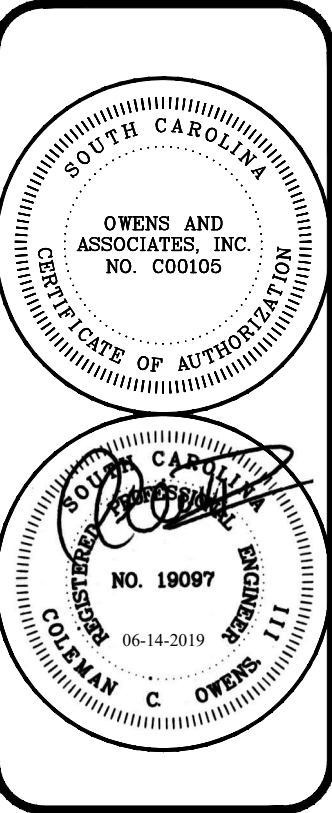

Owens and Associates Inc.,
Inc., consulting engineers
Mt. Pleasant, South Carolina

project:
MECHANICAL RENOVATIONS
AT MYRTLE BEACH
CONVENTION CENTER PH-II
CITY OF MYRTLE BEACH
MYRTLE BEACH, SC 29577

REVISIONS

project: 1905
date: 06-14-2019

ME-3