


HEATER PLAN
1/4" = 1'-0"

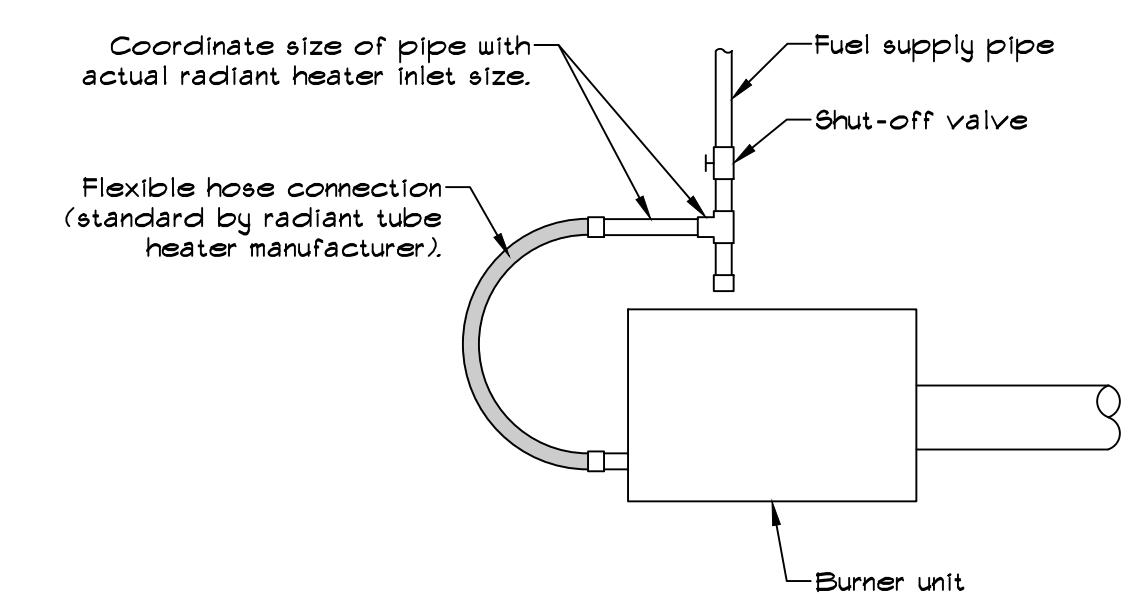


FUEL SUPPLY CONNECTION DETAIL
1" = 1'-0"

636-584-0540 (tel.)
636-584-0512 (fax)
mal@ochran.com



Missouri State Certificate of Authority Numbers:
Survey: 000380
Engineering: 001655
Architecture: 2002014240

Three working days prior to the start of any excavation call 1-800-485-8712 for utility location information.
All OSHA rules & regulations and applicable state and local construction regulations shall be strictly followed (i.e. trenching, blasting, etc.).

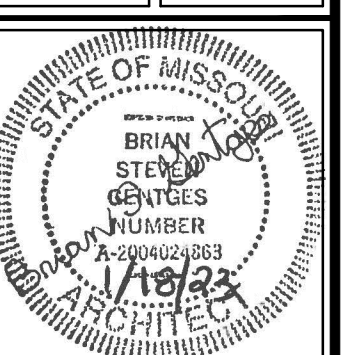

Brian S. Gentges, Architect
MO# A-2004024863

NEW HEATING SYSTEM
Existing Warehouse
Franklin County Sheriff's Department
Franklin County, Missouri

DATE	REVISION	DESIGN BY	APPROVED BY
		BSG	BSG
		DATE:	01/18/2023
		SCALE:	AS NOTED
		PROJ. NO.:	23-9440
		DWG. NO.:	

HEATING PLAN