


PERALTA COMMUNITY COLLEGE DISTRICT  
**LANEY COLLEGE ATHLETIC  
FIELDS & FIELD HOUSE**  
DSA INCREMENT 3  
900 FALLON ST. OAKLAND, CA  
DSA APPLICATION # 01-110972, File # 1-C1  
PCPD PROJECT # 02338

**INC # 3**  
IDENTIFICATION STAMP  
DIVISION OF THE STATE ARCHITECT  
APR 11 11 09 7 3  
A  
D  
M  
P  
E  
C  
H  
A  
N  
I  
C  
A  
L

65% PROGRESS	11-16-09
EBMJD SUBMITTAL	01-20-10
90% REVIEW SET	01-26-10
DSA SUBMITTAL	02-05-10
DSA RE-SUBMITTAL	06-30-10
SHEET DATA	
DATE:	03-12-10
JOB NO.:	1108-0140
PHASE:	CDS
ISSUED FOR:	BID SET
SCALE:	AS SHOWN
SHEET TITLE	


**ELECTRICAL  
SITE PLAN**  
RECEIVED  
SEP 21 2010  
CALIFORNIA BOARD OF ARCHITECTURE

SHEET NUMBER  
**E1.01**

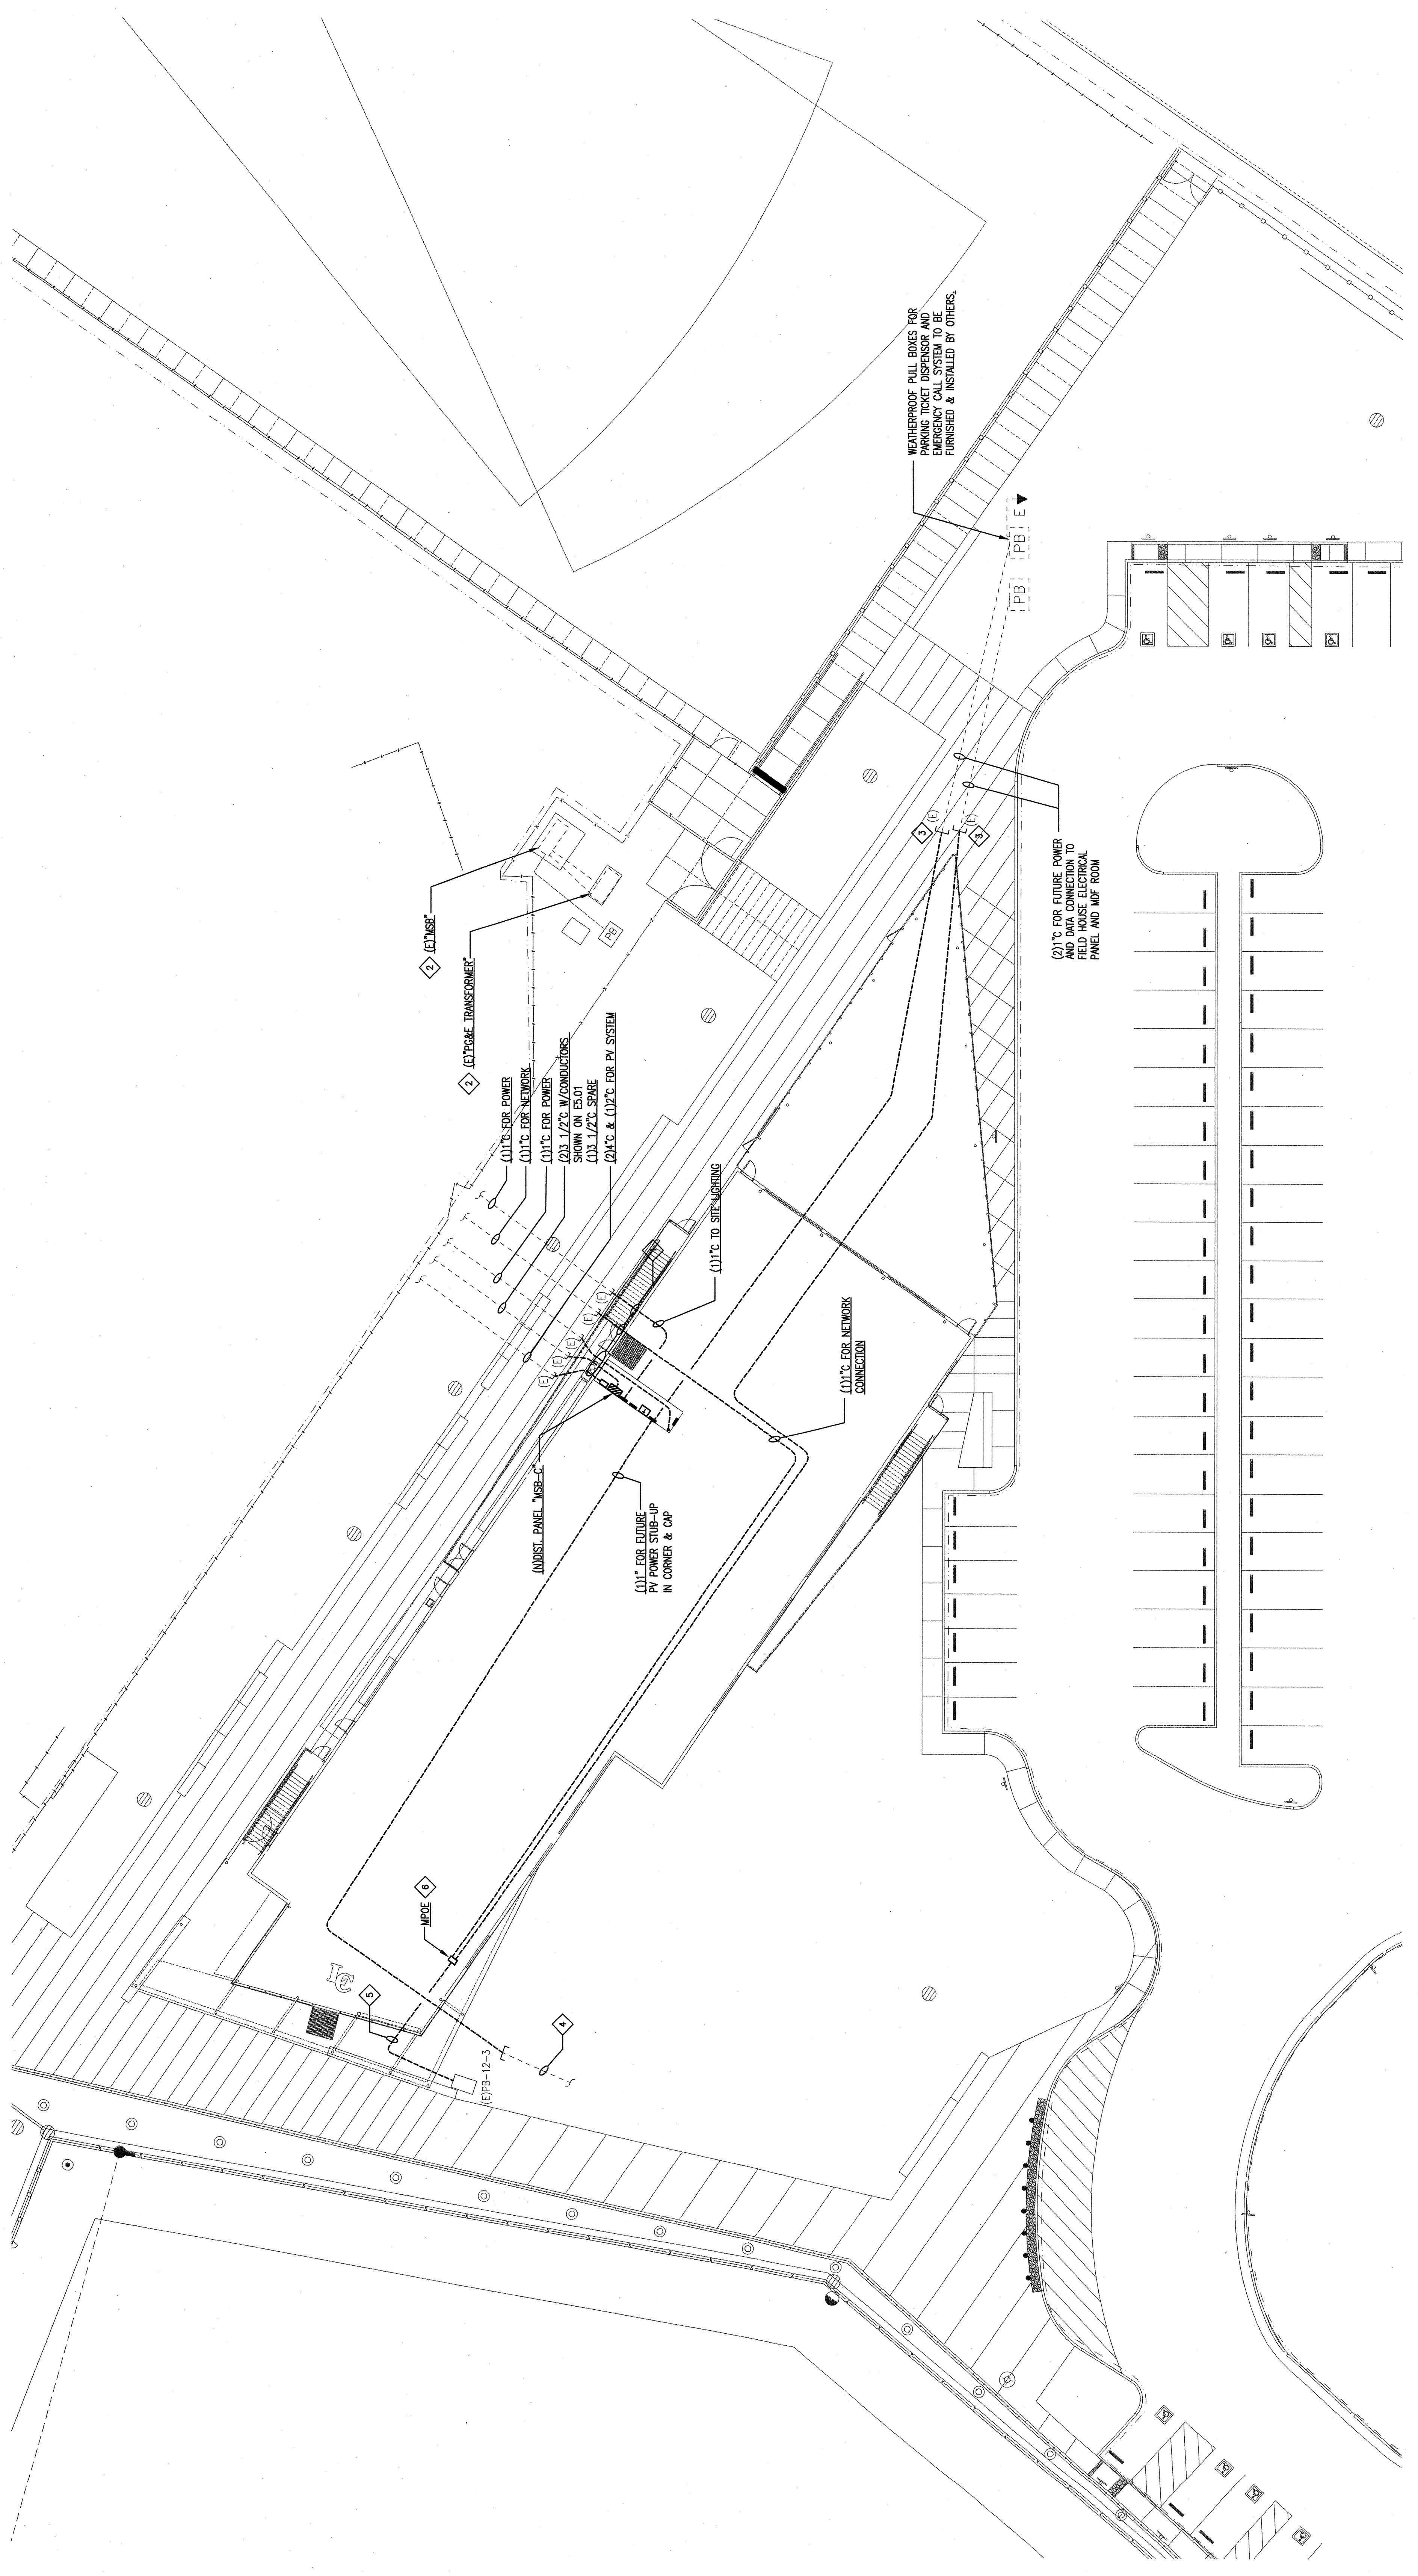

**SHEET NOTES**

- EXTEND (E) CONDUITS PROVIDED UNDER INCREMENTS 1 & 2.
- "MSB" & "PANEL TRANSFORMER" INSTALLED UNDER INCREMENT #2.
- EXTEND (E) CONDUITS TO NEW BUILDING. DATA CONDUIT SHALL BE RUN TO MUF AND POWER CONDUITS TO PANEL "JA".
- EXTEND (E) 1" CONDUIT TO PANEL "JA".
- EXTEND (E) (4)" CONDUITS TO TELEPHONE ROOM.
- DATA CHASE AS SHOWN ON EXD01.

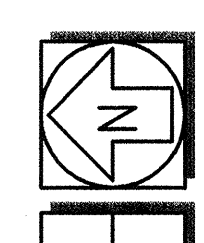

**A SITE PLAN**  
SCALE: 1/8" = 1'-0"

**E1.01**