



**HIGHLANDS COUNTY
BOARD OF COUNTY COMMISSIONERS
(HCBCC)
PURCHASING DIVISION**

DATE: May 15, 2019

BID NO. FWQ 19-012

ADDENDUM No. 1

Project: Water Jetting and Video Inspection of Leachate Collection Lines

This addendum is being issued to address questions received.

Changes to the solicitation:

1. All Bidders must provide evidence of 5 years' experience in cleaning and video taping of the leachate collection pipes and provide a minimum of 3 previously completed projects involving the cleaning and video taping of leachate pipes or current contracts involving similar work. Include a contact person and information (phone and email) for each completed project reference in the last 5 years.
2. Attached are plans of piping. Cell 1 was divided into an east half called Cell 1A and west half called cell 1B. Cell 3 was divided into 3 sections (3A, 3B and 3C) going north to south. See attachments to this addendum listed below.

1. Arbuckle Master Plan of site.

Plans showing header pipes of 6" or 8" at the following elevations in respective cells:

2. Piping System Cell 1 A & 1 B at 132 feet for leachate recir.sys.
3. Piping for system Cell 1A at el 114
4. As built for Cell 3 A at el 102
5. As Built for Cell 3 A at el 104
6. As built for Cell 3 C at el 102

Attachments:

Cell 3A at 102 plans

Cell 3B at el 102

Questions and Answers

1. Will the county consider changing the minimum requirements to 5 years?


Answer: Yes, see item 1 above changing the requirements to 5 years' experience but also requiring a minimum of three (3) references.

2. Can we review the leachate collection system drawings?

Answer: Yes, they are attached to this addendum.



3. May I know how much is the estimated budget for this project?

Answer: \$10,000

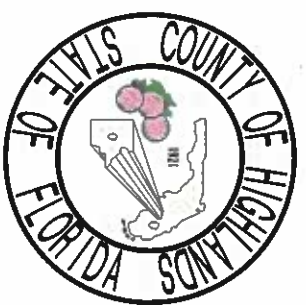

HIGHLANDS COUNTY SOLID WASTE MANAGEMENT CENTER

 
SITE MASTER PLAN

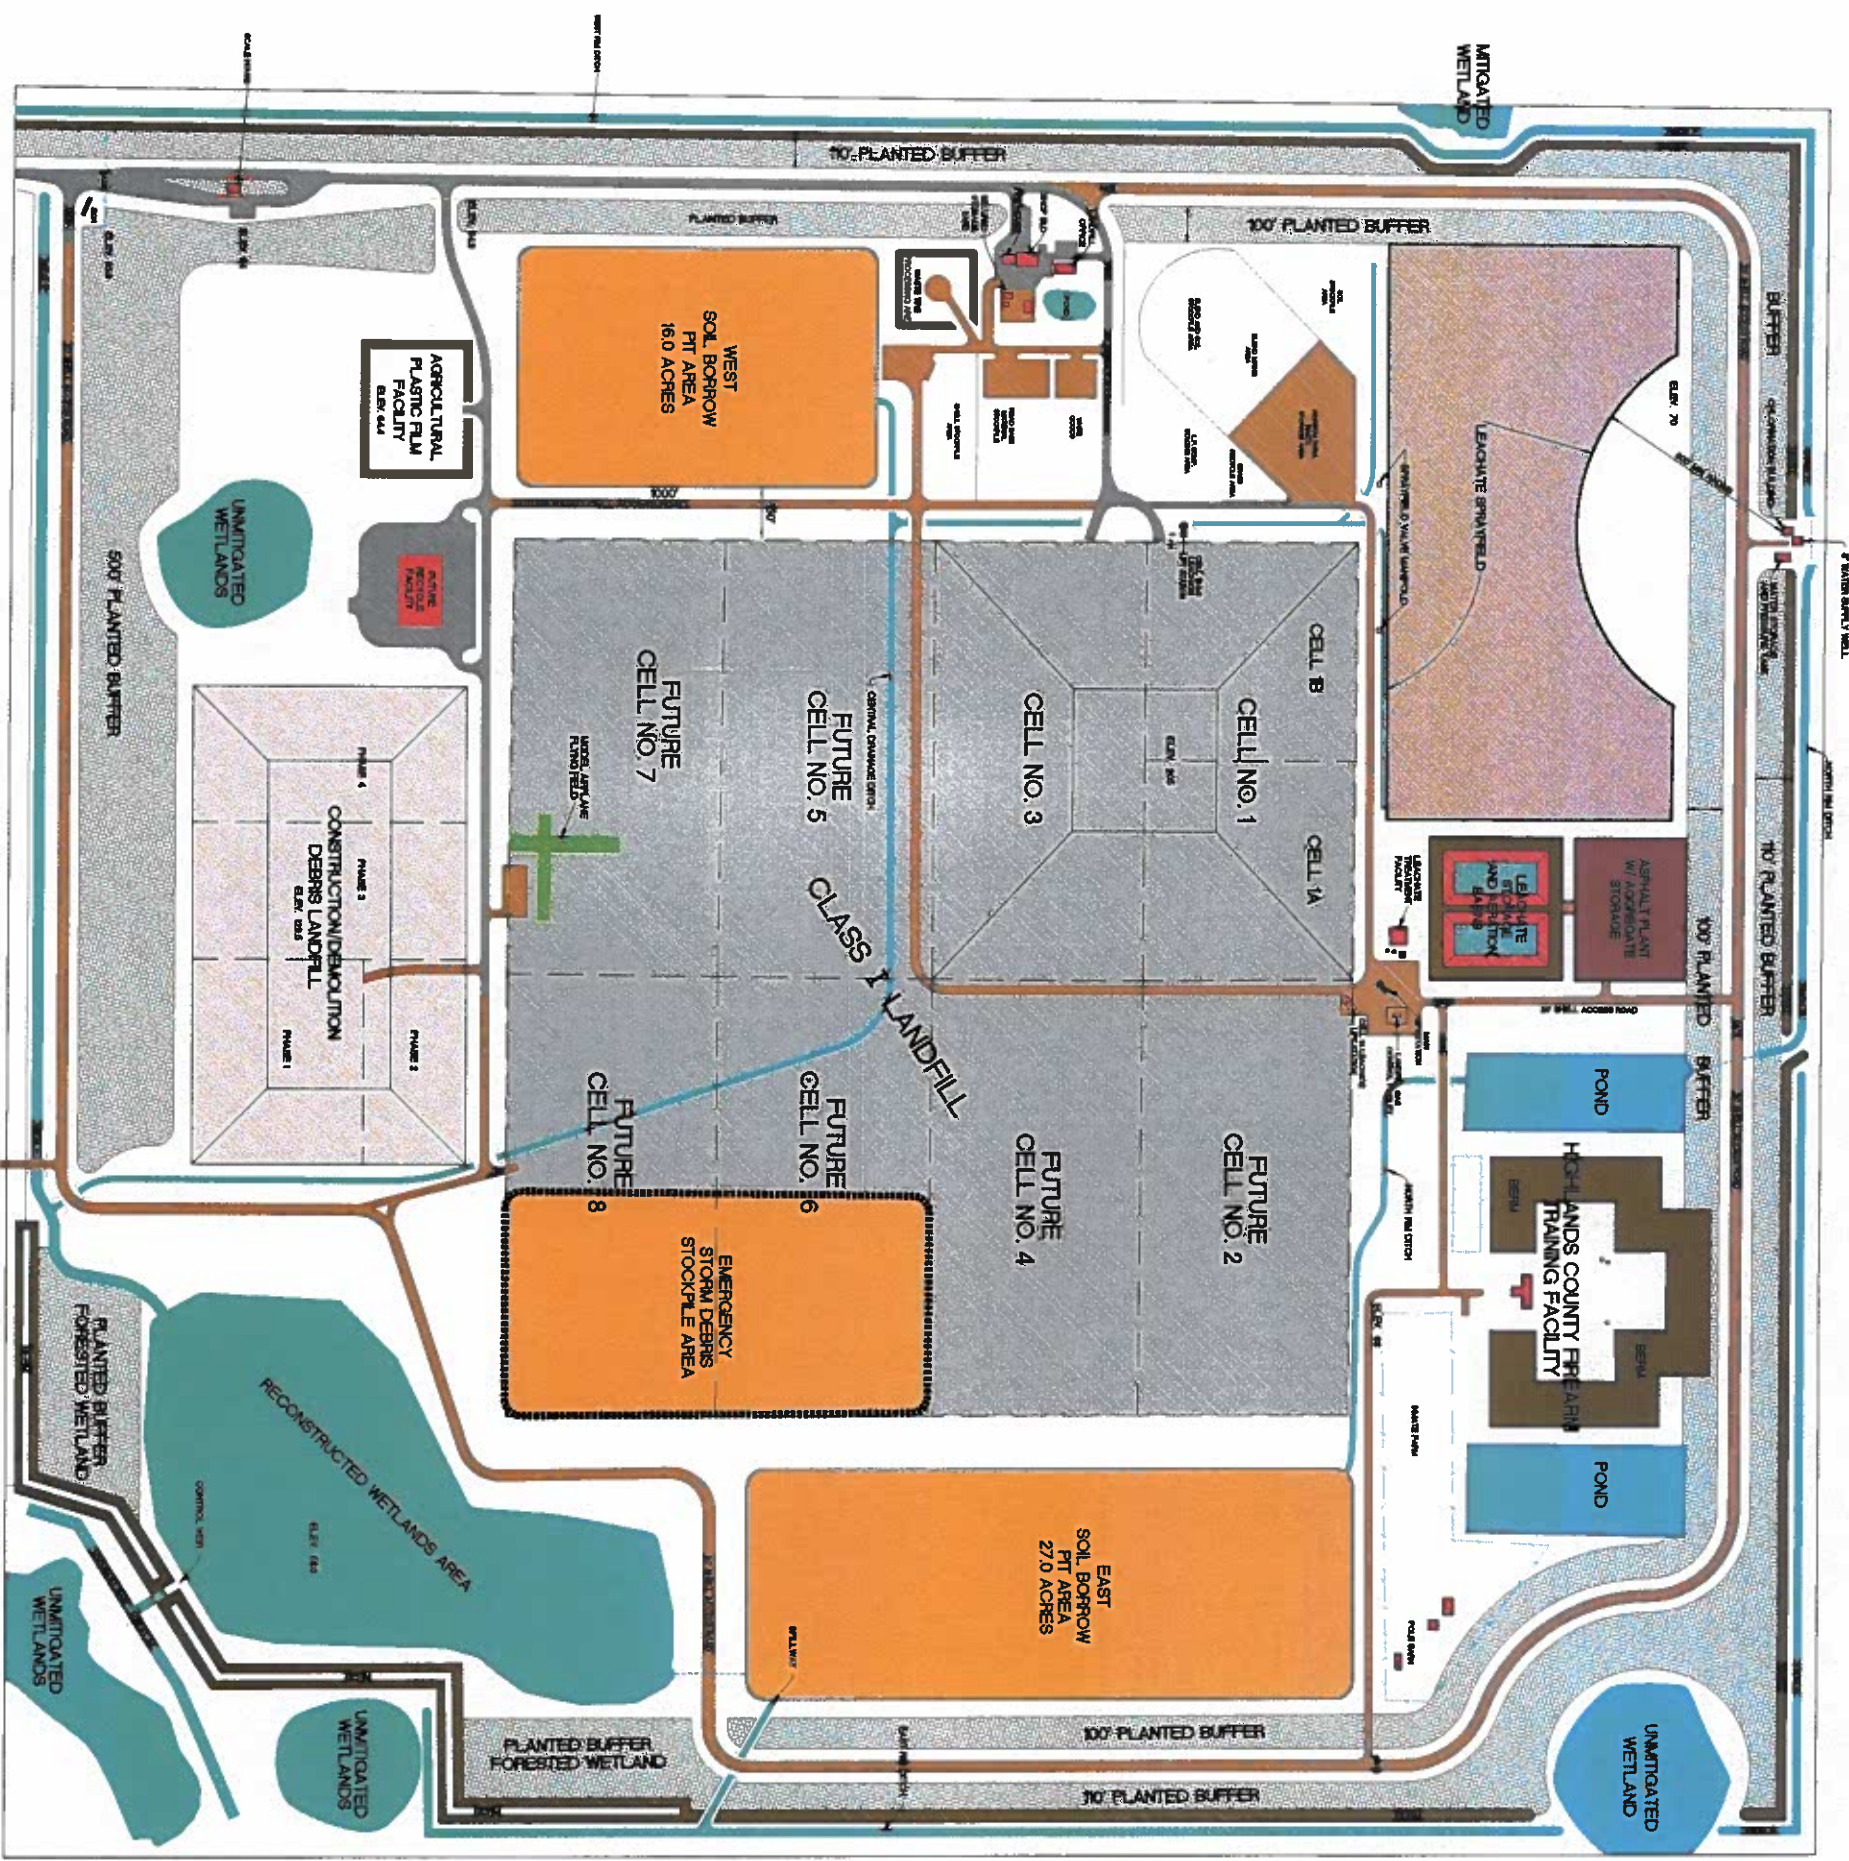


MARCH 2008



P:\176077C-AD\ENR\1716077 exhibit1.dwg, 12/22/2003 11:02:12 AM, bettyf

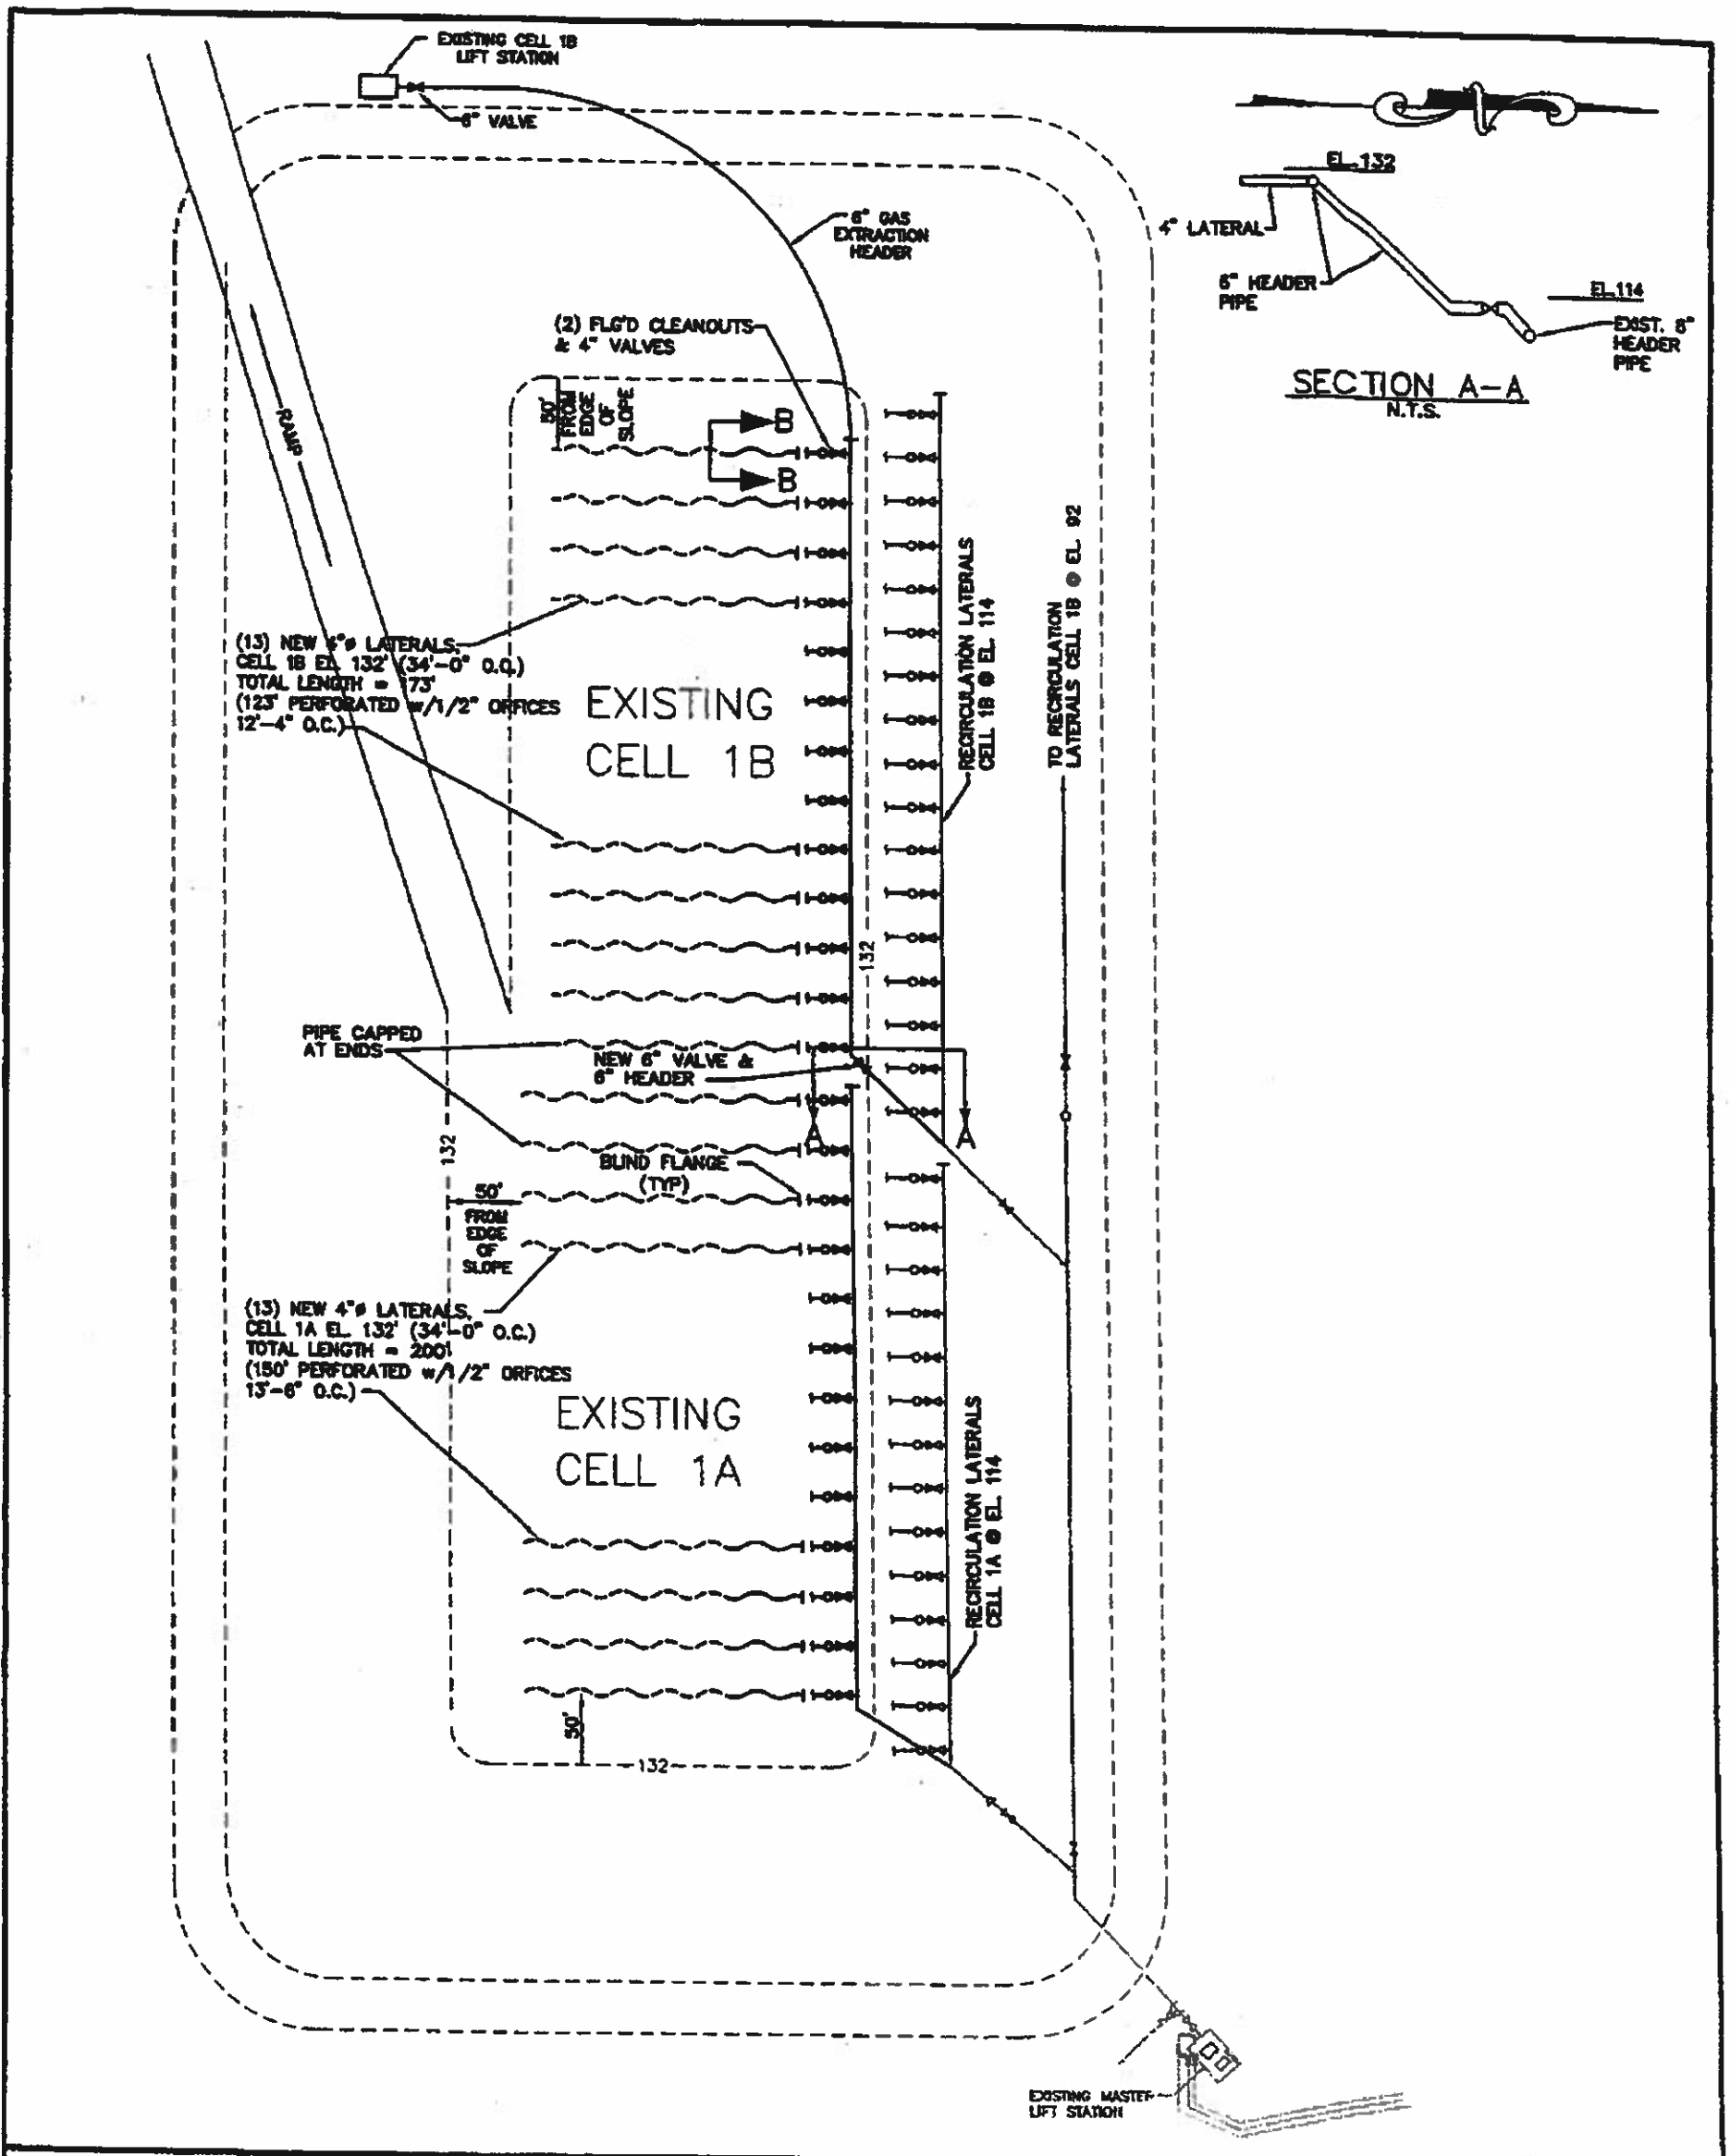

HIGHLANDS COUNTY SOLID WASTE MANAGEMENT CENTER CELL 1A AND 1B EL 132 LEACHATE RECIRCULATION SYSTEMS		PIPING LAYOUT	
CHASTAIN-SKILLMAN, INC.		DRAFTED BY: (12/16/03) B.L.F. SCALE: N.T.S.	

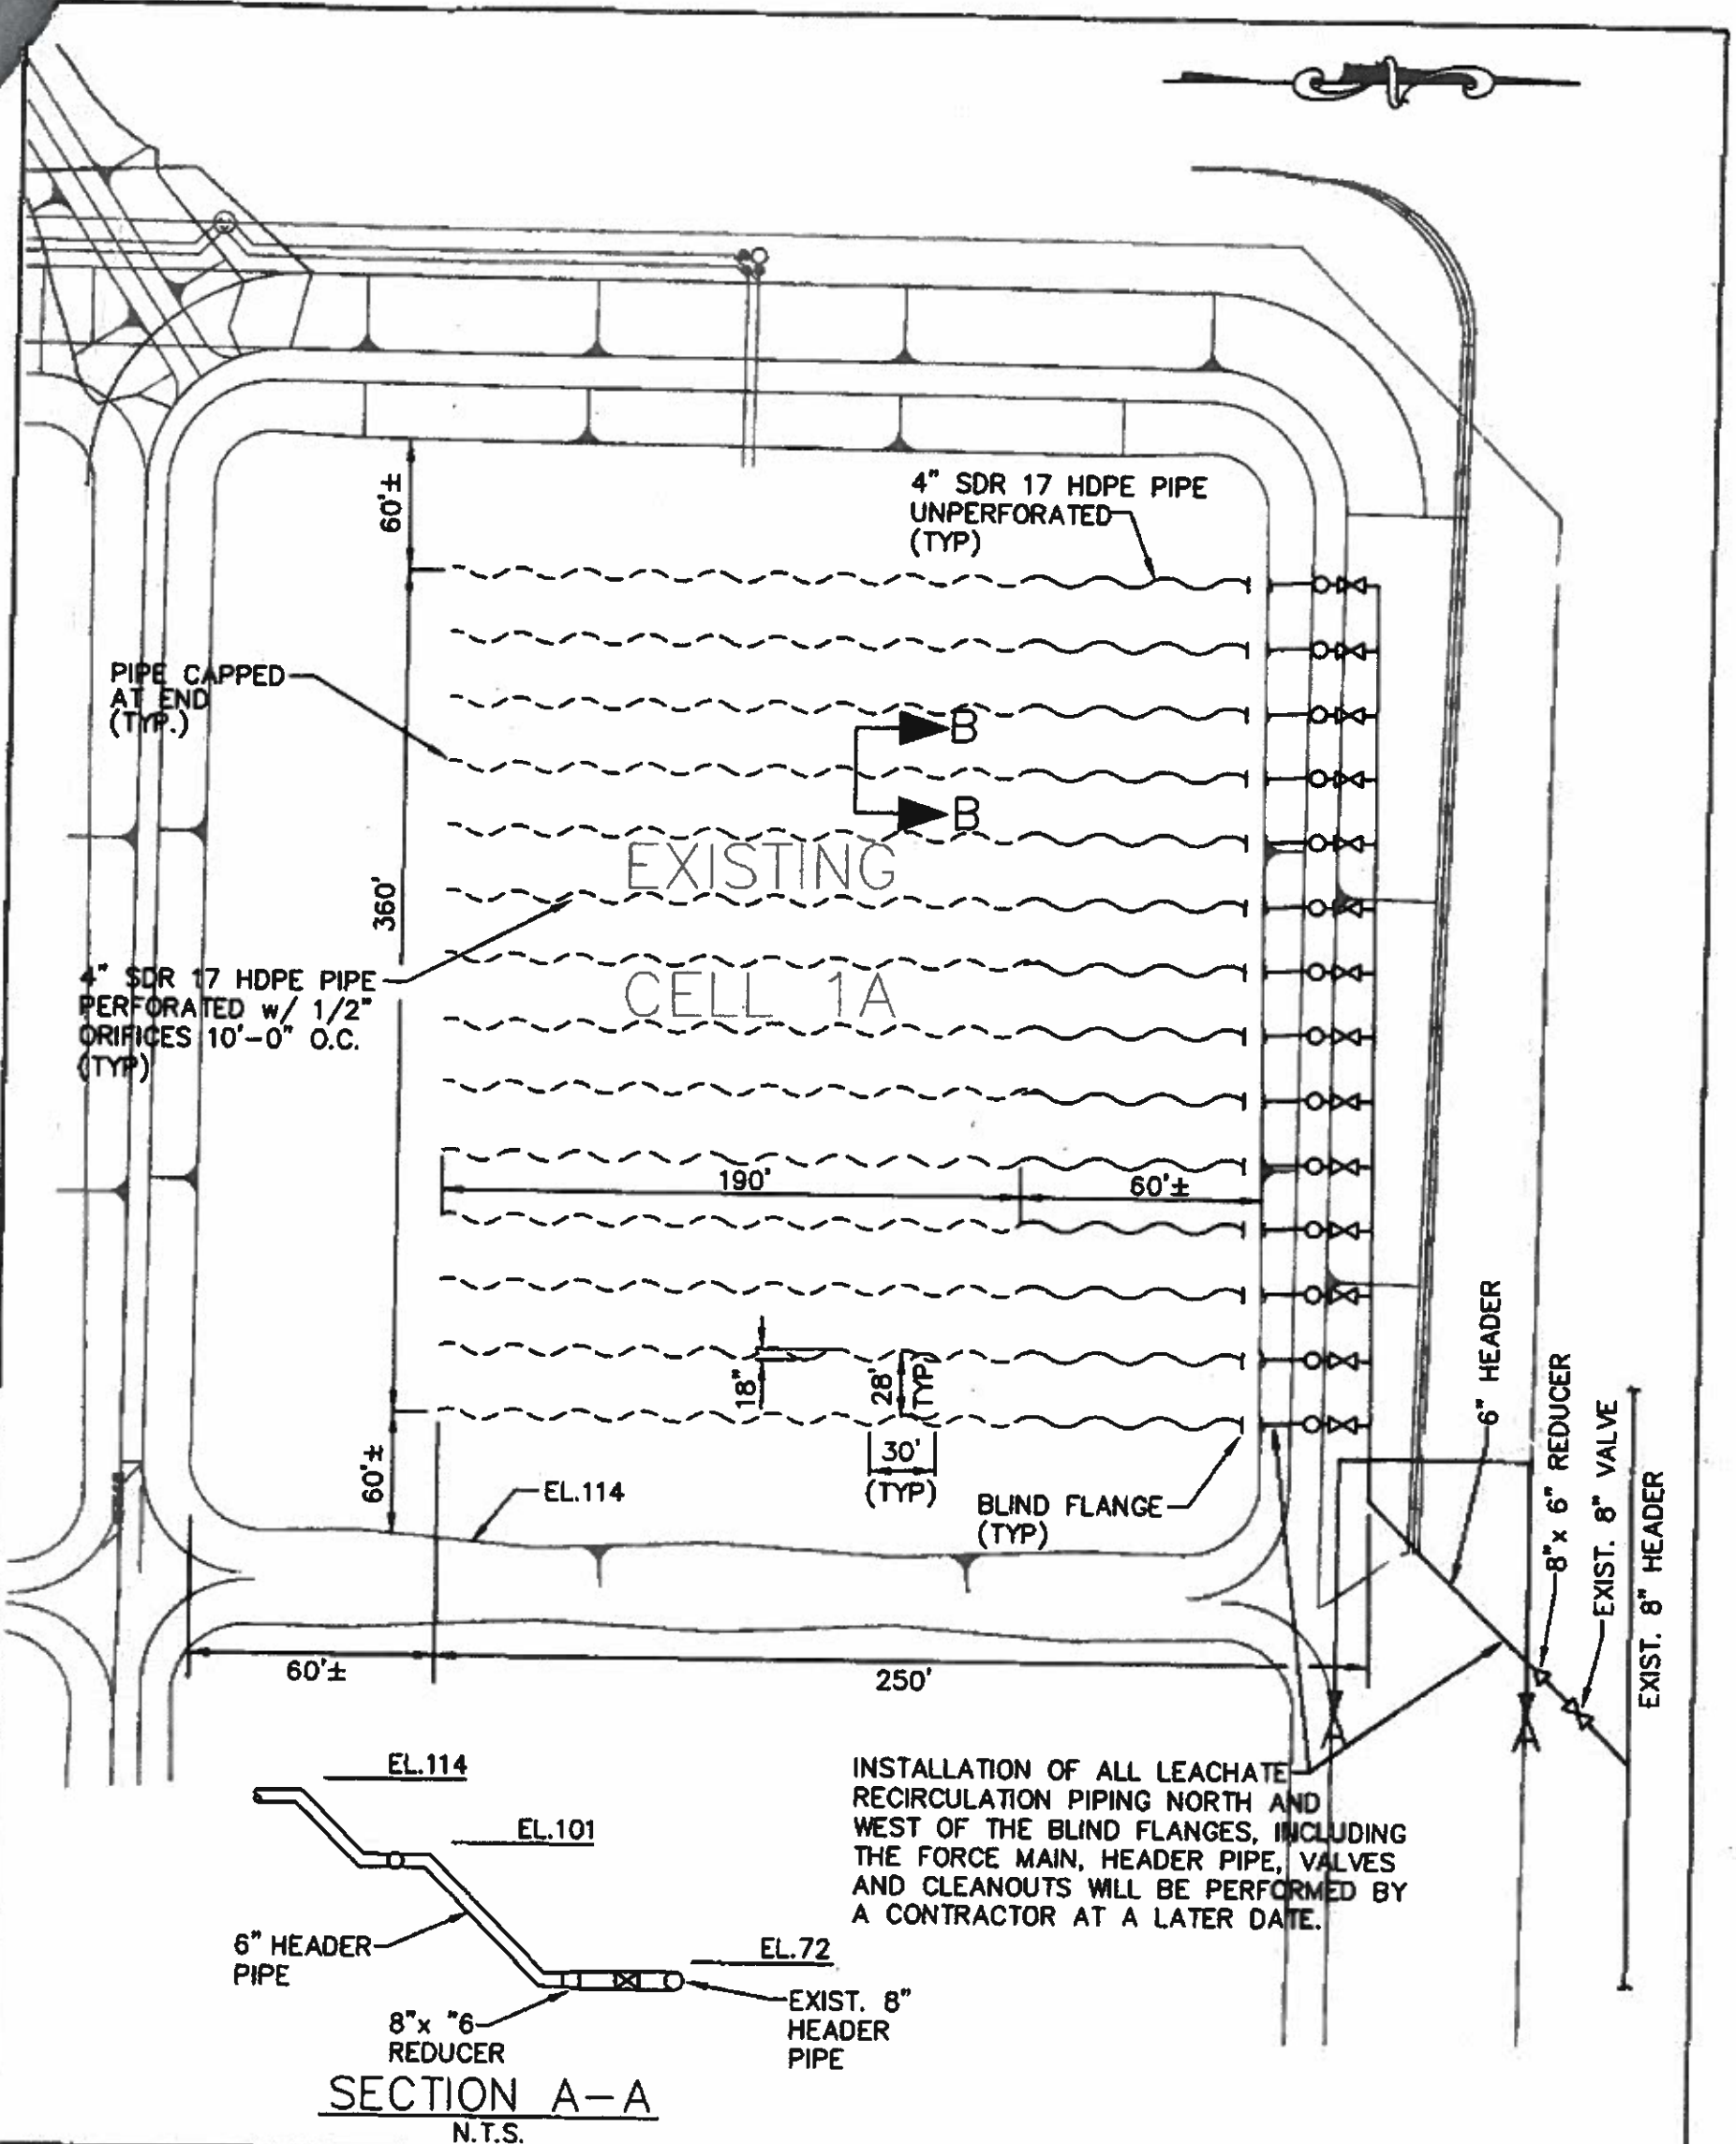

HIGHLANDS COUNTY SOLID WASTE
 MANAGEMENT CENTER
 CELL 1A LEACHATE RECIRCULATION SYSTEM

PIPING LAYOUT


CHASTAIN-SKILLMAN, INC.

DRAFTED BY: (12/20/00) D.A.F.
 REVIEWED/APPROVED BY: R.J.M.

SCALE: N.T.S.

C.S.I. PROJ. NO. 7160.29

FIG. NO. 1

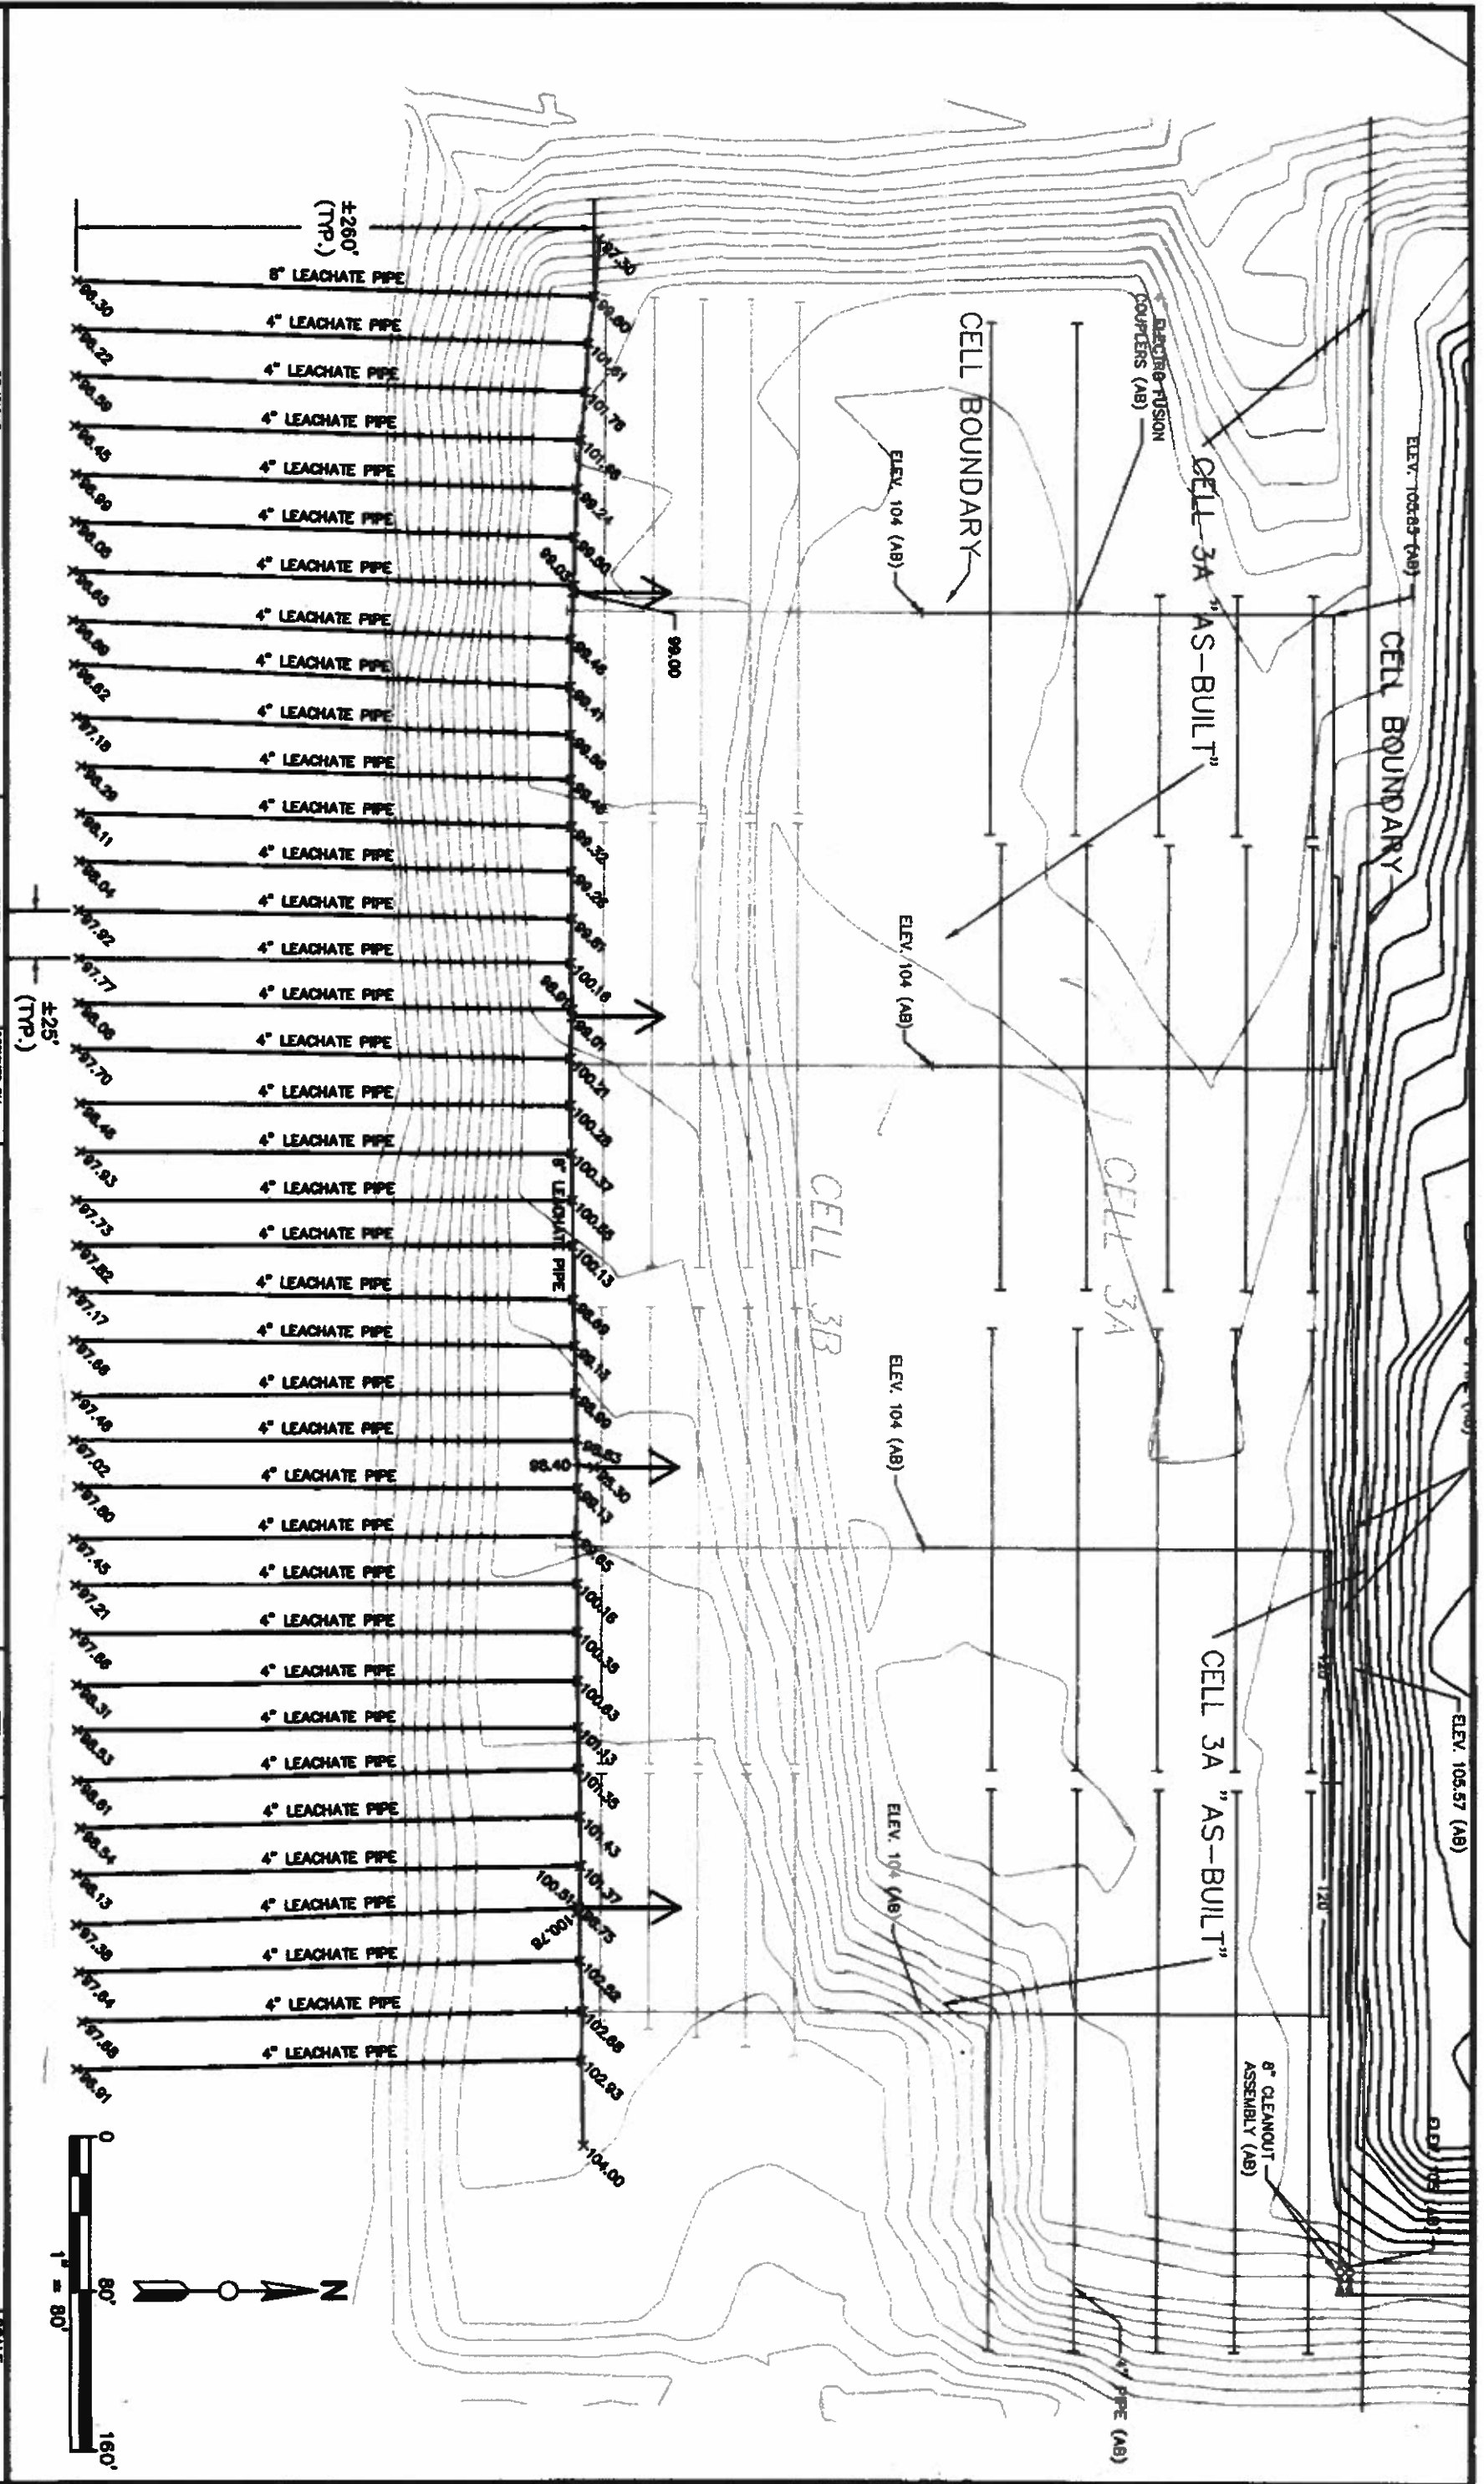

DATE	BY	REVISIONS	DESCRIPTION	STATUS
				AS-BUILT
REVISIONS DATE BY DESCRIPTION STATUS AS-BUILT				
HIGHLANDS COUNTY ENGINEERING DEPARTMENT 505 S. COMMERCE AVENUE SEBRING, FLORIDA 33870				
ARBUCKLE CREEK SOLID WASTE LEACHATE ASBUILT 2013				
SCALE: HORIZ. 1"=80' VERT. N/A PROJECT NO. N/A REV. 0				
SHEET 1 OF 1				

© 2013 Arduckle Creek Leachate Treatment Plant, 11/17, Condon, Richard, Collins as Best Except, City of Sebring